


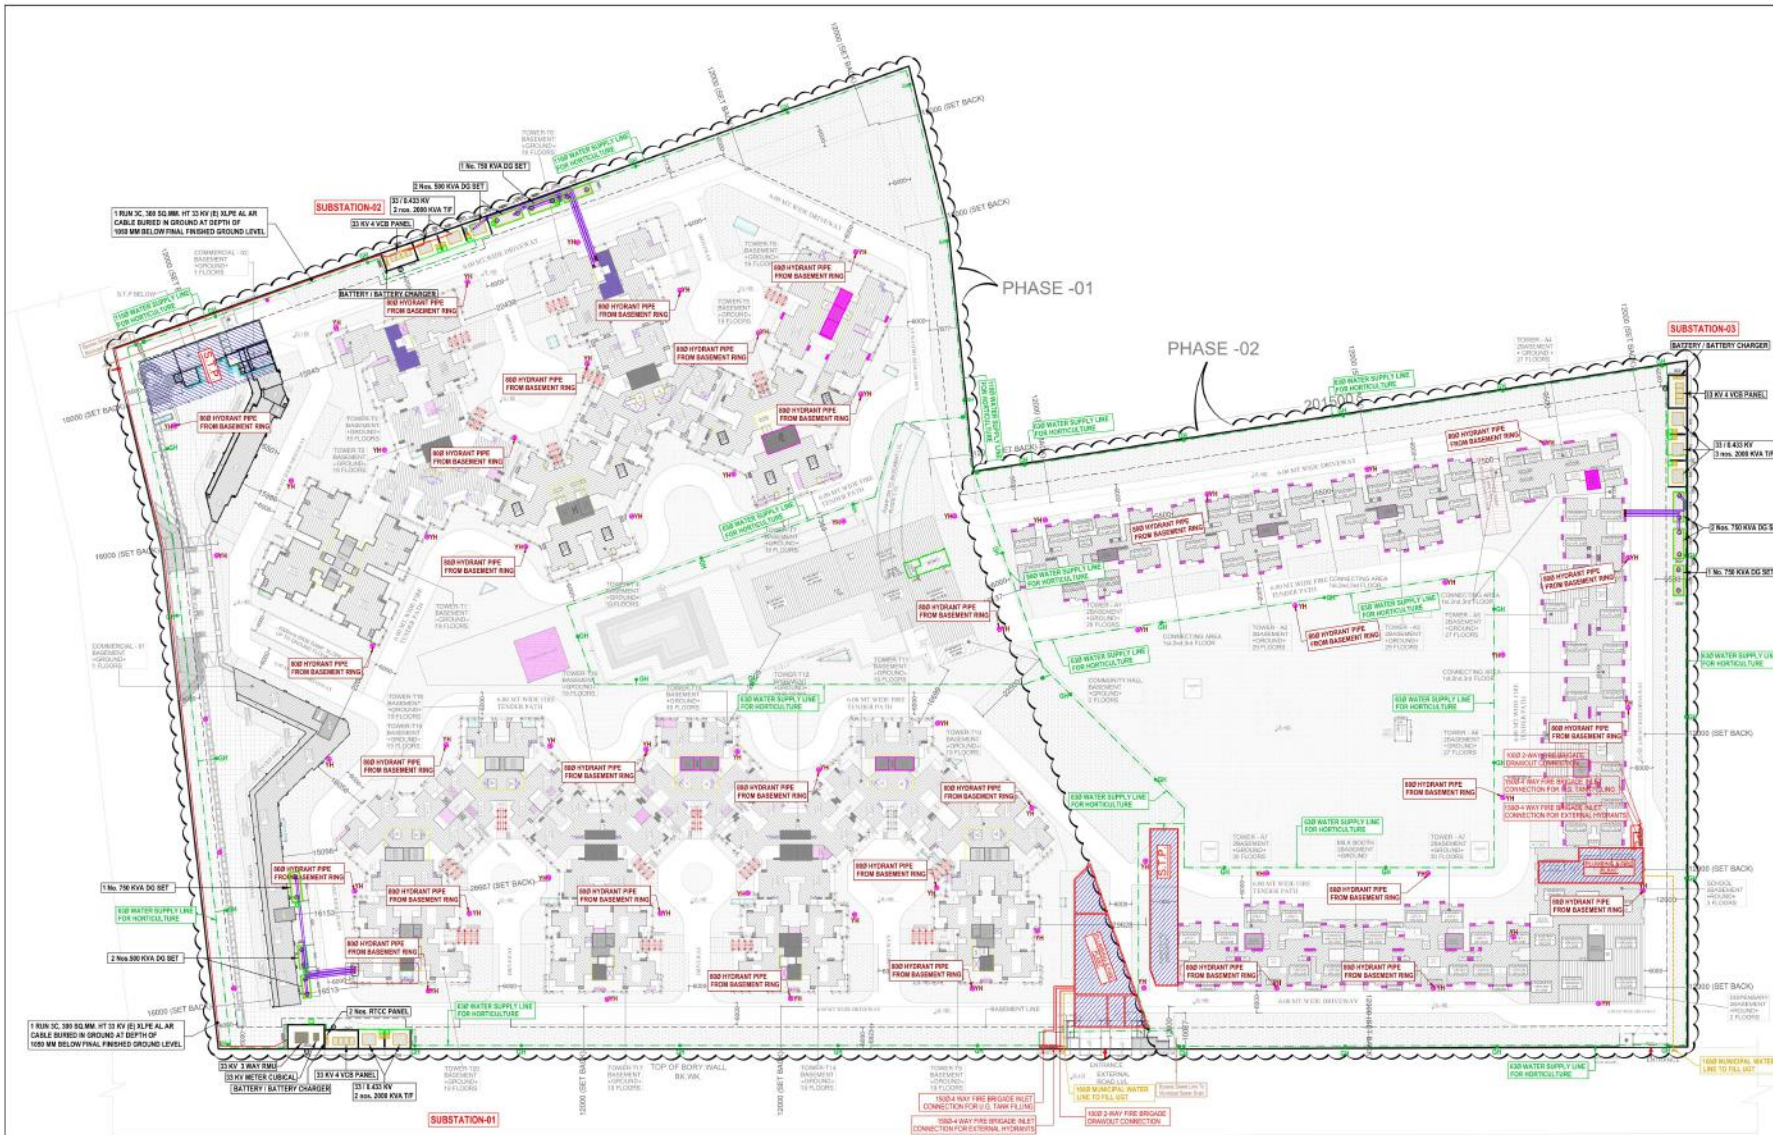

SITE PLAN

LEGEND :	
S. No.	SYMBOL
1.	— RISING MAIN LINE (FROM TOWER TO U.G.T.)
2.	— MAINFOLD WATER SUPPLY PIPE LINE
3.	— RECYCLED WATER SUPPLY LINE FOR HORTICULTURE
4.	— PROPOSED TUBE WELL
5.	— BASEMENT LINE
6.	— HYDRANT
7.	— GARDEN HYDRANT

Rev. No.	Date	Revision

Project : **SKYGARDEN GROUP HOUSING**
SHRI GROUP
NOIDA EXTN - G. NOIDA

Title : **LAYOUT PLAN**

Subtitle : **EXTERNAL WATER SUPPLY FIRE FIGHTING**

Drawing Released For : ☐ APPROVAL ☒ SUBMISSION
☐ ADVANCE COPY ☐ CONSTRUCTION

Org. No. : CES/150/SP/PL-03

Scale : 1:725 Drawn By : S.Bhandari

Date : 27.01.2017 Design By : Shakti Shakti

Chk By : Anand Havella

Architects : Owner :

Services Consultant : **Consummate Engineering Services (P) Ltd.**
cespl
Noida Office : B-20, Sector-47, Noida - 201 301
Tel : (0120) 8585851 (Ext. 101)
Lko Office : 8/68, Preeti Park, Gurgaon, Haryana
Tel : (0120) 8585851
e-mail : info@cespl.com, website : www.cespl.com