
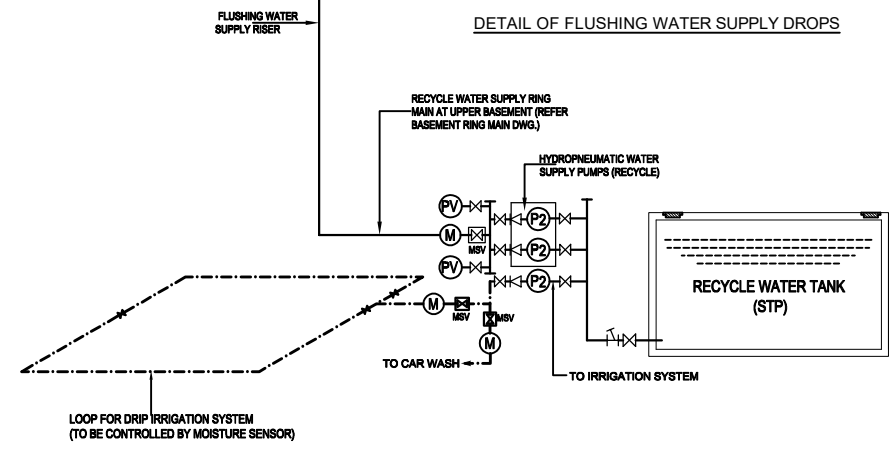
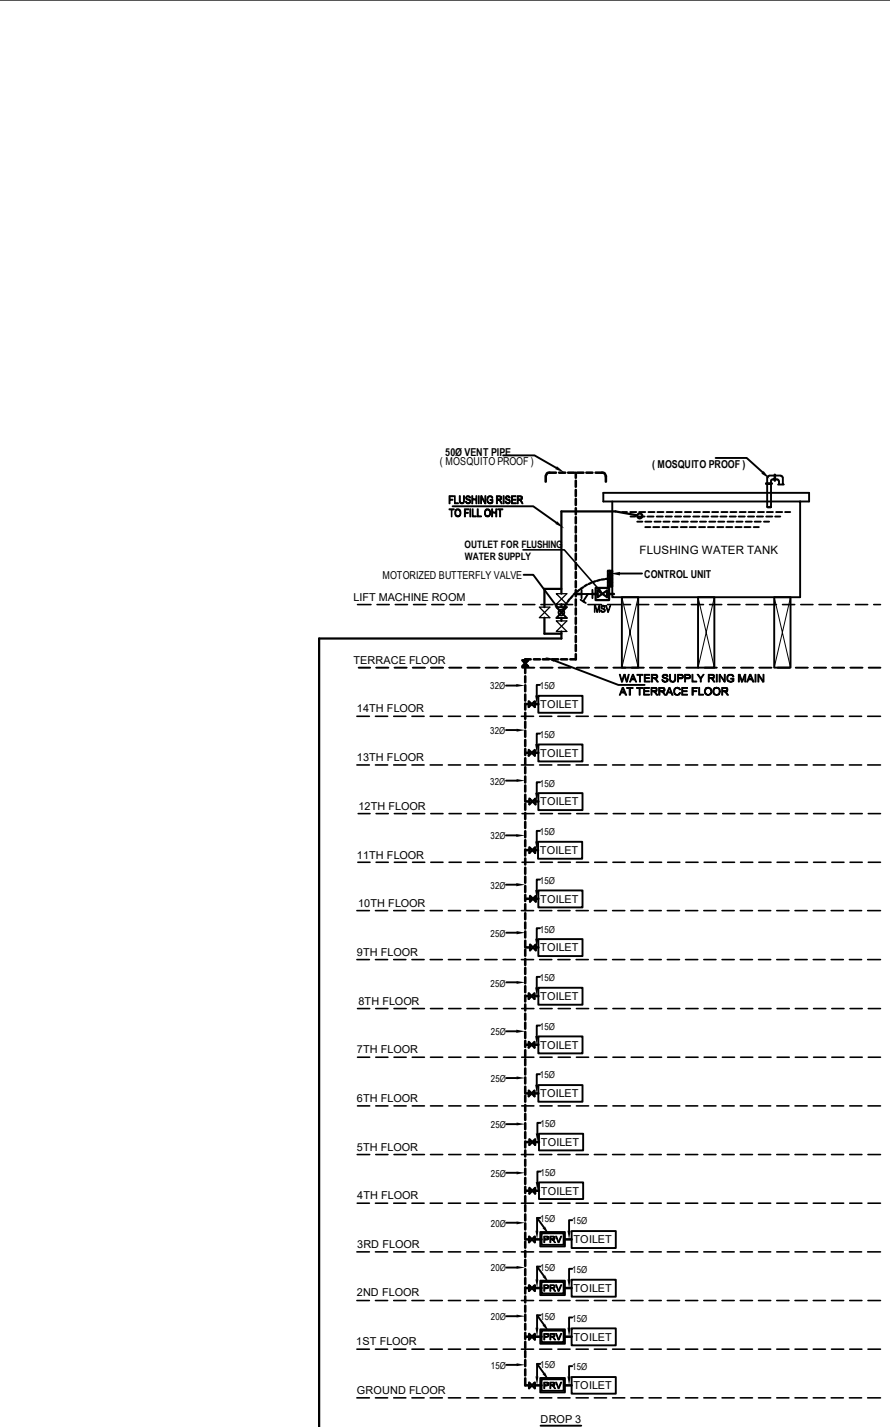
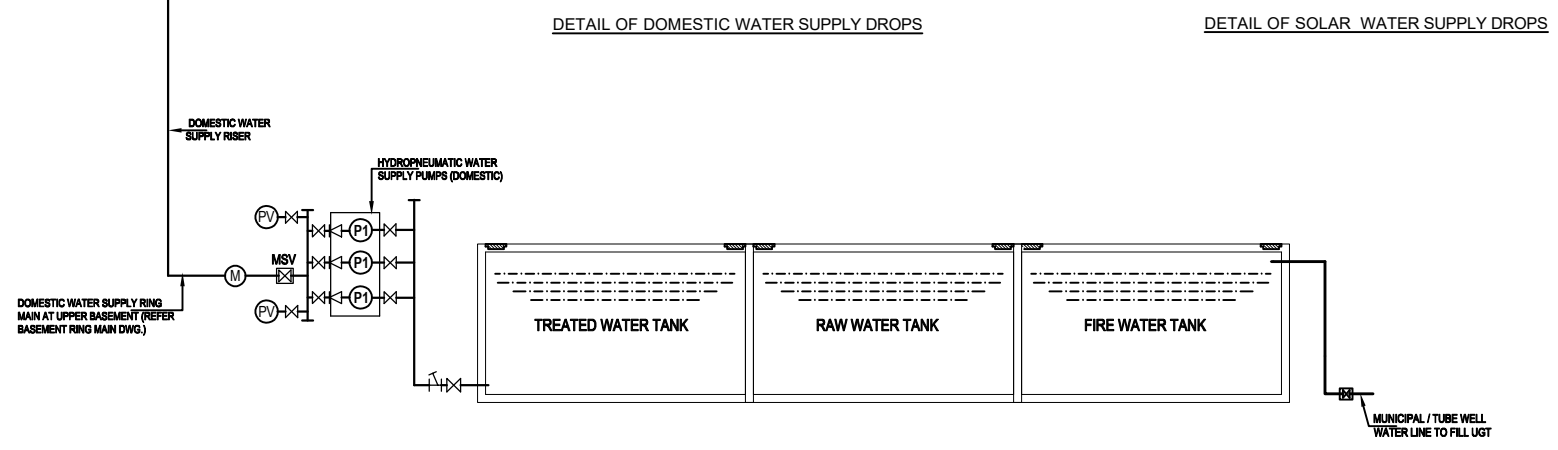


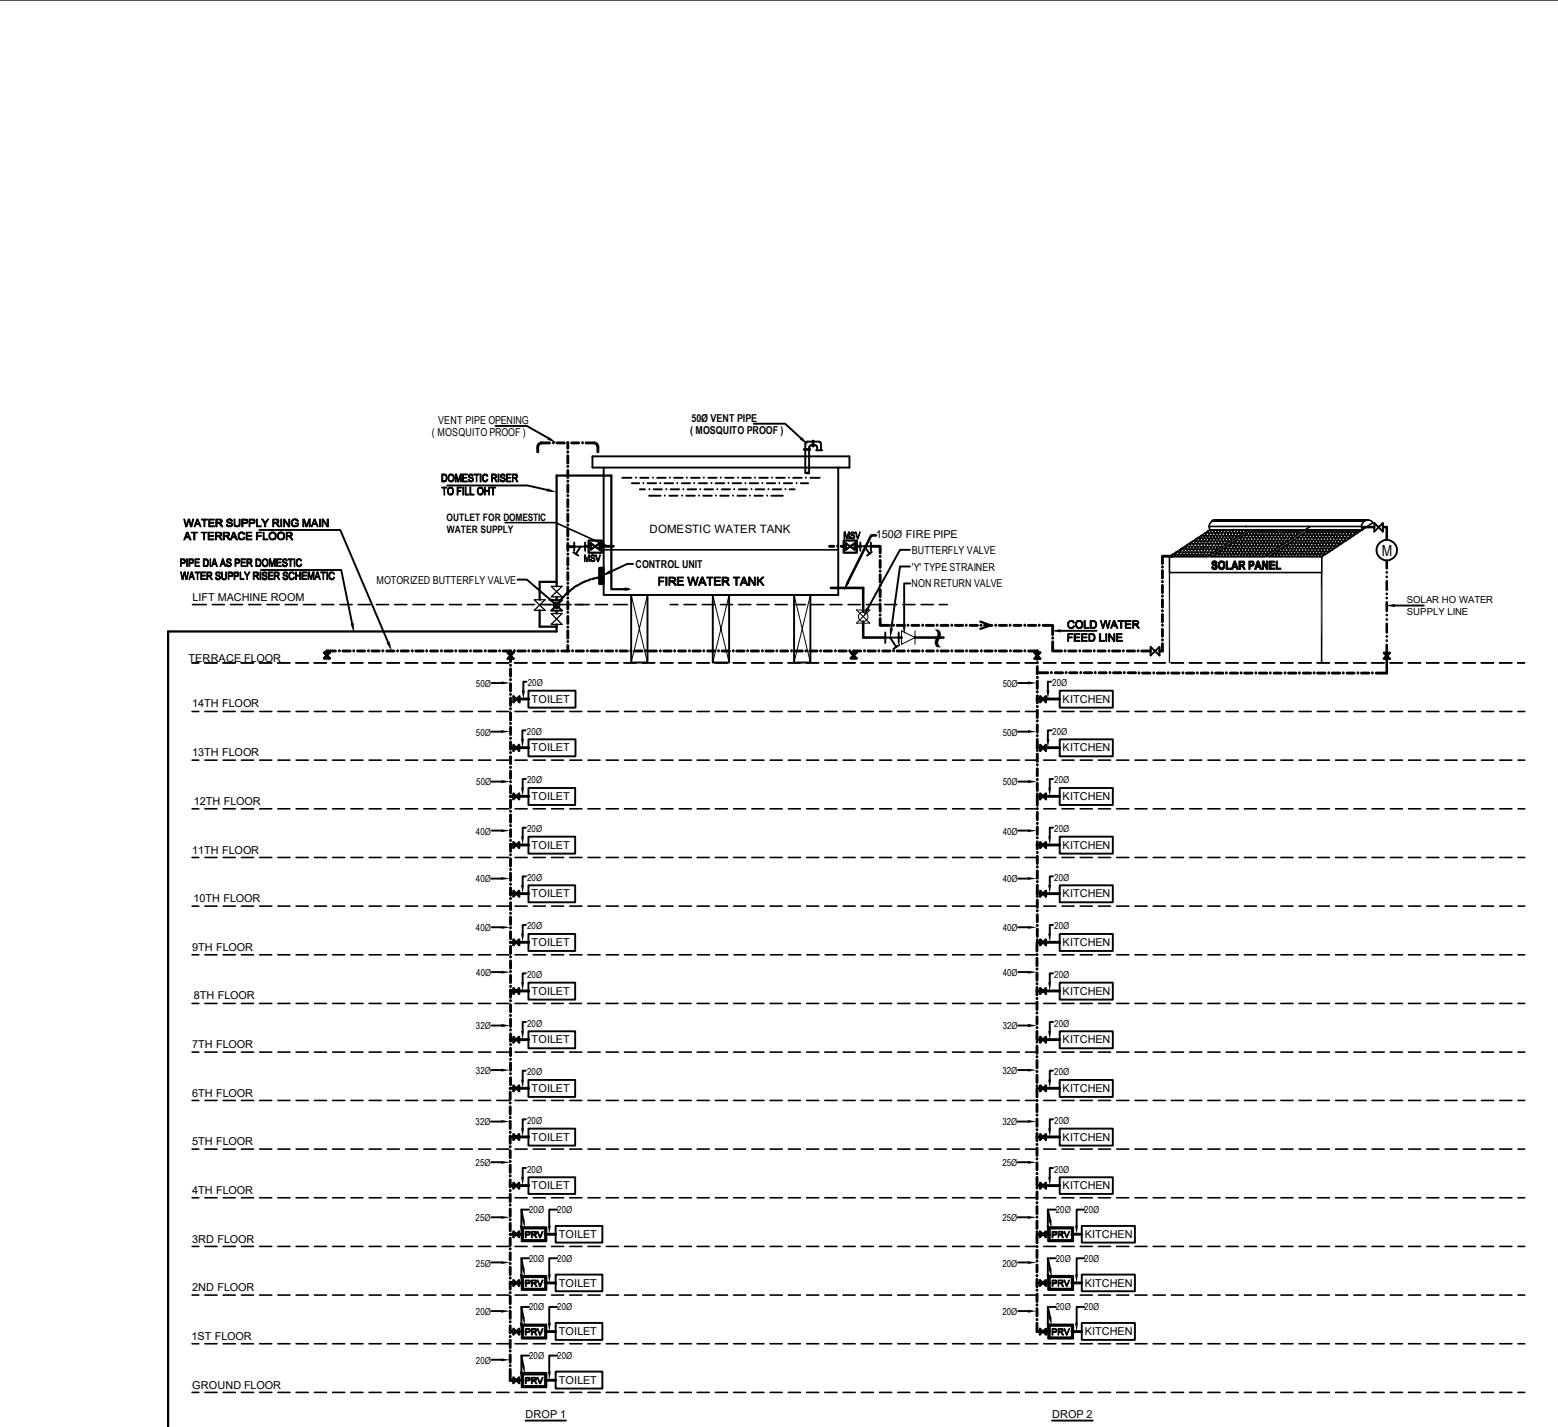

LEGEND : (Plumbing)		
S. No.	SYMBOL	DESCRIPTION
1.	---	DOMESTIC WATER SUPPLY PIPE
2.	---	FLUSHING WATER SUPPLY PIPE
3.	---	SOLAR WATER SUPPLY PIPE
4.	---	BALL VALVE TYPE ISOLATING VALVE
5.	---	NON RETURN VALVE
6.	---	'Y' TYPE STRAINER
7.	---	WATER METER
8.	PRV	PRESSURE REDUCING VALVE
9.	MSV	MAIN SHUT OFF VALVE

Rev. No.	Date	Revision
--	--	--

Project :
"ANANTA" RESIDENTIAL / COMMERCIAL
COMPLEX AT TCG 3/3, VIBHUTI KHAND,
GOMTINAGAR , LUCKNOW.

Title :
PLUMBING DRAWING

Subtitle :
WATER SUPPLY SCHEMATIC (G + 17)

Drawing Released For :
☐ APPROVAL ☒ GREEN SUBMISSION
☐ ADVANCE COPY ☐ CONSTRUCTION

Drg. No : ANANTA / LUCKNOW / GREEN / WS - 01



Scale : 1 : 275 Drawn By : Baldev

Date : June 2018 Design By : Sanjay goel

Ckd By : Anand Havelia

Architects :
DESIGN GROUP
ARCHITECTS ENGINEERS INT.DESIGNERS
HALWASIYA COURT HAZRATGANJ LUCKNOW

services consultant
Consummate Engineering Services (P) Ltd.
Noida Office : B - 67, Sector - 67, Noida - 201 301
Tel : (0120) 6613500
Lko. Office : R 006, Rohtas Plumeria, Gomti Nagar, Lucknow
Tel : (0522) 6515455
e mail : mail@cespl.in, website : www.cespl.in

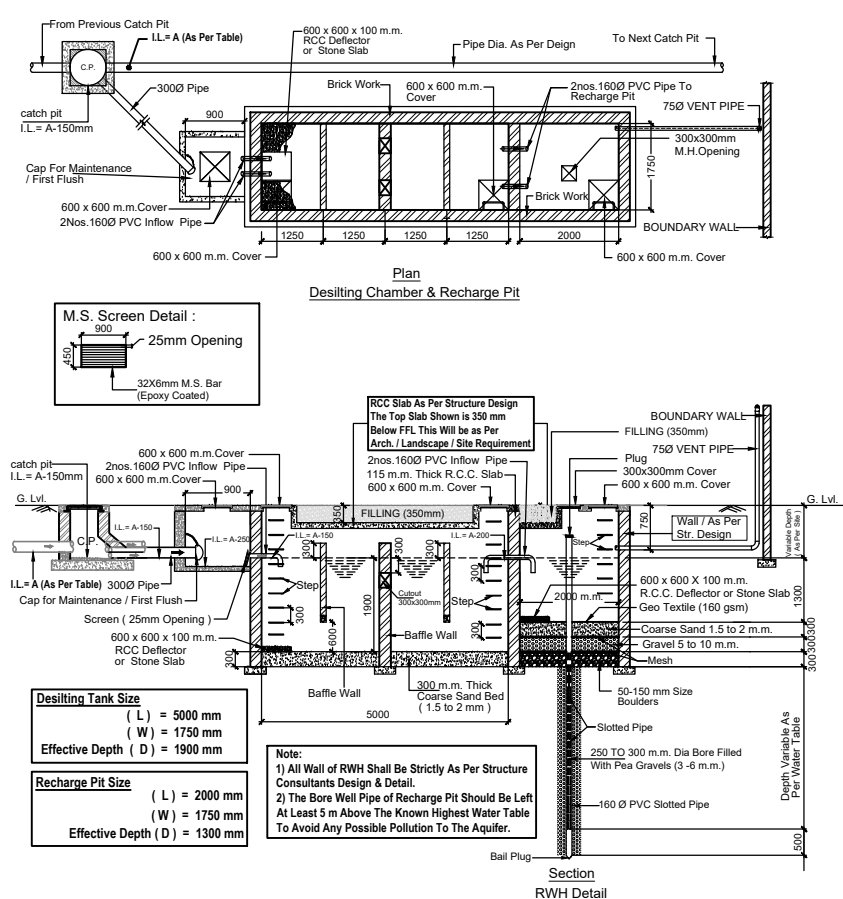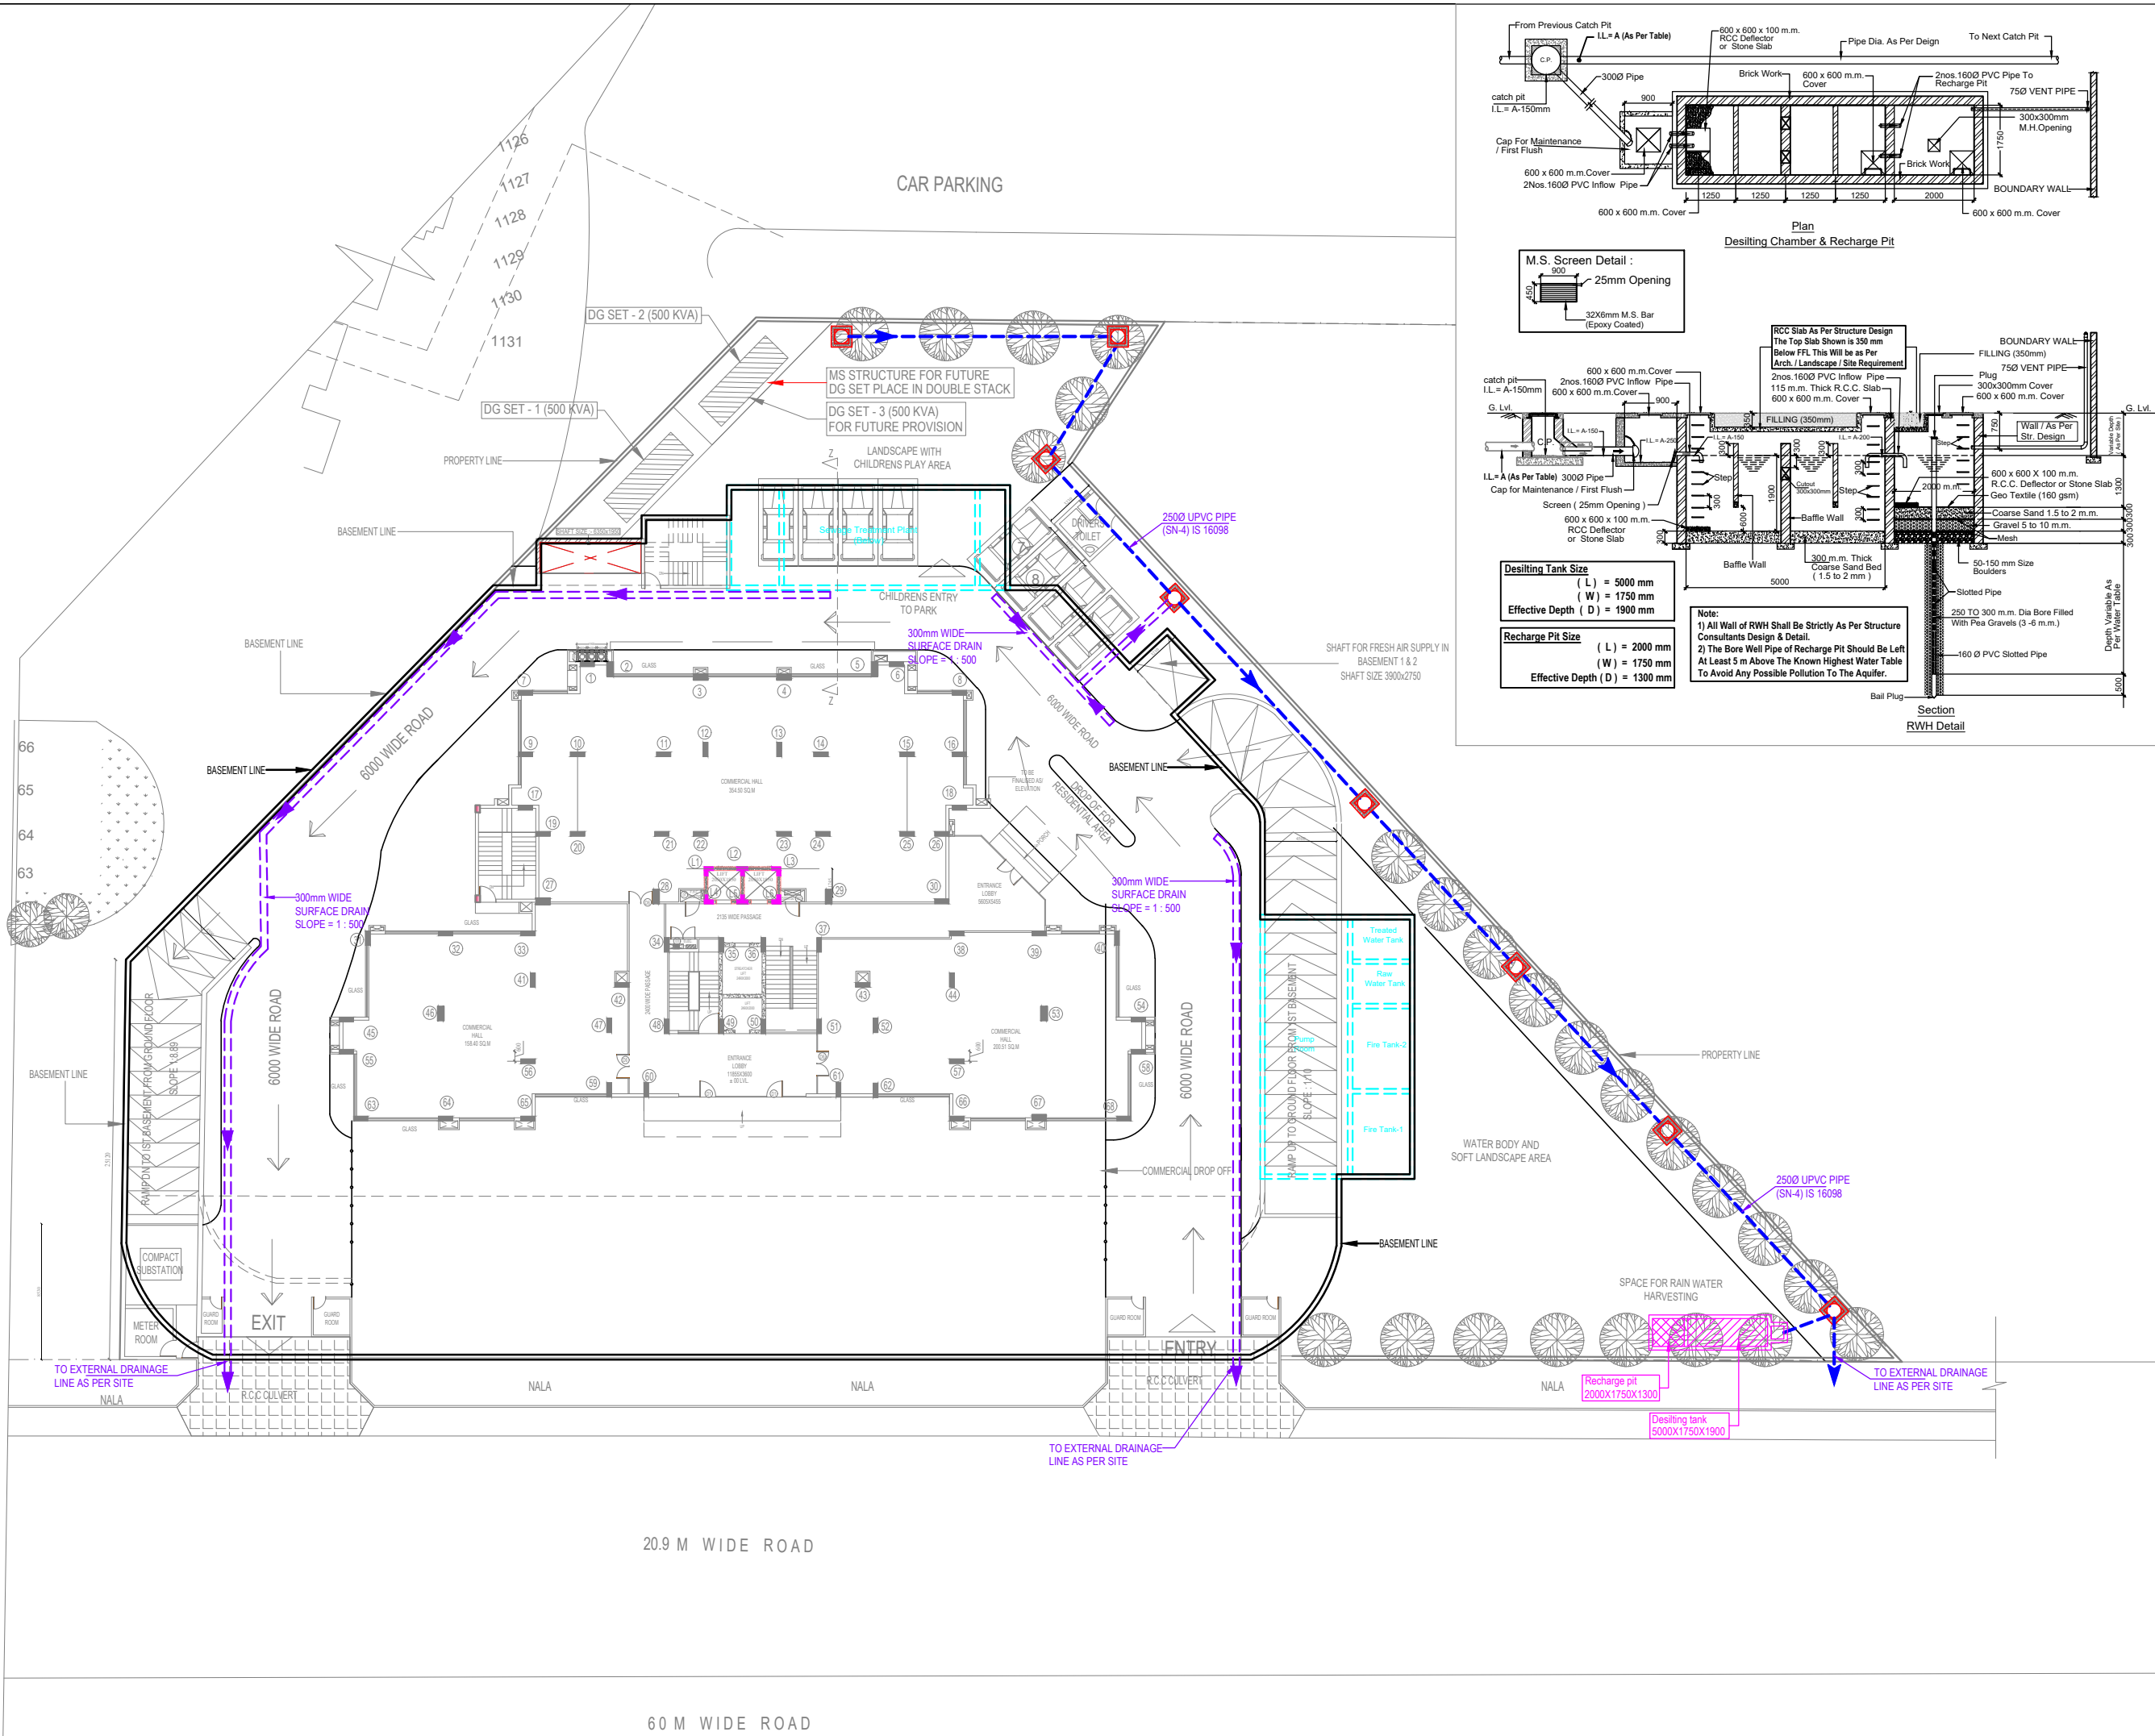

LEGEND :		
S. No.	SYMBOL	DESCRIPTION
1.	C.P.	CATCH PIT
2.	—■—	UNDER GROUND PIPE DRAIN
3.	---	SURFACE DRAIN
4.	■	RAIN WATER HARVESTING
5.	---	BASEMENT RETAINING WALL
6.		
7.		
8.		

Rev. No.	Date	Revision

Project :
"ANANTA" RESIDENTIAL / COMMERCIAL
COMPLEX AT TCG 3/3, VIBHUTI KHAND,
GOMTINAGAR , LUCKNOW.

Title :
LAYOUT PLAN

Subtitle :
EXTERNAL DRAINAGE SYSTEM

Drawing Released For :
☒ APPROVAL ☐ SUBMISSION
☐ ADVANCE COPY ☐ CONSTRUCTION

Dr. No. :
AN / LKO / ES - 02



Scale :
1 : 200

Date :
July, 2018

Ckd By :
Anand Havelia

Architects :
DESIGN GROUP
ARCHITECTS ENGINEERS INT.DESIGNERS
HALWASIYA COURT HAZRATGANJ LUCKNOW

Services Consultant :
Consummate Engineering Services (P) Ltd.
Noida Office : B - 67, Sector - 67, Noida - 201 301
Tel : (0120) 6613500 (24 Lines)
Lko. Office : R 006, Rohas Plumeria, Gomti Nagar, Lucknow
e mail : mail@cespl.in website : www.cespl.in

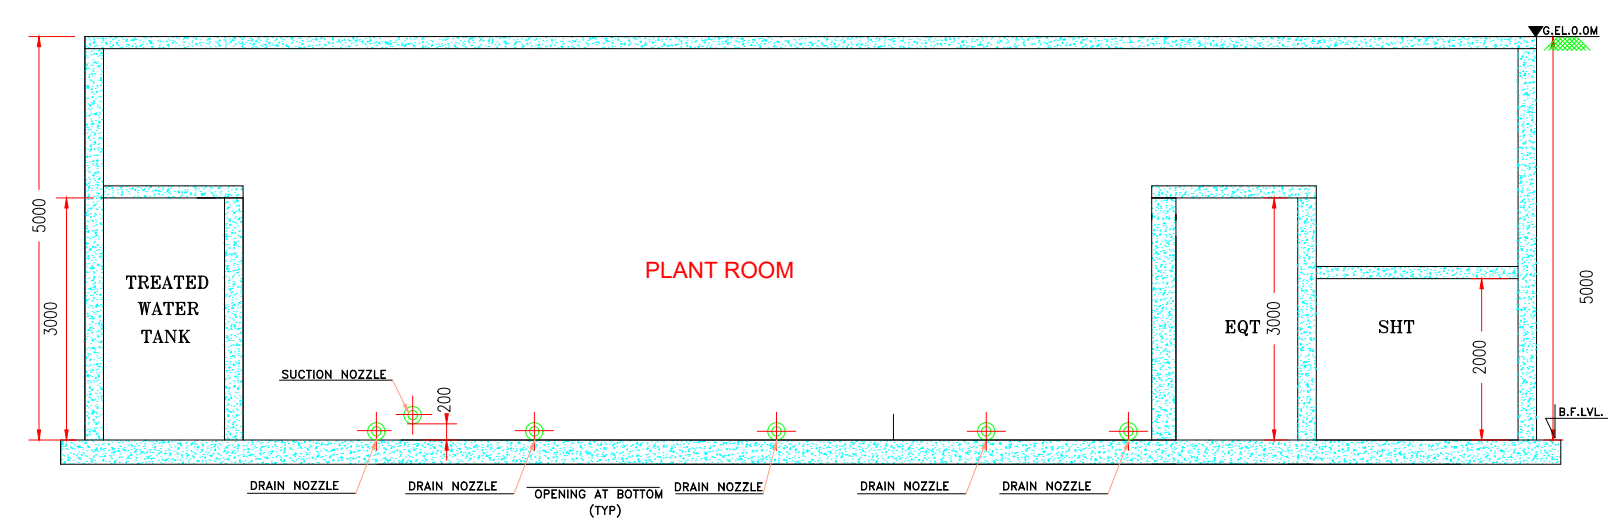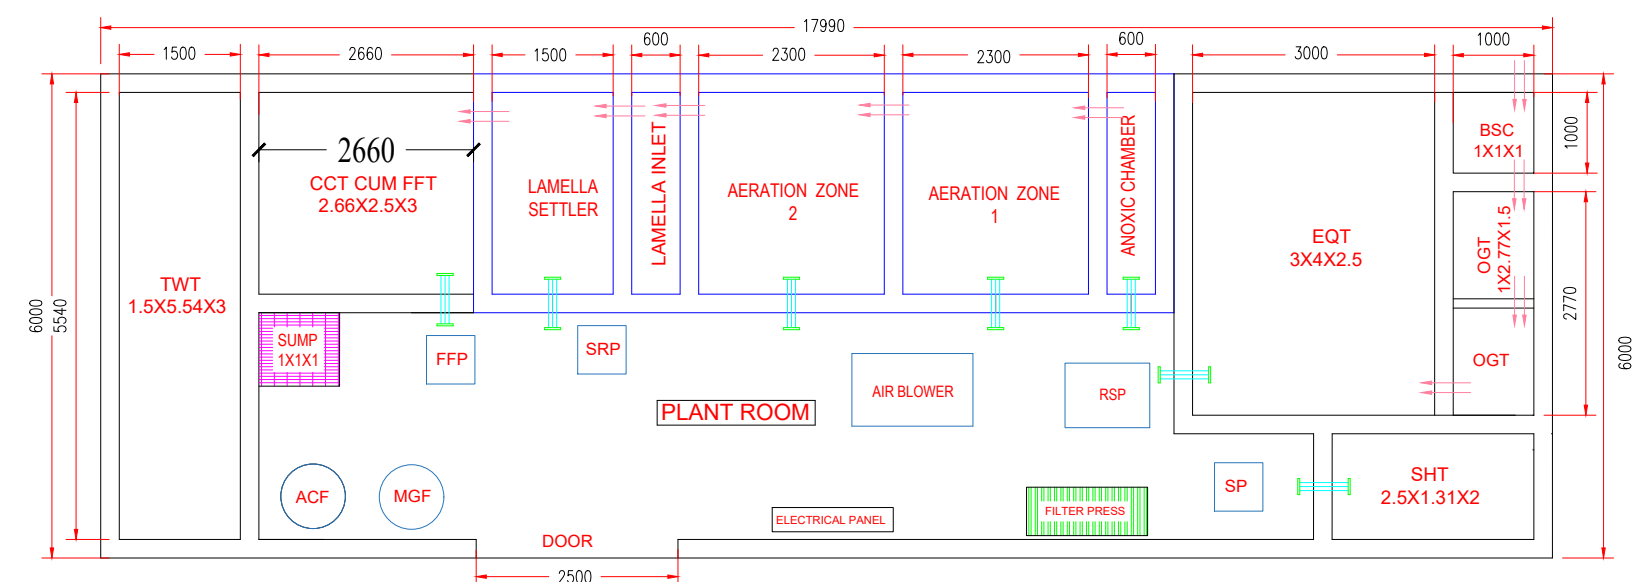

SECTION B-B





NOTE -

1. THIS DRAWING IS FOR PLAN & DIMENSION ONLY.
2. THIS DRAWING IS NOT FOR STRUCTURAL WORK.
3. ALL TANKS FRP RUNGS REQUIRED .

INDION® IS THE REGISTERED TRADE MARK
OF ION EXCHANGE (INDIA) LIMITED FOR
WATER TREATMENT EQUIPMENTS, CHEMICALS,
ION EXCHANGE RESINS & MEMBRANES

INDIA : 91-22-2769 9122
INDONESIA: 62-21-478 69367
THAILAND : 66-2-381 7464
KENYA : 254-2-337 730

REV.	DATE	DESCRIPTION	DRAWN	PROCESS/ MECHANICAL	ELECTRICAL/ INSTRUMENT	CIVIL
			APPROVED			
PROJECTS :-			ANANTA (HALWASIYA DEVELOPPMENTS)			
DRAWN	YOGESH GAUR		 ION EXCHANGE THE POWER BEHIND WATER (INDIA)LTD TOTAL WATER MANAGEMENT MUMBAI NEW DELHI KOLKATA CHENNAI			
CHECKED		CIVIL				
PROCESS/ MECHANICAL	ELECTRICAL/ INSTRUMENT					
APPROVED		TITLE-		STP 100 KLD PLAN		
SCALE	NTS	FROM:-	SHINE WATER EXPERTS			REV. 0
			Authorized Channel Partner Of Ion-exchange (India) Ltd. E-mail: bc.bhagat@shinewaterexperts.com Mobile : + 919336045174 Website : www.shinewaterexperts.com			
CONTRACT NO.						
DATE	01/02/19		Address:- 17154, Indira Nagar, Lucknow-226016,India Registered Office: 7/53, Vikas Nagar, Lucknow -226022, India			

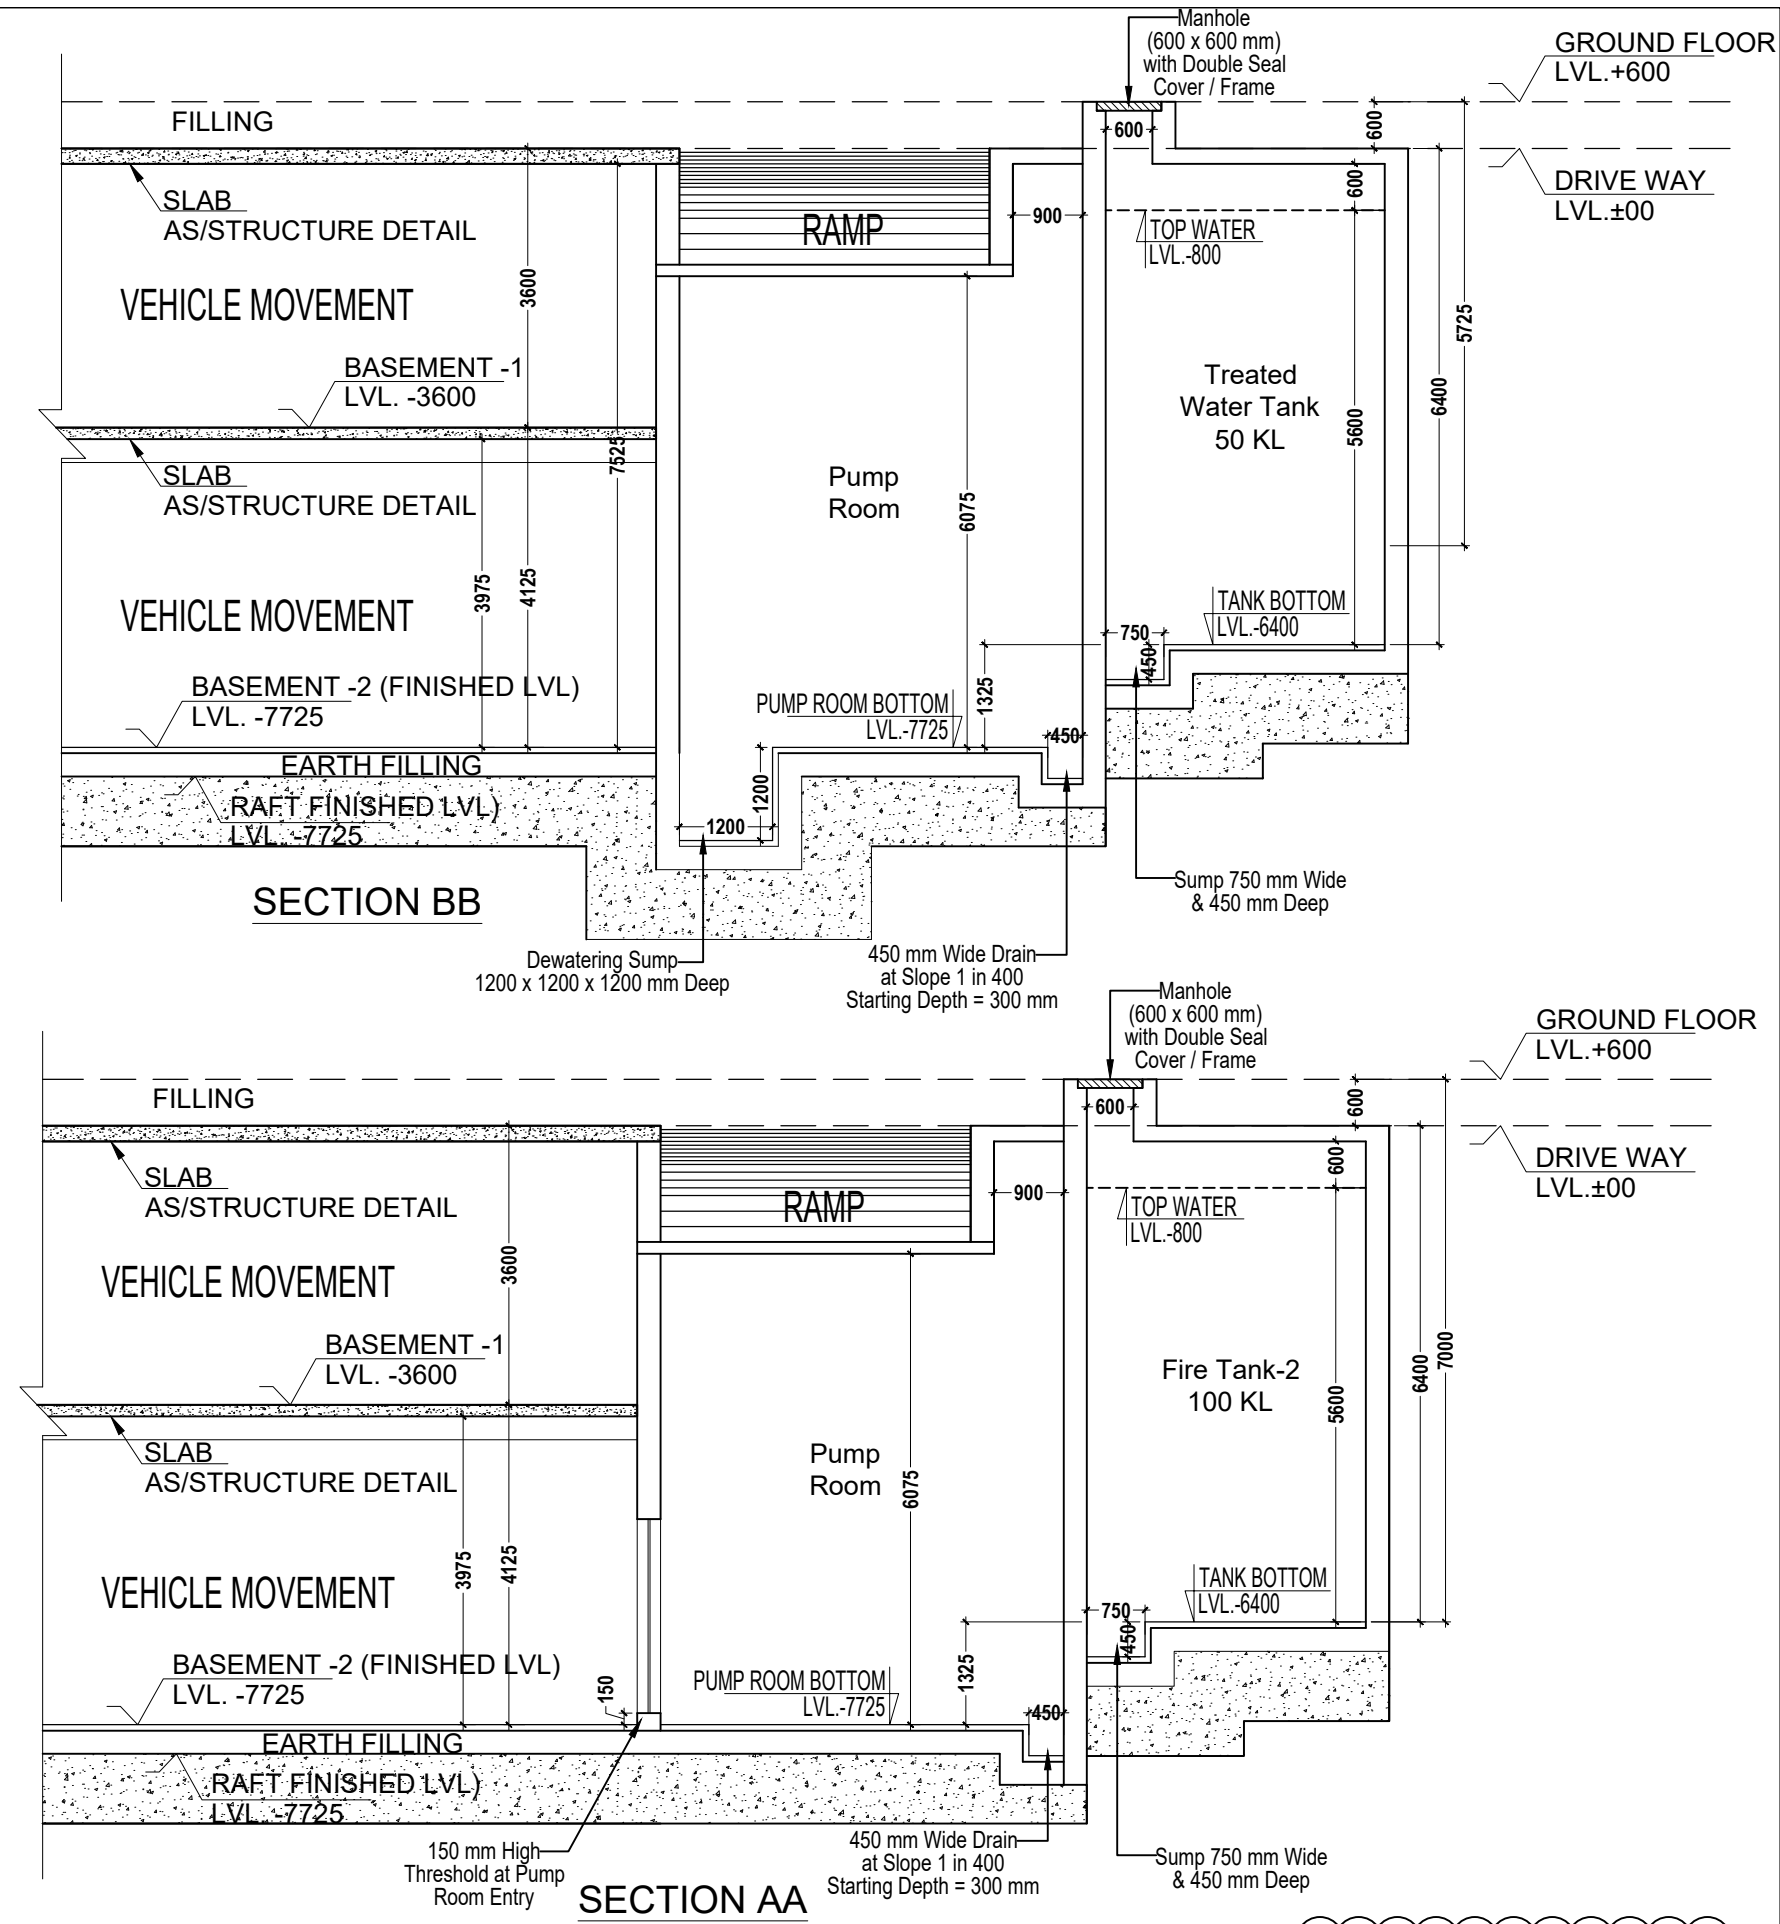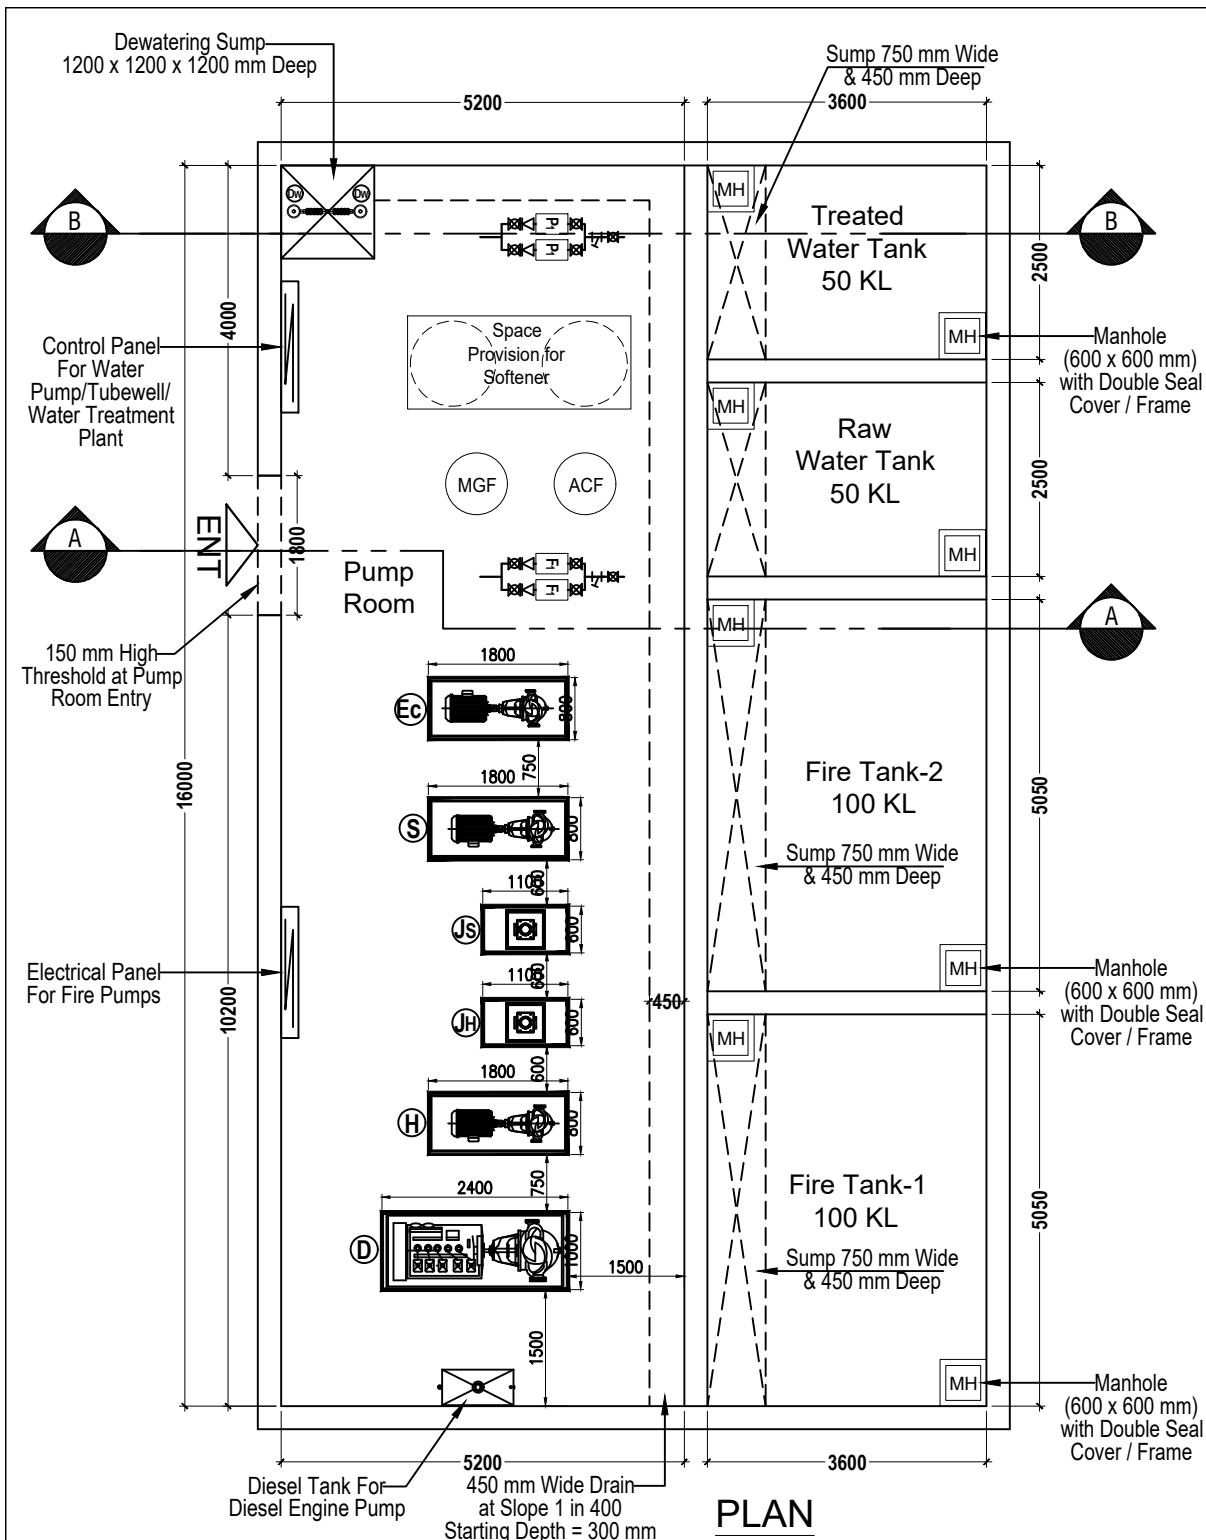

project "ANANTA" Residential / Commercial Complex At TCG 3/3, Vibhuti Khand, Gomti Nagar, Lucknow ...		title General Arrangement Drawing	
drawing released for ☒ APPROVAL ☐ SUBMISSION ☐ ADVANCE COPY ☐ CONSTRUCTION		subtitle Under Ground Tank	
architects Design Group Architects Engineers Int. Designers Halwasiya Court Hazratganj Lucknow		services consultant Consummate Engineering Services (P) Ltd. Noida Office : B - 67, Sector - 67, Noida - 201 301 Tel : (0120) 6943500 (24 Lines) Lko. Office : R 006, Rohtas Plumeria, Gomti Nagar, Lucknow e mail : mail@cespl.in, website : www.cespl.in	
drg. no. Ananta / GA-01		scale N.T.S.	
date 15/02/2018		drawn by Shikha Kalra	
ckd by Anand Havelia		rev. no. ...	
date ...		revision ...	

UNDER GROUND WATER STORAGE TANK GENERAL ARRANGEMENT DRAWING

Note: -
 1) As per min. area requirement for Raw & Treated Water Tank, the capacity of both tanks has been increased from 35 KL each to 50 KL.
 2) Pls check manholes location with respect to the Site Plan.