


STORM WATER DRAINAGE LEGEND :-	
	RCC STORM WATER DRAINAGE PIPE
	STORM WATER MANHOLE (SIZE=900MM X 800 MM)
	DE-SILTING CHAMBER (Size = 1.2Mtr. X 0.9 Mtr.)
	RAIN WATER HARVESTING PIT (Size = 2.0 Mtr. Dia)

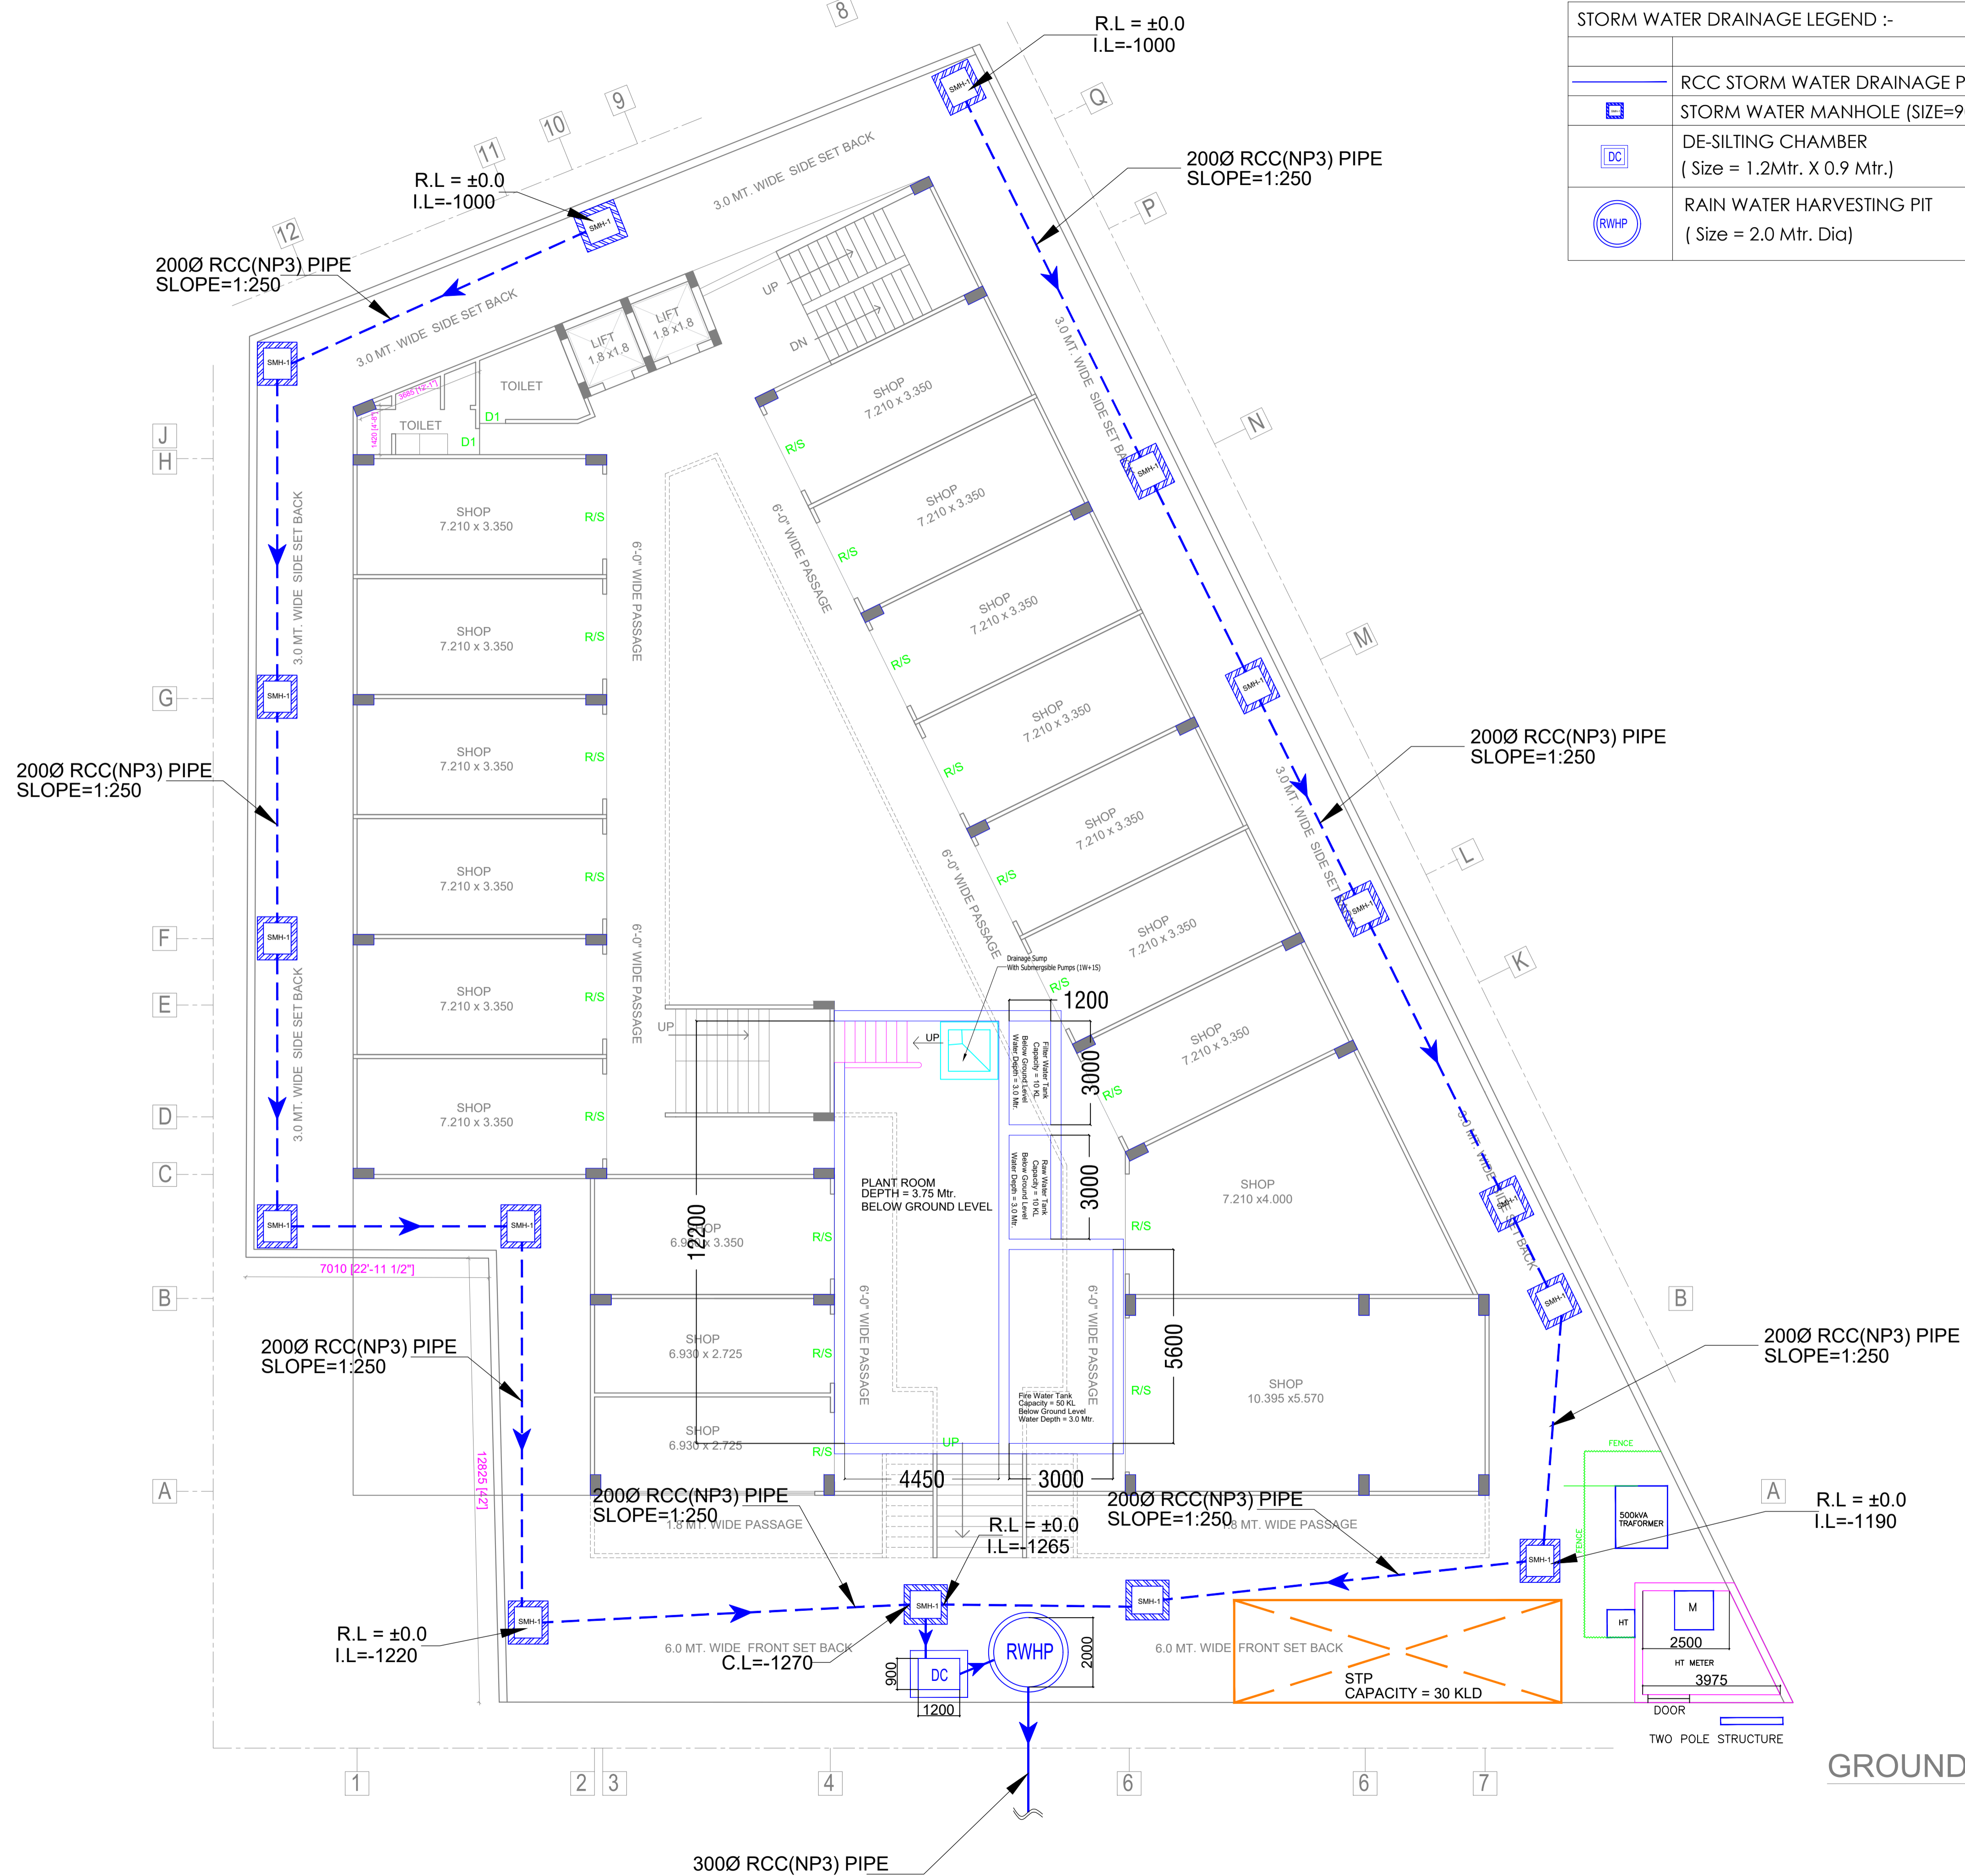

GROUND FLOOR PLAN

Rev. No.	Date	Revision
R-0	12-10-2025	ORIGINAL SUBMISSION

**Project :**  
 Layout of Commercial / Studio at "KDMG Central Plaza" Situated at Plot No.- X Trilokpuram Greens Village -Gulistanpur Surajpur site -C, Pargana Dadri, Tehsil Sadar, Greater Noida, Distt. Gautam Buddh Nagar, U.P. - 201306

**Owner:**  
**Analox Town Planners Pvt. Ltd.**

**Subtitle :**  
**SITE PLAN**  
**STORM WATER DRAINAGE LAYOUT**

**Drawing Released For :**  
 **APPROVAL**     **SUBMISSION**  
 **ADVANCE COPY**     **CONSTRUCTION**

**Drg. No. : PL-03**

**Scale : 1:100**      **Drawn By : Ravinder**

**Date : 12-10-2025**      **Design By : Ravinder**

**Ckd By : Sachin Dixit**

**Architects :**  
**D+P ASSOCIATES**  
 DESIGNERS & PLANNERS  
 architects,engineers,interior designers,landscape & vastu consult.  
 D-201, BLUE MOON HOMES 2nd FLOOR RAJNAGAR EXTENSIONS  
 GHAZIABAD M o b i l e : 9 8 1 0 8 8 9 1 6  
 Email Id:dushyantnigam@gmail.com

