


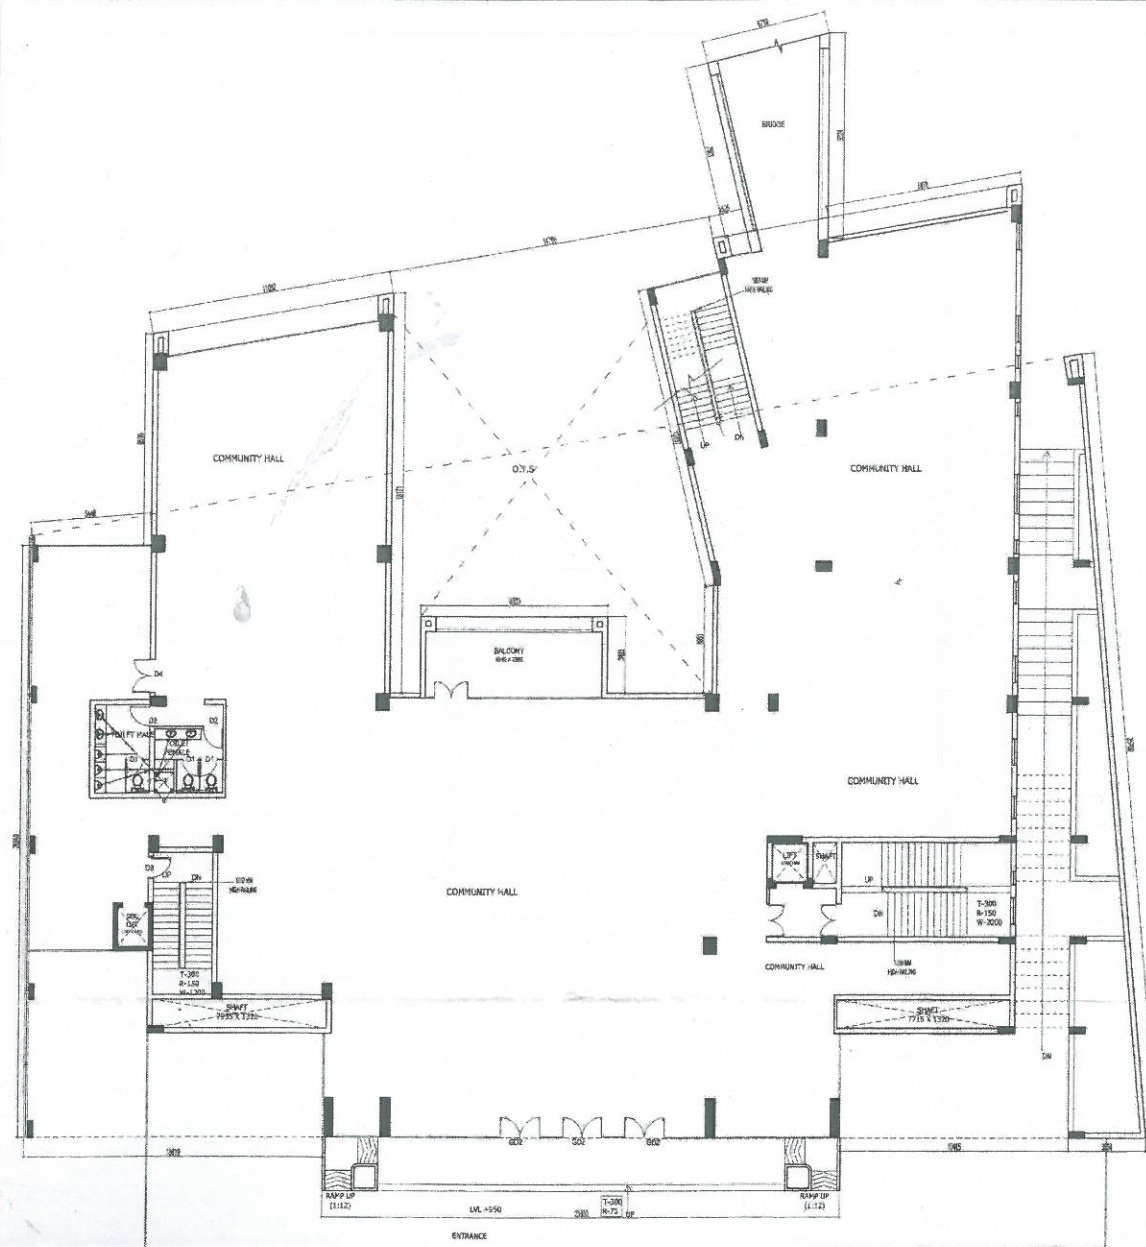

GROUND FLOOR PLAN

15% ADDITIONAL F.A.R. AREA CALCULATION OF COMMUNITY CENTER		
S.NO.	PARTICULARS	AREA (SQ.M)
PROPOSED CLUB F.A.R. AREA		
1	15% ADDITIONAL F.A.R. AREA CALCULATION AT GROUND FLOOR	= 1641.319
2	15% ADDITIONAL F.A.R. AREA CALCULATION AT FIRST FLOOR	= 1372.560
3	15% ADDITIONAL F.A.R. AREA CALCULATION AT SECOND FLOOR	= 1197.730
4	15% ADDITIONAL F.A.R. AREA CALCULATION AT TERRACE FLOOR	= 108.833
TOTAL AREA		4326.242

GROUND COVERAGE AREA		
S.NO.	PARTICULARS	AREA (SQ.M)
GROUND FLOOR AREA CALCULATION TOWARD 15% ADDITIONAL F.A.R.		
TOTAL AREA		1641.319

20% ADDITIONAL F.A.R. AREA CALCULATION TOWARD 15% ADDITIONAL F.A.R. FOR GROUND FLOOR


S.NO.	PARTICULARS	AREA (SQ.M)
1	23.631 X 4.705 =	111.194
2	8.047 X 4.073 =	32.775
3	5.573 X 8.476 =	47.237
4	8.047 X 3.771 =	30.345
5	4.255 X 15.291 =	65.124
6	13.618 X 11.516 =	156.825
7	6.868 X 16.482 =	113.287
8	0.230 X 0.420 =	0.097
9	0.602 X 8.699 =	5.303
10	0.5 X 9.824 X 1.678 =	8.242
11	0.822 X 1.907 =	1.562
12	10.301 X 8.588 =	88.456
13	8.500 X 18.953 =	161.106
14	18.818 X 15.490 =	291.272
15	13.262 X 5.291 =	70.179
16	0.5 X 0.425 X 1.738 =	0.370
17	5.116 X 1.691 =	8.651
18	0.5 X 0.425 X 0.420 =	0.089
19	2.931 X 11.688 =	34.287
20	0.5 X 3.262 X 0.773 =	1.261
21	5.114 X 0.773 =	3.953
22	0.188 X 1.548 =	0.293
23	0.5 X 3.724 X 0.645 =	1.204
24	0.5 X 1.918 X 47.901 =	7.569

AREA DIAGRAM FOR GROUND FLOOR

25	0.5	X	3.842	X	0.905	=	1.738
26			3.734	X	7.484	=	27.845
27	0.5	X	5.303	X	0.916	=	2.426
28			5.114	X	1.548	=	7.916
29	0.5	X	9.978	X	1.529	=	6.684
30			5.370	X	11.267	=	61.041
31			8.647	X	16.298	=	141.171
32	0.5	X	2.858	X	0.452	=	0.648
33	0.5	X	6.410	X	0.452	=	0.393
34			2.863	X	30.110	=	86.205
35	0.5	X	2.737	X	30.236	=	41.378
36			3.100	X	5.004	=	15.512
37	0.5	X	0.454	X	5.019	=	1.139
TOTAL 15% ADDITIONAL F.A.R. AREA							1641.319

This drawing is a "COPYRIGHT" of the architect. It is not to be used or reproduced without the permission of the architect.

GENERAL NOTE: PLANT ROOMS, TOILET, KITCHEN ETC. IF NOT NATURALLY VENTILATED, MECHANICALLY VENTILATED. FOR PURPOSES OF PROPOSED F.A.R. AFTER REC. SUBMITTED FOR APPROVAL PLEASE.

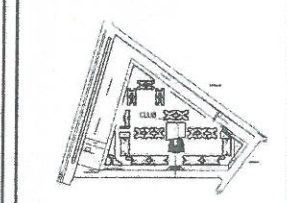

PLUMBING LEGEND	
1	1000 SOIL & VENT PIPE
2	1000 WASTE & VENT PIPE
3	1500 RAIN WATER PIPE
4	COLD WATER SUPPLY ON TAKE
5	80 B CNG RISER PIPE TO G.H. TANK
6	75 B RAIN WATER PIPE
FD	FLOOR DRAIN (WITH GRATING)
FT	FLOOR TRAP (100 X 75MM WITH GRATING)
BD	BALCONY DRAIN (WITH GRATING)
WB TO FT	300 WASTE PIPE
FD TO FT	800 WASTE PIPE
FT TO VERTICAL STACK	750 WASTE PIPE
WB TO VERTICAL STACK	1000 SOIL PIPE

SUBMISSION DRAWING

CLIENT: IV COUNTY PVT. LTD.

PROJECT: Cleo County

PROPOSED GROUP HOUSING FOR IV COUNTY PVT. LTD. AT PLOT NO.-GH-05 SECTOR-121, MOHA, U.P.

DATE: 15.07.19 PROJECT WORKSHEET CHECKED BY: TOWN PLANNER

SCALE: 1:100 DRAWING SHEET DEALT BY: SUBMIT SHEETS APPROVED BY: TOWN PLANNER

DRAWING TITLE: GROUND FLOOR PLAN COMMUNITY CENTRE

OWNER SIGN: IV COUNTY PVT. LTD. PROJECT SIGN: [Signature]

Authorised Signatory: [Signature]

TOWN PLANNER SIGN: [Signature]

TOWN PLANNER: [Signature]

ARCHITECT: Confluence

CONFLUENCE ARCHITECTS

201, 2ND FLOOR, 10/11, 10/12, 10/13, 10/1088, 10/10