



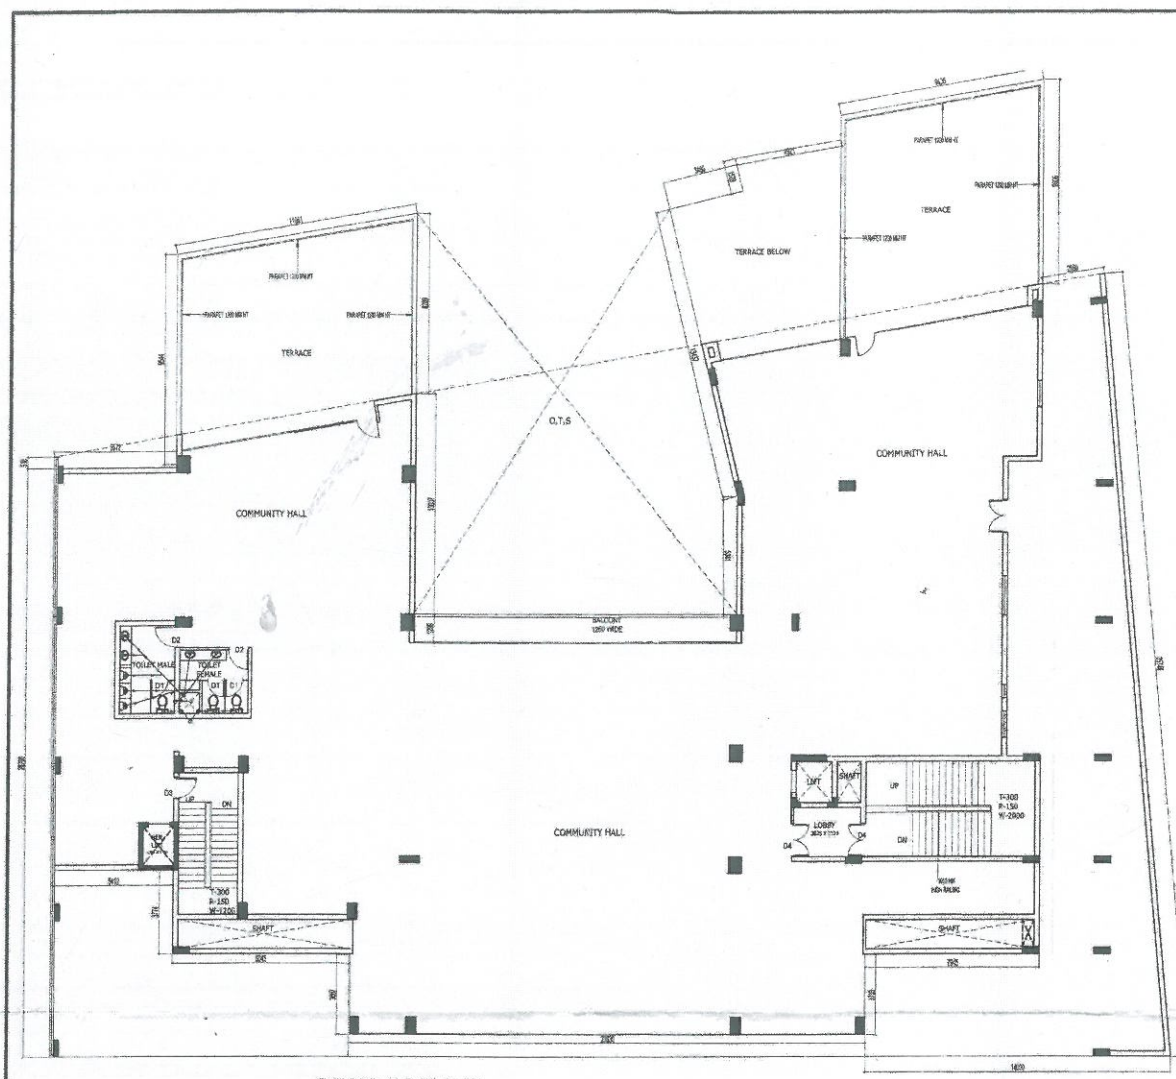

SECOND FLOOR PLAN

TOTAL AREA OF SECOND FLOOR			
S.NO.	PARTICULARS		AREA (SQ.M)
SECOND FLOOR AREA CALCULATION TOWARD 15% ADDITIONAL F.A.R.			1197.730
TOTAL AREA			1197.730

नोट: 1. यह मानचित्र सहायक नक्शे के तहत तैयार किया गया है। यदि आप 5 वर्ष की अवधि के लिए इसे उपयोग करना चाहते हैं, तो आपको इसे नक्शा कार्यालय में दर्ज कराना होगा। अन्यथा, इसे नष्ट कर दिया जाएगा।

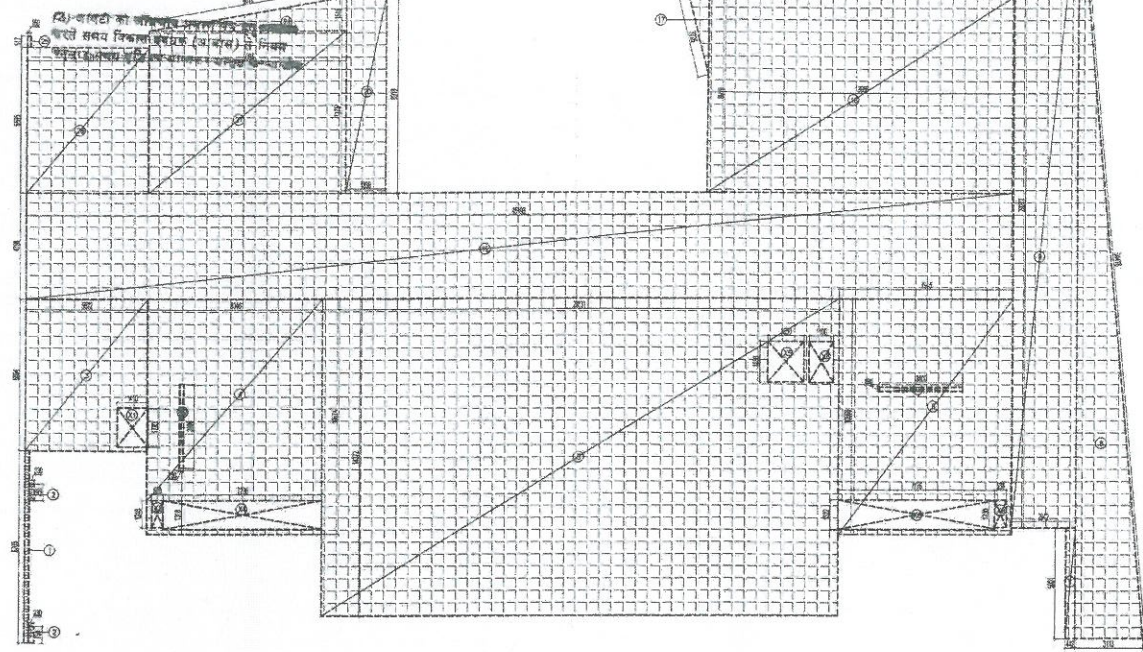

AREA DIAGRAM FOR SECOND FLOOR

AREA CALCULATION TOWARDS 15% ADDITIONAL F.A.R FOR SECOND FLOOR									
S.NO.	PARTICULARS					AREA (SQ.M)			
1						1.741			
2						0.300			
3						38.413			
4						85.883			
5						336.825			
6						84.757			
7						2.210			
8	0.5	X	3.113	X	34.418	53.572			
9			2.942	X	29.277	89.133			
10	0.5	X	0.780	X	0.837	0.318			
11	0.5	X	0.410	X	0.454	0.083			
12	0.5	X	2.858	X	0.454	0.840			
13			2.880	X	0.833	2.382			
14	0.5	X	15.889	X	2.748	21.578			
15	0.5	X	0.598	X	2.538	0.759			
16			14.859	X	2.488	36.842			
17	0.5	X	0.902	X	3.728	1.680			
18			13.958	X	8.919	124.474			
19			45.193	X	4.798	219.636			
20			1.836	X	8.919	16.375			
21	0.5	X	1.973	X	1.943	1.559			
22	0.5	X	1.954	X	0.870	0.855			
23	0.5	X	0.115	X	0.870	0.039			
24	0.5	X	9.072	X	1.545	7.006			
25			0.180	X	0.517	0.083			
26			5.571	X	8.595	36.741			
27			9.084	X	7.375	66.962			
TOTAL 15% ADDITIONAL F.A.R AREA WITHOUT SUBTRACTION (A)						1226.989			
AREA SUBTRACTION									
STAIRCASE CUTOUT									
X1			1.410	X	1.760	2.482			
X2			0.230	X	3.800	0.780			
X3			0.320	X	1.918	0.649			
X4			1.318	X	7.096	9.333			
X5			1.650	X	1.850	3.053			
X6			1.190	X	1.850	2.035			
X7			3.630	X	0.200	0.750			
X8			1.322	X	7.178	9.487			
X9			0.538	X	1.230	0.662			
TOTAL CUTOUT AREA (B)						29.239			
TOTAL 15% ADDITIONAL F.A.R AREA (A) - (B)						1197.730			

IV County Pvt. Ltd.
Auth. Sign.

This drawing is a "COPYRIGHT" contents of this drawing, part thereof may not be used or reproduced without the permission of the Architect.

NO. OF SHEET	DATE	ISSUED TO	REMARKS

REVISION	DATE	DESCRIPTION	BY

GENERAL NOTES:
1. ANY VENTILATION, TOILET, UTILITY, ETC. IT IS NOT PERMITTED TO BE PLACED IN THE BUILDING.
2. THE STAIRCASE IS OF PROPOSED TYPE AS PER PLAN.

CLUB

AREA LEGEND:

FAR AREA
COUNTED IN FAR AREA

PLUMBING LEGEND:

1	1000 SOIL & VENT PIPE
2	1000 WASTE & VENT PIPE
3	1500 RAIN WATER PIPE
4	COLD WATER SUPPLY ON TAKE
5	60 Ø COLD WATER PIPE TO CUM. TANK
6	75 Ø RAIN WATER PIPE
FD	FLOOR DRAIN (WITH GRATING)
FT	FLOOR TRAP (100 Ø TRAP WITH GRATING)
BD	BALCONY DRAIN (WITH GRATING)
WS TO FT	80 Ø WASTE PIPE
FD TO FT	80 Ø WASTE PIPE
FT TO VERTICAL STACK	75 Ø WASTE PIPE
WS TO VERTICAL STACK	1000 SOIL PIPE

SUBMISSION DRAWING

CLIENT
IV COUNTY PVT. LTD.

PROJECT
Cleo County

PROPOSED GROUP HOUSING FOR
IV COUNTY PVT. LTD.
AT PLOT NO. - 04 - 05, SECTOR - 121,
MODA, U.P.

DATE: 14.11.2018
SCALE: 1:100

PROJECT ENGINEER: [Signature]
ARCHITECT: [Signature]
TOWN PLANNER: [Signature]

DRAWING TITLE
SECOND FLOOR PLAN
COMMUNITY CENTRE

OWNER SIGN: [Signature]
ARCHITECT SIGN: [Signature]
TOWN PLANNER SIGN: [Signature]

ARCHITECTS
Confluence

REGISTRATION NO. S-081
PRACTICE NO. RO

This drawing is available on www.fires.inconfluence.com.