


PROPOSED PLAN OF THE RESIDENTIAL  
BUILDING FOR SRI SANJEET KUMAR ,SRI  
MANISH  
KUMAR & RAJAN KUMAR SONS OF  
LATE SRI GORAKH PRASAD & ISHANT KUMAR  
S/O  
SRI SANTOSH KUMAR & SMT. MANJULA DEVI W/O  
SRI SANTOSH KUMAR AND SMT. SHAKUNTALA  
DEVI  
W/O LATE SRI GORAKH PRASAD

SITUATED AT. NATHMALPUR  
GORAKHPUR

ARAZI NO. -129(mi),143

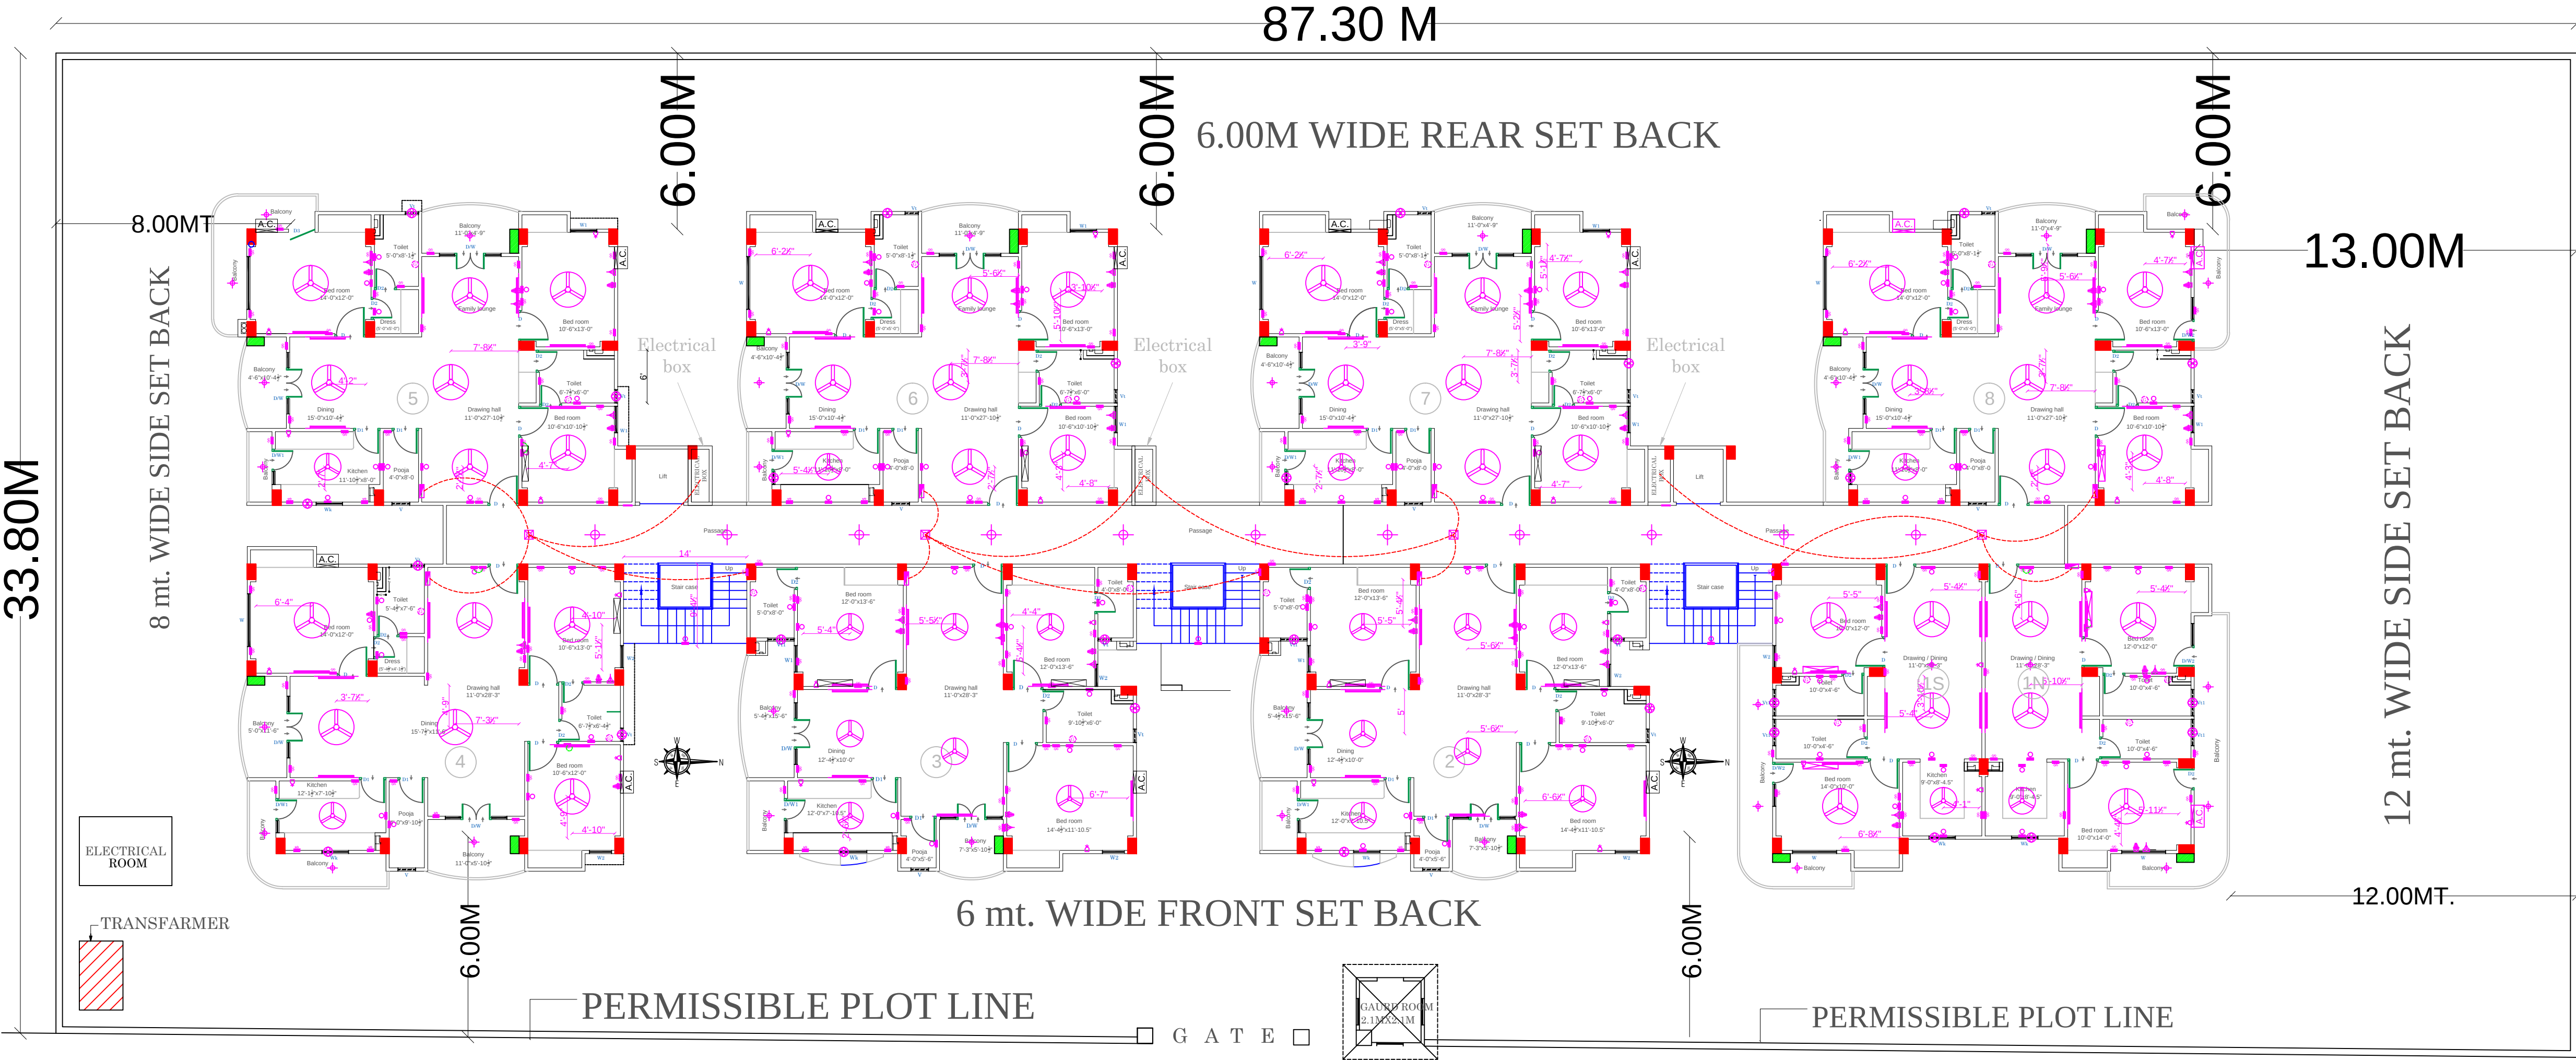

## ELECTRICAL PLAN

| TYPE | PARTICULAR | SIZE          |
|------|------------|---------------|
| D    | DOOR       | 3'-6" X 7'-0" |
| D1   | DOOR       | 3'-0" X 7'-0" |
| D2   | DOOR       | 2'-6" X 7'-0" |
| W    | WINDOW     | 6'-0" X 5'-0" |
| W1   | WINDOW     | 4'-0" X 5'-0" |
| W2   | WINDOW     | 3'-0" X 5'-0" |
| WK   | WINDOW     | 5'-0" X 3'-6" |
| V    | VENTILATOR | 3'-0" X 1'-6" |

| SCALE                   | STAIR DETAIL | LEGEND                                                                                                               |
|-------------------------|--------------|----------------------------------------------------------------------------------------------------------------------|
| 1" = 8'-0", 1" = 4'-0"  | RISER - 6"   | PROPOSED CONSTRUCTION<br>EXISTING CONSTRUCTION<br>EXISTING TO BE DEMOLISH<br>EXISTING TO BE COMPOUNDED<br>SEVER LINE |
| 1" = 2'-0", 1" = 32'-0" | TREAD - 12"  |                                                                                                                      |

DATE :-

DRN. BY :-

SPECIFICATION :-

- ALL BRICK WORK TO BE DONE WITH CEMENT SAND MORTAR 1:6
- R.C.C. WORK TO BE DONE WITH CEMENT CONCRETE RATIO 1:2:4
- SAL WOOD TO BE USED IN DOOR, WINDOW & VENTILATOR.

OWNER'S SIGN.