


BENNA GANESH PRATISHTHAN

SITE LINE

RETAINING WALL ABSTR.

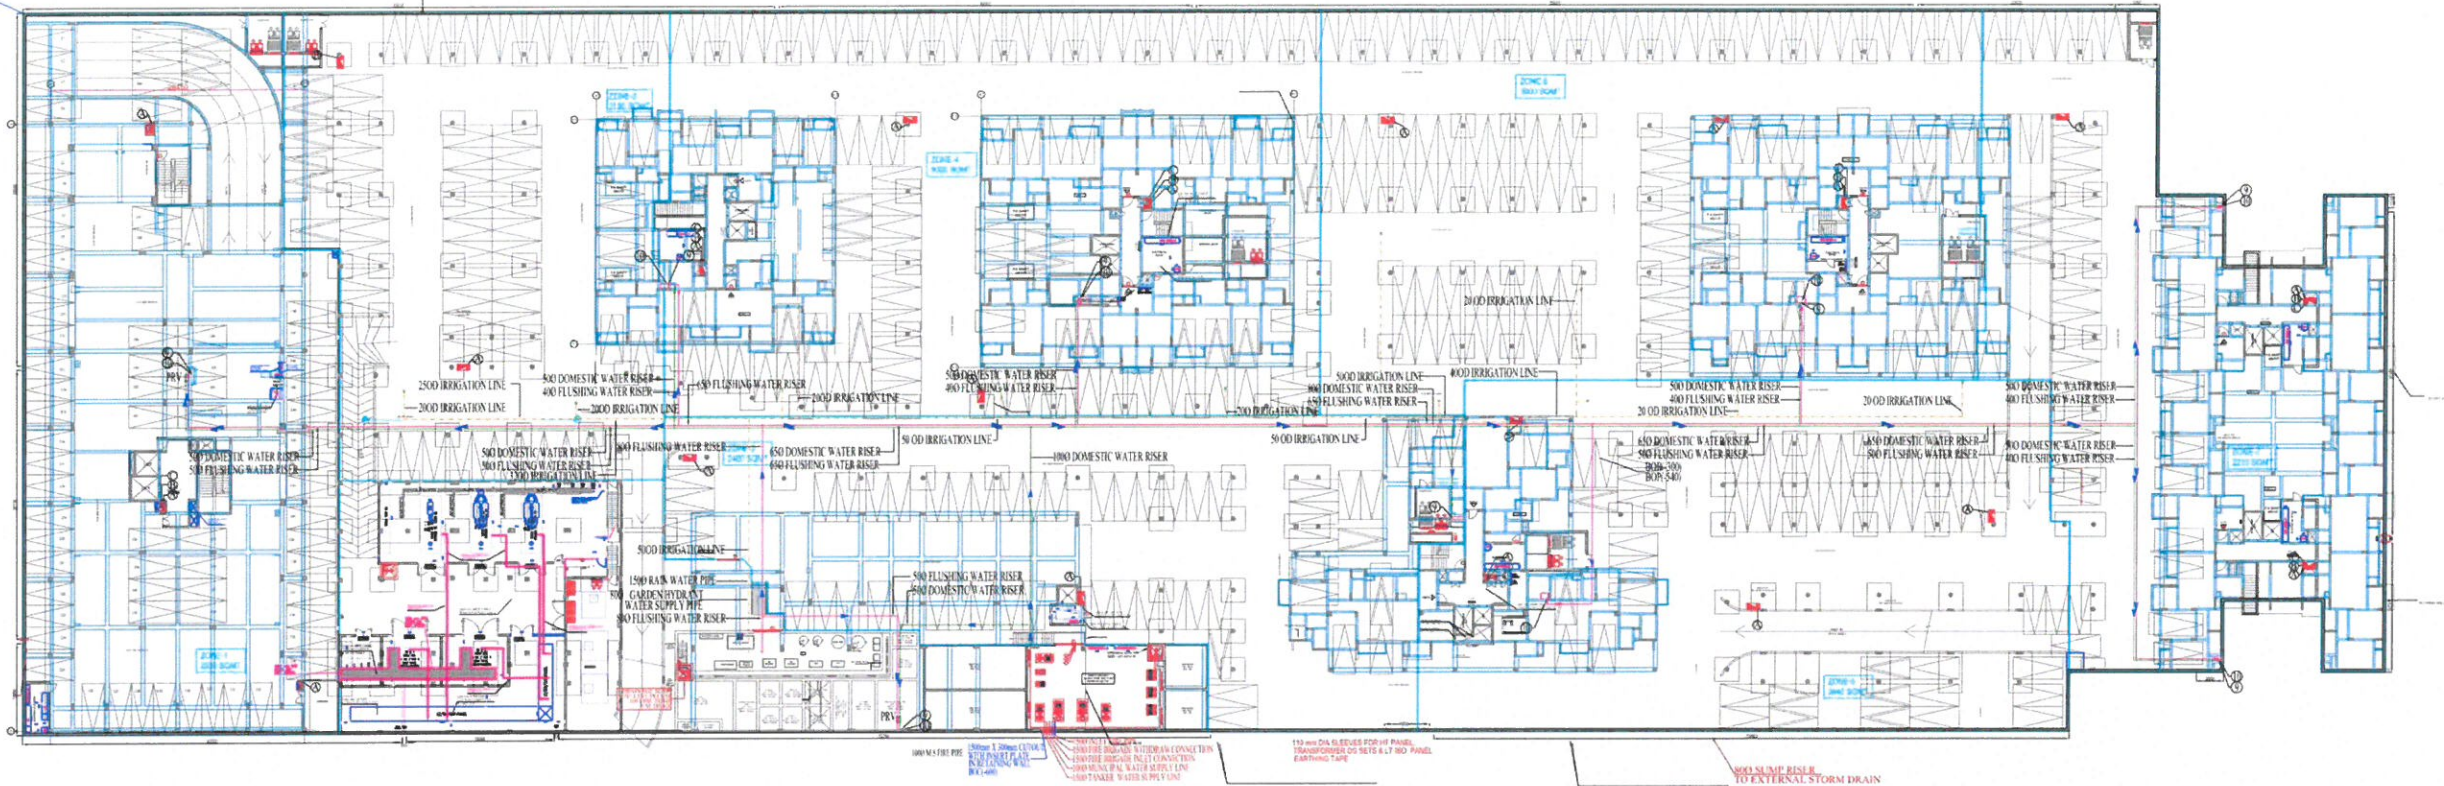

BASEMENT FLOOR PLAN

BASEMENT CEILING PLAN - WATER SUPPLY


GENERAL NOTES :

1. DRAWINGS IN PL & FF SERIES REPRESENTS PLUMBING AND FIRE SUPPRESSION SYSTEM.
2. IN CASE OF ANY DISCREPANCY IT SHOULD BE BROUGHT TO THE NOTICE OF ARCHITECT / PROJECT MANAGER / CONSULTANT.
3. DRAWING SHOULD NOT BE SCALED. ONLY WRITTEN DIMENSIONS TO BE FOLLOWED.
4. THIS DRAWING SHOULD BE READ IN CONJUNCTION WITH RELEVANT ARCHITECTURAL AND SCULPTING STRUCTURAL AND OTHER SERVICES DRAWING.
5. ALL SERVICES SHIFTS WILL BE SEALED AT EVERY FLOOR LEVEL AFTER INSTALLING SERVICES.


PLUMBING LEGEND

1. 110 OD SOIL/WASTE & VENT PIPE
2. 110 OD WASTE & VENT PIPE
3. 75# VENT PIPE
4. 75 OD BALCONY DRAIN PIPE
- 4a. 75 OD UTILITY BALCONY DRAIN PIPE
5. 160 OD RAIN WATER PIPE
- 5a. 200 OD RAIN WATER PIPE
- 2a. 110 OD KITCHEN & PANTRY WASTE PIPE
- 2b. 110 OD SHOP & CAFE WASTE PIPE
9. DOMESTIC WATER SUPPLY RISER
10. FLUSHING WATER SUPPLY RISER
- FD. FLOOR DRAIN
- FT. FLOOR TRAP
- FT. URINAL TRAP
- COP. CLEAN OUT PLUG
- BOB. BOTTOM OF BEAM
- BOC. BOTTOM OF CUTOUT
- BOP. BOTTOM OF PIPE
- DROP
- RISE

- ① 1500 FIRE HYDRANT PIPE
- ② 800 DRAIN PIPE
- ③ 1500 SPRINKLER PIPE

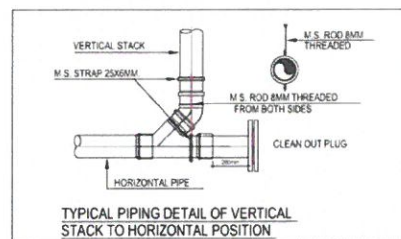


TYPICAL PIPING DETAIL OF VERTICAL STACK TO HORIZONTAL POSITION

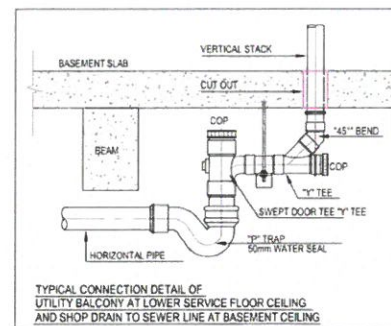

TYPICAL CONNECTION DETAIL OF UTILITY BALCONY AT LOWER SERVICE FLOOR CEILING AND SHOP DRAIN TO SEWER LINE AT BASEMENT CEILING

REVISIONS			
REV NO	DESCRIPTION	DATE	REMARK
R0	WATER SUPPLY LAYOUT	17-07-2018	

KEY PLAN

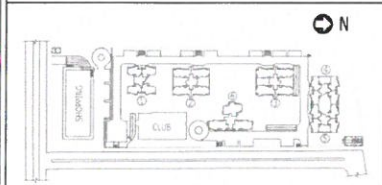

ELECTRICAL CONSULTANT
AMPOWER CONSULTANCY SERVICES
 B-222 (IND FL 1) NARAYANA (IND AREA) PHASE-1
 NEAR BHAKARWALA, NEW DELHI-110028
 PH: 2886772, 4414735 TEL: FAX NO: 41414735
 E-mail: ampower@ampowerconsultancy.com

HVAC CONSULTANT
GSP DESIGN CONSULTANT
 M.E.P. BUILDING SERVICES
 80 Buss Road, Third Floor, Jeeva Park
 Near Mini Model School / Garden Dham Mandir, New Delhi-110056
 E-mail: msp.gsp@gmail.com

Plumbing and Fire Suppression Consultants
C P Vidya and Associates
 312A, UNITECH ARCADE, SOUTH CITY-4
 SECTOR-49 NEAR PARK HOSPITAL (GURGAON)
 Haryana-122018 (INDIA)
 Email: cpvidyaassociates@gmail.com

STRUCTURAL CONSULTANT
PRISTINE IDEAS
 40/221, LOWER GROUND FLOOR, CR PARK, NEW DELHI-110019
 PHONE: 011-49053477
 E-mail: aashish@pristineideas.org

LANDSCAPE CONSULTANT
DESIGN ACCORD
 301 & 302 U.S. COMPLEX 125 MATHURA ROAD, OPP. APOLLO HOSPITAL
 NEW DELHI-110076
 Telephone: +91 11 26387203
 E-mail: mail@designaccord.net

PROJECT:
EXPERION - CAPITAL

CLIENT:

EXPERION PVT. LTD.
 FIRST FLOOR, 1101 FLOOR BLOCK B, SUBHANT 104,
 M G ROAD, GURGAON, HARYANA 122002
 PHONE: +91 124-442 2630, TEL/FAX: +91 124-442 2633

DSP DESIGN ASSOCIATES PVT. LTD.
 Architects & Interior Designers

8th Floor, Deshpand House, Shiv Sagar
 Estate, D. Anna Besant Road, Opposite
 Narayana Centre, Varanasi, Mumbai - 400 018
 Tel: +91 22 4910 1800
 Web: www.dspdesign.co.in


#1002A, Tenth Floor,
 Times Tower, M G Road,
 Gurgaon-122002
 Tel: +91 124 4221417

• MUMBAI • BANGALORE • PUNE • DELHI • HYDERABAD • CHENNAI

SHEET TITLE:
BASEMENT CEILING WATER SUPPLY LAYOUT PLAN

DRAWING NO:	PL/EC/BAS-01A	DATE:	17-07-2018
SCALE:	1:400	STATUS:	REVISION
DEALT	CHECKED	SURVEET	ALOK

THIS DRAWING IS THE SOLE PROPERTY OF DSP DESIGN ASSOCIATES PVT. LTD.
 USE OF THIS DRAWING FOR ANY PURPOSE OTHER THAN THAT MENTIONED TO
 BE DONE ONLY AFTER THEIR PRIOR APPROVAL.

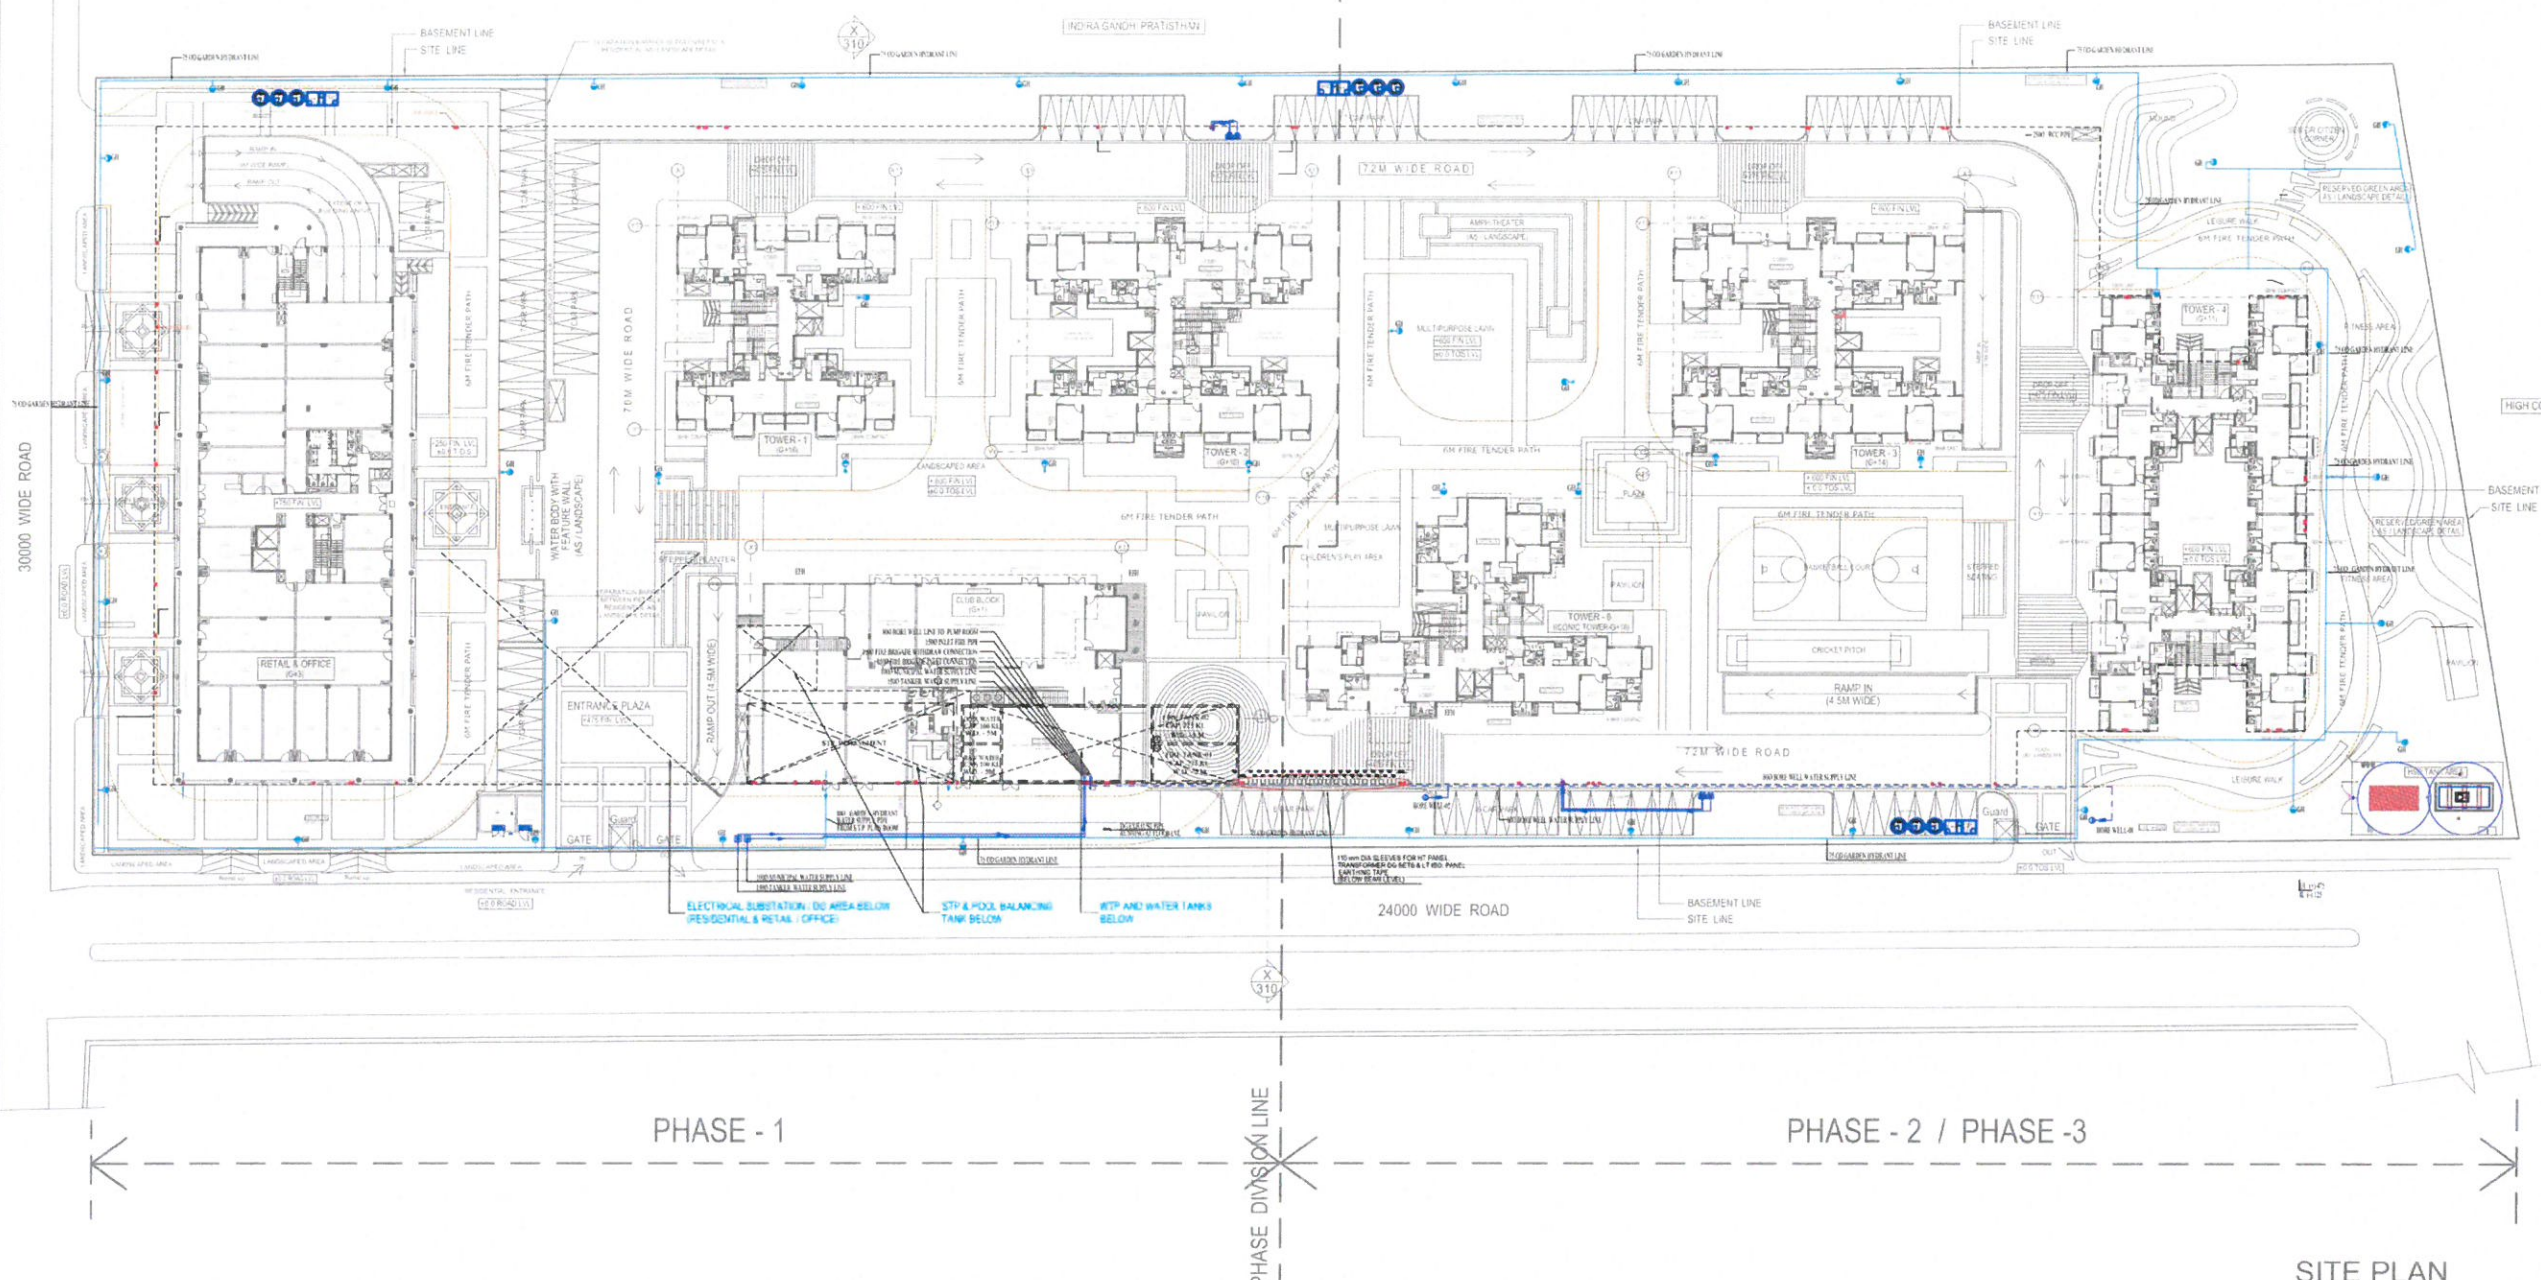

PLUMBING LEGEND:-

	DOMESTIC WATER SUPPLY
	FLUSHING WATER SUPPLY
	MUNICIPAL WATER SUPPLY
	GARDEN HYDRANT LINE
	GH GARDEN HYDRANT
	VALVE
	NON RETURN VALVE
	BORE WELL

QTY.	PRINTS ISSUED TO	ISSUE FOR	DATE

REV	DESCRIPTION	DATE

PROJECT
EXPERION - CAPITAL

CLIENT
EXPERION PVT. LTD.

Plumbing and Fire Suppression Consultants
C P Vidya and Associates
 312A UNITED ARCADE, SOUTH CITY-6
 SECTOR-48 NEAR PARK HOSPITAL (GURGAON)
 Maryana-72018 (INDIA)
 Email - cpvassociates@gmail.com

HVAC CONSULTANTS
GSP DESIGN CONSULTANT
 M E P BUILDING SERVICES
 B0 Block #56, Third Floor, Janki Park
 Near Mira Model School / Sanatan Dharm Mandir, New Delhi-110058
 E-mail - mep.gsp@gmail.com

ELECTRICAL CONSULTANTS
 AMPPOWER CONSULTANCY SERVICES
 B-222, (IND FL.), NARANA RD. AREA, PHASE-1,
 NEAR BHAMERWALA, NEW DELHI-110028
 Ph:- 2386772, 41414735, TELE FAX NO 41414735
 E-mail - vishal@ampowerconsultancy.com, vishal@ampowerconsultancy.com

STRUCTURAL CONSULTANTS
 PRISTINE IDEAS
 40/221, LOWER GROUND FLOOR, CR PARK,
 NEW DELHI, 110019. PHONE : 011 - 49053477
 E-mail - gajay@pristineideas.org

LANDSCAPE CONSULTANTS
 DESIGN ACCORD
 301 & 302, U.S. COMPLEX, 120, MATHURA
 ROAD, OPP. APOLLO HOSPITAL, NEW DELHI -
 110076
 Telephone : +91 11 26397203
 E-mail : mail@designaccord.net

DSP DSP DESIGN ASSOCIATES PVT. LTD.
 Architects & Interior Designers

6th Floor, Devchand House, Shiv Sagar
 Estate, Dr. Arvind Bhattar, Opposite
 Nehru Centre, Vasant Vihar, New Delhi - 110016
 Tel: +91 22 4915 1800
 Web: www.dspdesign.co.in

#1002A, Tenth Floor
 Times Tower, 41 G. Road,
 Gurgaon - 122009
 Tel: +91 124 4221417

MUMBAI BANGALORE PUNE DELHI HYDERABAD CHENNAI

Drawing Title: SITE PLAN WATER SUPPLY & IRRIGATION LAYOUT	Approved: C.P.V. Checked: A.K Scale: 1:450(A1) Dealt: M.S.A. Date: 23-05-17
Dwg No :- PL/EC/SP-01A	NORTH POINT:
Rev No :- R0	

SITE PLAN WATER SUPPLY