


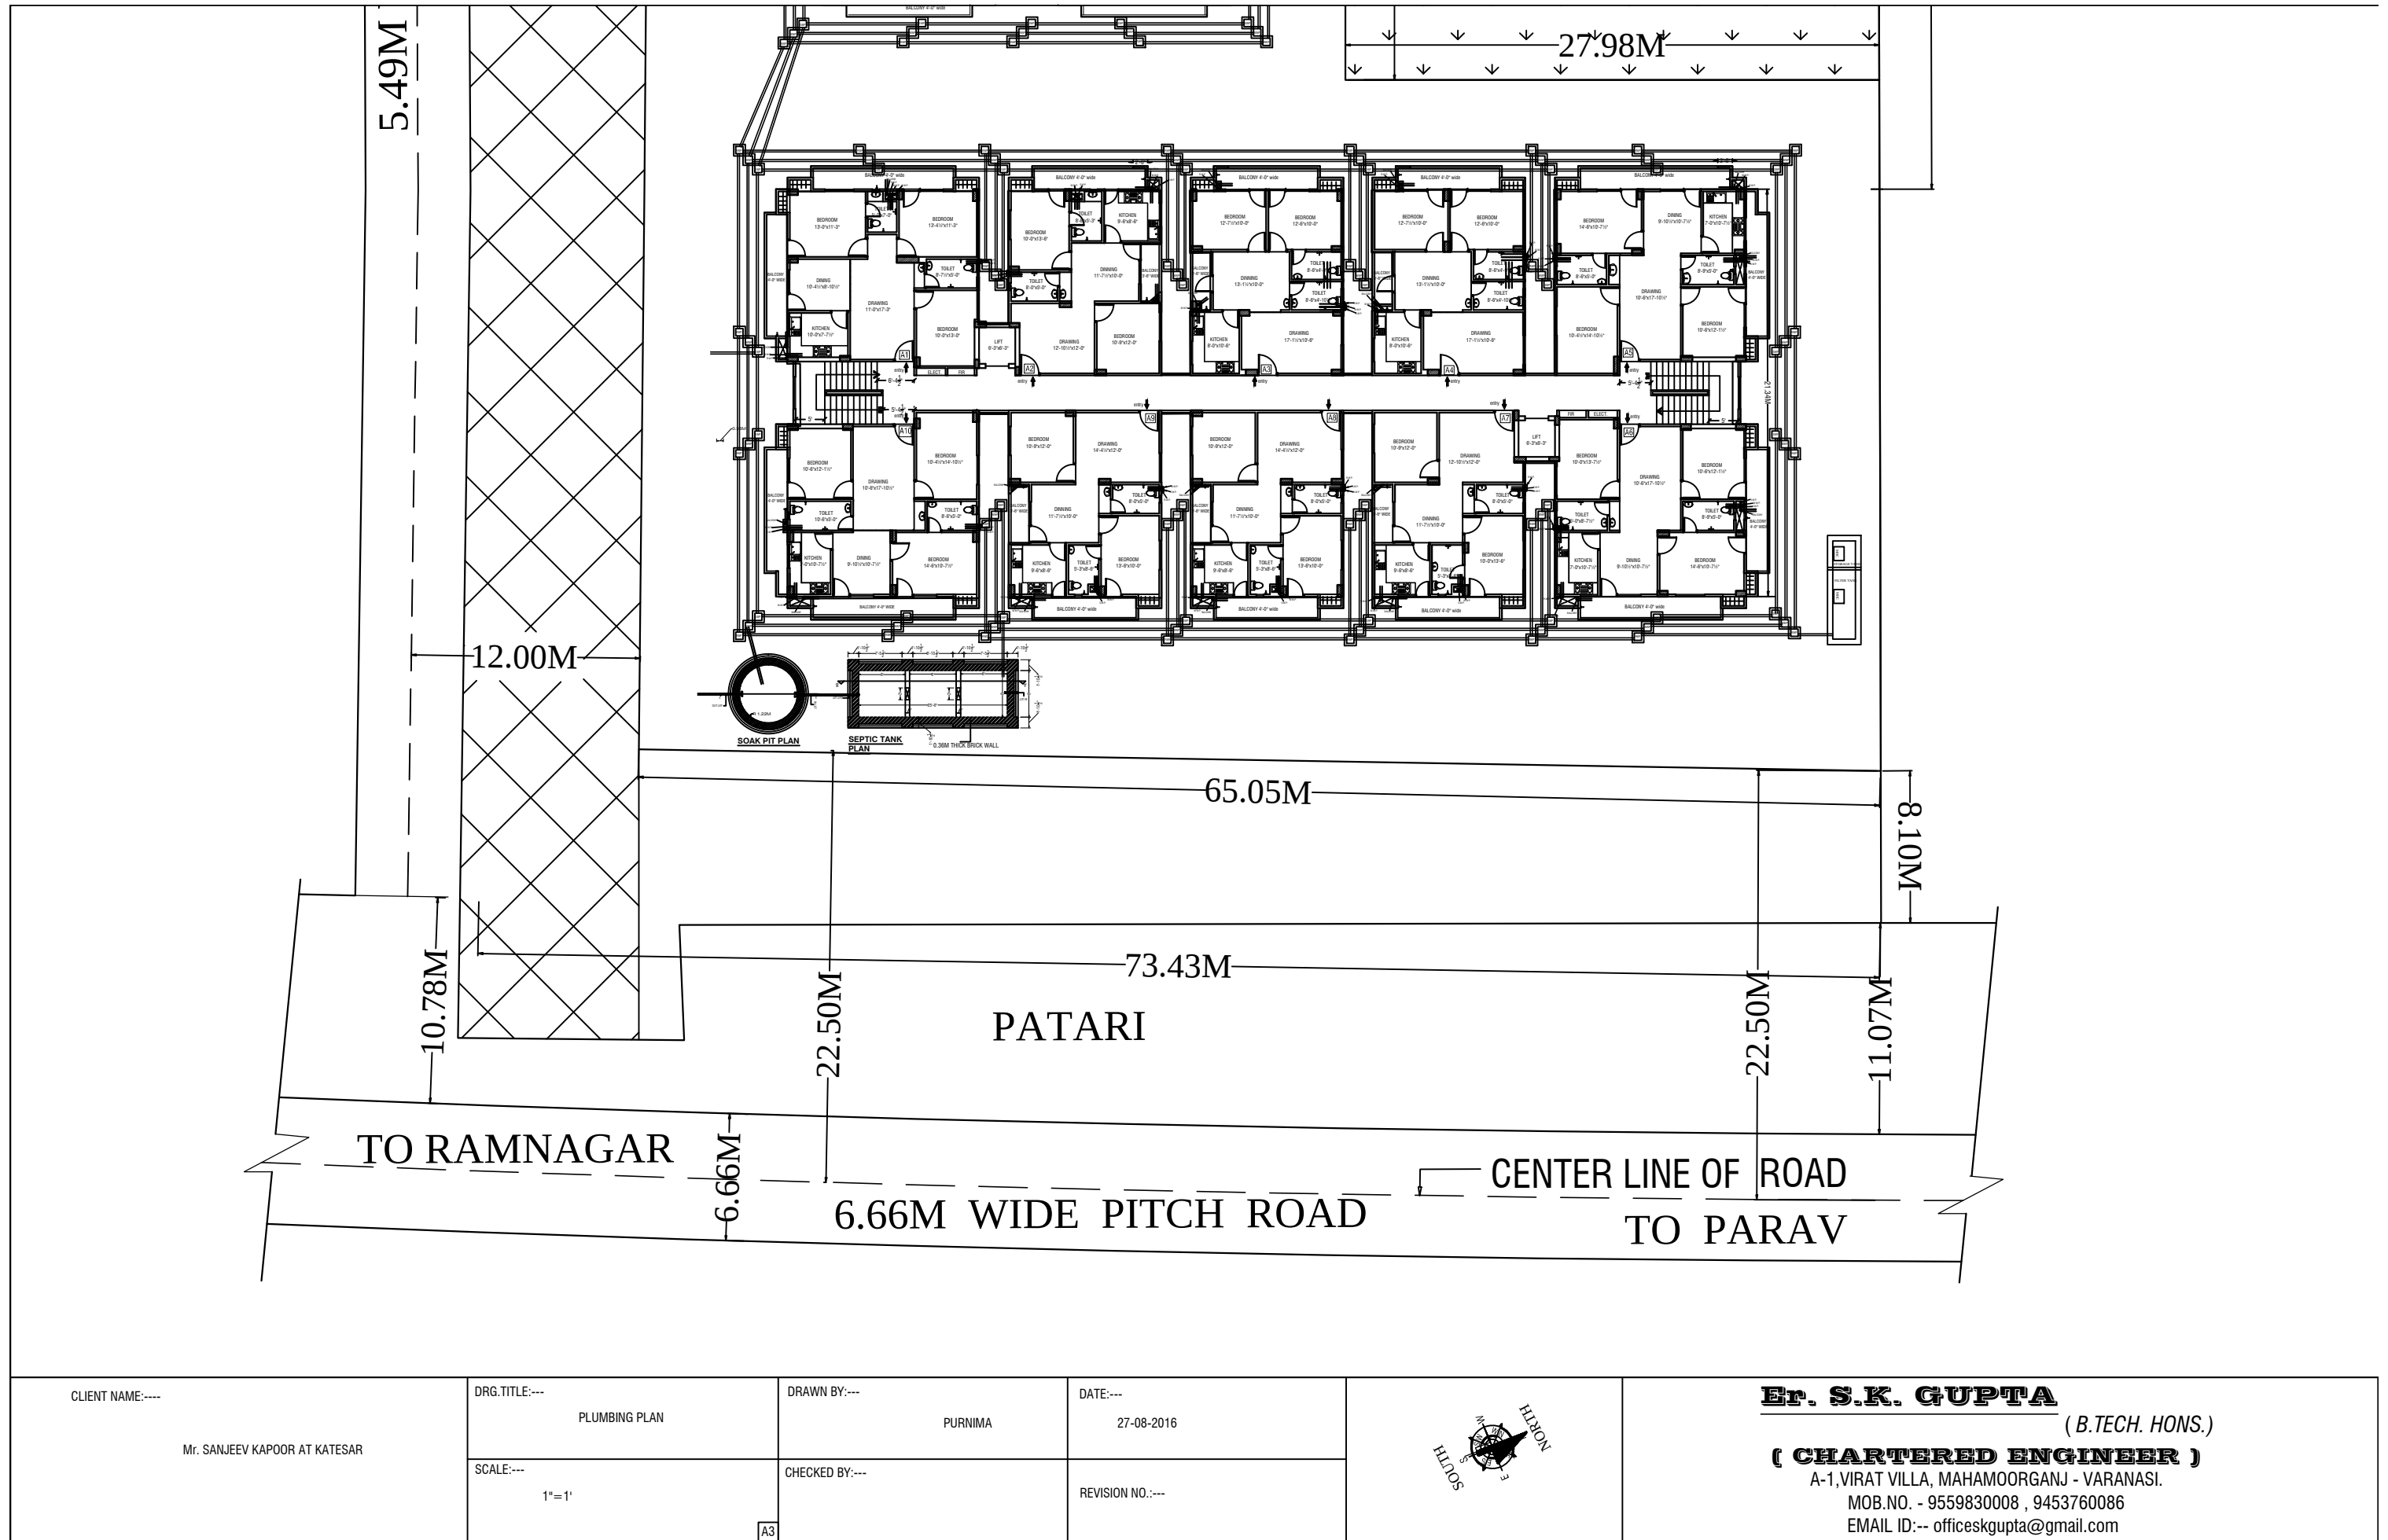

CLIENT NAME:----

Mr. SANJEEV KAPOOR AT KATESAR

DRG.TITLE:---

PLUMBING PLAN

DRAWN BY:---

PURNIMA

DATE:---

27-08-2016

SCALE:---

1"=1'

CHECKED BY:---

REVISION NO.----



Er. S.K. GUPTA

(B.TECH. HONS.)

(CHARTERED ENGINEER)

A-1,VIRAT VILLA, MAHAMOORGANJ - VARANASI.

MOB.NO. - 9559830008 , 9453760086

EMAIL ID:- officeskgupta@gmail.com