




This drawing is a "COPYRIGHT" contents of this drawing or part thereof may not be used or reproduced without the permission of the Architect

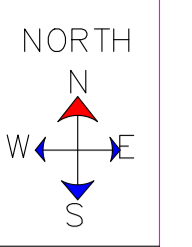

PROJECT
PROPOSED GROUP HOUSING-02 IN OMAXE HITECH CITY , LUCKNOW U.P.

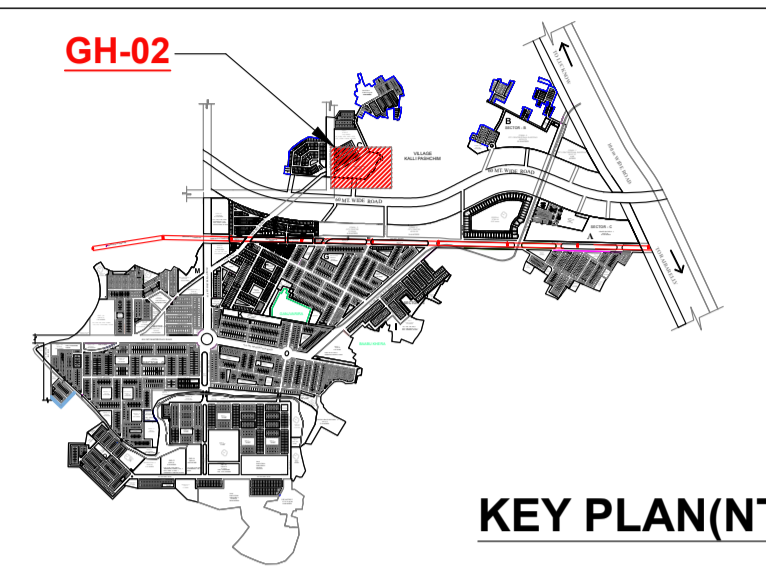

KEY PLAN(NTS)

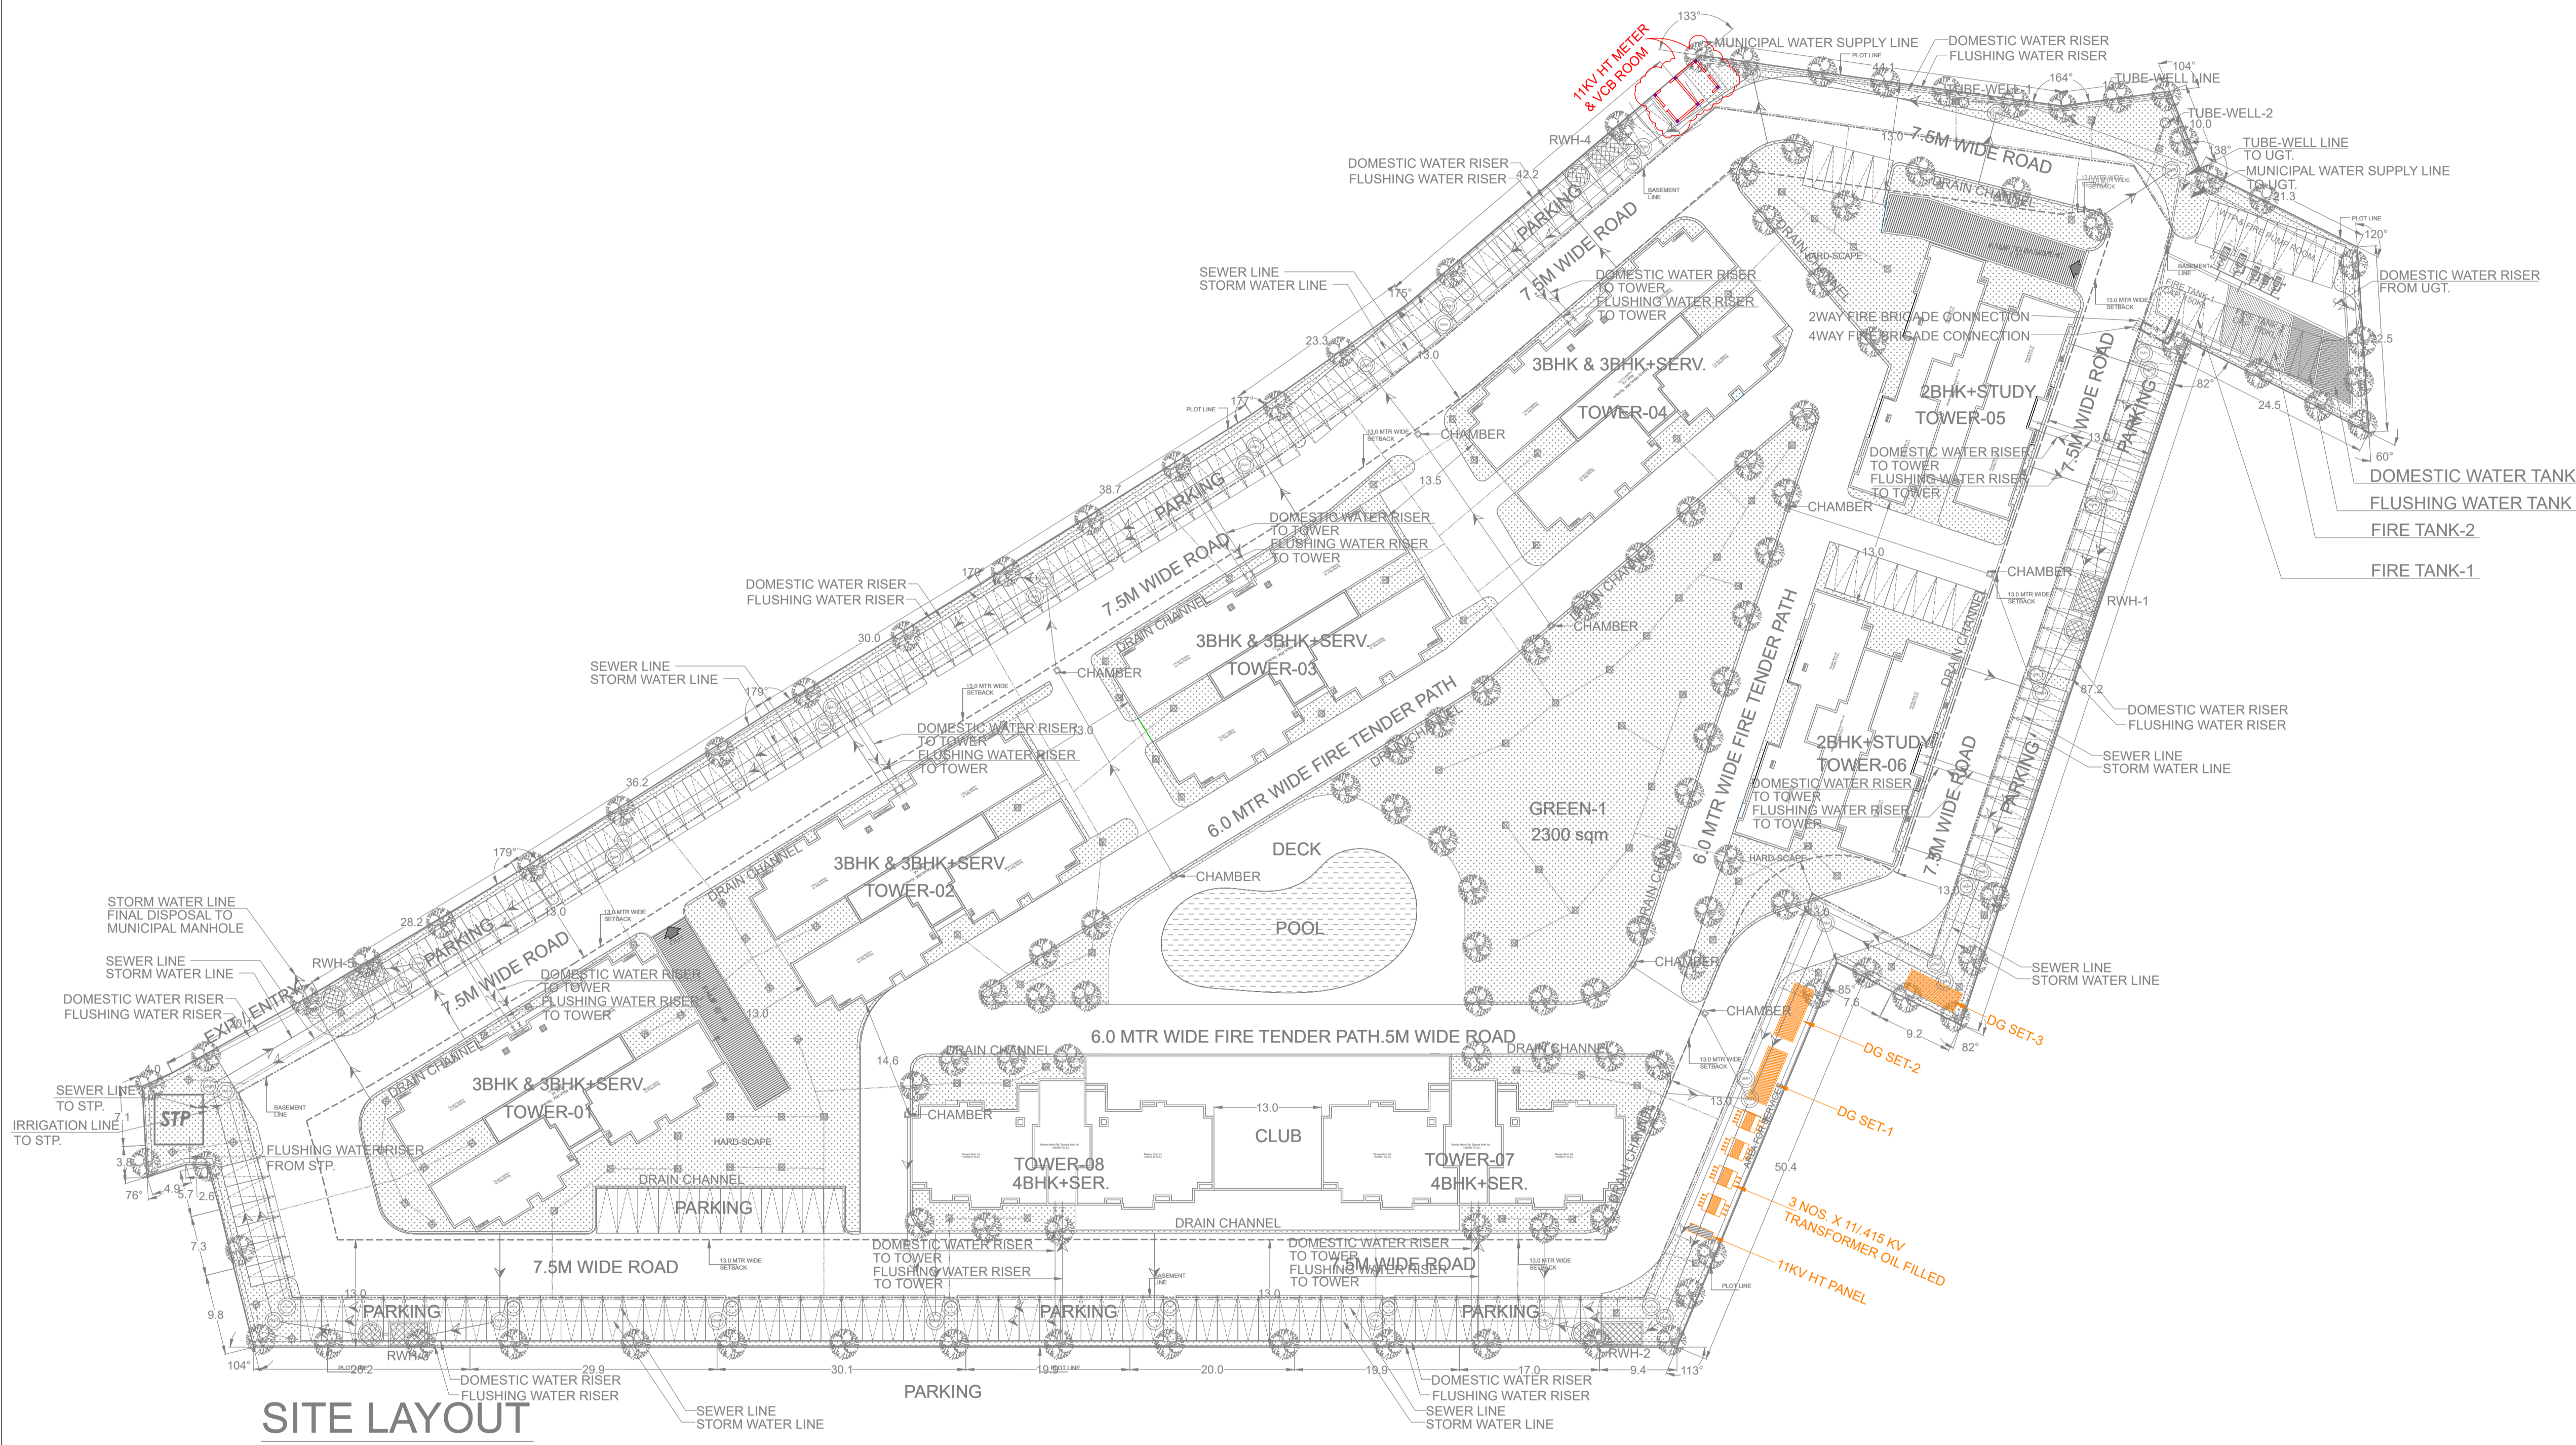

SITE LAYOUT

TOTAL PLOT AREA -22977.18 Sqm.

DRAWING TITLE
GROUP HOUSING-02 ELECTRICAL SITE PLAN

SCALE	DATE
ARCHITECT	CLIENT/ OWNERS
N.T.S.	JAN-2024

DRAWING NUMBER-
 LKO/HI-TECH/GH-02/SUB-01