




KANPUR- GWALIOR HIGHWAY

BASEMENT FLOOR PLAN

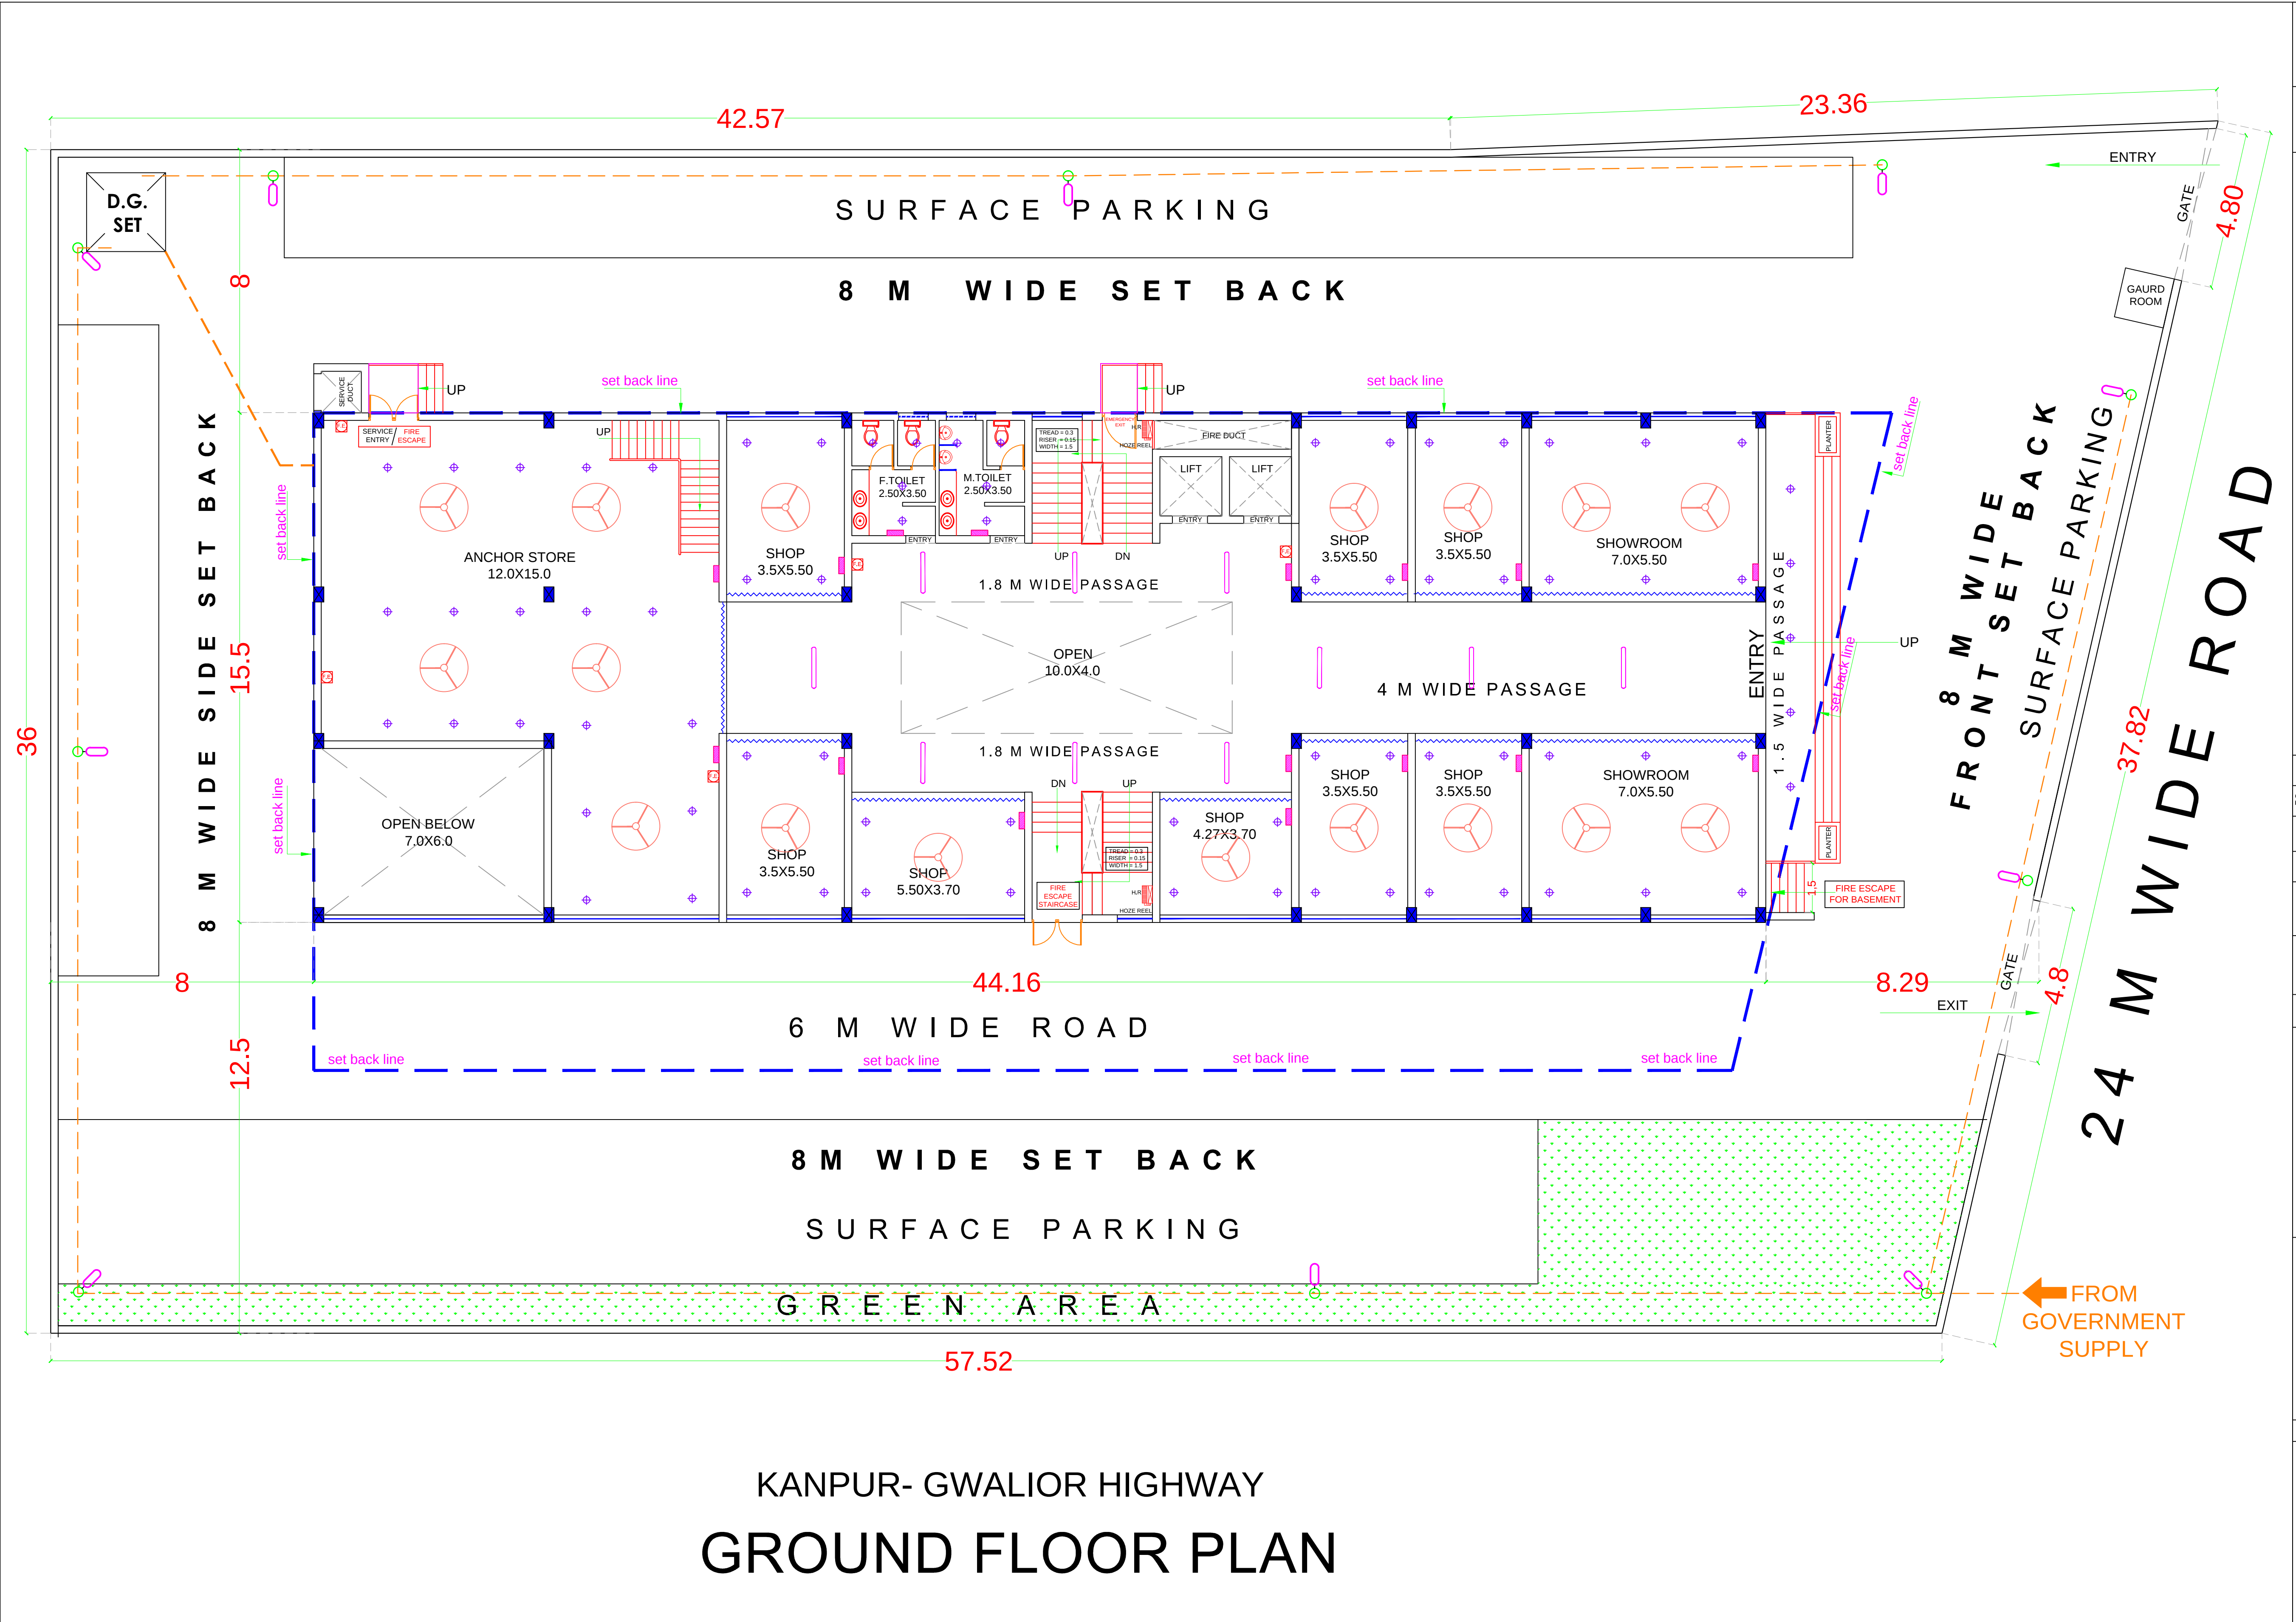

ELECTRICAL PLAN

SHEET NO. 3

GROUND FLOOR PLAN

LEGEND


S.N	SYMBOLS	DESCRIPTION
1		CEILING LIGHT
2		TUBE LIGHT
3		CHANDLER
4		CEILING FAN
5		SWITCH BOARD

PROPOSED COMMERCIAL BUILDING
ASHOK TRADE CENTRE FOR ASHOK
INFRA PROPERTIES PVT. LTD.
ARAJI No. 99/4 AND ARAJI No.
107 MOJA MERY AT KANPUR - GWALIOR
HIGHWAY, TEHSIL JHANSI
AUTH. SIGN:-
SH. ROHIT GIRI


ARCHITECT

ANUPAM NAYAK

AUTH. SIGN.

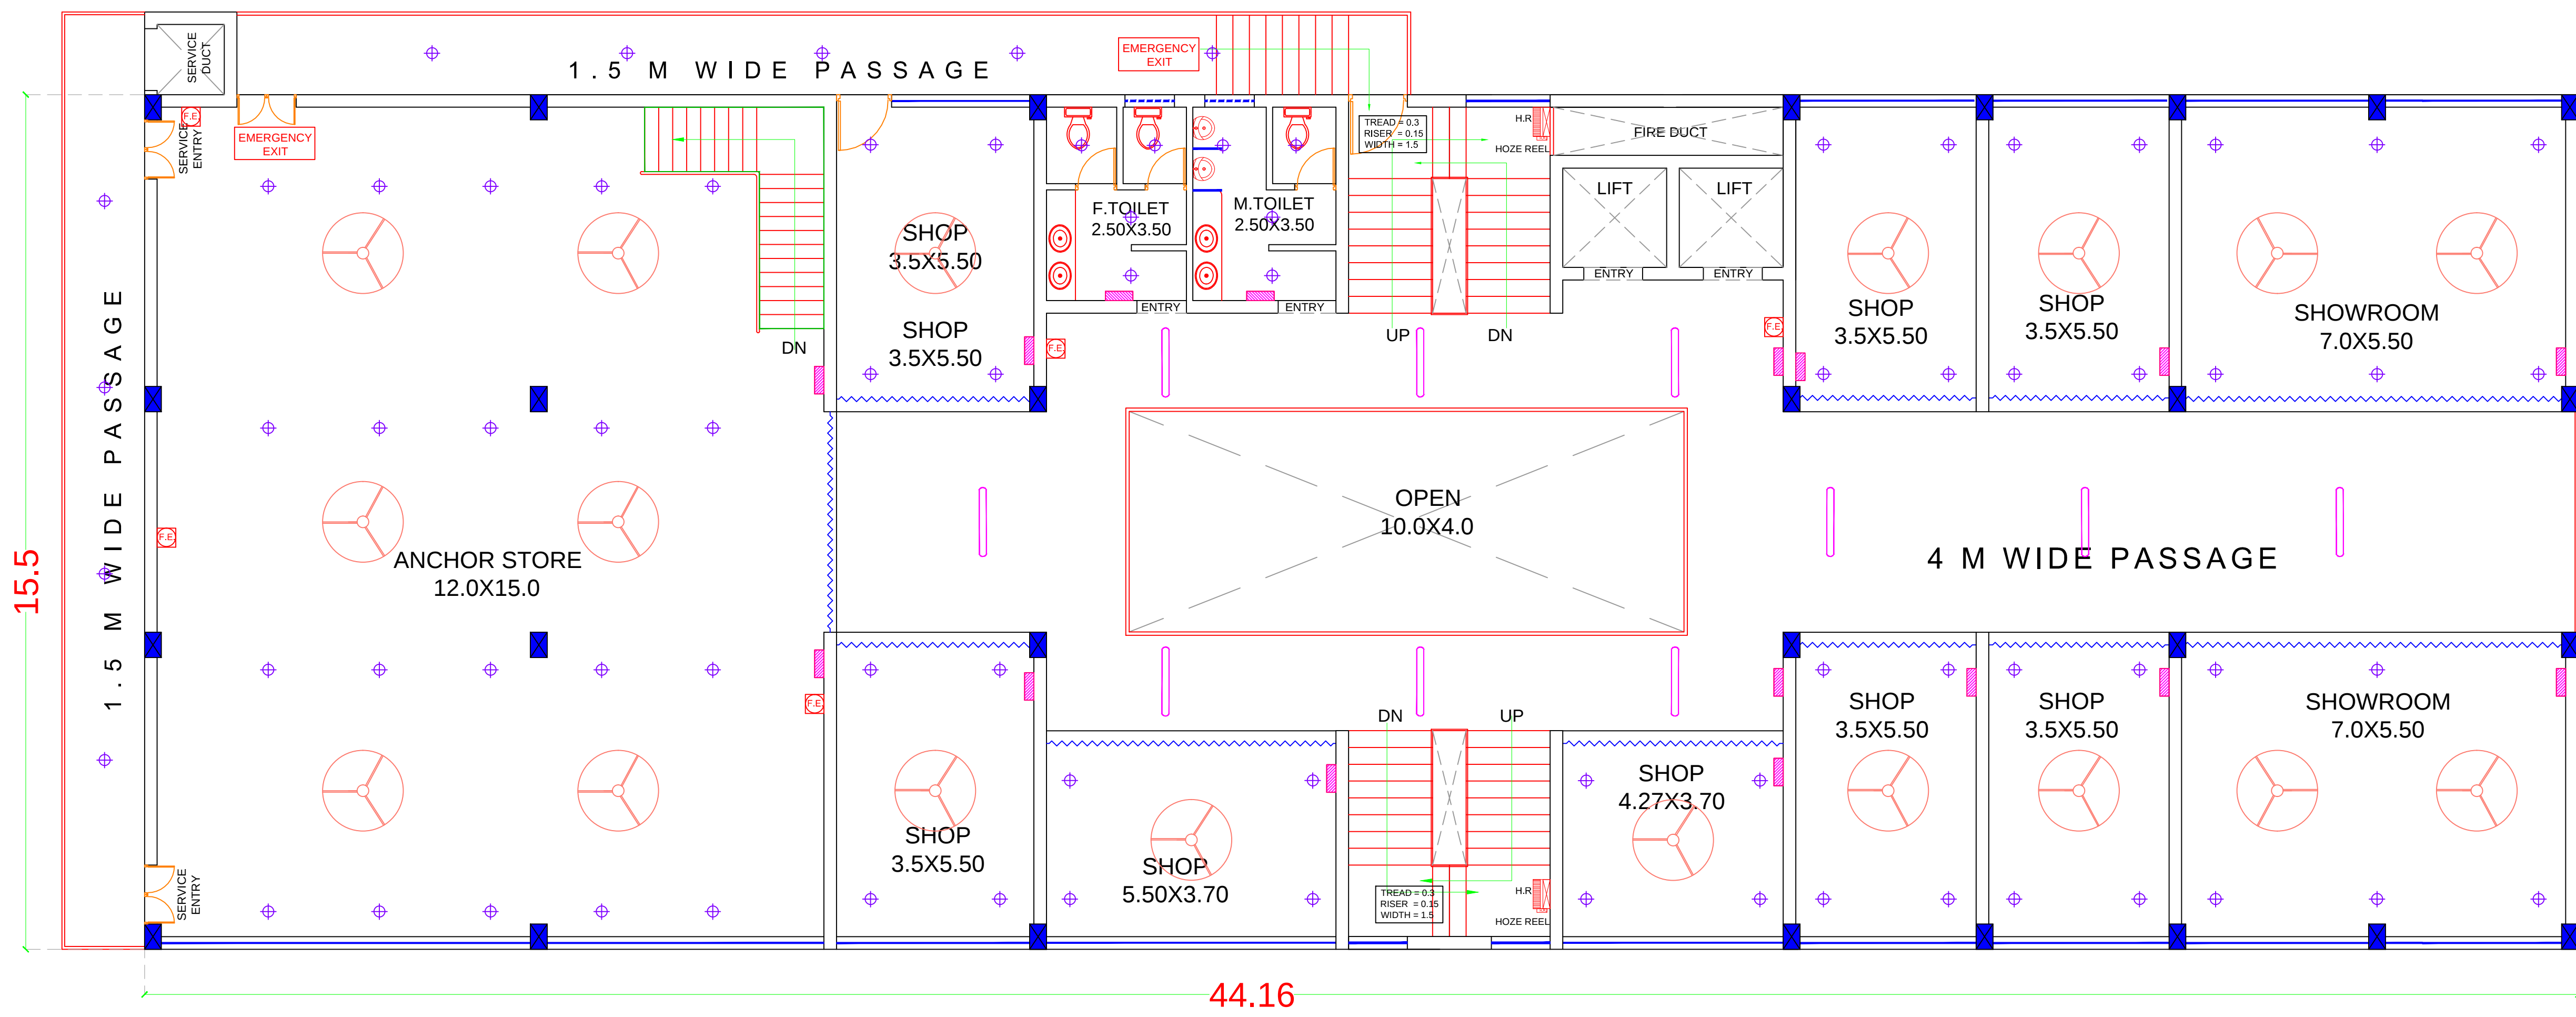

FIRST FLOOR PLAN

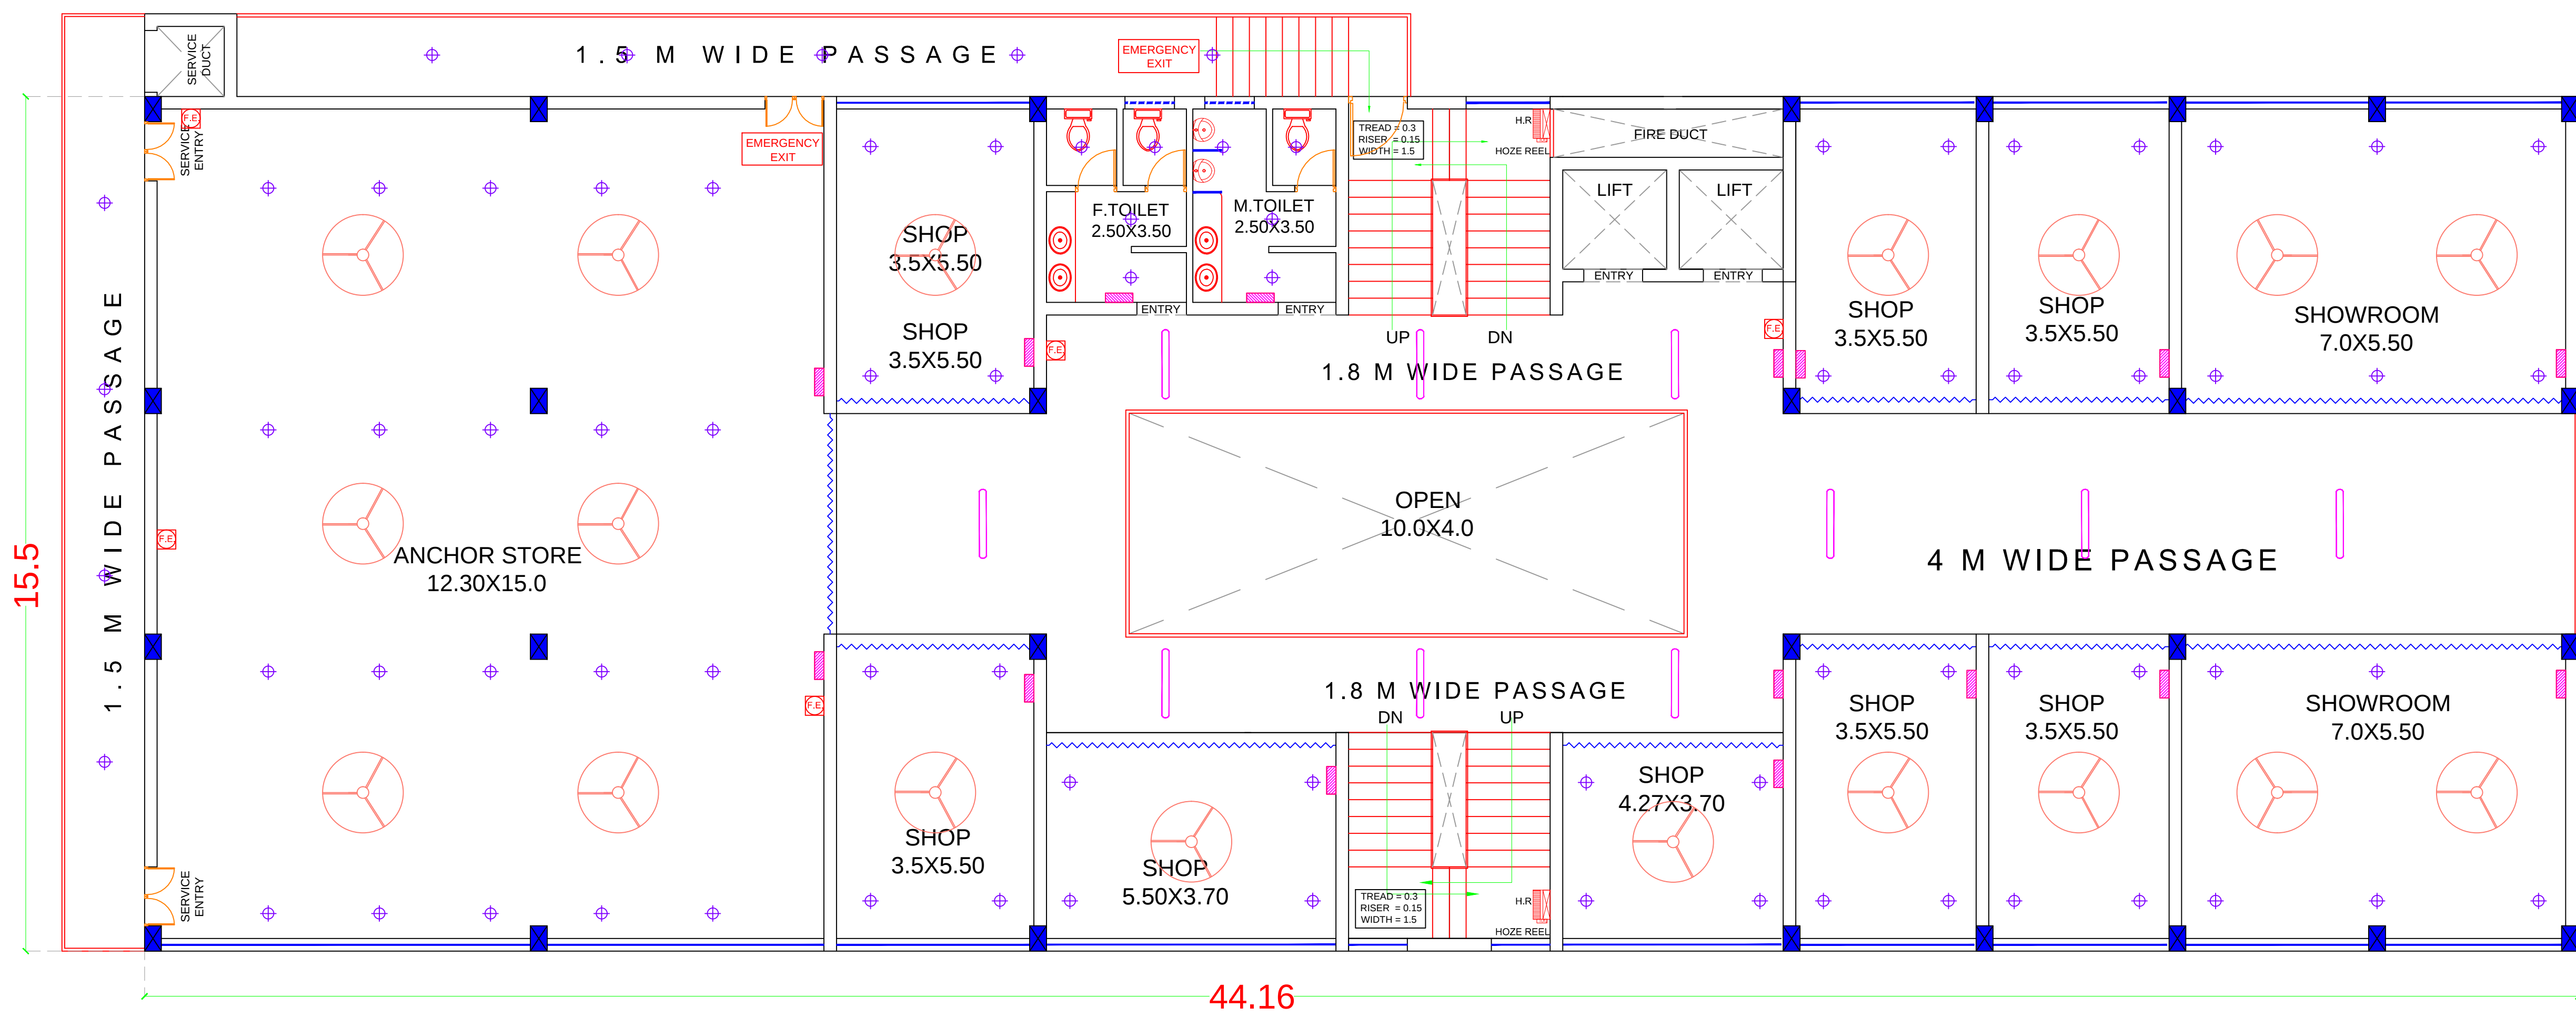

SECOND FLOOR PLAN

FIRST & SECOND FLOOR PLAN

LEGEND

S.N	SYMBOLS	DESCRIPTION
1		CEILING LIGHT
2		TUBE LIGHT
3		CHANDLER
4		CEILING FAN
5		SWITCH BOARD


PROPOSED COMMERCIAL BUILDING
ASHOK TRADE CENTRE FOR ASHOK
INFRA PROPERTIES PVT. LTD.
ARAJI No. 99/4 AND ARAJI No.
107 MOJA MERY AT KANPUR - GWALIOR
HIGHWAY, TEHSIL JHANSI

AUTH. SIGN.:-
SH. ROHIT GIRI


ARCHITECT AUTH. SIGN.




ANUPAM NAYAK

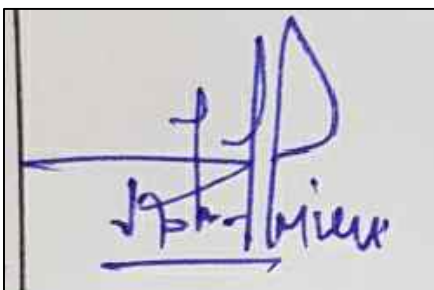

THIRD , FOURTH & FIFTH FLOOR PLAN

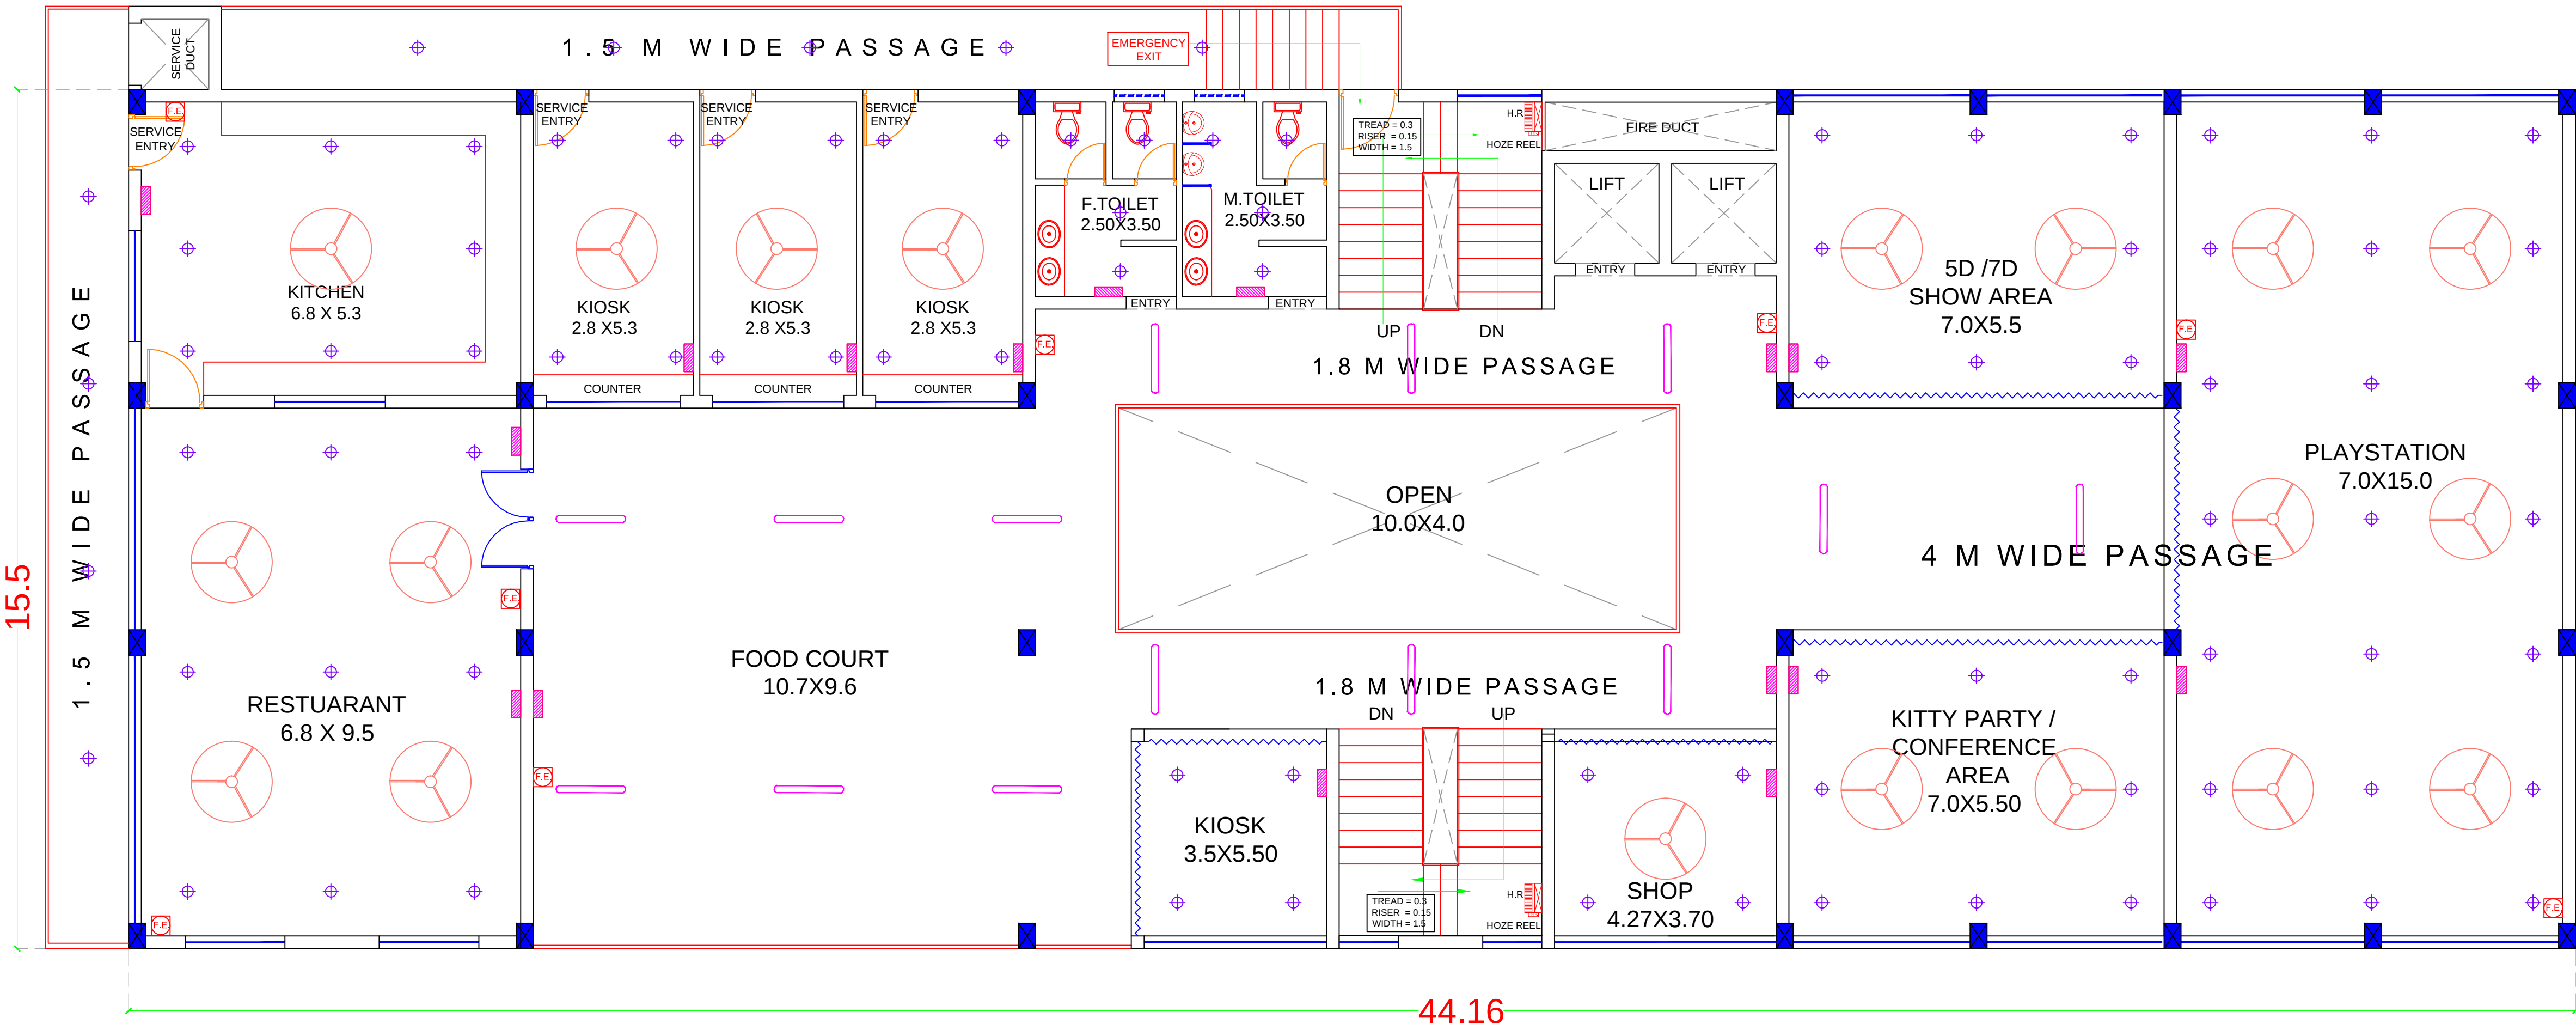

THIRD FLOOR PLAN

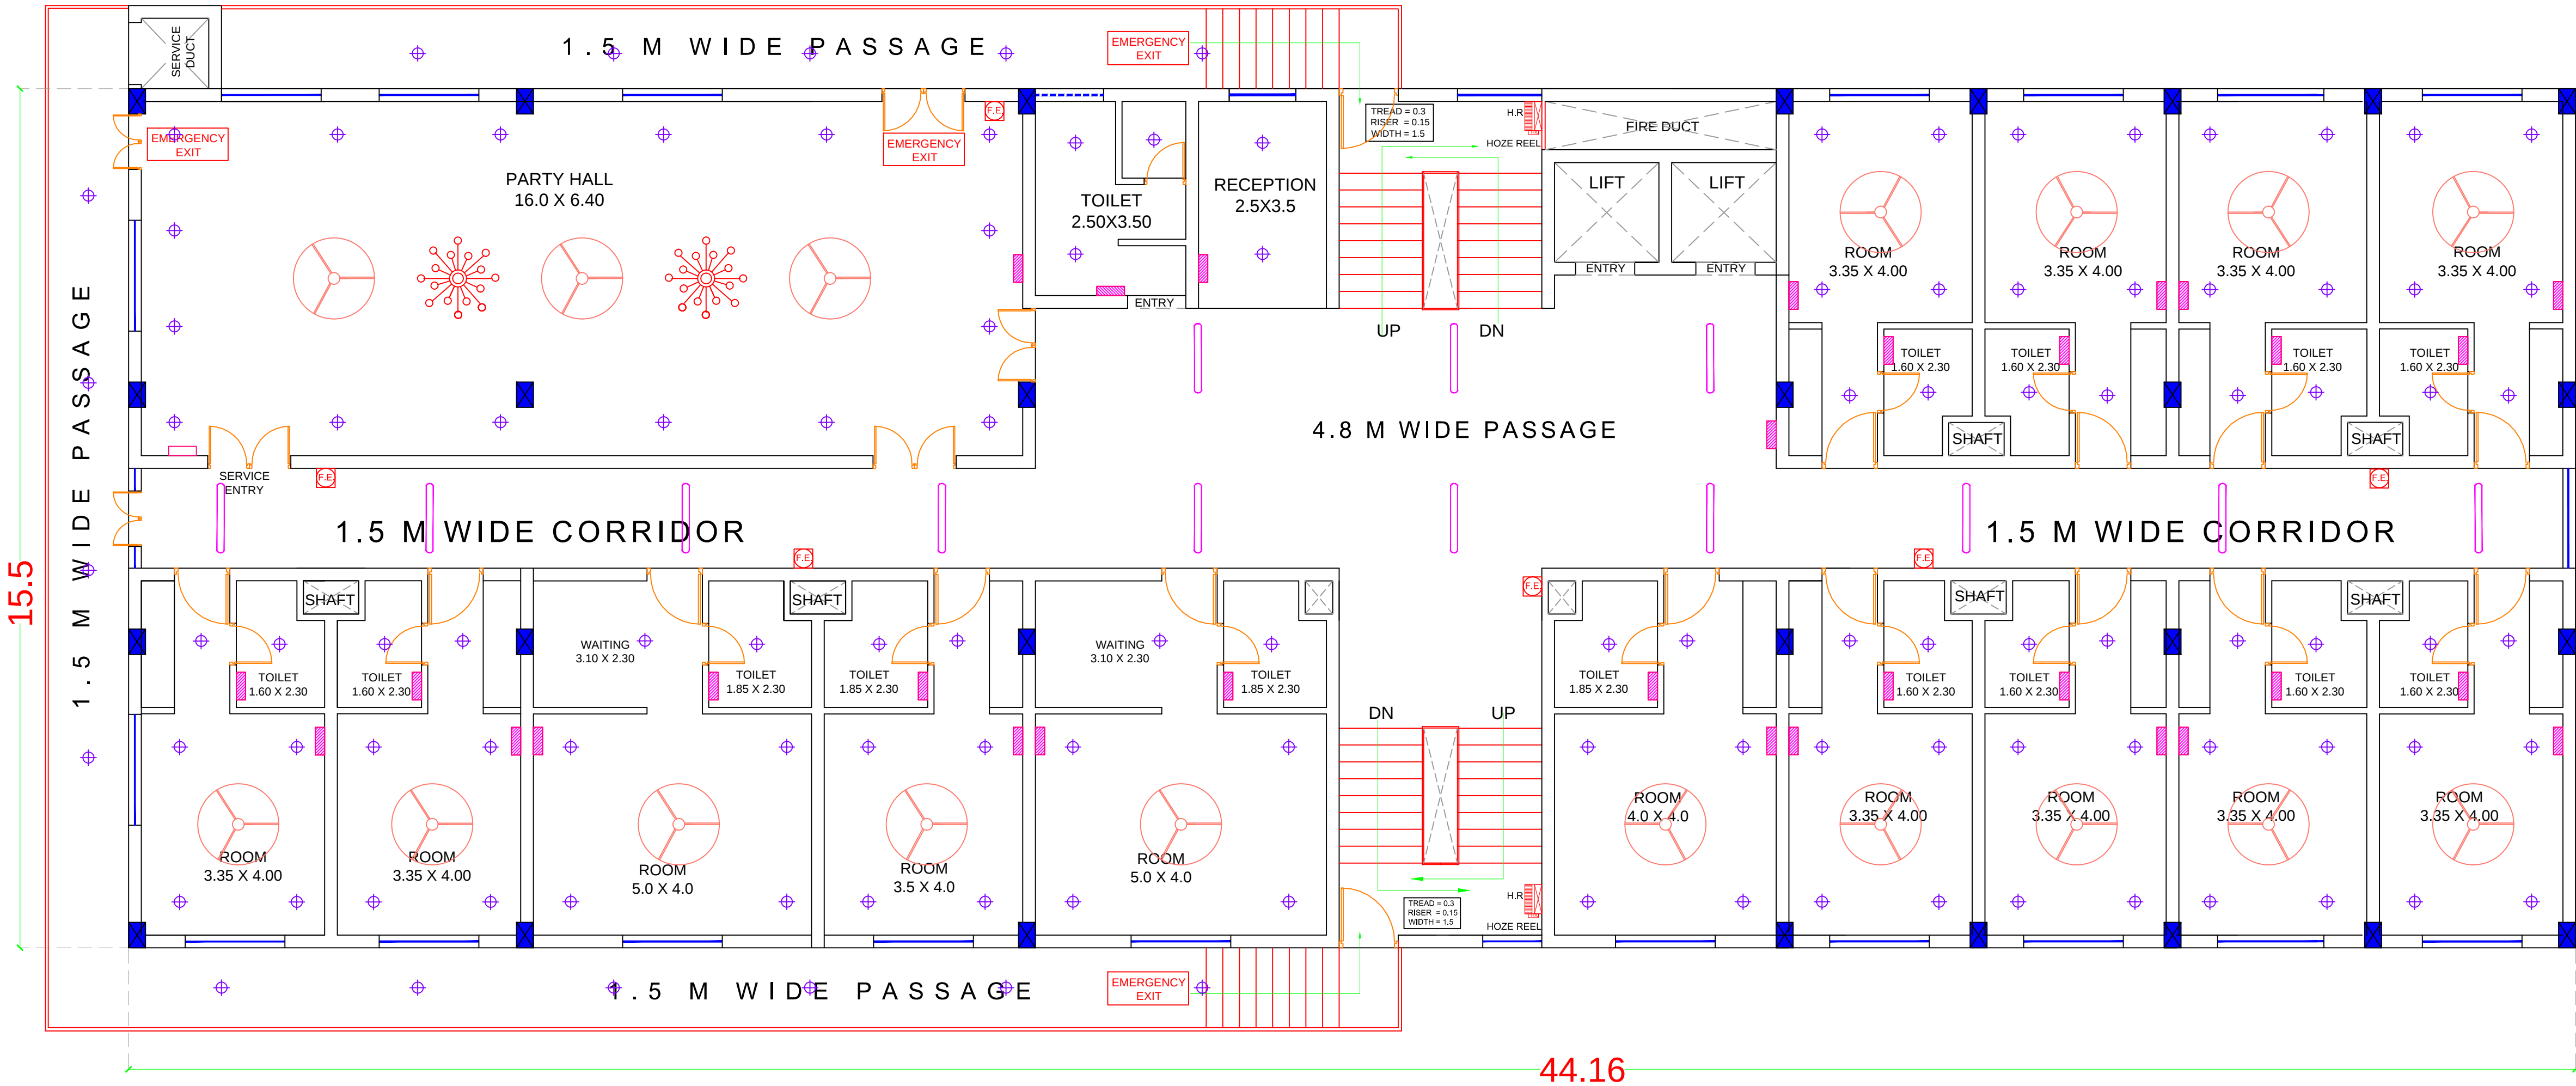

FOURTH & FIFTH FLOOR PLAN

LEGEND		
S.N	SYMBOLS	DESCRIPTION
1		CEILING LIGHT
2		TUBE LIGHT
3		CHANDLER
4		CEILING FAN
5		SWITCH BOARD

PROPOSED COMMERCIAL BUILDING
ASHOK TRADE CENTRE FOR ASHOK
INFRA PROPERTIES PVT. LTD.
ARAJI No. 99/4 AND ARAJI No.
107 MOJA MERY AT KANPUR - GWALIOR
HIGHWAY, TEHSIL JHANSI
AUTH. SIGN.:-
SH. ROHIT GIRI


ARCHITECT

ARCHITECT


ANUPAM NAYAK

AUTH. SIGN.

AUTH. SIGN.

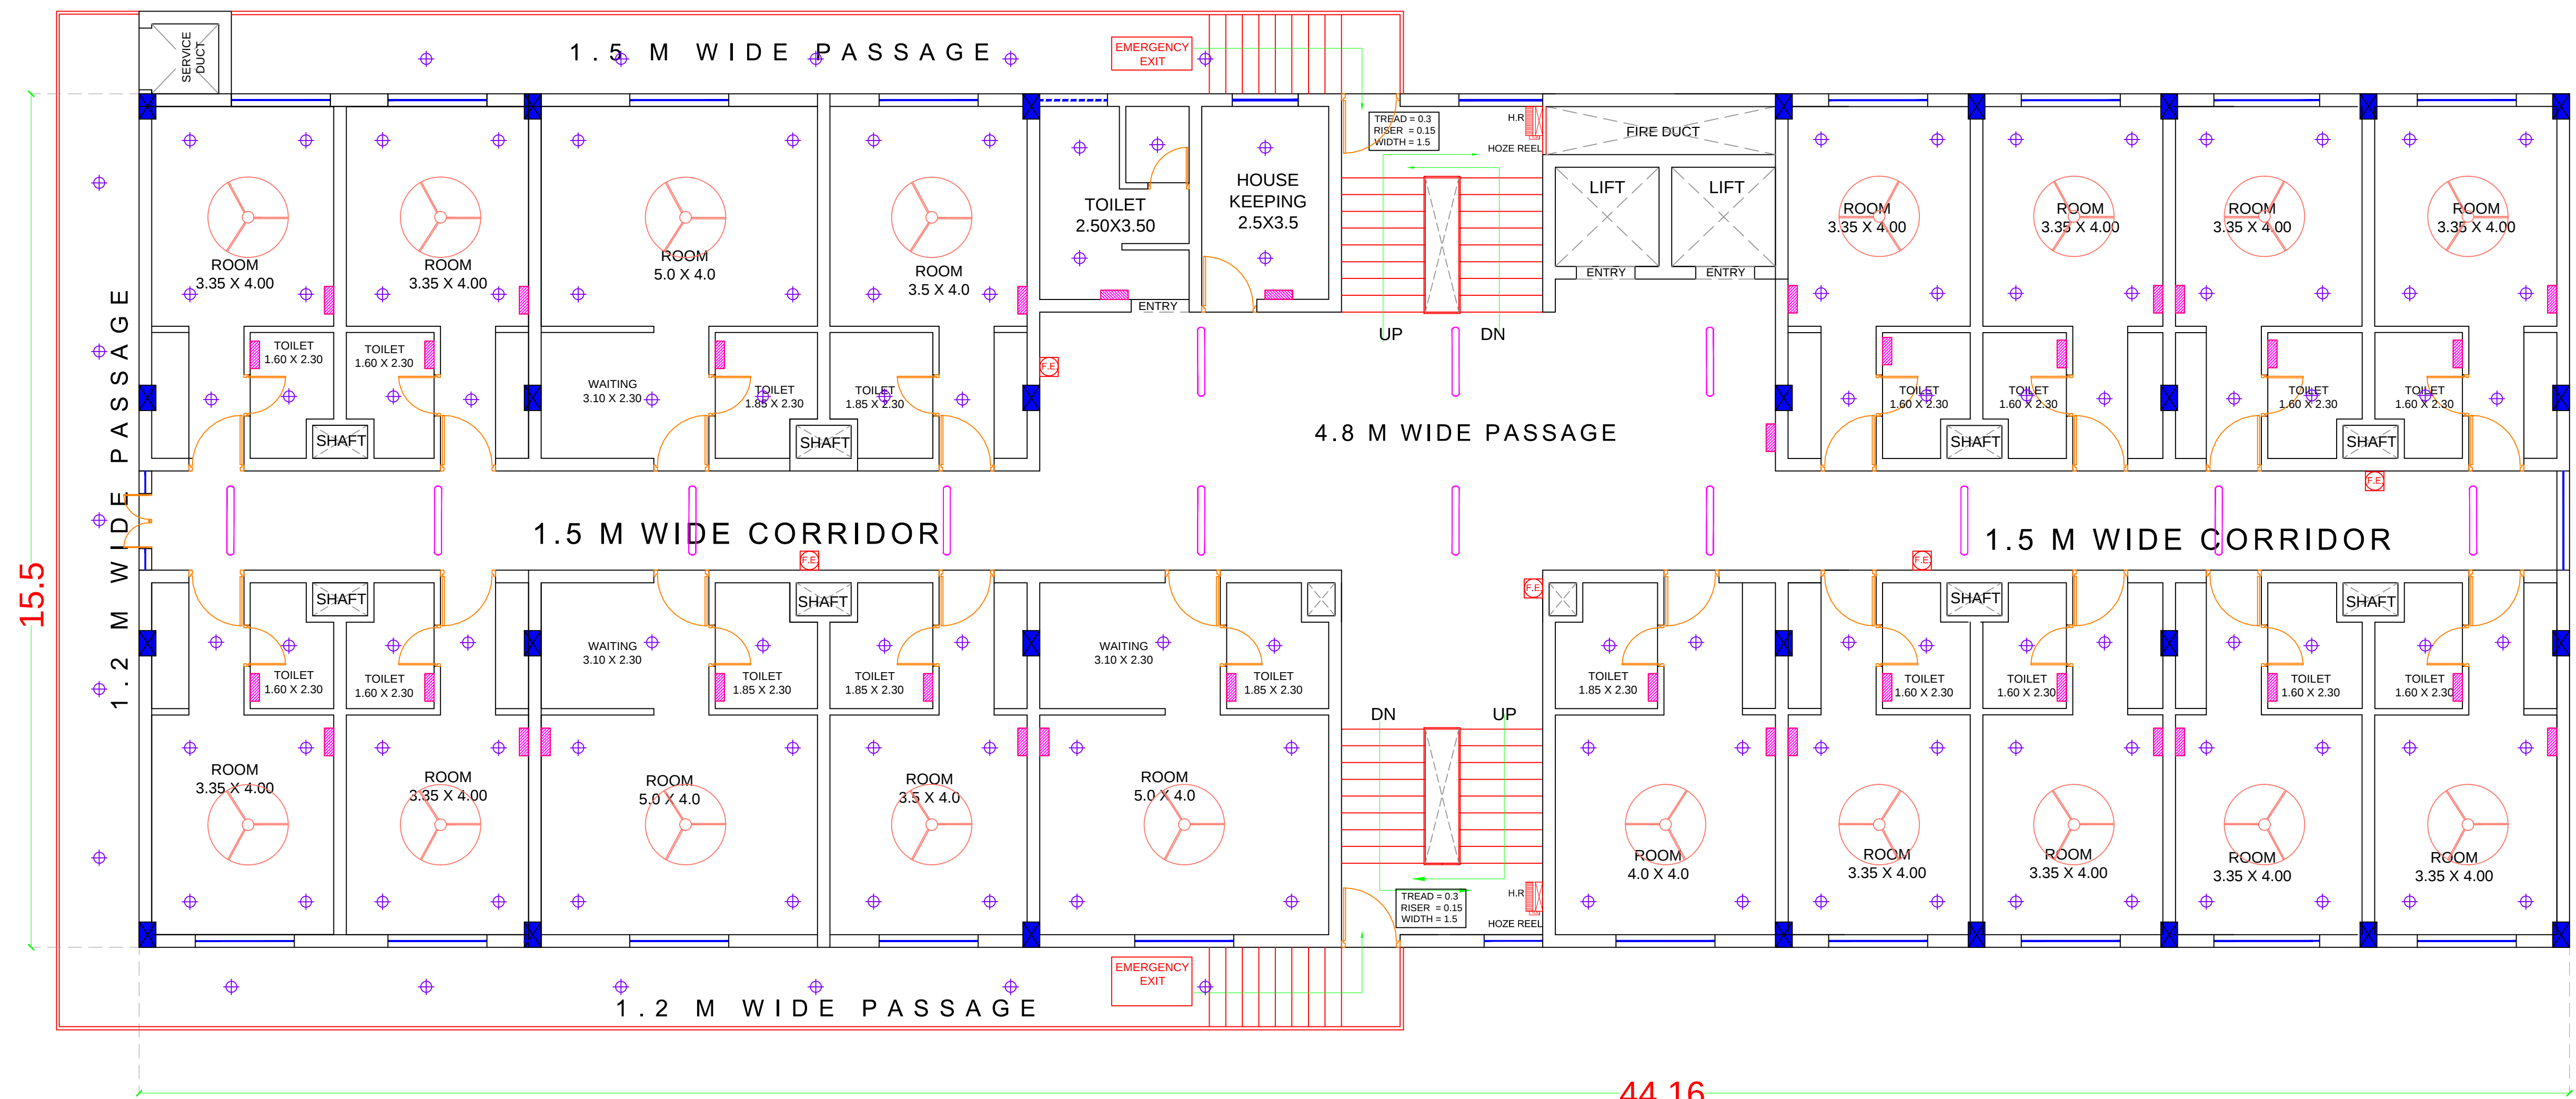

SIXTH FLOOR PLAN

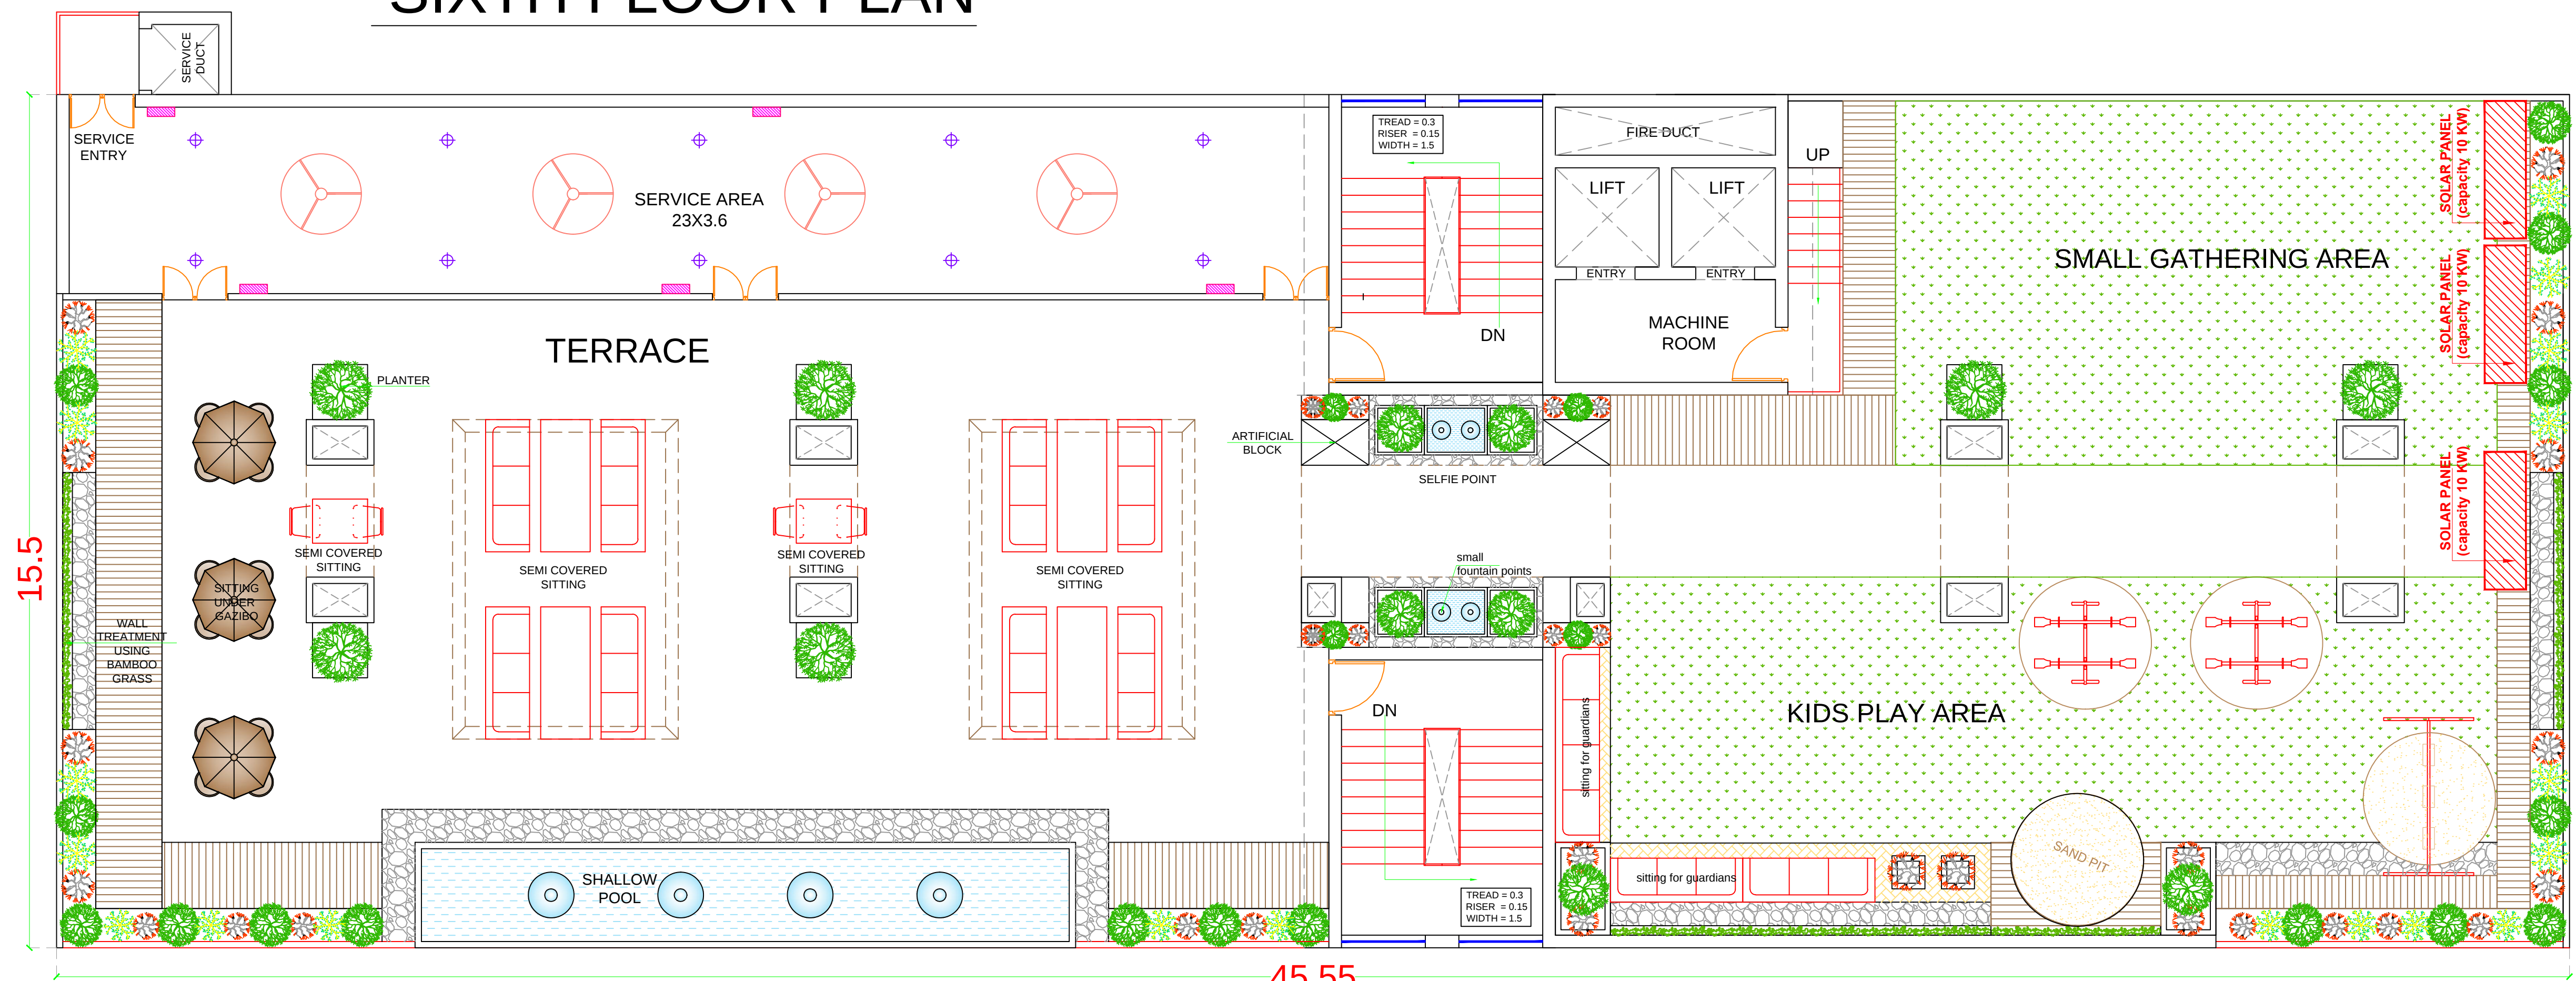

TERRACE PLAN

SIXTH FLOOR & TERRACE PLAN

LEGEND

S.N	SYMBOLS	DESCRIPTION
1		CEILING LIGHT
2		TUBE LIGHT
3		CHANDLER
4		CEILING FAN
5		SWITCH BOARD

PROPOSED COMMERCIAL BUILDING
ASHOK TRADE CENTRE FOR ASHOK
INFRA PROPERTIES PVT. LTD.
ARAJI No. 99/4 AND ARAJI No.
107 MOJA MERY AT KANPUR - GWALIOR
HIGHWAY, TEHSIL JHANSI

AUTH. SIGN.:-
SH. ROHIT GIRI

ARCHITECT

AUTH. SIGN.

ANUPAM NAYAK