



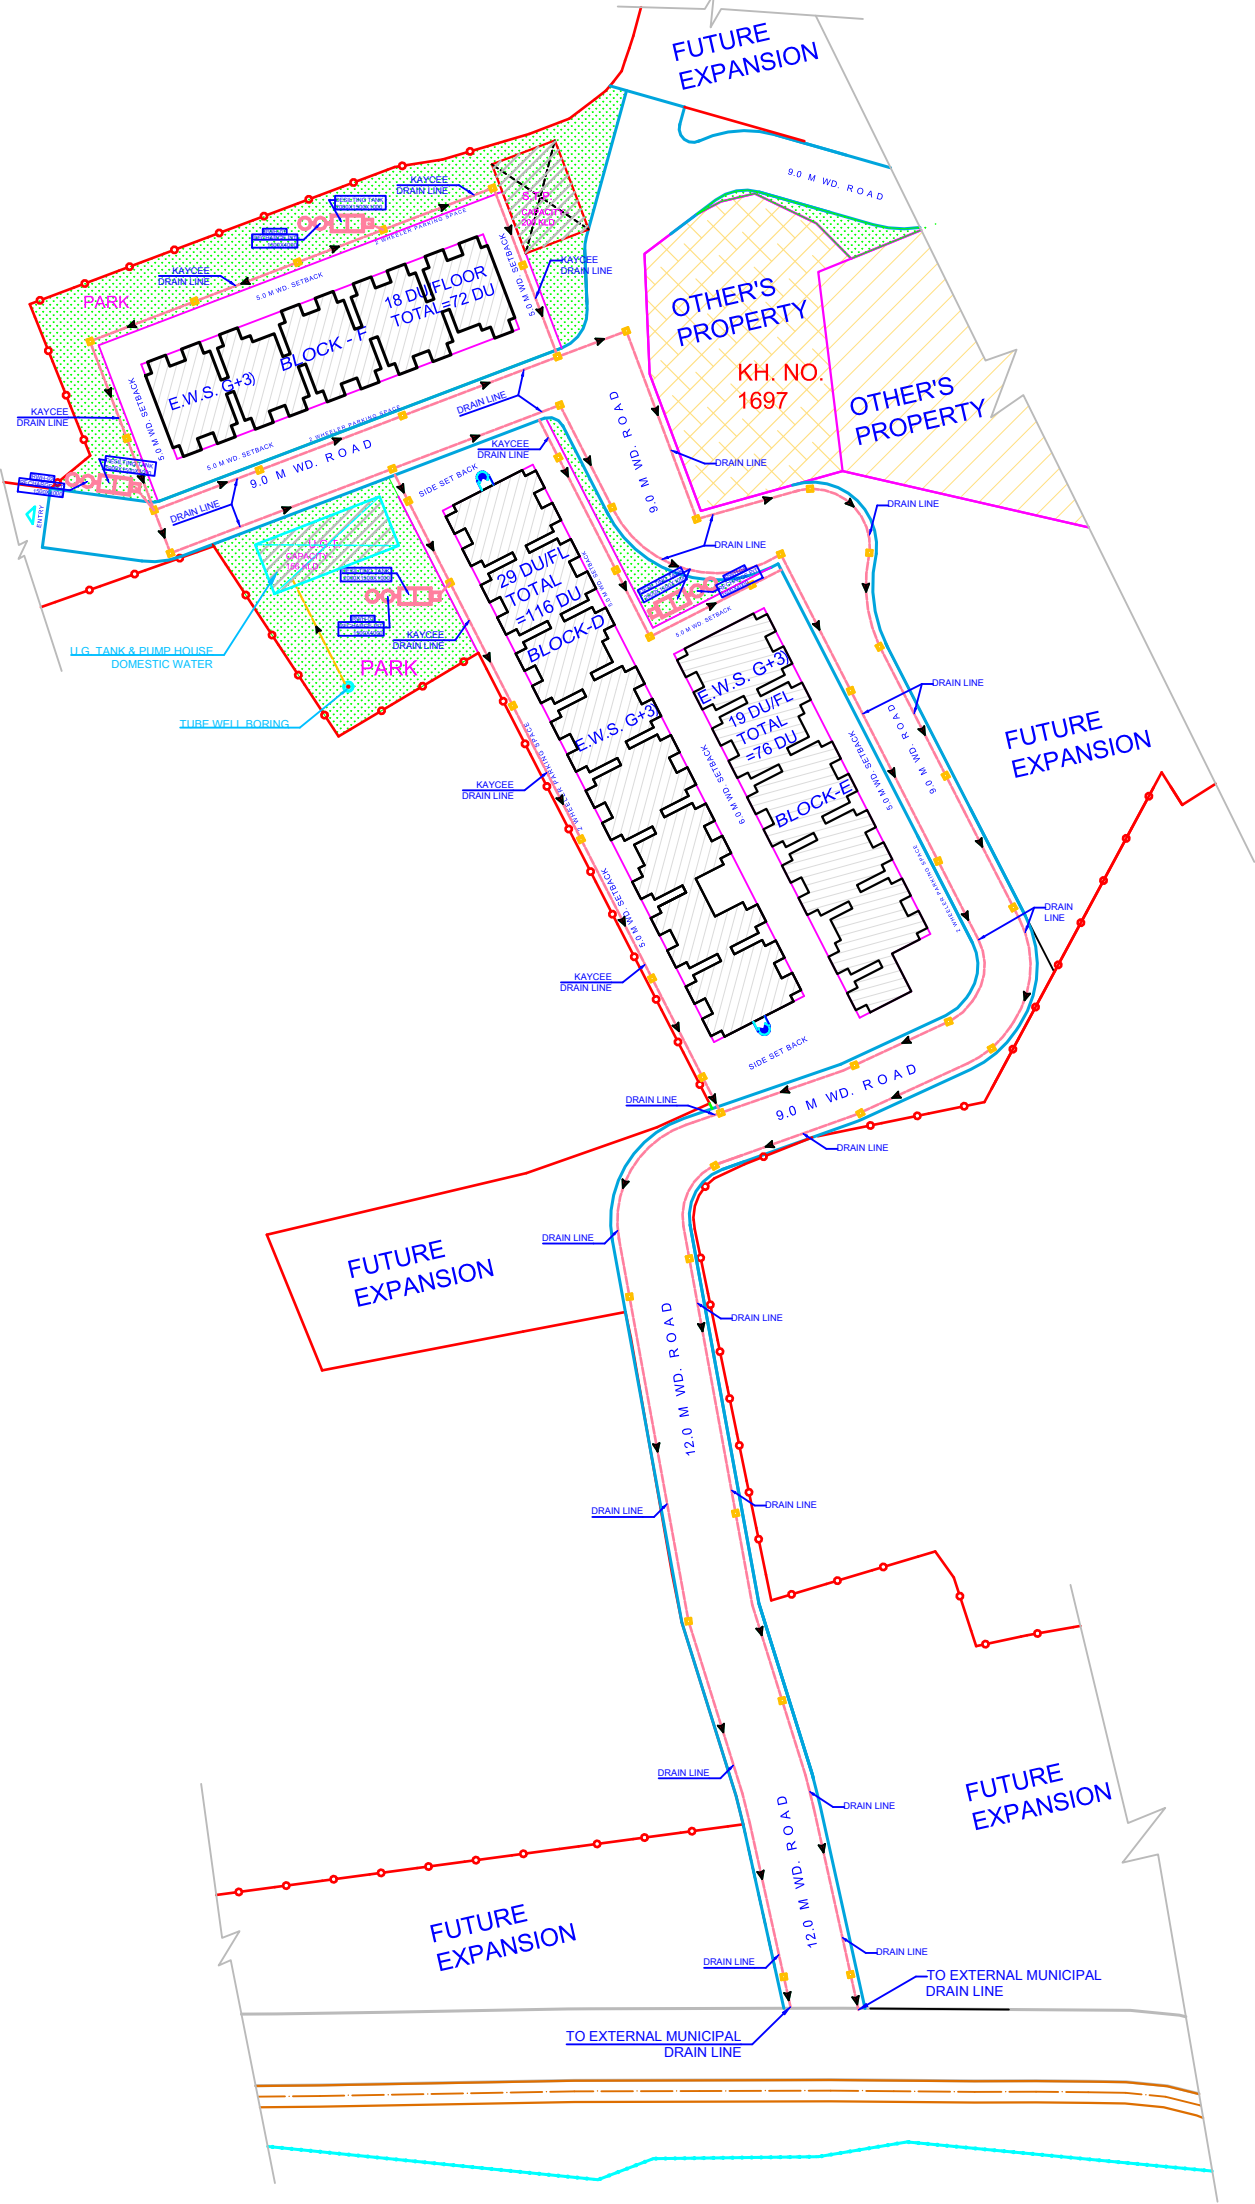

LEGEND:		
S.NO.	SYMBOL	DESCRIPTION
1.		CATCH PIT
2.		UNDERGROUND DRAIN PIPE
3.		RAIN WATER HARVESTING

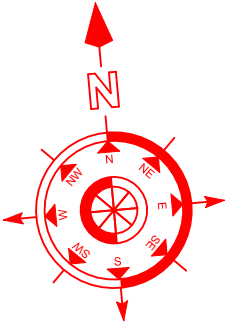

PROJECT TITLE:
PRADHAN MANTRI AWAS YOJNA (URBAN) AT KHASRA NO.1672,1689, 1691,1696 ON VILLAGE PARA LUCKNOW

LAND AREA---
12788 SQM

DRG. TITLE:
SUBMISSION PLAN

SHEET TITLE:
DRAINAGE PLAN

DRWN BY :

DATE :

CHKD BY :

APPVD. BY :

ISSUED BY :

CLIENT:

NAGAR NIGAM
LUCKNOW

ARCHITECT:


DESIGNED BY

Ar. Vivek Sharma

91-9451080969

Project Managment Consultant

D-1/329 Sec.-F JankiPuram Lucknow-226021
Email - konceptmdn@gmail.com, viveksharmamd@gmail.com

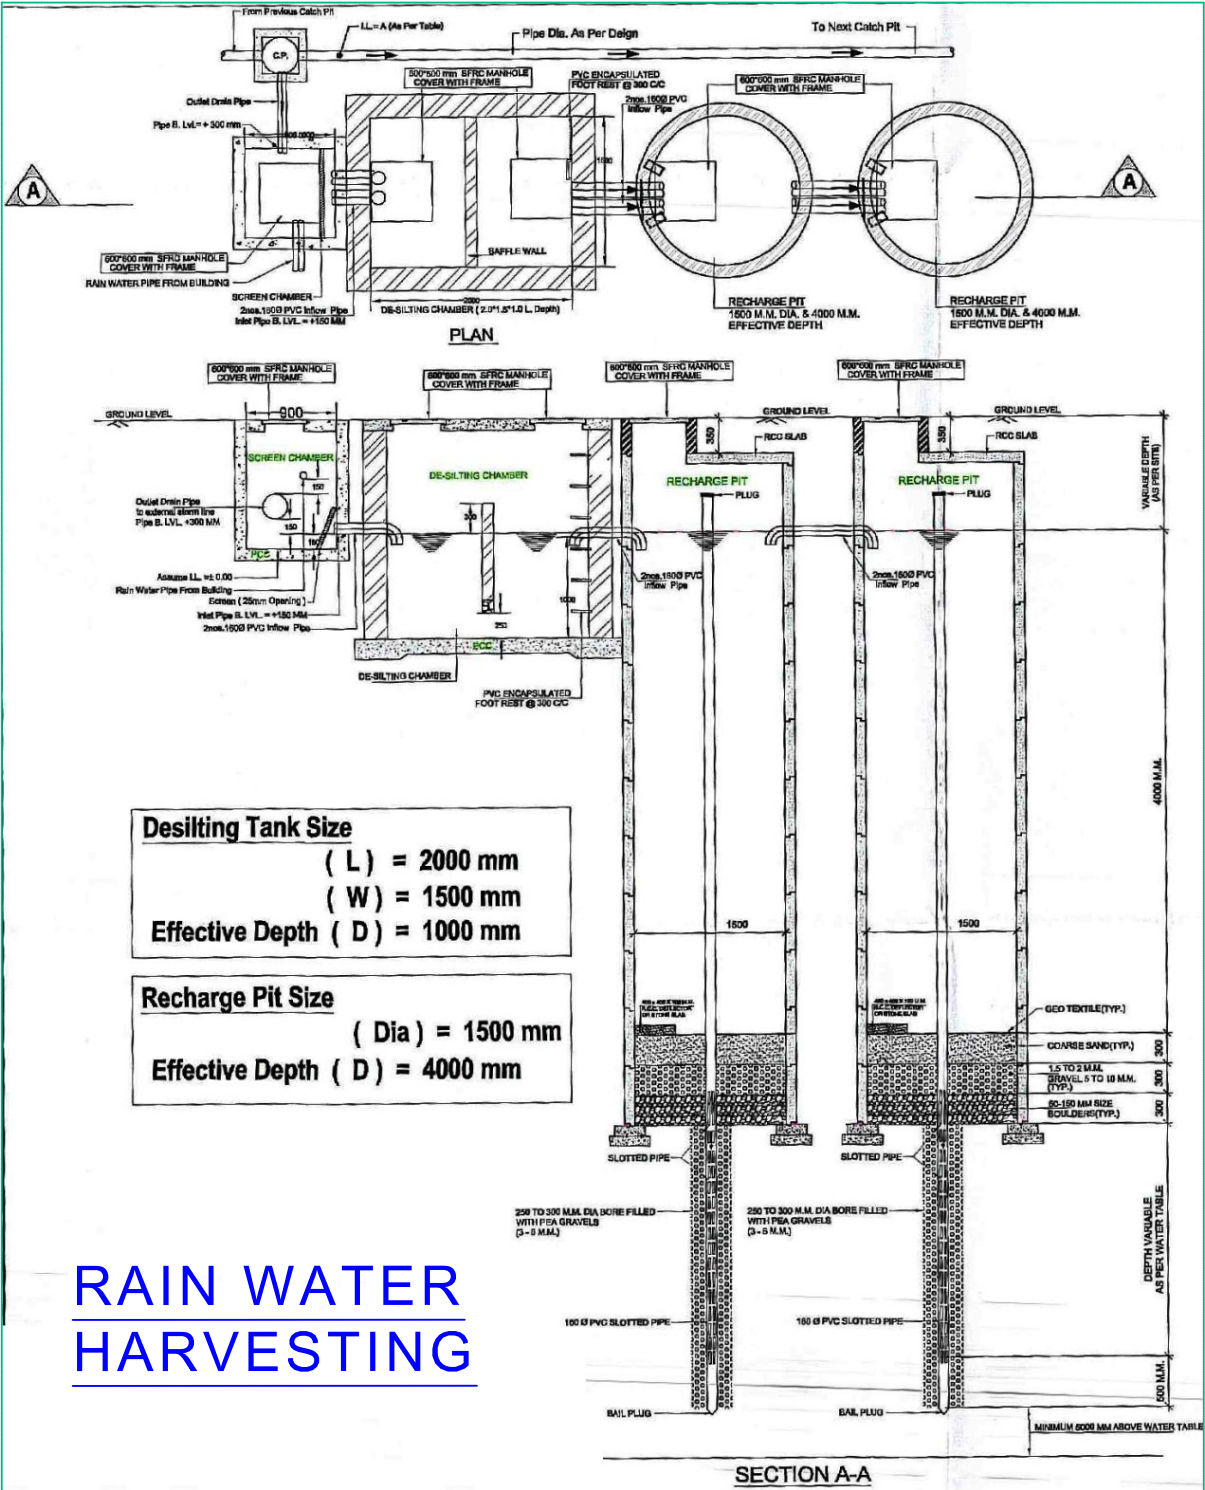

DRAINAGE PLAN