

NOTE:

1. ALL DIMENSIONS ARE IN FEET & INCHES, UNLESS SPECIFIED OTHERWISE.
2. INCASE OF ANY DISCREPANCY, IMMEDIATELY CONSULT THE ARCHITECT.
3. ONLY WRITTEN DIMENSIONS ARE TO BE FOLLOWED.PLEASE DO NOT SCALE THE DRAWING


1. This part of the brief is a summary of the decisions made regarding the interior design and construction of the nalanda heights-group housing at agra.
2. All internal walls are constructed of 8" & 4" thick concrete block with 10 mm cement plaster finish on both sides. wall thickness may vary deending on the height of the wall.
3. All masonry walls to be finished with cement shall be smooth and able to accept and retain appropriate paint finish.
4. Floor finish refer finishes schedule.
5. Interior paint colors and finishes refer finishes schedule.
6. Toilet plumbing fixtures and accessory types and model to be as per approved. install per local building code. refer to plans for location.

CLIENT.:
VARAHI BUILDERS PVT. LTD.


DRAWING NO.:
AR-01

DATE
17-01-2011

THIS DRAWING IS THE PROPERTY AND COPYRIGHT OF
A.K.PATHAK & ASSOCIATE. IT SHALL NOT BE COPIED,
REPRODUCED OR USED WITHOUT THE WRITTEN CONSENT
OF A.K.PATHAK & ASSOCIATE.

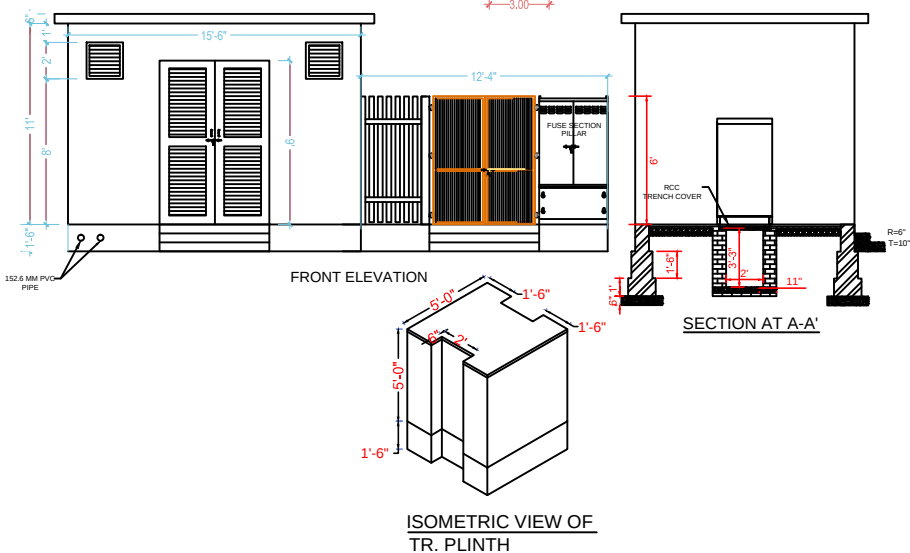

ELECTRICAL LAYOUT, TYPICAL FLOOR PLAN- 1ST TO 8TH FLOOR, VARAHI APARTMENTS, AGRA

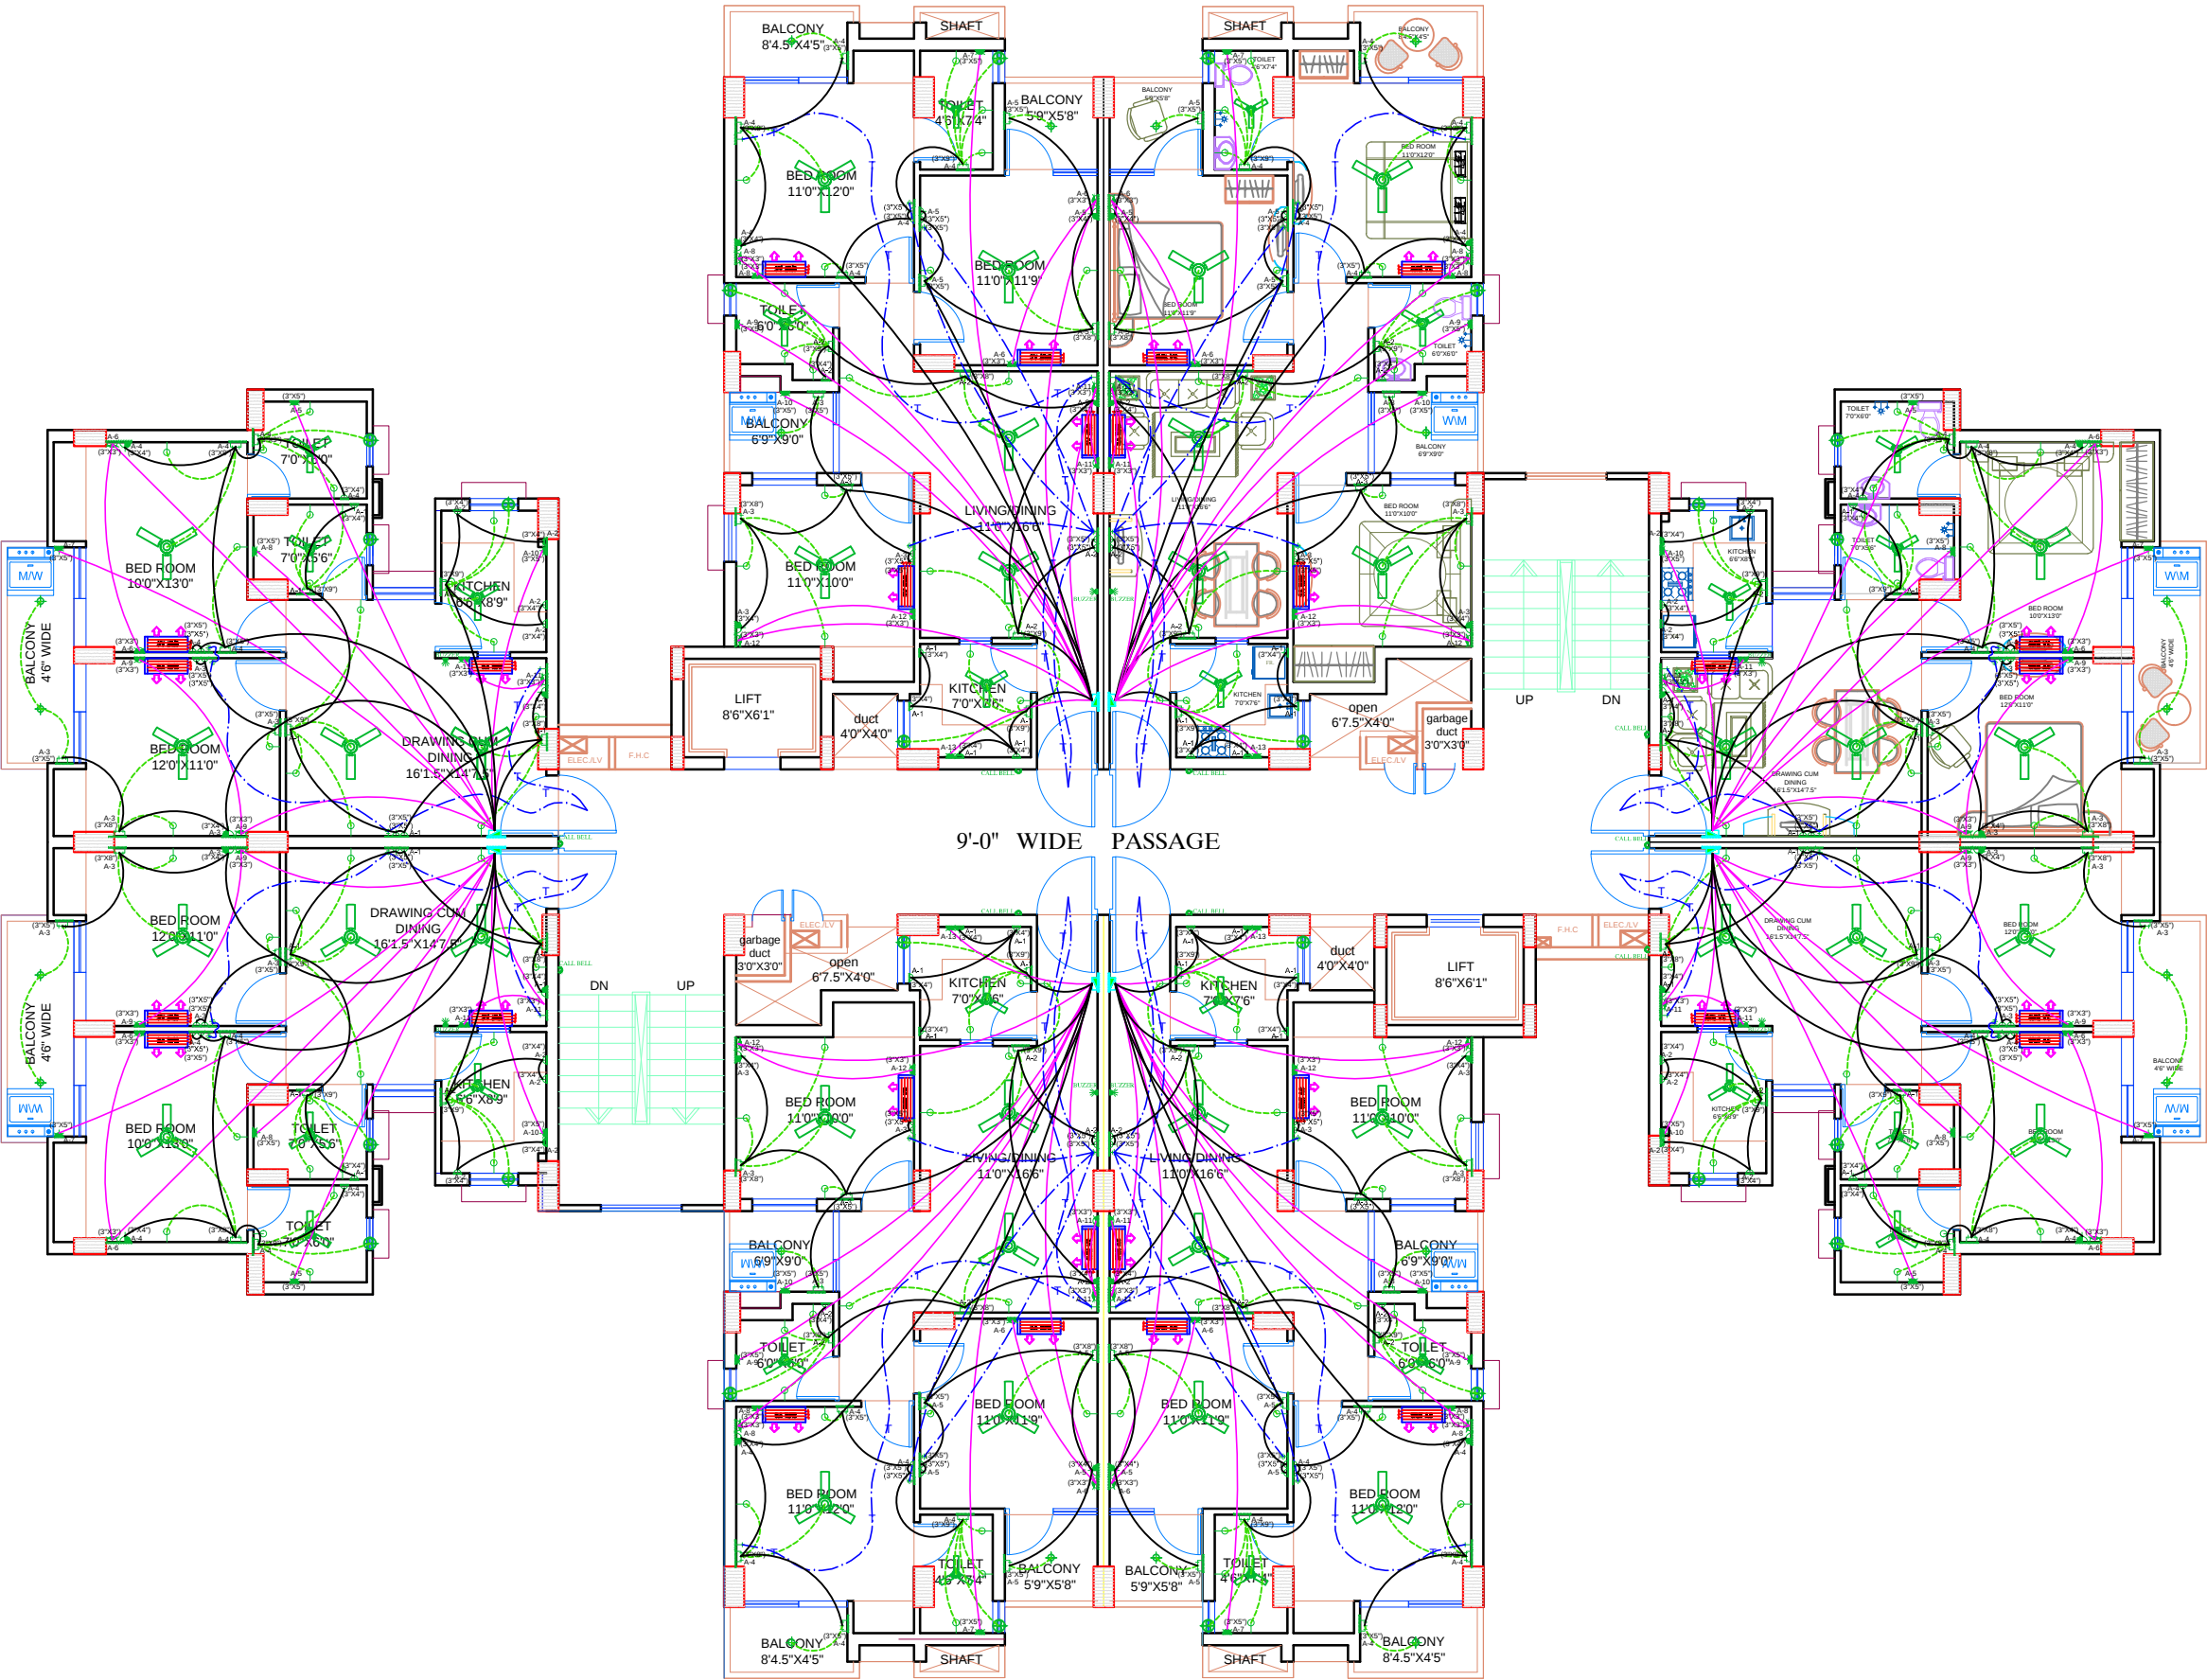

LEGEND : (Electrical System)			
S. No.	SYMBOL	DESCRIPTION	POSITION
1.		LIGHT POINT/ WALL BRACKET	2250
2.		CEILING LIGHT (SURFACE)	
3.		CORRIDOR /STAIR CASE LED LIGHT	
4.		CHANDLIER	
5.		CEILING FAN	
6.		EXHAUST FAN / CEILING ROSE	2000
7.		SWITCH BOARD/ SWITCH BOARD (BEDSIDE)	1200 / 550
8.		6 AMP SWITCH & SOCKET (BED SIDE)	550
9.		2 NOS. 6 AMP SOCKET CONTROLLED BY 1 NO. SWITCH (FOR T.V.)	900
10.		T.V. ANTENNA POINT	900
11.		TELEPHONE POINT (BED SIDE)	550
12.		6 AMP SWITCH & SOCKET (FOR REFRIGERATOR)	1050
13.		6 AMP SWITCH & SOCKET (FOR RO)	1650
14.		6 AMP SOCKET OUTLET (FOR CHIMNEY) (SWITCH WILL BE WITH JUICER BOARD)	2150
15.		6 AMP SWITCH SOCKET (FOR JUICER/MIXER) & SOCKET FOR CHIMNEY	1050
16.		6/16 AMP SWITCH & SOCKET (FOR MICROWAVE/ WASHING MACHINE)	1050
17.		LIGHT POINT/ WALL BRACKET (TOILET)	2150
18.		MIRROR LIGHT	2000
19.		16 AMP SWITCH & SOCKET (FOR TOL. GEYSER)	1550 / OR AS SPECIFIED
20.		16 AMP. SOCKET FOR A/C UNIT	2250
21.		16 AMP. SWITCH FOR A/C UNIT	550
22.		CALL BELL PUSH	1050
23.		BUZZER	2250
24.		DISTRIBUTION BOARD (TOP LEVEL)	2100
25.		INDICATES CONTROLLING OF LIGHT/FAN FROM SWITCH BOARD	
26.		INDICATES CONTROLLING OF POWER CIRCUIT FROM DB BOARD	
27.		INDICATES CONTROLLING OF SWITCH BOARD CIRCUIT FROM DB BOARD	
28.		INDICATIVE CONDUIT RUN FOR T.V. SYSTEM	
29.		INDICATIVE CONDUIT RUN FOR TELEPHONE SYSTEM	

Revision Notes:

Rev. No.	Date	Description

Sheet No.: 1

Drawn By: Er. SAMBHAV JAIN

Checked By: Er. ANIL K. GOYAL

DATE: 03.01.2018

Rev. No. (R0)

NORTH:

ELECTRICAL CONSULTANTS:

C. B. M. G.
ENGINEERS & CONSULTANTS
PVT. LIMITED
1, Ellora Complex, Khandari Crossing, Surya Nagar,
Agra-282002.
E- mail: ansh13579@gmail.com, anil@cemgindia.com

PROJECT:

VARAHI APARTMENTS, AGRA.

DRAWING TITLE:

1ST TO 8TH FLOOR ELECTRICAL
LAYOUT (TYPICAL FLOOR)