


- SPECIAL NOTES**
1. ALL DIMENSIONS ON THIS DRAWING ARE IN MM.
  2. ONLY WRITTEN DIMENSIONS ARE TO BE FOLLOWED. DRAWINGS SHOULD NOT BE SCALED UNDER ANY CIRCUMSTANCES.
  3. ALL MEASUREMENTS MUST BE CHECKED AND VERIFIED BY THE CONTRACTORS PRIOR TO EXECUTION OF WORK AT THE SITE.
  4. THIS DRAWING IS TO BE READ IN CONJUNCTION WITH ALL RELEVANT STRUCTURAL SERVICES & FACILITY PLANNING DRAWINGS.
  5. ARCHITECTURAL DRAWINGS ARE TO BE FOLLOWED FOR THE LOCATION OF ALL STRUCTURAL MEMBERS & MASONRY WALLS. FOR SIZES & REINFORCEMENT DETAILS OF STRUCTURAL MEMBERS RELEVANT STRUCTURAL DRAWINGS ARE TO BE REFERRED.
  6. ANY DISCREPANCIES BETWEEN ARCHITECTURAL, STRUCTURAL AND SERVICES DRAWINGS MUST BE BROUGHT TO THE NOTICE OF THE ARCHITECTS IMMEDIATELY & PRIOR TO EXECUTION AT SITE.
  7. CO-ORDINATION WITH THE SERVICES SUCH AS HVAC, PLUMBING & ELECTRICAL ETC. IS THE RESPONSIBILITY OF THE CONTRACTORS.
  8. ALL MASONRY WALLS SHOULD BE ALIGNED WITH THE COLUMNS AS INDICATED ON THE PLAN RESPECTIVE OF THE POSITION AS CALCULATED WITH THE DIMENSIONING.
  9. FOR DETAILS, REFER RELEVANT LARGE SCALE DETAIL DRGS. AS INDICATED.

MEP SERVICES LEGEND	
	SEWER MANHOLE WITH 600MM MANHOLE COVER
	CATCH BASIN 600 X 600
	STORM WATER MANHOLE WITH 600MM PERFORATED MANHOLE COVER
GH	GARDEN HYDRANT
	EXTERNAL FIRE HYDRANT (750x600x250) MM
	EXTERNAL SEWER LINE
	EXTERNAL STORM WATER LINE (DIA AS / DESIGN CHART)
	GARDEN IRRIGATION WATER SUPPLY LINE (DIA MENTION IN LAYOUT)
	EXTERNAL FIRE HYDRANT LINE (DIA MENTION IN LAYOUT)
	DOMESTIC WATER SUPPLY
	FLUSHING LINE WATER SUPPLY
	MUNICIPAL LINE WATER SUPPLY
	TUBE WELL WATER SUPPLY LINE
R.P.	RECHARGE PIT (2000 X 2000) MM
D.C.	DESILTING CHAMBER (1000 X 2000)MM

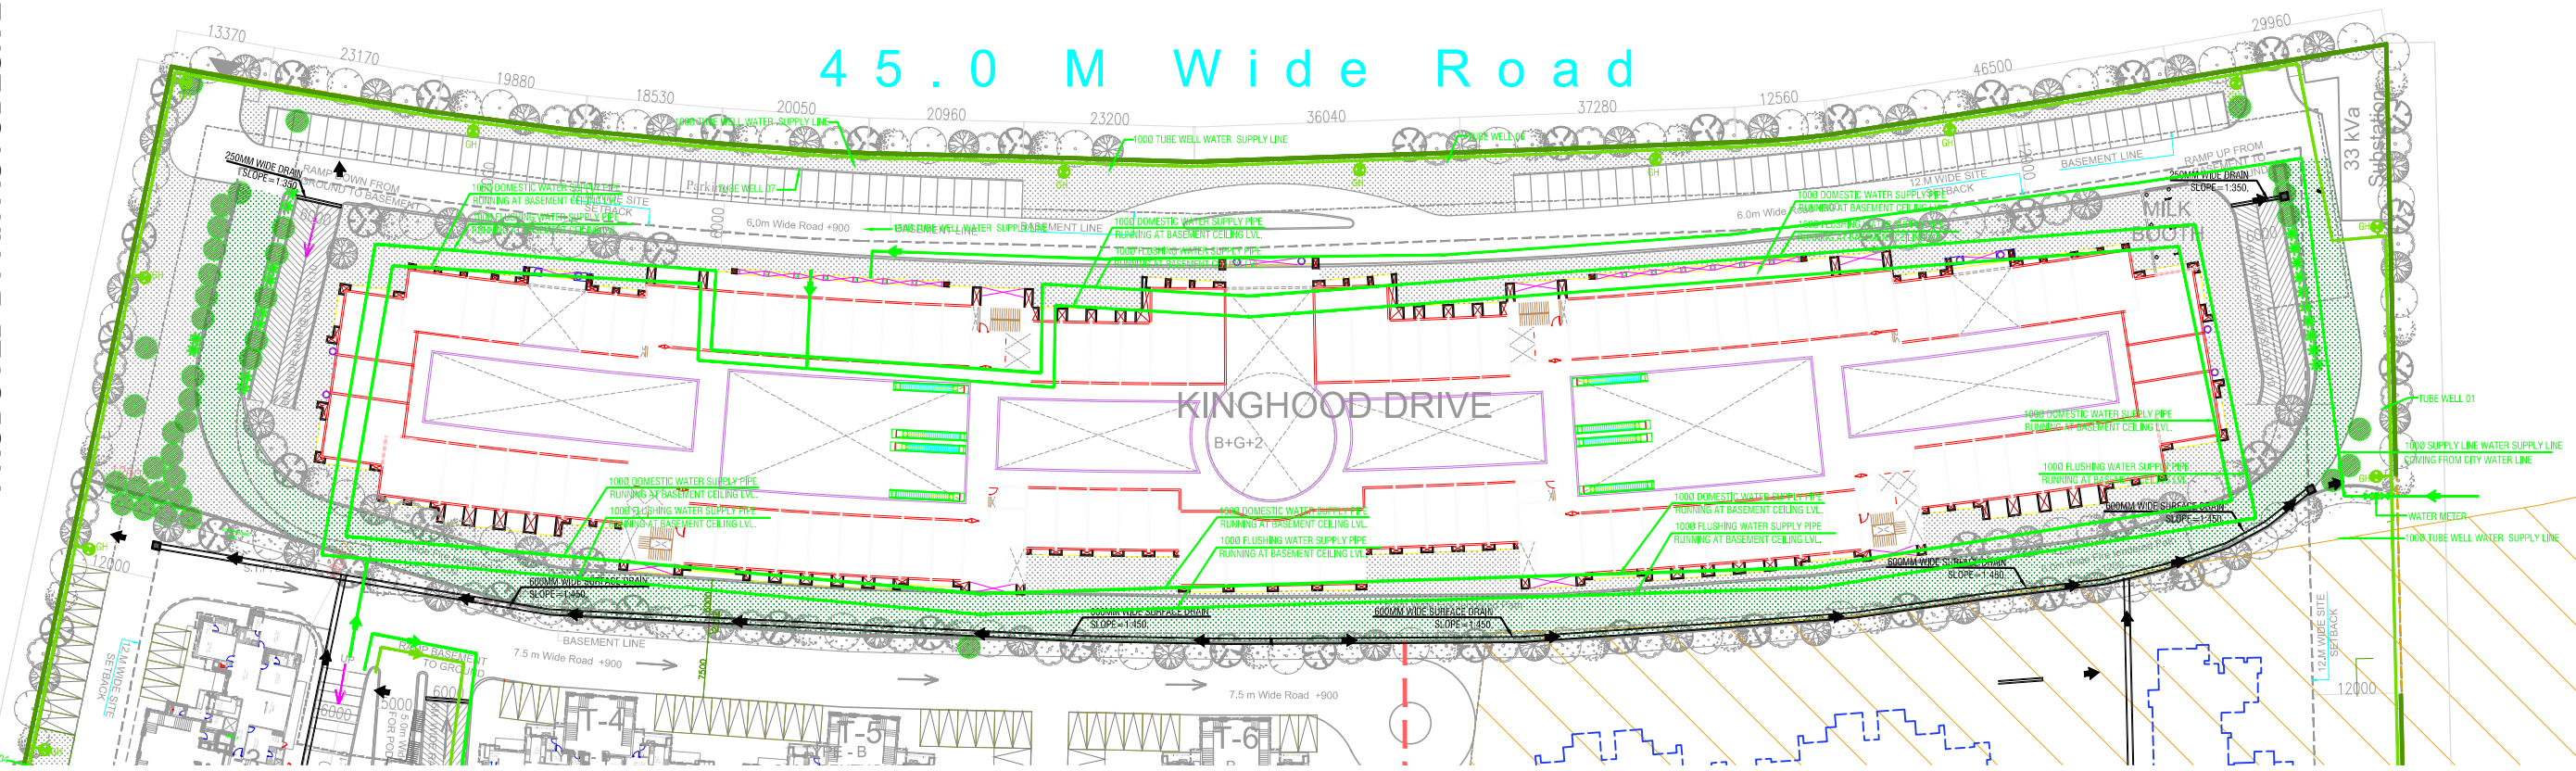

MEP Services Consultants:  
**PARADISE CONSULTANTS**  
Plot No. 103, Basement,  
Near Living Style Mall, Jasola Vihar  
LANDLINE+91-11-29943601,461332800,41030619  
New Delhi - 110025  
E-mail: paradiseconsultants@gmail.com  
website: www.paradiseconsultants.com

**EXTERNAL SITE PLAN  
WATER SUPPLY LAYOUT**

SCALE - 1:500@A0	DATE - 16.09.16	DRG NO.	
DRAWN BY T. SRAWAT	CHECKED BY ANL		