


NOTE- NO LOCATION GIVEN FOR T.V. CABINET SHIFT T.V. POINT IN GIVEN PROVISION

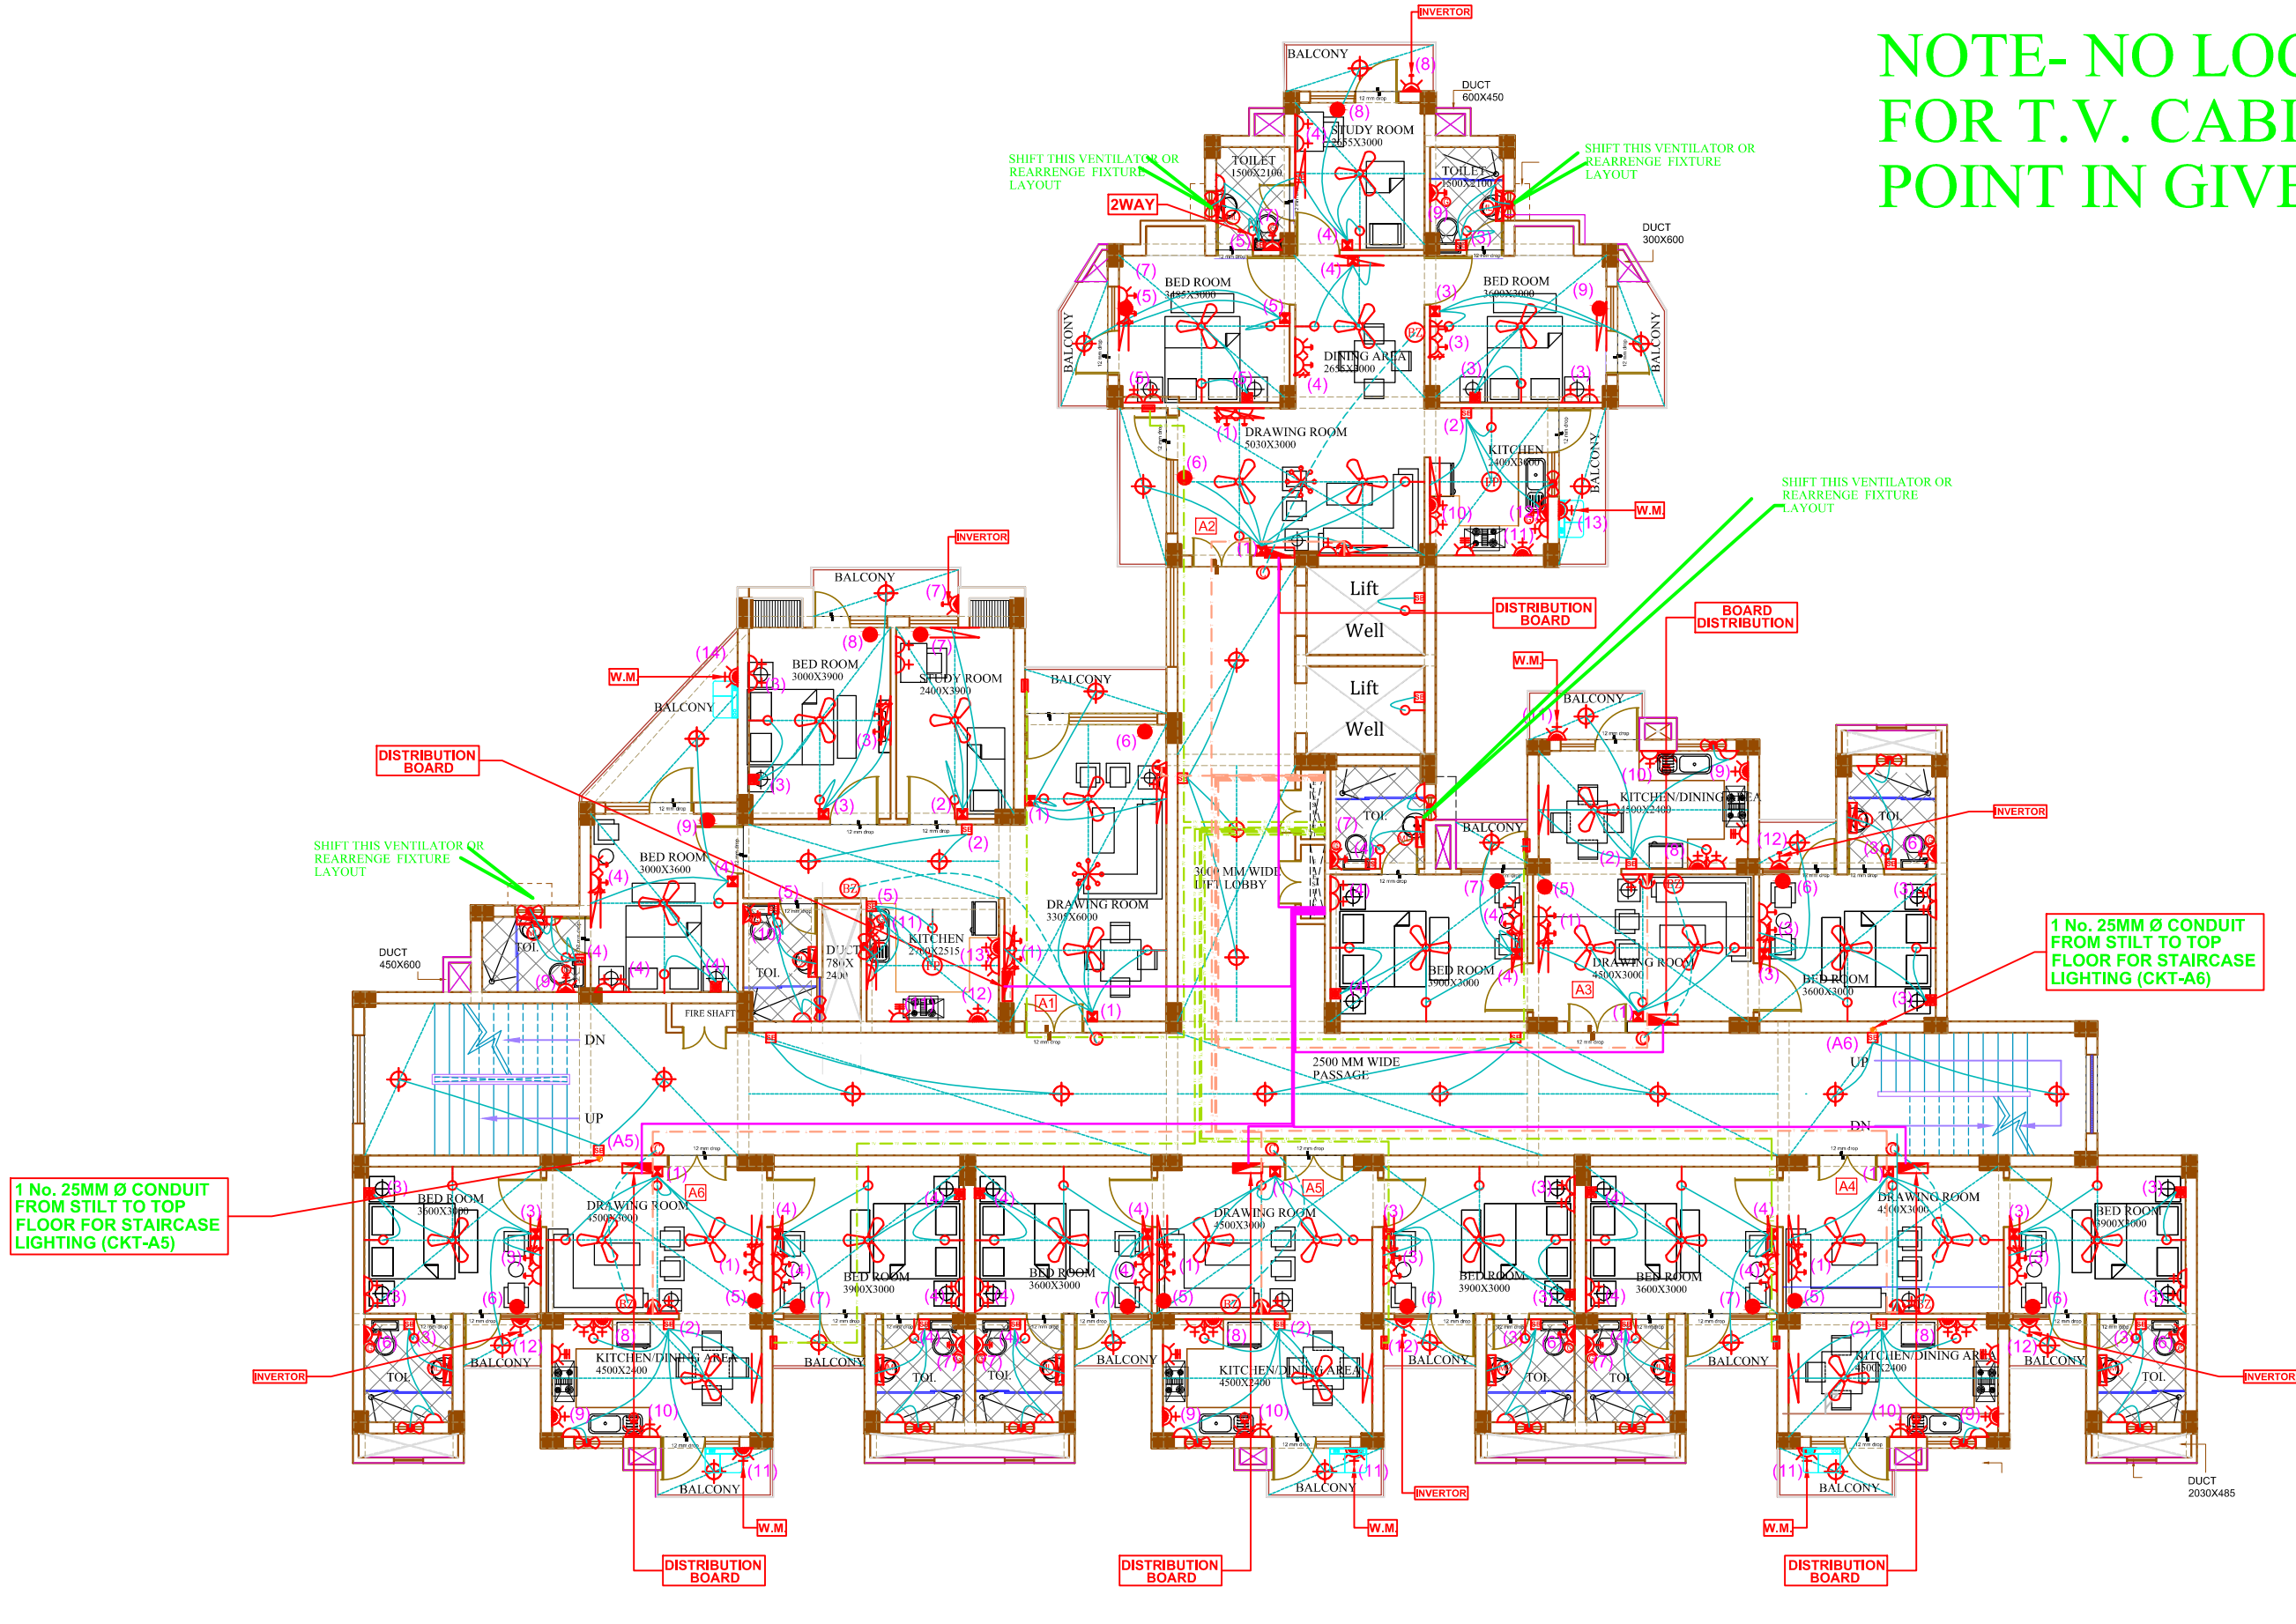

LEGEND:-ELECTRICAL

S.NO	SYMBOL	DESCRIPTION	POSITION
1		1x28 W T5 TUBE LIGHT FIXTURE(SURFACE)	2550
2		WALL MOUNTED LIGHT FIXTURE	2250
3		CEILING LIGHT	ON CEILING
4		MIRROR LIGHT	1950
5		SWITCH BOARD WITH 5A SWITCH & SOCKET	1200
6		SWITCH BOARD WITHOUT 5A SWITCH & SOCKET	1200
7		SWITCH BOARD WITH 5A SWITCH & SOCKET	550
8		5 -AMP PLUG POINT	300
9		5 -AMP PLUG POINT	100 or 500 ABOVE PLATFORM
10		5 -AMP PLUG POINT	900
11		5 -AMP PLUG POINT	550
12		5 -AMP PLUG POINT WITHOUT SWITCH	2250
13		5 -AMP PLUG POINT FOR CHIMNEY	1800
14		5/15 -AMP POWER POINT	300
15		15 AMP POWER SOCKET FOR GEYSER IN TOILET-SS-1650 & KITCHEN S-1850 & SWITCH WITH R.O. POINT AT 1100 MM	
16		5/15 -AMP POWER POINT	1100 or 500 ABOVE PLATFORM
17		5/15 -AMP POWER POINT	900
18		20/32 -AMP MCB (A.C. POINT)	450
19		CEILING FAN	ON CEILING
20		EXHAUST FAN	IN WIN/VEN.
21		TELEPHONE / INTERCOM SOCKET (SIDE TABLE)	550
22		CHANDLIER	ON CEILING
23		CALL BELL	1200
24		BUZZAR	2400
25		TELEVISION POINT	900
26		DISTRIBUTION BOARD	1800 (TOP OF D.B.)
27		SPITTER (CABLE T.V. HUB)	1650
28		INDICATES CONTROLLING OF LIGHT/FAN FROM SWITCH BOARD.	
29		250 TELEPHONE CONDUIT	
30		250 CABLE T.V. CONDUIT	
31		320 SUBMAIN CONDUIT FROM L.T. PANEL TO DISTRIBUTION BOARD	

PROJECT: PROPOSED GROUP HOUSING FOR LUCKNOW DEVELOPMENT AUTHORITY AT SHAHEED PATH.	CLIENT :- LUCKNOW DEVELOPMENT AUTHORITY	AREA STATEMENT:-	ARCHITECT :- SHUBHENDRA BAJPAI	ARCHITECTURAL CONSULTANTS :- ARCH DOT CREATION (LUCKNOW OFFICE):- 4/404,VIVEK KHAND, GOMTI NAGAR LUCKNOW. Ph.-4071522,9415021936. e-mail add.-adcreation1@yahoo.co.in (GHAZIABAD OFFICE):- 2160-2161 Romano Mahagun Mascot,Crossing Republic ,Ghazyabad. Ph. : 09871599836 e-mail add.-adcreation2@yahoo.co.in
DRG. TITLE:- ELECTRICAL	BUILDING :- TYPICAL FLOOR PLAN (1 TO 7th FLOOR) 'BLOCK -A'	DATE :- JULY -2015	DRG. NO. :- GH/BL-A/LKO/ELE-02	SCALE :- N.T.S.
NORTH :-				