


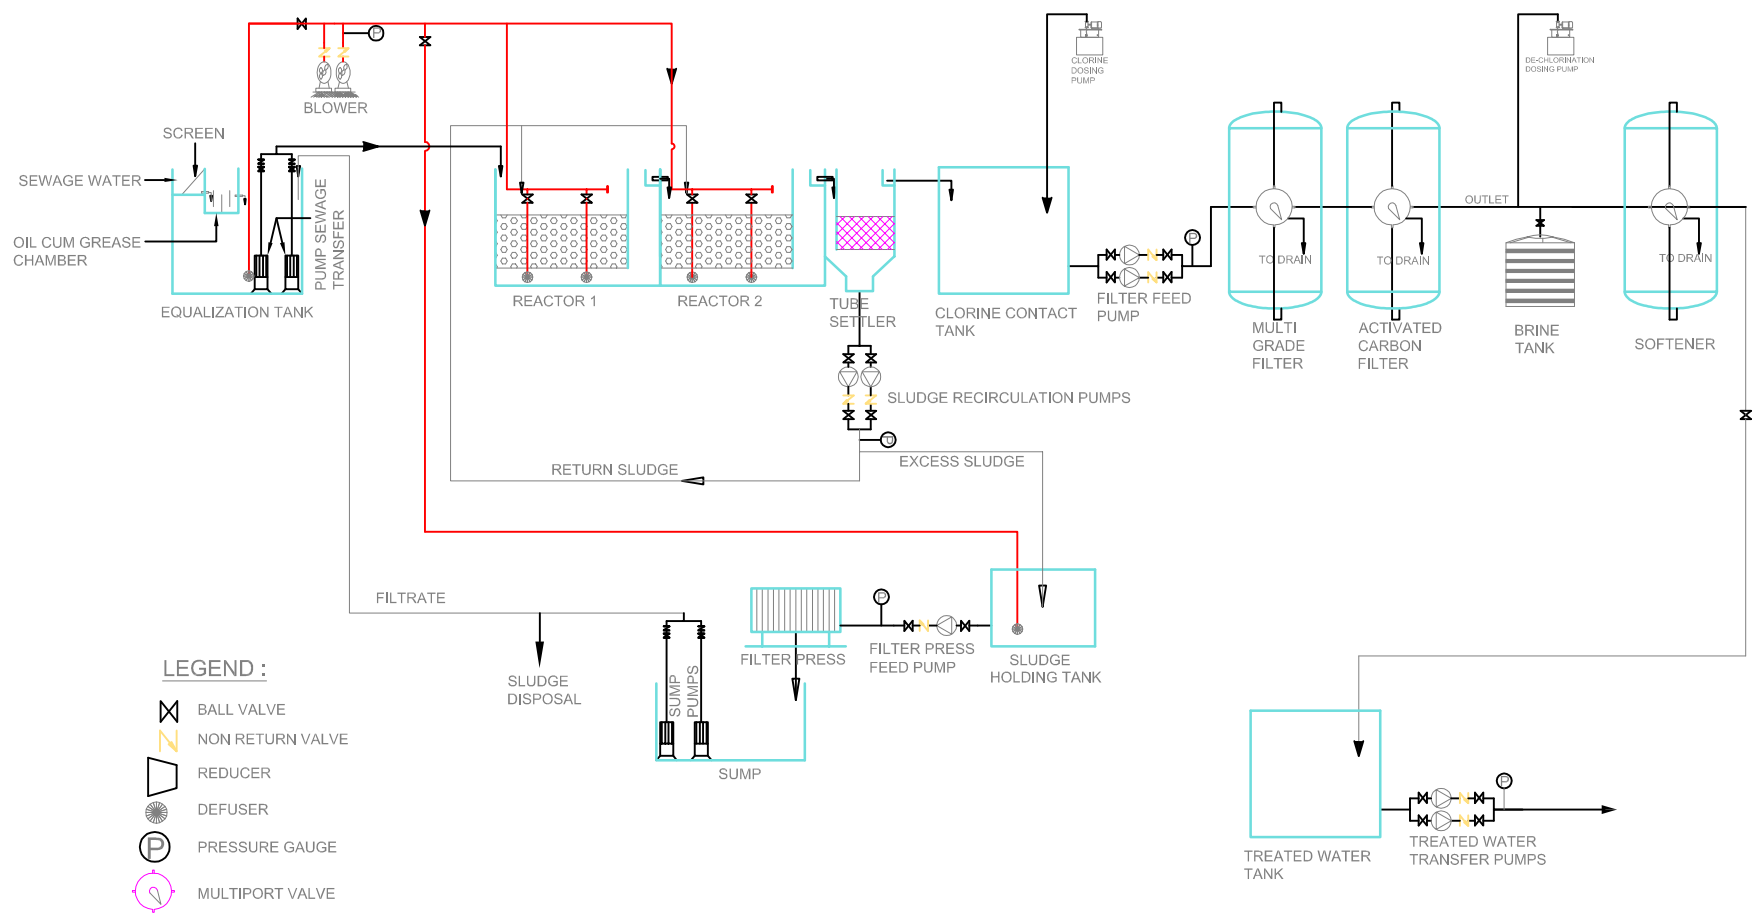

LEGEND :		
S. No.	SYMBOL	DESCRIPTION
1.	M.H. 	MANHOLE
2.		SEWER LINE
3.	M.H. 	MANHOLE SIZE. 900x800mm
4.		SEWER LINE
5.	C.P. 	CATCH PIT
6.		UNDER GROUND PIPE DRAIN
7.		CATCH PIT 500x450mm
8.		UNDER GROUND PIPE DRAIN
9.	M.H. 	MANHOLE SIZE. 600x600mm
10.		1500 BRANCH SERWER LINE
11.		1500 BRANCH DRAIN LINE
12.	C.P. 	CATCH PIT 500x450
13.		
14.		
15.		



ROAD

ROAD

TO LUCKNOW

Waste Treatment Plan

PROJECT				Waste Treatment Plan				drawing released for		Services Consultant :							
PROPOSED APARTMENT/GROUP HOUSING FOR SHREEYA BUILDERS & DEVELOPERS AT GATA NO. 1081& 1082, VILLAGE -RENDUWA PALHARI ,PARGAN DEWA ,TEHSIL-NAWABGANJ, DISTRICT - BARABANKI , UTTER PRADESH								☐ APPROVAL	☒ ADVANCE COPY	☐ SUBMISSION	☐ CONSTRUCTION	SERVICES DESIGN & ASSOCIATES					
				TO JANIBAD V						C-2/140, VIBHUTI KHAND, GOMTI NAGAR,LUCKNOW Mob No -9936190952 ,9450375372 E-Mail - sdaup32@gmail.com							
	PROJECT CODE	PROPOSED APARTMENT/GROUP HOUSING	OWNER	NOTE 1.VERIFY ACTUAL SITE DIMENSION 2.SUBMIT SHOPDRAWINGS AND SAMPLE FOR DESIGNERS APPROVALS 3.ANY DISCREPANCY ON PLAN ,CONTRACTORS TO VERIFY SITE AND INFORM DESIGNER 4.PROVIDE MOCK-UP ON SITE FOR DESIGNERS APPROVAL			REVISIONS			SHEET CONTENTS:- SITE PLAN EXTERNALSEWERAGE , DRAINAGE & RAIN WATER HARVESTING SYSTEM		REVISION NO.:-	DATE: 28/01/2026	SHEET NO:			
			MR.NALIN PRABHAT S/o V K AGARWAL				NO	REMARKS	DATE			1	DRAWN BY: AnkIt				
			LOCATION				CITY						CHECKED BY: R. Kumar				
			GATA NO. ~ 1081 & 1082										SCALE:				
			THIS DRAWNS,AS AN INSTRUMENT IF SERVICE IS THE PROPERTY AND AS SUCH MUSTNOT BE REPRODUCED OR COPIED IN PART OR IN WHOLE WITHOUT THIER PERMISSION. ALL DRAWINGS ARE TO BE RETURENED WHEN MO LONGER IS USE														