




PLUMBING LEGEND :	
	STORM WATER MANHOLE WITH 5600 S.F.R.C. PERFORATED MANHOLE COVER.
	CATCH BASIN (450 x 450) MM WITH PERFORATED MANHOLE COVER
	CATCH BASIN (600 x 600) MM WITH PERFORATED MANHOLE COVER
	EXTERNAL RCC STORM WATER LINE (DIA AS / DRAWING)
	DI MUNICIPAL WATER SUPPLY LINE
	TUBE WALL WATER SUPPLY LINE
	RECHARGE PIT (3.0M DIA)
	DESILTING CHAMBER (1500 x 3000) MM
	BUTTERFLY VALVE WITH CHAMBER
	NON RETURN VALVE (NRV) WITH CHAMBER

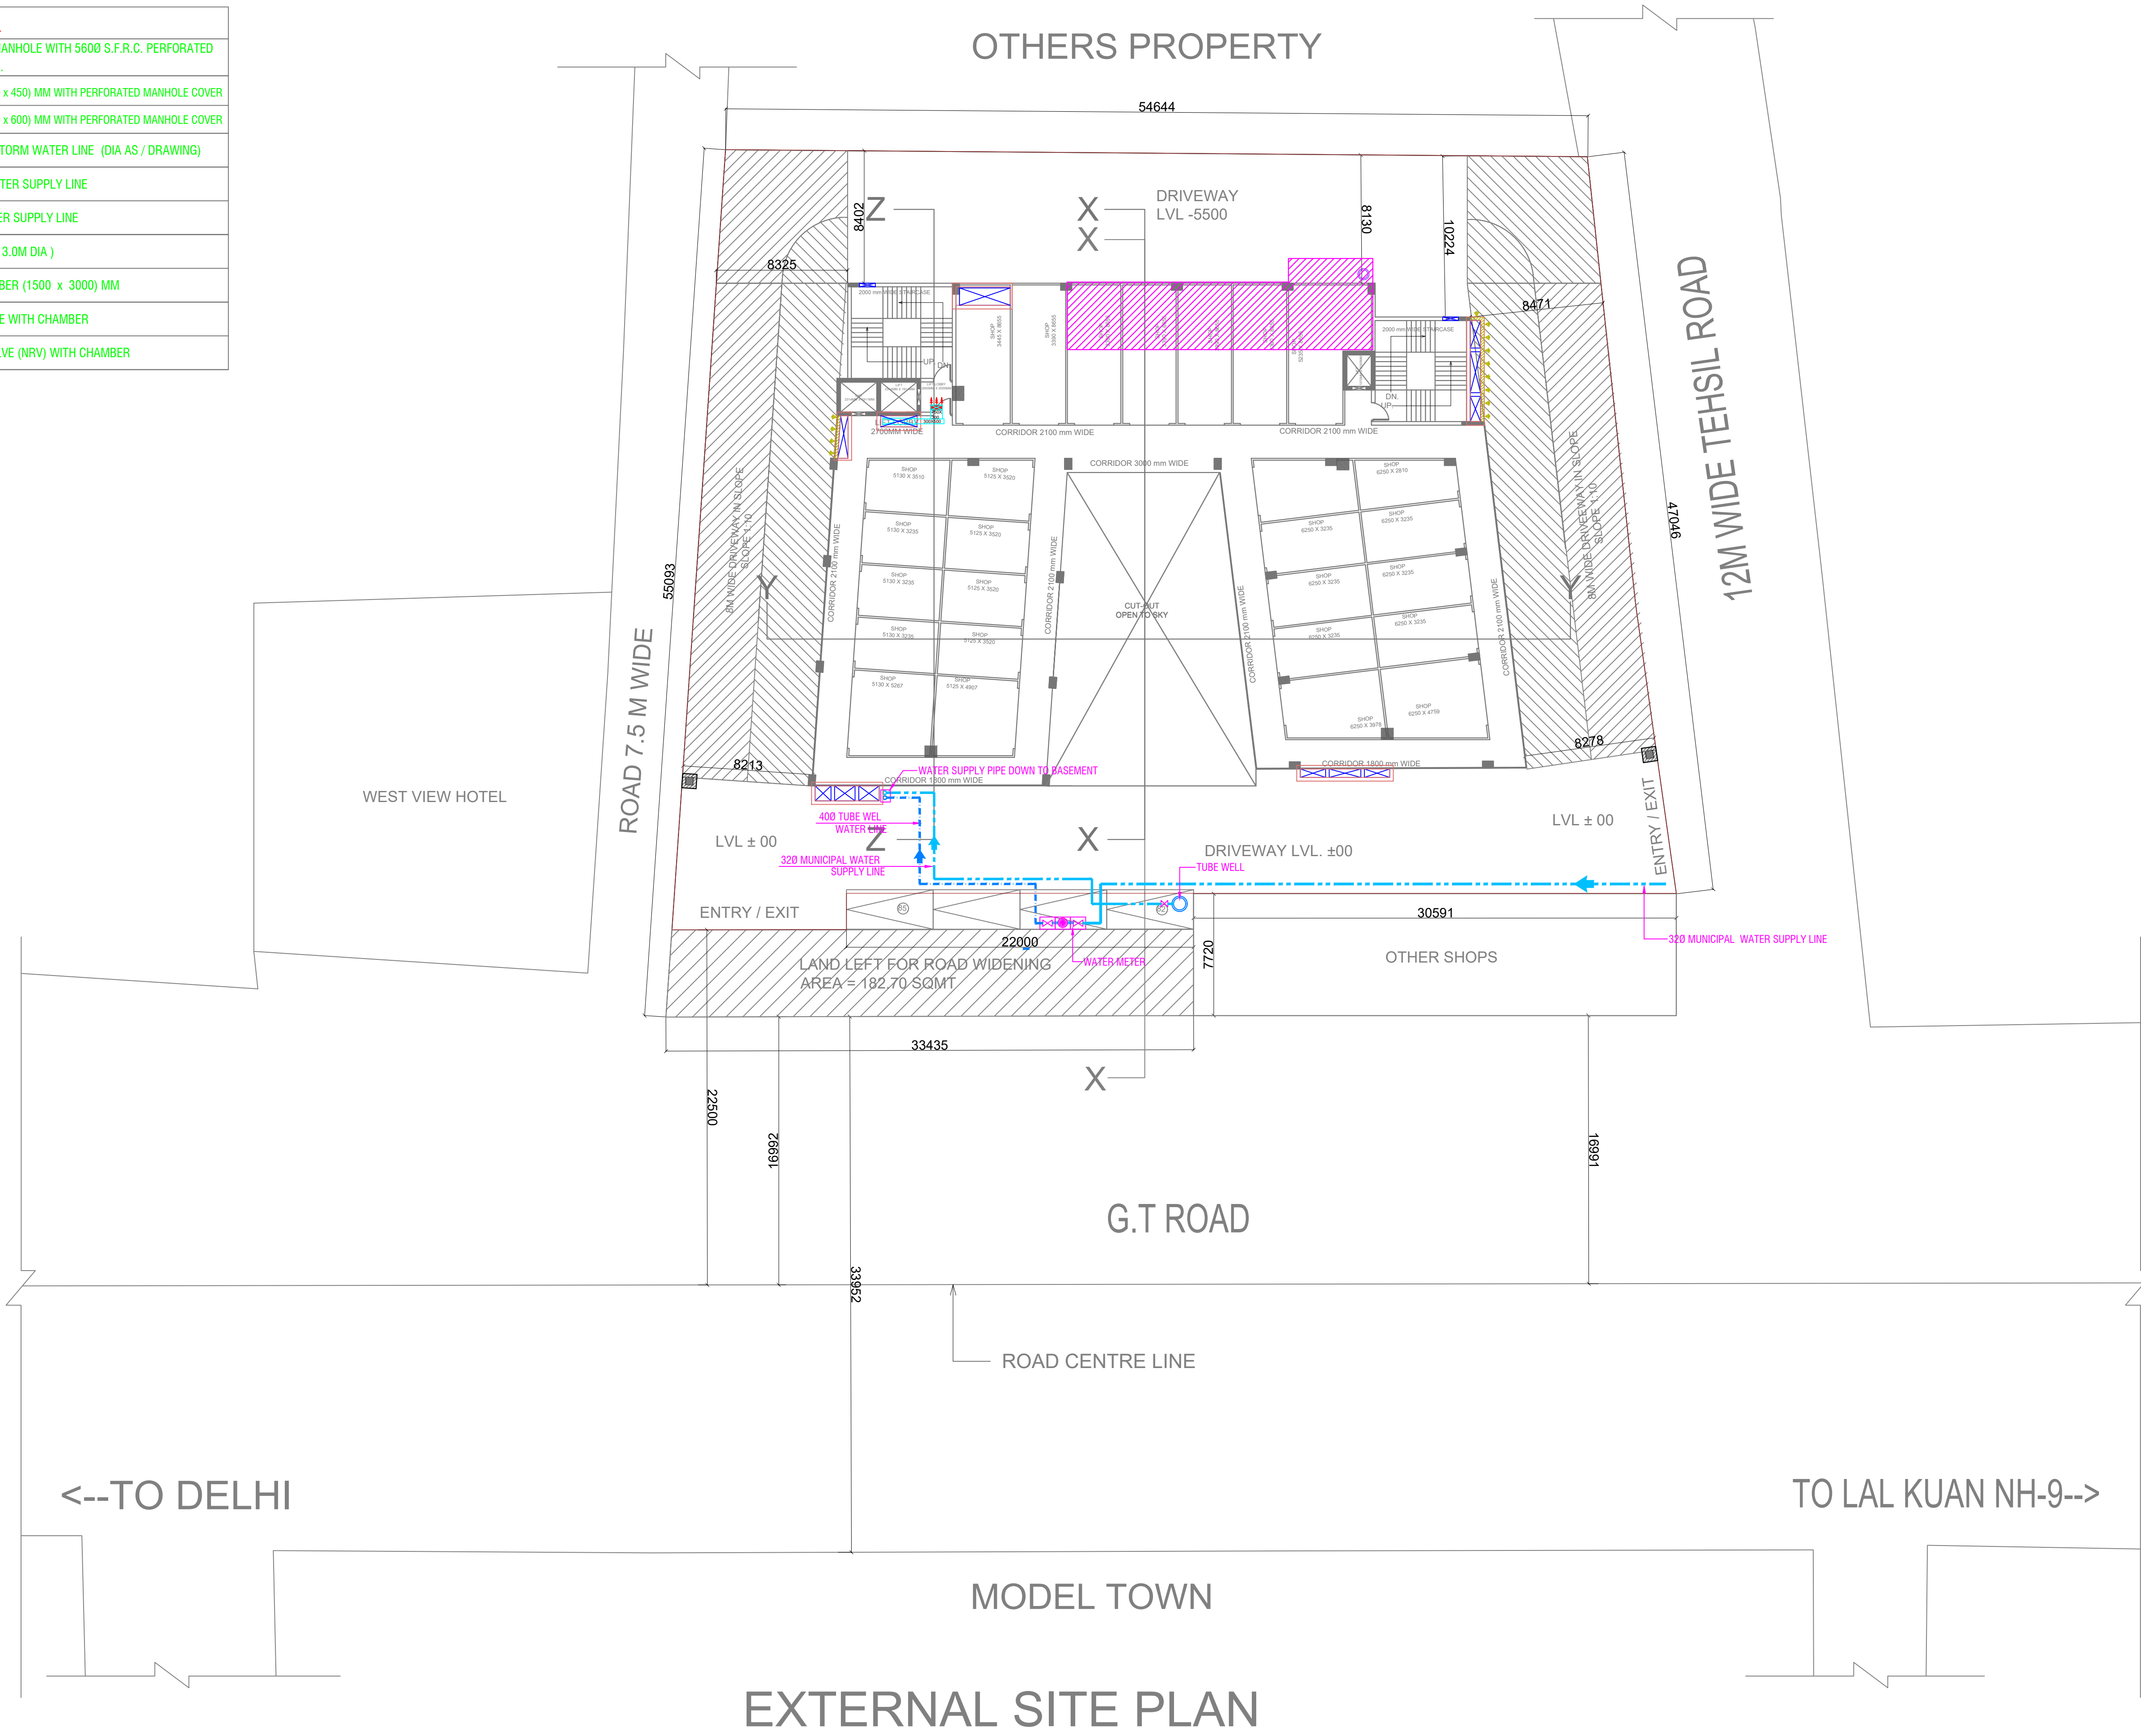

SUBMISSION DRAWING	
NOTE :- ALL DIMENSIONS ARE IN MM	
	
PROJECT :- SUBMISSION DRAWINGS FOR PROPOSED COMMERCIAL CUM CINEMA (NAVRANG SQUARE) AT KHASRA NO. 1106 AND 1112, VILLAGE KELA, G.T ROAD , GHAZIABAD.	
CLIENT :- RENOWNED BUILDTech PVT. LTD. THROUGH ITS DIRECTOR Mr. SHAILENDRA SHARMA .	
MEP CONSULTANTS: PARADISE CONSULTANTS PLOT NO. 96, POCKET-1, BASEMENT JASOLA VIHAR NEW DELHI - 110025 PH+91-11-29943601, E-mail: paradiseconsultants@gmail.com	
DRAWING TITLE :- EXTERNAL SITE PLAN WATER SUPPLY LAYOUT	
KGN ARCHITECTS PLOT NO 1,2ND FLOOR JT TRACTOR AGENCY, PREM ENCLAVE, KRISHNA NAGAR, DELHI MEERUT ROAD, GHAZIABAD CONTACT :- 7052867168 MAIL :- kgnarchitects@gmail.com	
DRAWN BY :-	CHECKED BY :-
SCALE	DATED :-
1:200 (A1)	
ARCHITECT'S SIGN.	
OWNER'S SIGN	PL-PC-N-S-102


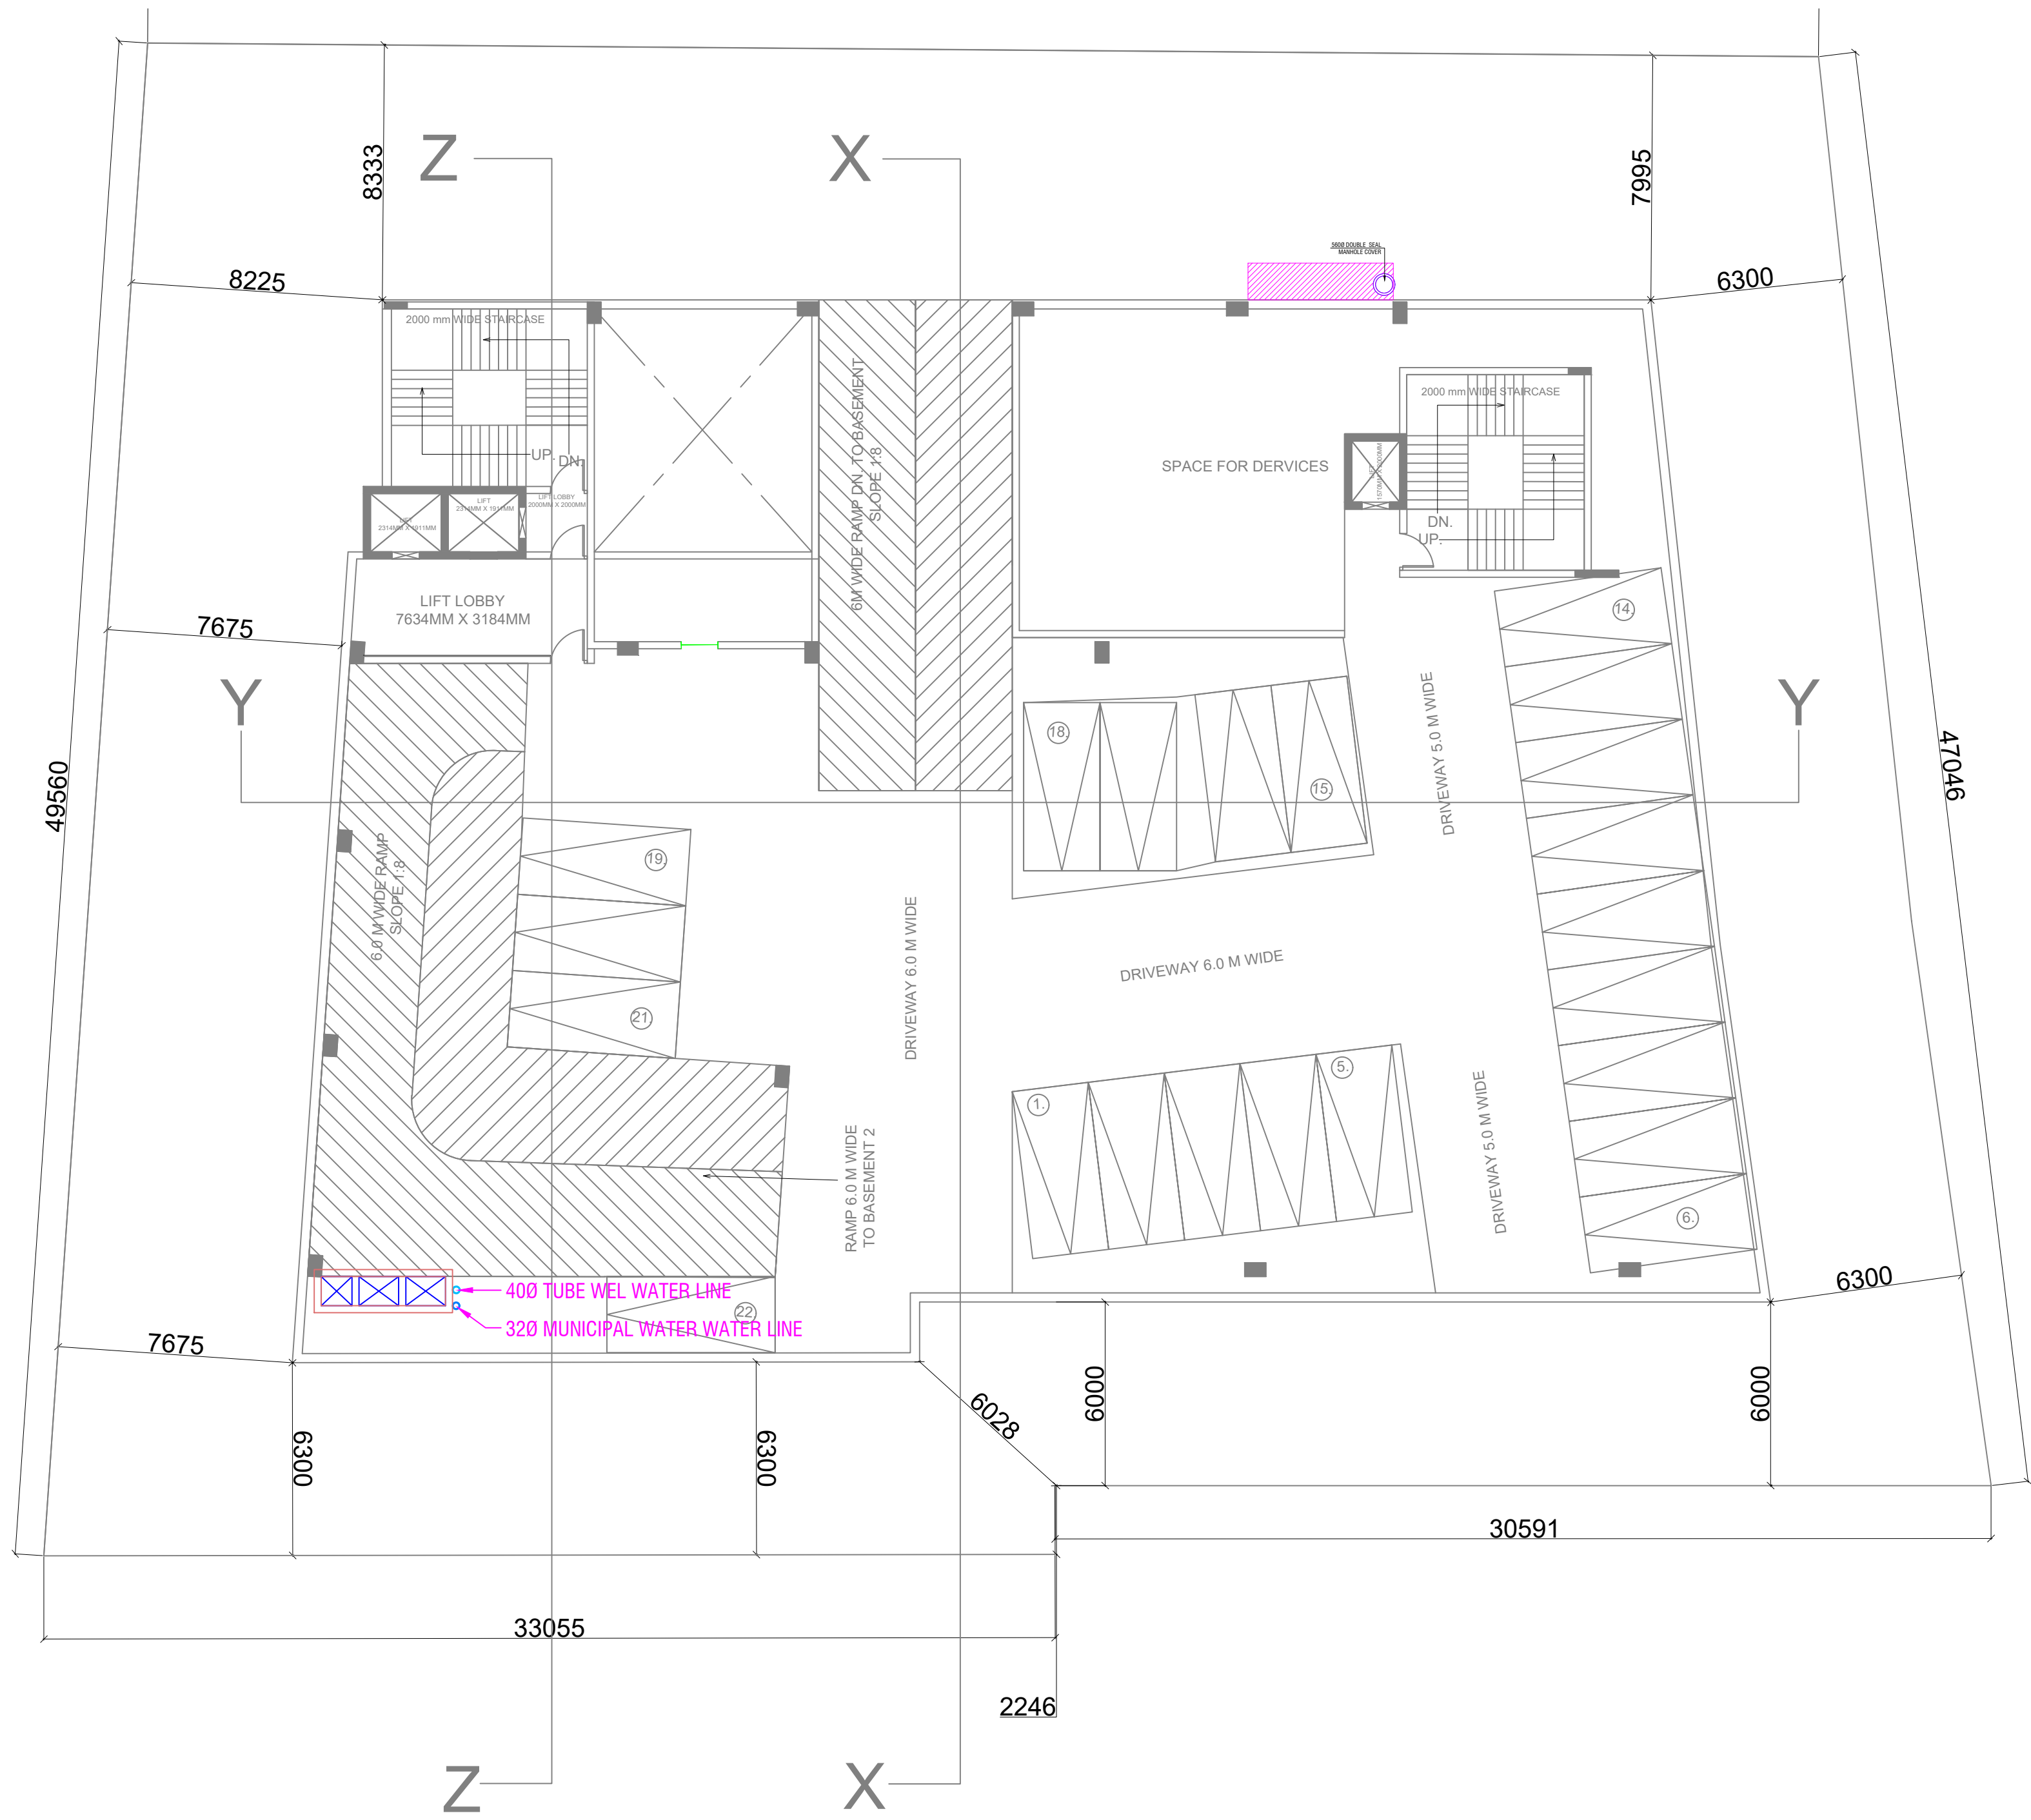


BASEMENT-1 FLOOR PLAN

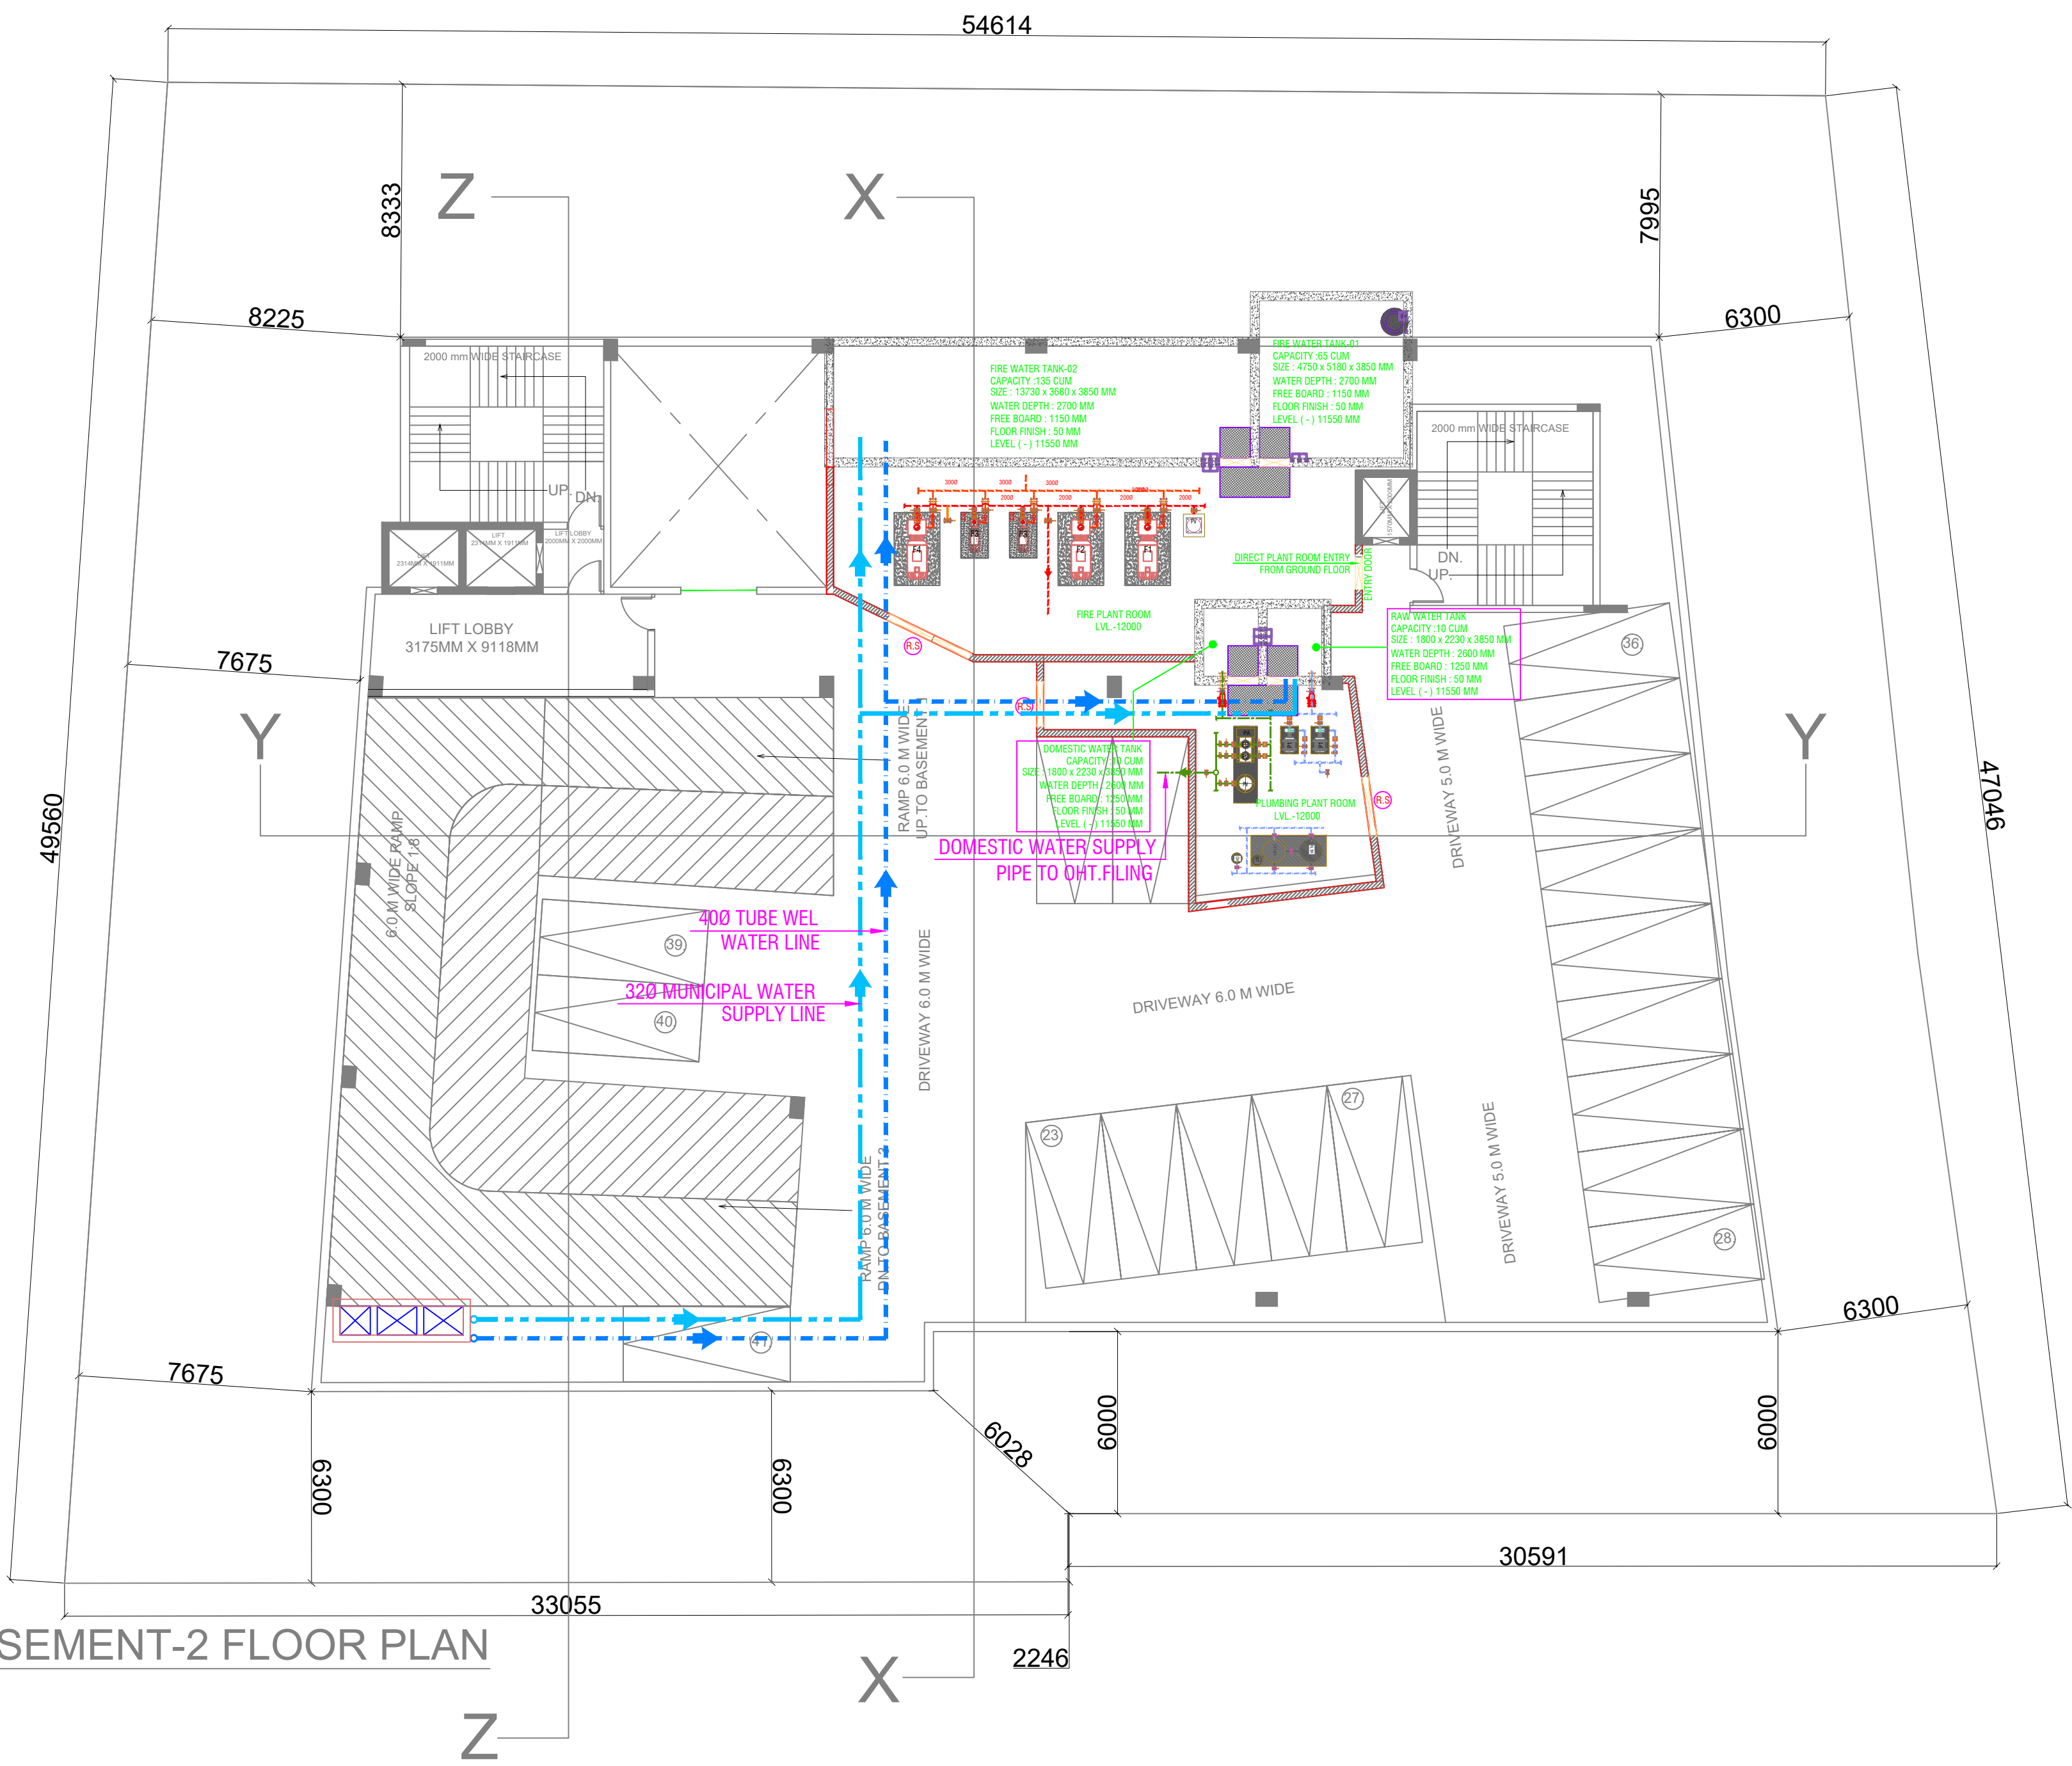


BASEMENT-2 FLOOR PLAN

SUBMISSION DRAWING			
NOTE :- ALL DIMENSIONS ARE IN MM			
PROJECT :- SUBMISSION DRAWINGS FOR PROPOSED COMMERCIAL CUM CINEMA (NAVRANG SQUARE) AT KHASRA NO. 1106 AND 1112, VILLAGE KELA, G.T ROAD , GHAZIABAD.			
CLIENT :- RENOWNED BUILDTECH PVT. LTD. THROUGH ITS DIRECTOR Mr. SHAILENDRA SHARMA .			
MEP CONSULTANTS: PARADISE CONSULTANTS PLOT NO. 96, POCKET-1, BASEMENT JASOLA VIHAR NEW DELHI - 110025 PH-011-46132800,41030619 E-mail: paradiseconsultants@gmail.com			
DRAWING TITLE :- FIRST & SECOND BASEMENT PLAN WATER TANK & WATER SUPPLY PLAN			
KGN ARCHITECTS PLOT NO 1,2ND FLOOR JT TRACTOR AGENCY, PREM ENCLAVE, KRISHNA NAGAR, DELHI MEERUT ROAD, GHAZIABAD CONTACT :- 7052867168 MAIL :- kgnarchitects@gmail.com			
DRAWN BY :-	CHECKED BY :-	SCALE 1:100 (A1)	DATED :-
OWNER'S SIGN		ARCHITECT'S SIGN.	
		PL-PC-N-S-BASE-101	

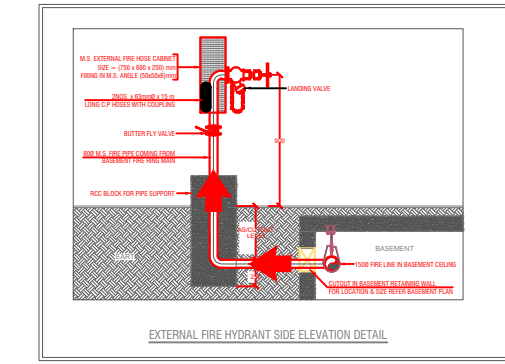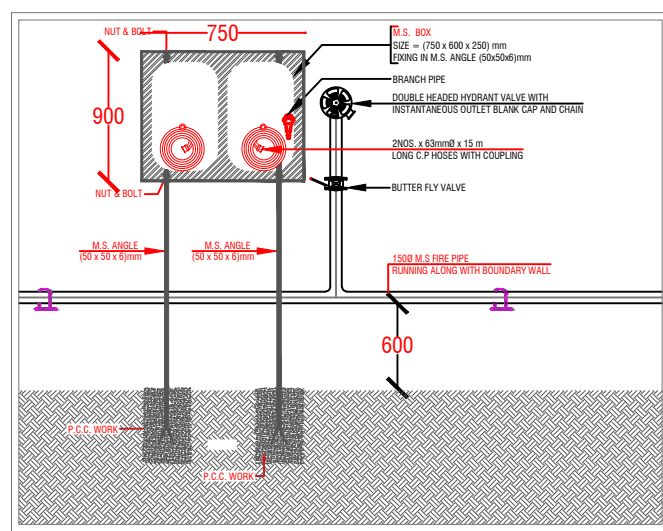


---	MS EXTERNAL FIRE HYDRANT PIPE
■	EXTERNAL FIRE HYDRANT

FIRE LEGEND:-	
---	EXTERNAL FIRE RING MAIN PIPE
■	FIRE TENDER ROAD
IMPORTANT NOTES:-	
DISTANCE BETWEEN EXTERNAL FIRE HYDRANT C / C = 45.0m	
TOTAL NO. E.F.H. :- 07 NOS	

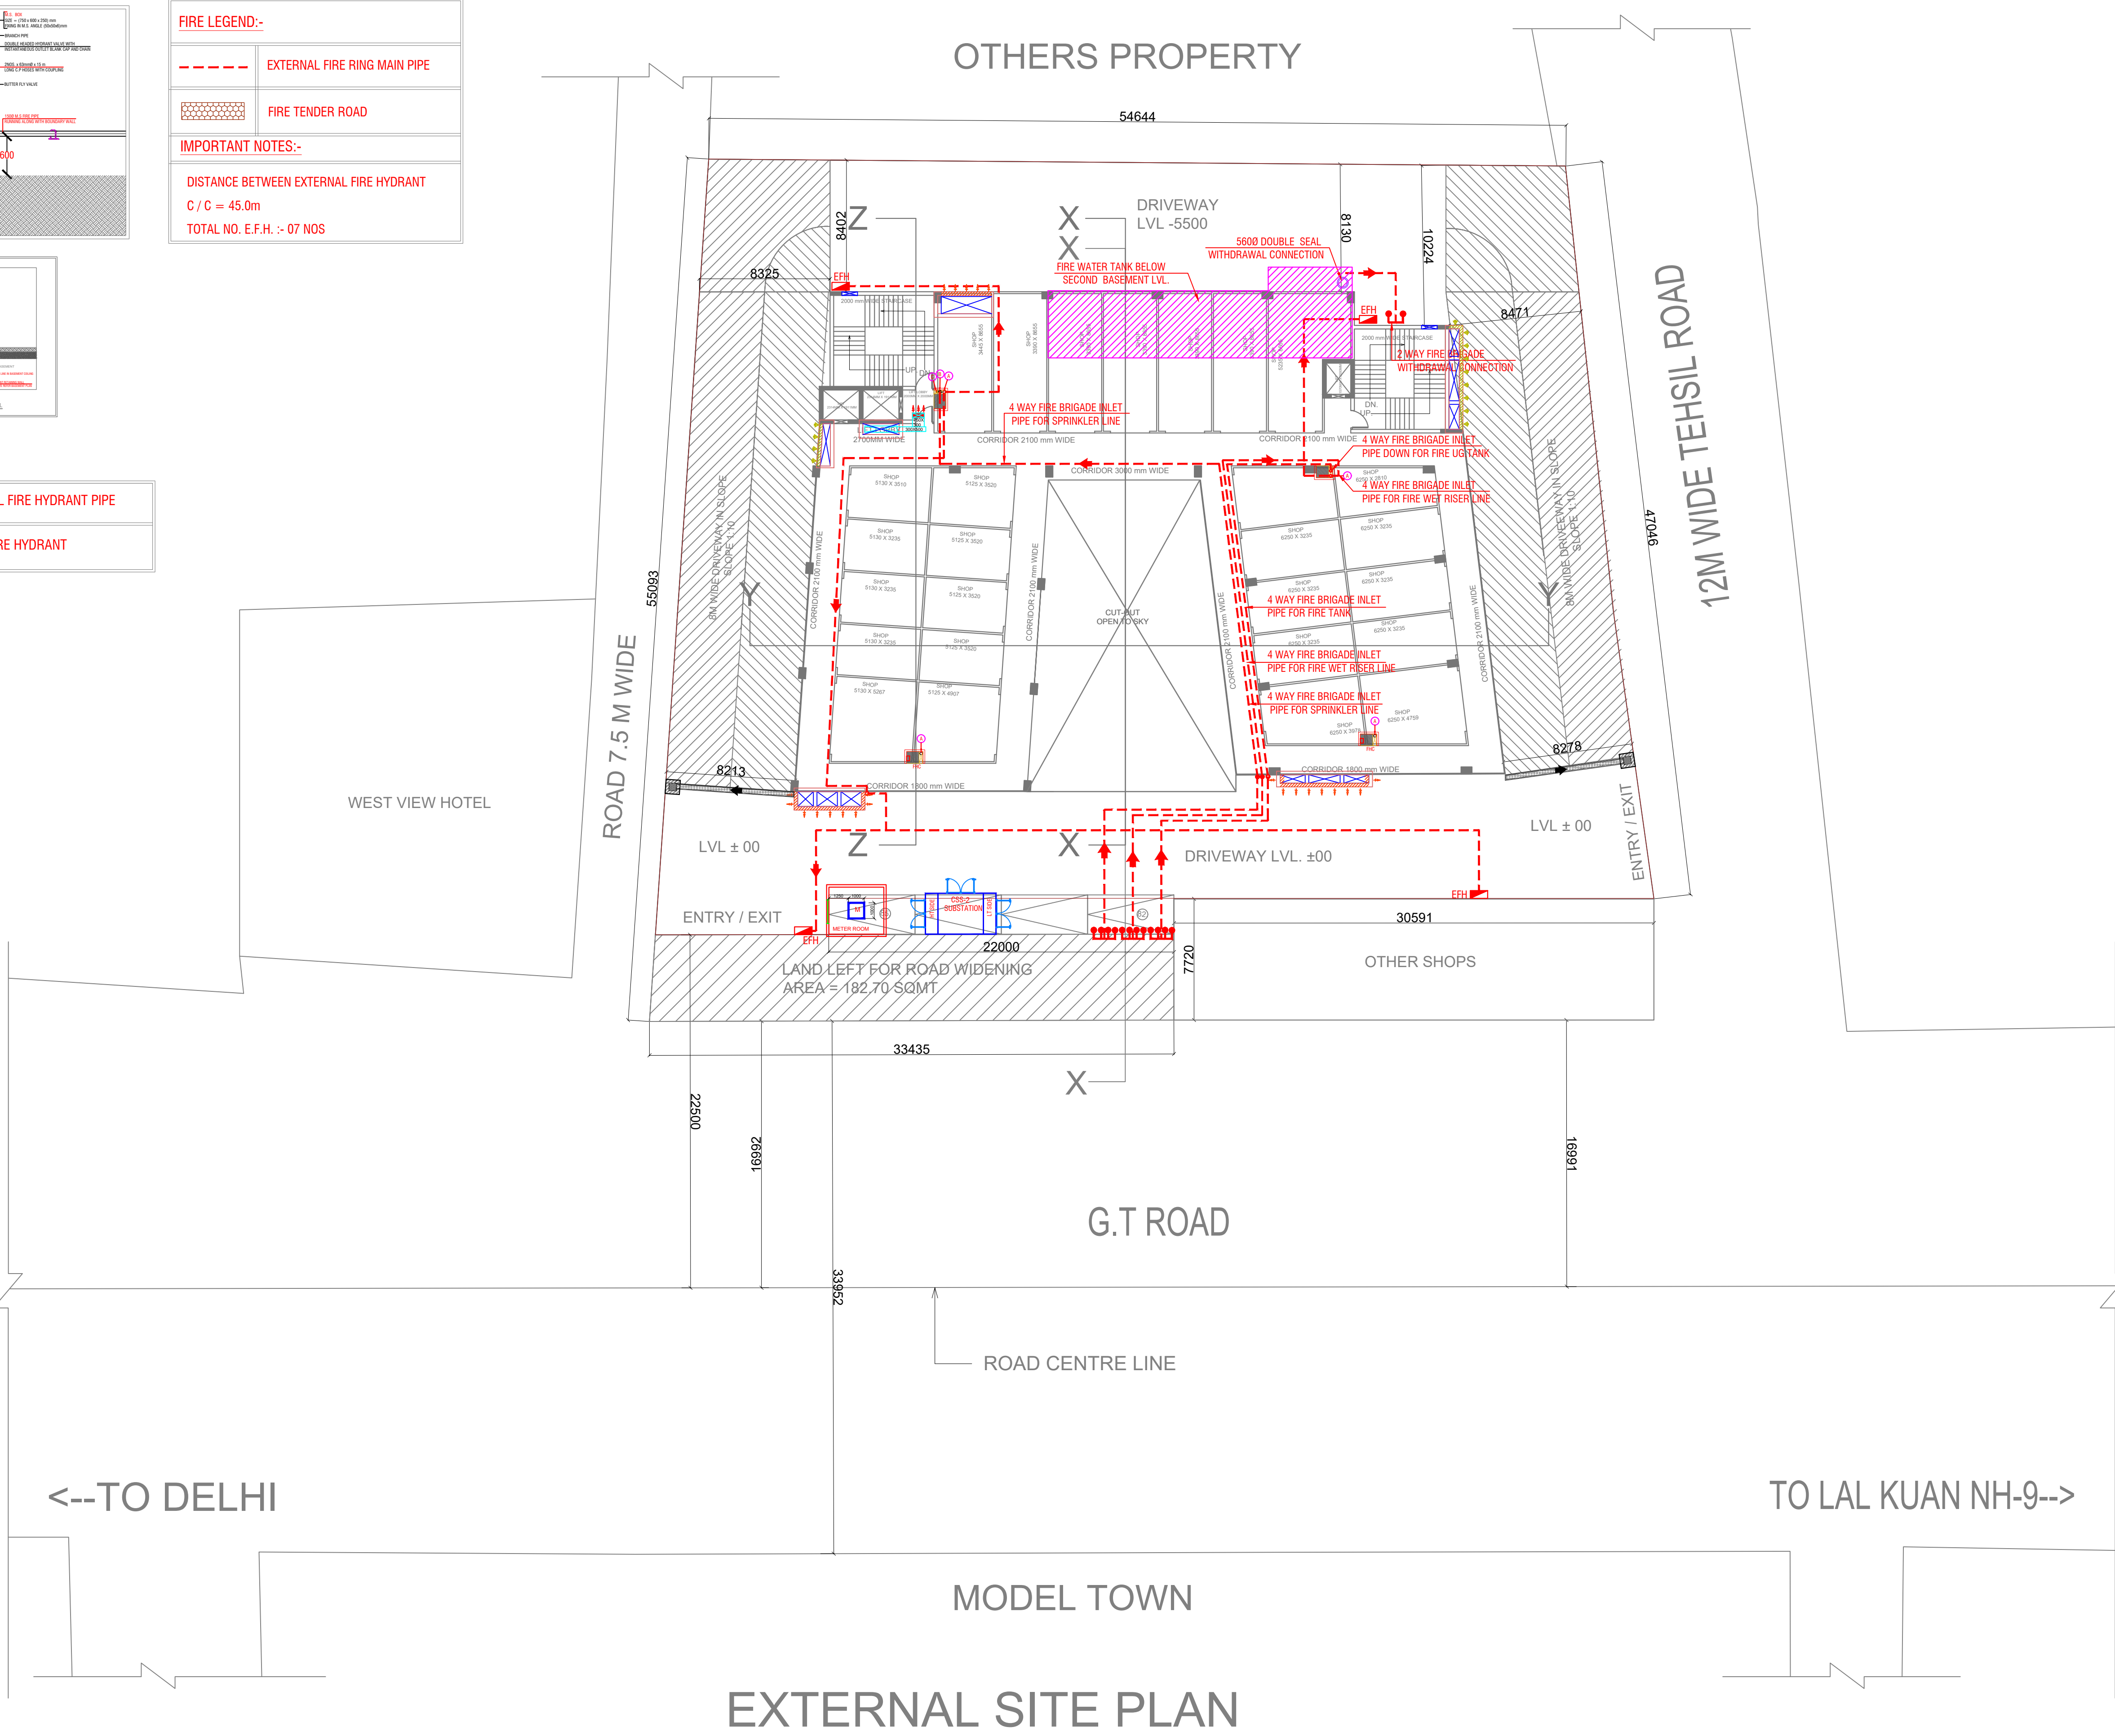

SUBMISSION DRAWING	
NOTE :- ALL DIMENSIONS ARE IN MM	
PROJECT :- SUBMISSION DRAWINGS FOR PROPOSED COMMERCIAL CUM CINEMA (NAVRANG SQUARE) AT KHASRA NO. 1106 AND 1112, VILLAGE KELA, G.T ROAD , GHAZIABAD.	
CLIENT :- RENOWNED BUILDTECH PVT. LTD. THROUGH ITS DIRECTOR Mr. SHAILENDRA SHARMA .	
MEP CONSULTANTS: PARADISE CONSULTANTS PLOT NO. 96, POCKET-1, BASEMENT JASOLA VIHAR NEW DELHI - 110025 PH+91-11-29943601, E-mail: paradiseconsultants@gmail.com	
DRAWING TITLE :- EXTERNAL SITE PLAN FIRE LAYOUT	
KGN ARCHITECTS PLOT NO 12ND FLOOR JT TRACTOR AGENCY, PREM ENCLAVE, KRISHNA NAGAR, DELHI MEERUT ROAD, GHAZIABAD CONTACT :- 7052867168 MAIL :- kgnarchitects@gmail.com	
DRAWN BY :-	CHECKED BY :-
SCALE 1:200 (A1)	DATED :-
ARCHITECT'S SIGN.	
OWNER'S SIGN	FF-PC-N-S-101

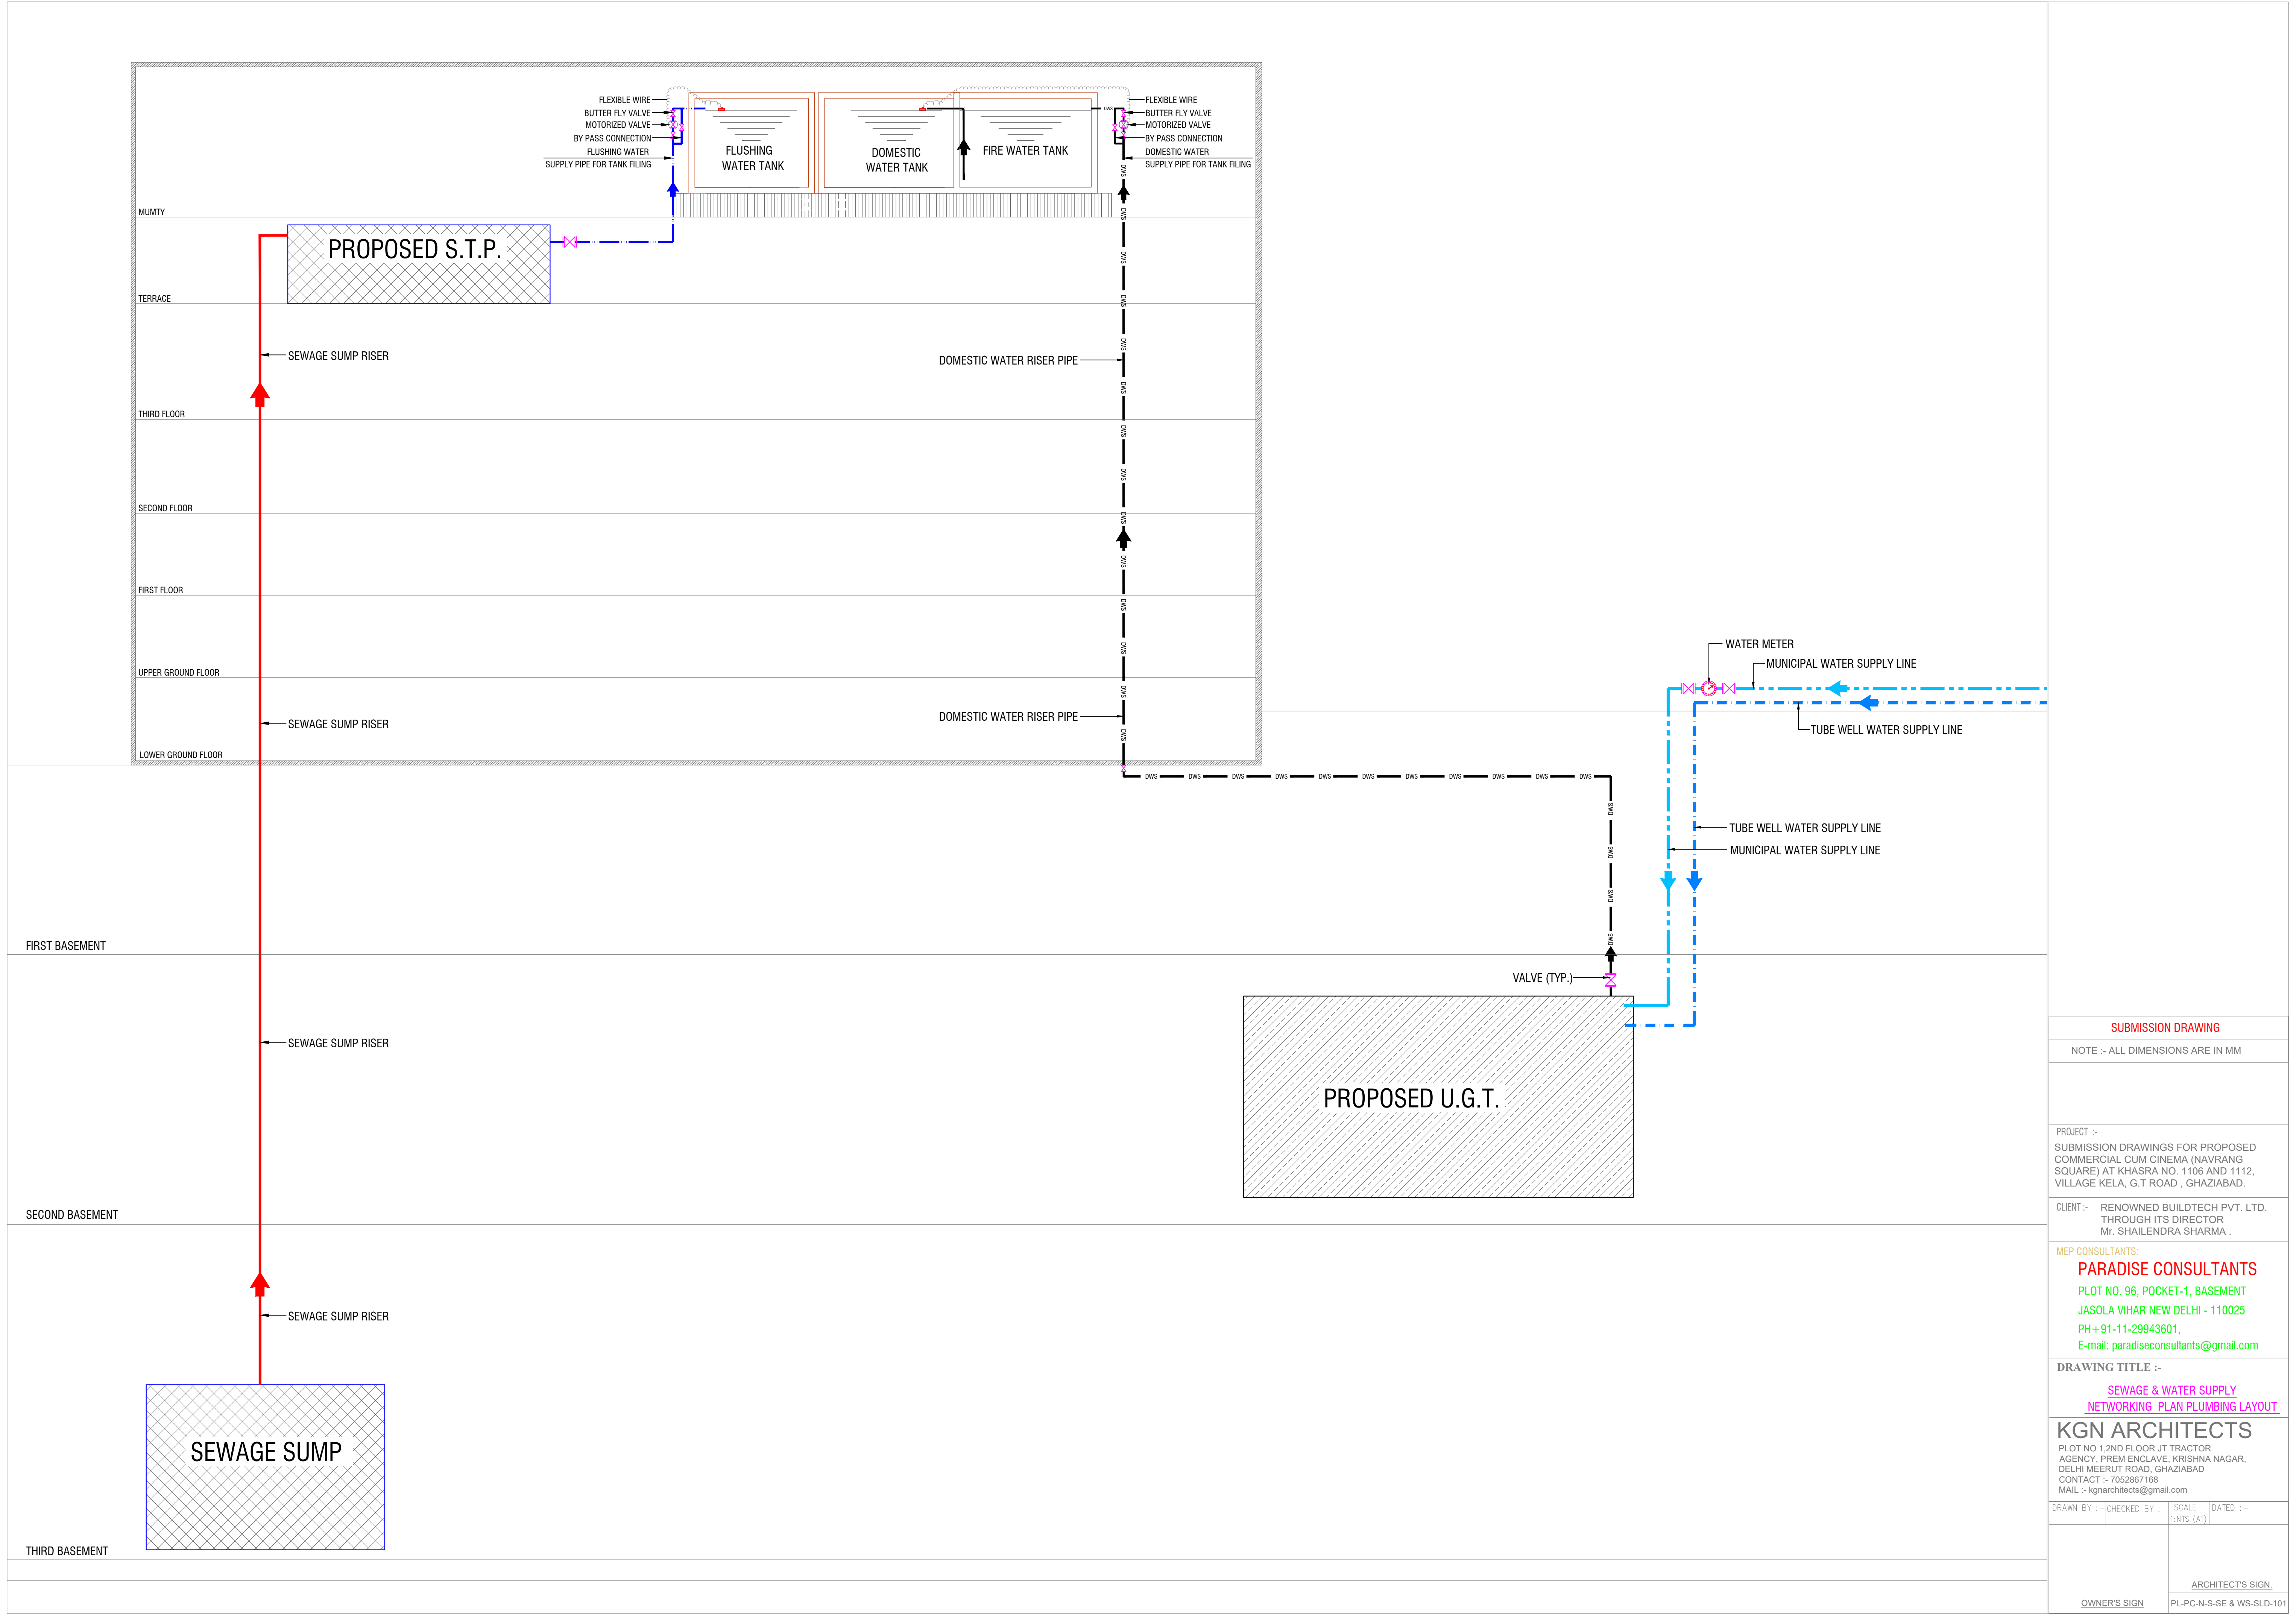

SUBMISSION DRAWING			
NOTE :- ALL DIMENSIONS ARE IN MM			
PROJECT :- SUBMISSION DRAWINGS FOR PROPOSED COMMERCIAL CUM CINEMA (NAVRANG SQUARE) AT KHASRA NO. 1106 AND 1112, VILLAGE KELA, G.T ROAD , GHAZIABAD.			
CLIENT :- RENOWNED BUILDTECH PVT. LTD. THROUGH ITS DIRECTOR Mr. SHAILENDRA SHARMA .			
MEP CONSULTANTS: PARADISE CONSULTANTS PLOT NO. 96, POCKET-1, BASEMENT JASOLA VIHAR NEW DELHI - 110025 PH+91-11-29943601, E-mail: paradiseconsultants@gmail.com			
DRAWING TITLE :- SEWAGE & WATER SUPPLY NETWORKING PLAN PLUMBING LAYOUT			
KGN ARCHITECTS PLOT NO 1, 2ND FLOOR JT TRACTOR AGENCY, PREM ENCLAVE, KRISHNA NAGAR, DELHI MEERUT ROAD, GHAZIABAD CONTACT :- 7052867168 MAIL :- kgnarchitects@gmail.com			
DRAWN BY :-	CHECKED BY :-	SCALE 1:NTS (A1)	DATED :-
OWNER'S SIGN		ARCHITECT'S SIGN. PL-PC-N-S-SE & WS-SLD-101	