




FIRST FLOOR PLAN PLUMBING & FIRE SHAFT PLAN

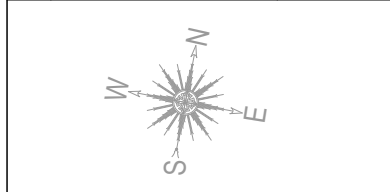

PROJECT	
COMMERCIAL	
DRAWING TITLE	
FIRST FLOOR PLUMBING & FIRE PLAN	
DEALT BY	
ROHIT SINGH	
DATE - 23-05-2024	REVISION NO. - 0
SCALE	DWG NO-01
NTS	
JANUS DESIGNS	
NEAR GANPATI PLAZA, RAILWAY ROAD, HAPUR Ph:07417857758,09997563895. EMAIL: Jatinsgoel@gmail.com WEB: www.janusdesigns.in	

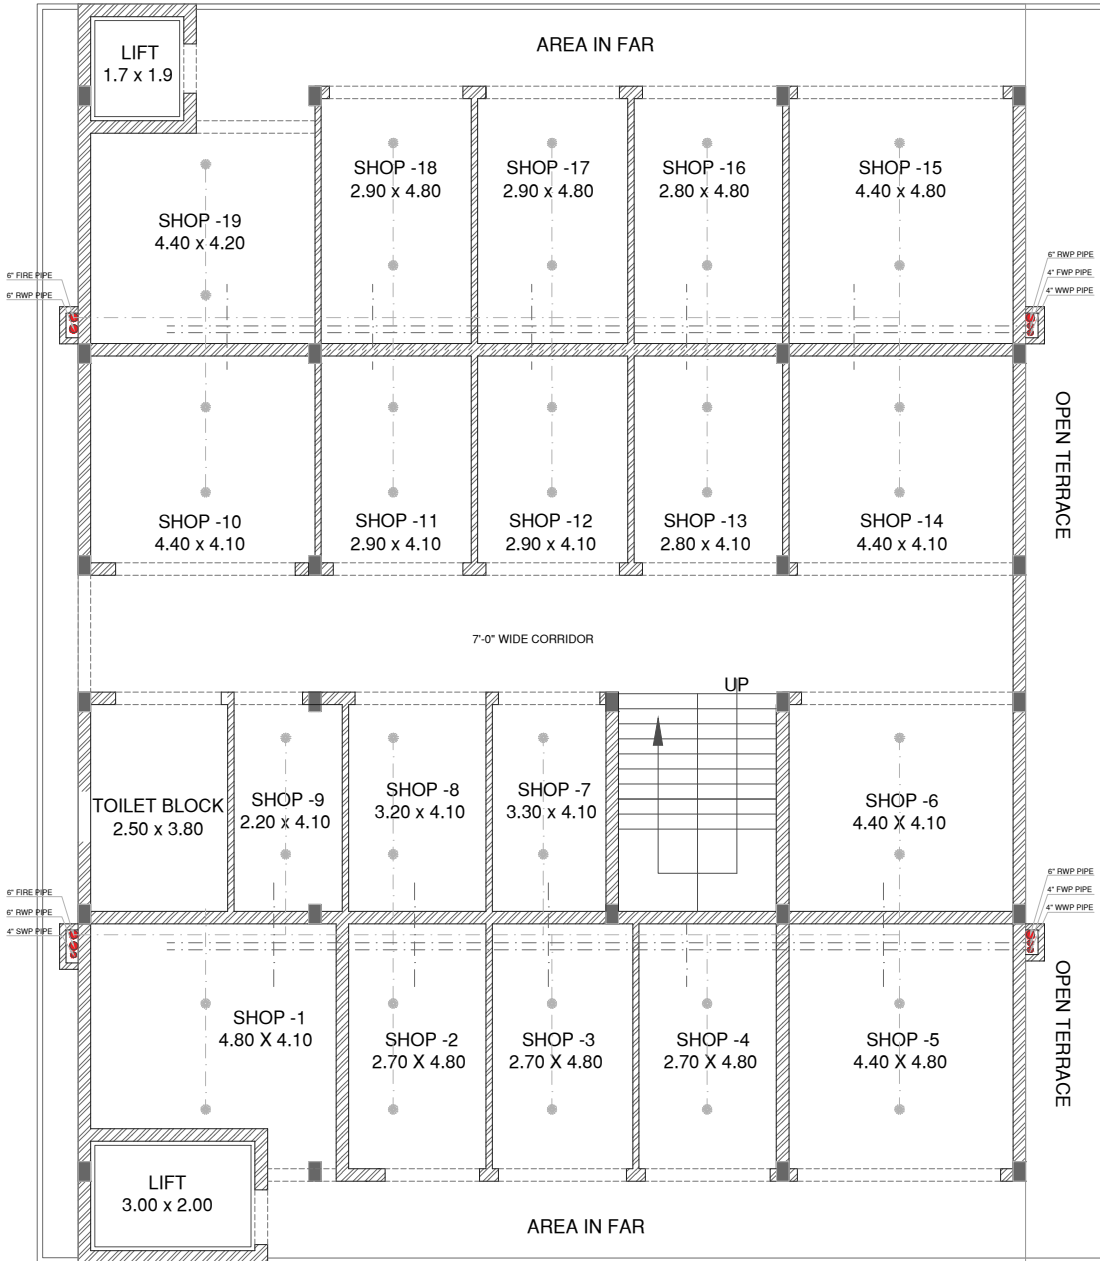

SECOND FLOOR PLAN PLUMBING & FIRE SHAFT PLAN

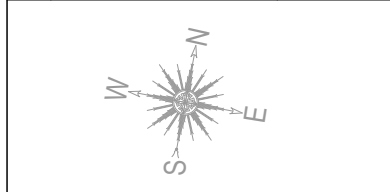

PROJECT
COMMERCIAL


DRAWING TITLE
SECOND FLOOR PLUMBING & FIRE PLAN

DEALT BY
ROHIT SINGH


DATE - 23-05-2024 REVISION NO. - 0

SCALE **DWG NO-01**
NTS

JANUS DESIGNS
NEAR GANPATI PLAZA, RAILWAY ROAD, HAPUR
Ph:07417857758,09997563895.
EMAIL: Jatinsgoel@gmail.com
WEB: www.janusdesigns.in

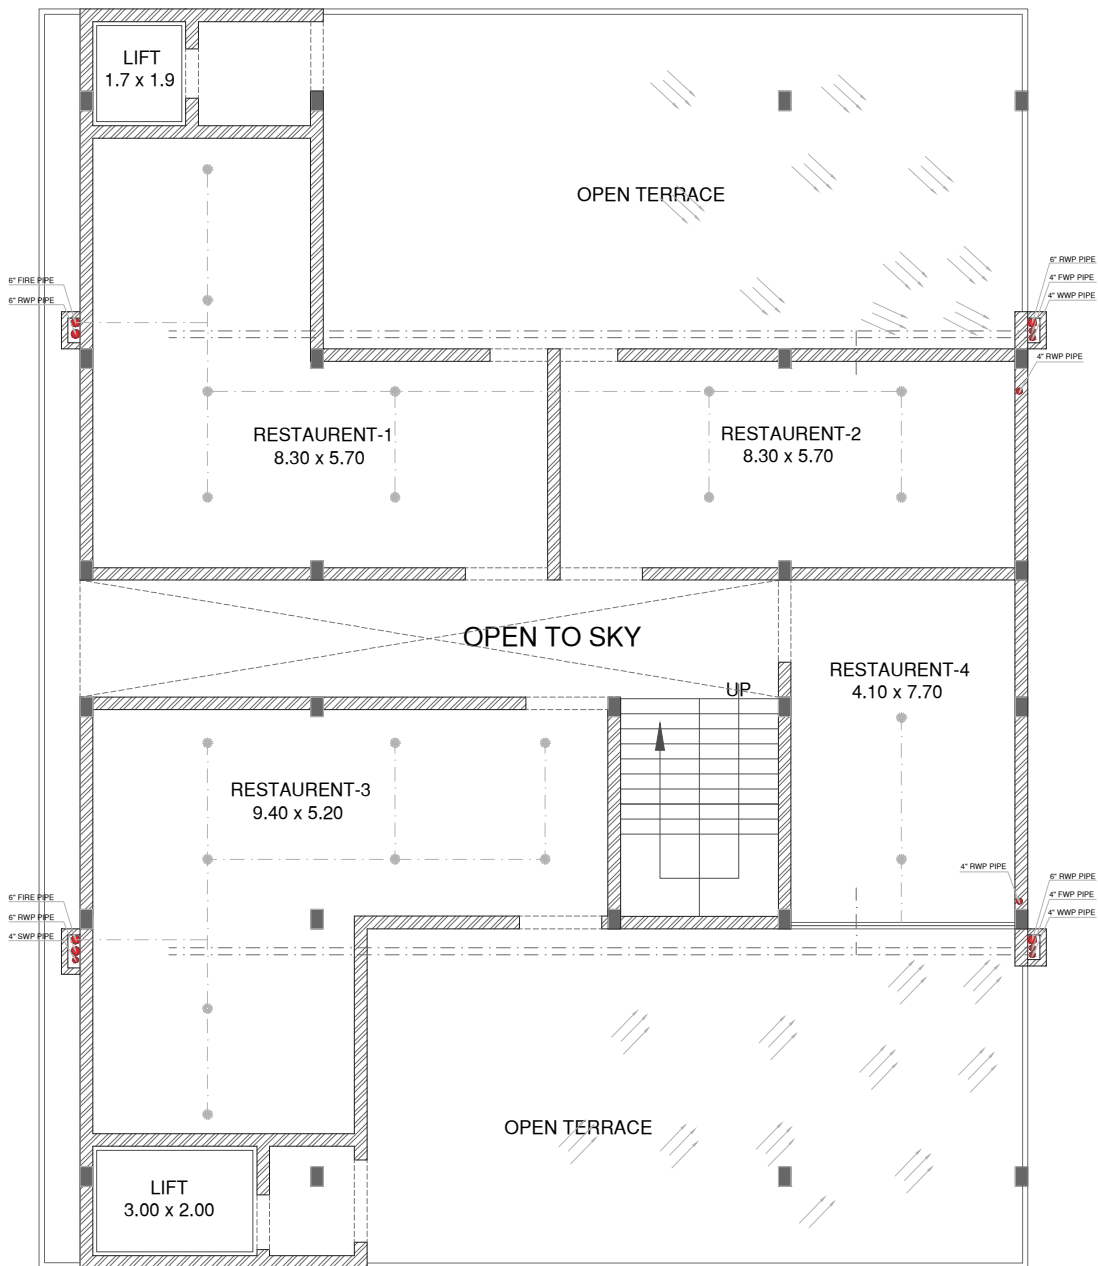

THIRD FLOOR PLAN PLUMBING & FIRE SHAFT PLAN

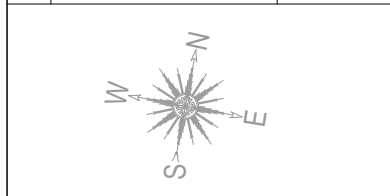

PROJECT
COMMERCIAL

DRAWING TITLE
SECOND FLOOR PLUMBING & FIRE PLAN


DEALT BY
ROHIT SINGH

DATE - 23-05-2024 REVISION NO. - 0


SCALE **DWG NO-01**
NTS

JANUS DESIGNS
NEAR GANPATI PLAZA, RAILWAY ROAD, HAPUR
Ph:07417857758,09997563895.
EMAIL: Jatinsgoel@gmail.com
WEB: www.janusdesigns.in

OWNER

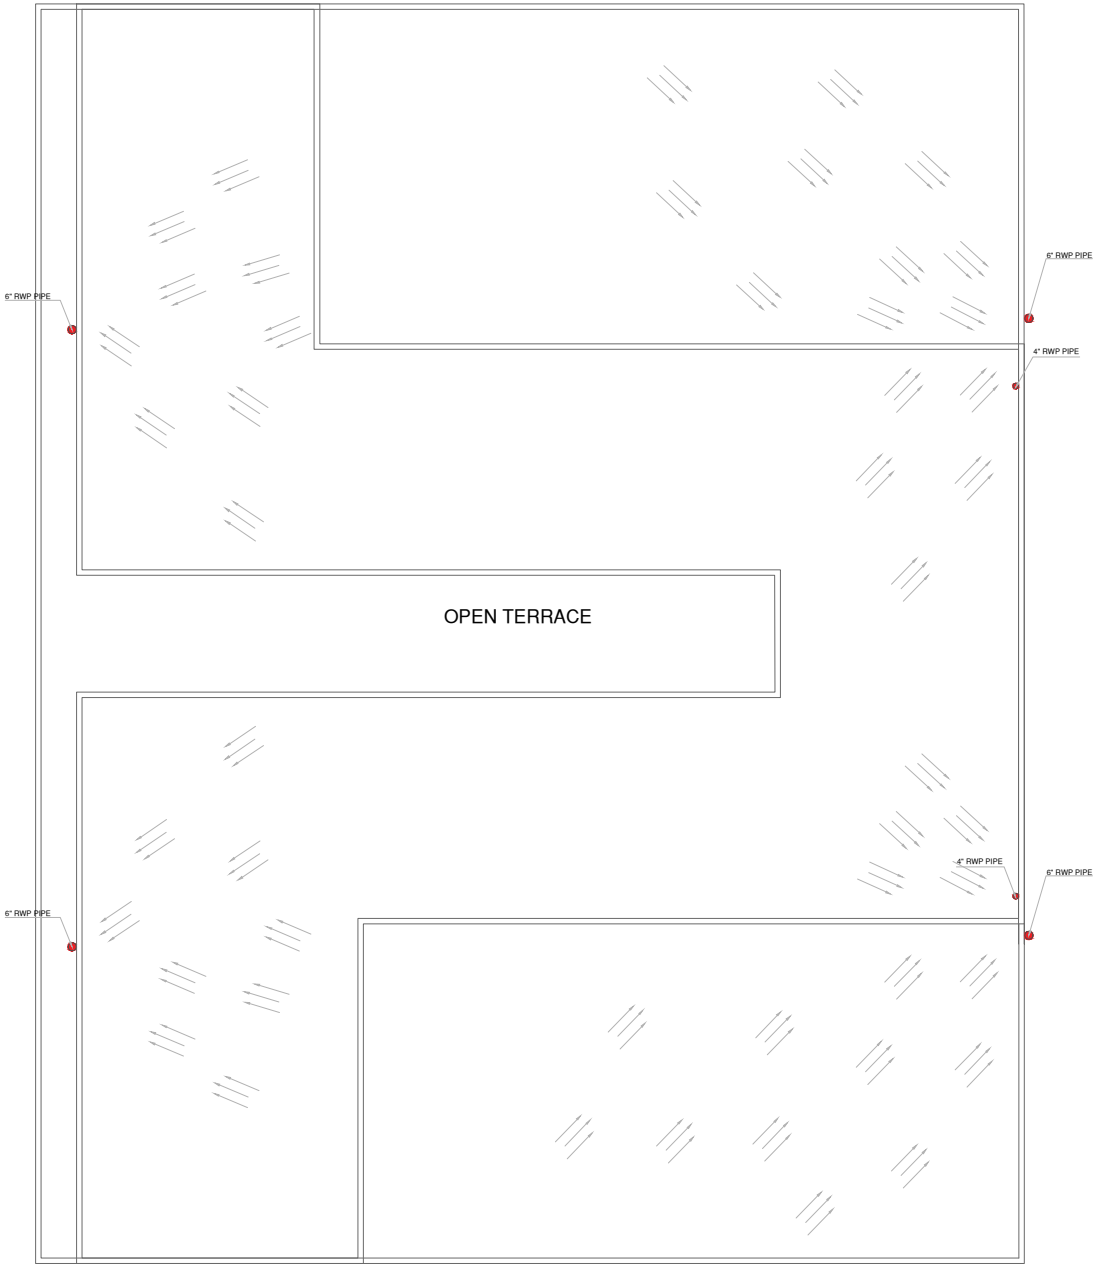

TERRACE FLOOR PLAN

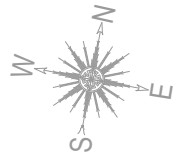

PROJECT
COMMERCIAL

DRAWING TITLE
TERRACE FLOOR PLUMBING & FIRE PLAN

DEALT BY
ROHIT SINGH

DATE - 23-05-2024 REVISION NO. - 0

SCALE **DWG NO-01**
NTS

JANUS DESIGNS
NEAR GANPATI PLAZA, RAILWAY ROAD, HAPUR
Ph:07417857758,09997563895.
EMAIL: Jatinsgoel@gmail.com
WEB: www.janusdesigns.in

PROJECT

COMMERCIAL

DRAWING TITLE

DEALT BY

ROHIT SINGH

DATE - 24-05-2024

REVISION NO. - 0


SCALE

NTS

DWG NO-01

JANUS DESIGNS


NEAR GANPATI PLAZA, RAILWAY ROAD, HAPUR
Ph:07417857758,09997563895.
EMAIL: Jatinsgoel@gmail.com
WEB: www.janusdesigns.in

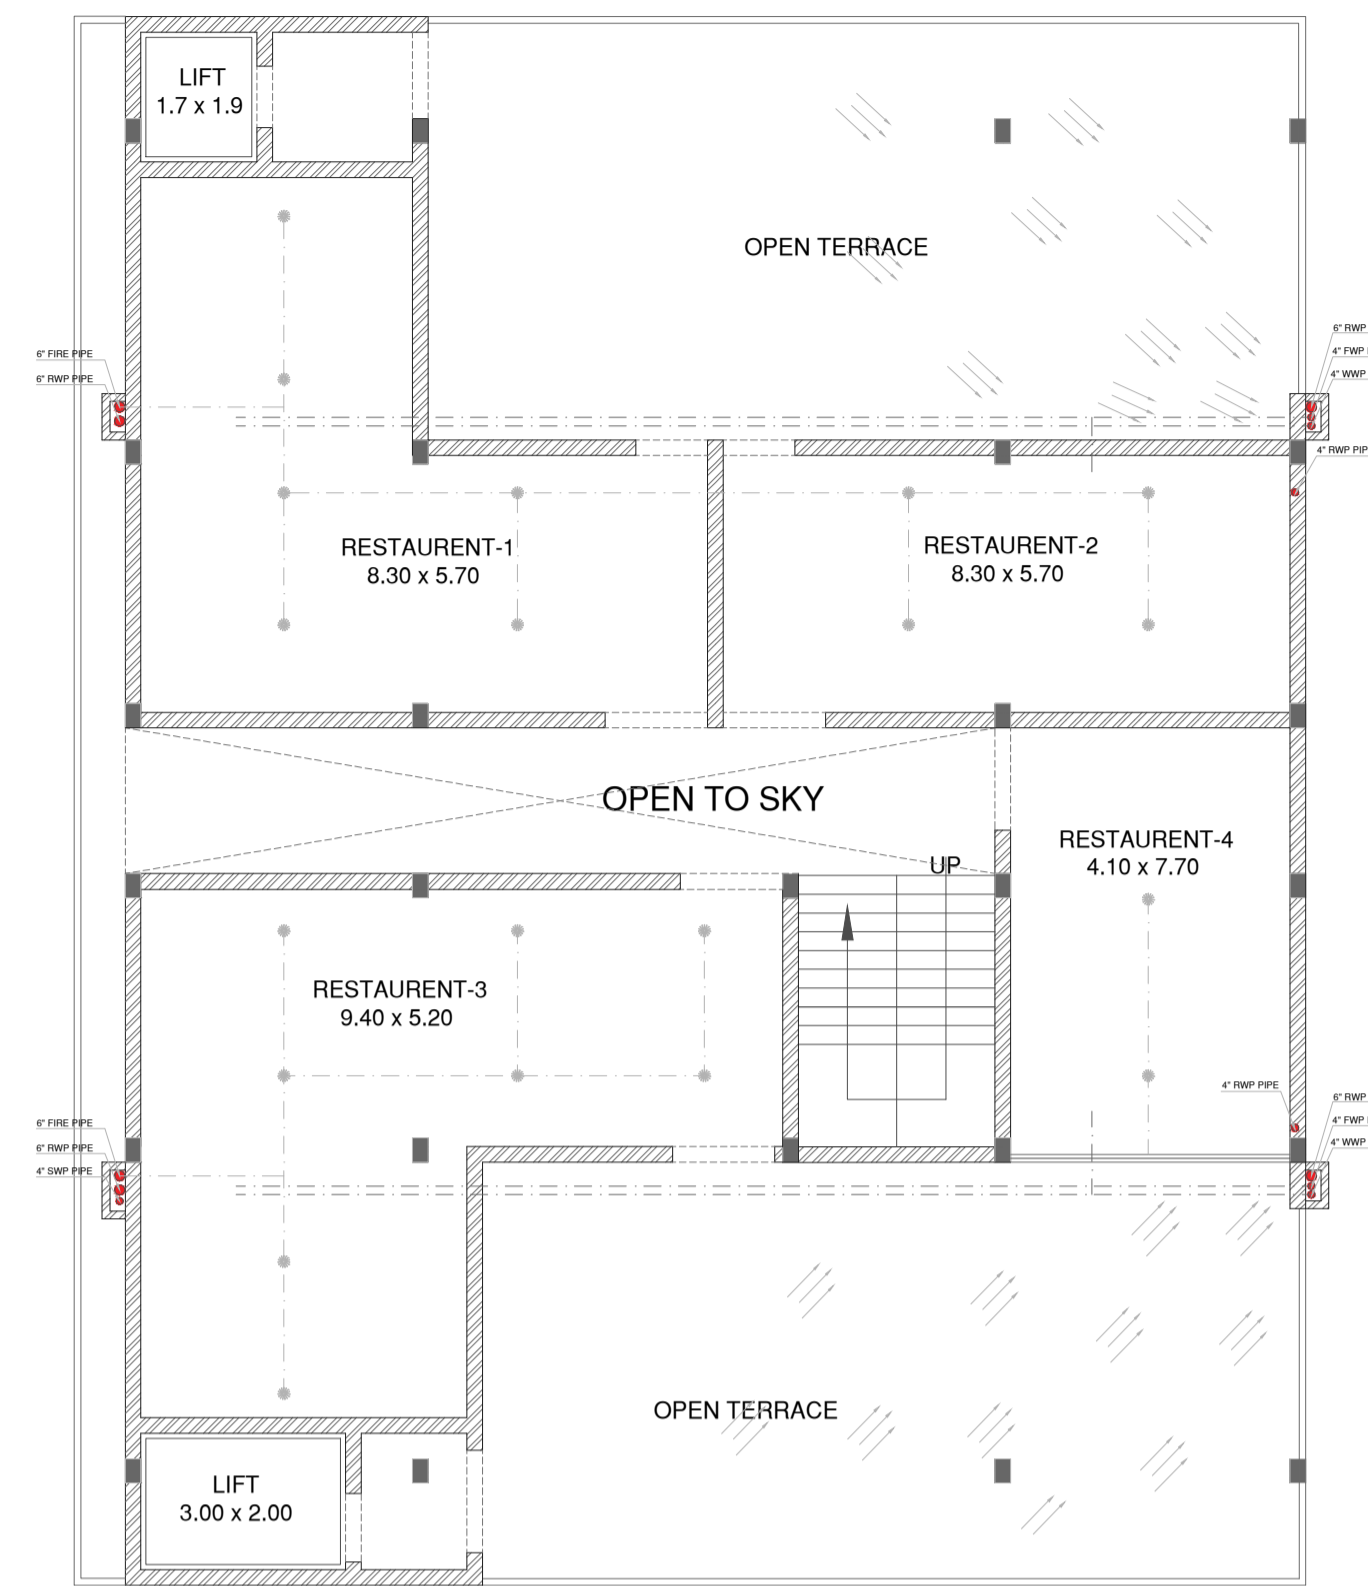


**THIRD FLOOR PLAN
PLUMBING & FIRE SHAFT PLAN**



TERRACE FLOOR PLAN

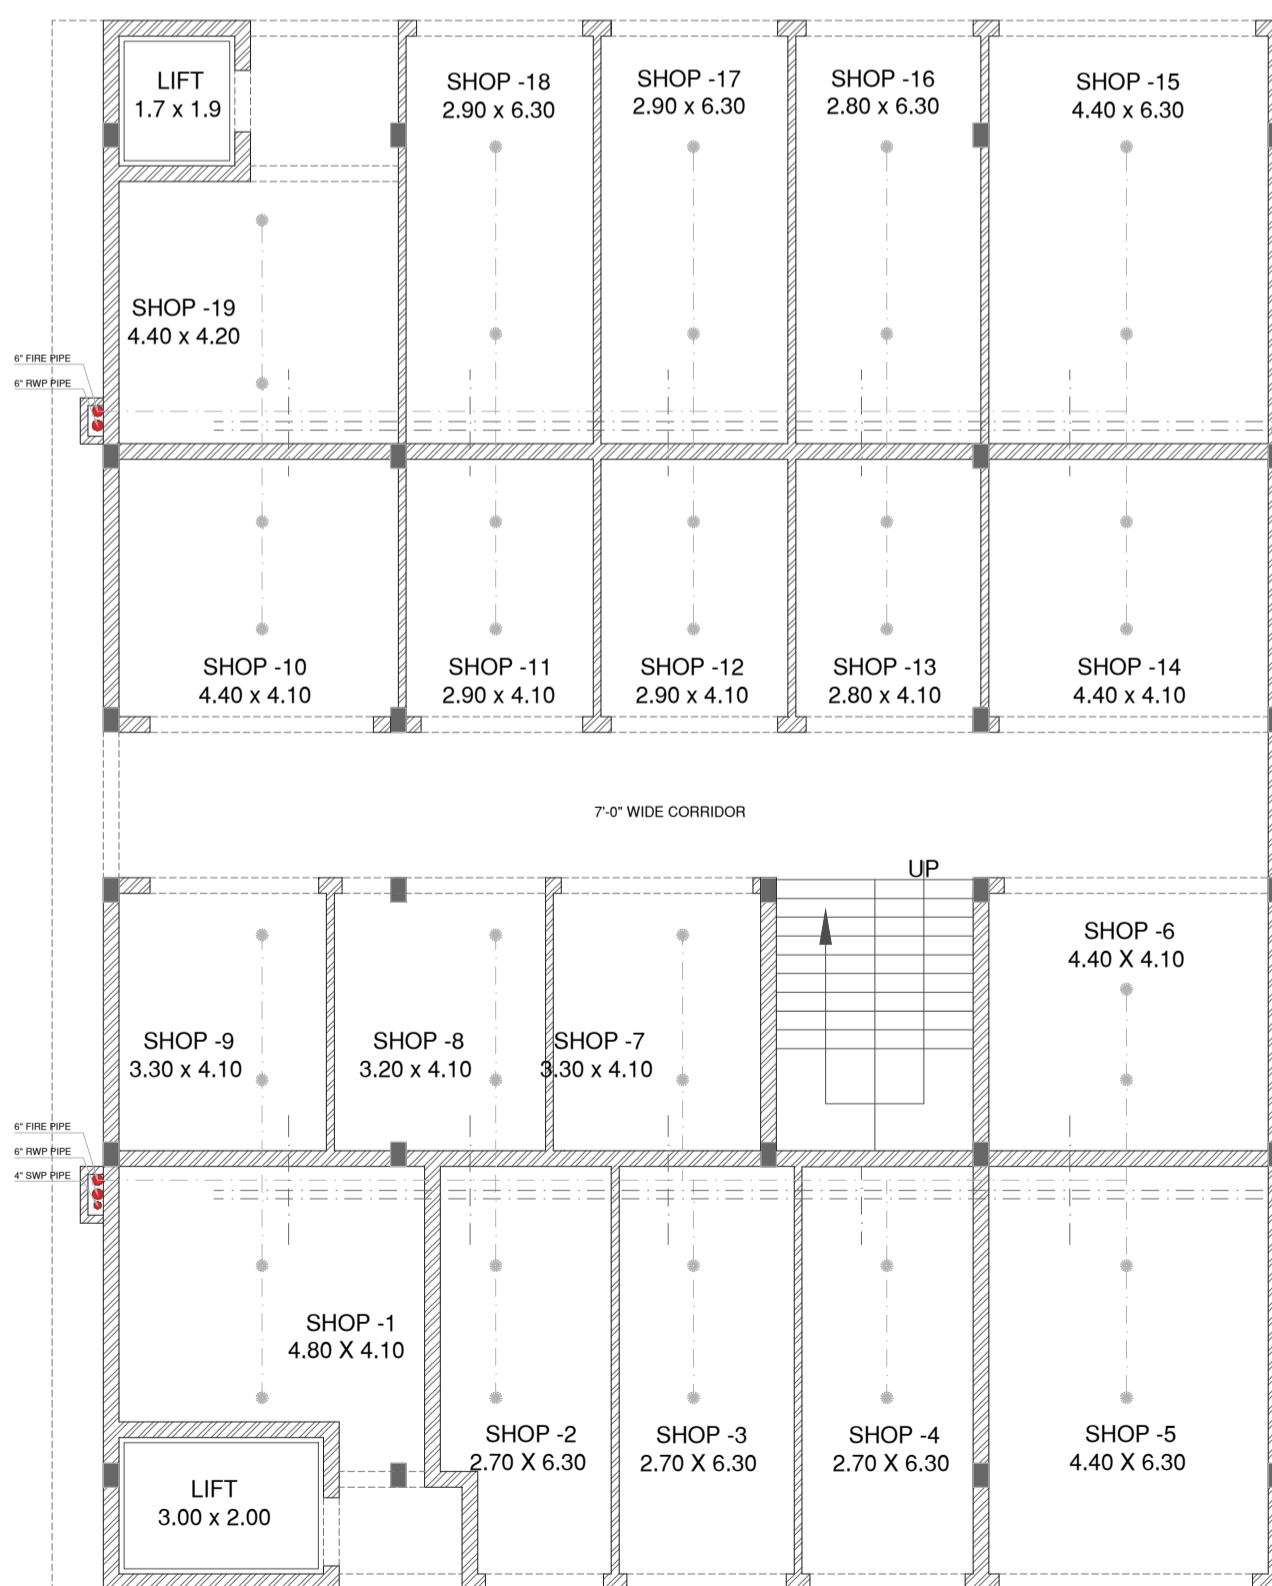


**GROUND FLOOR PLAN
PLUMBING & FIRE SHAFT PLAN**

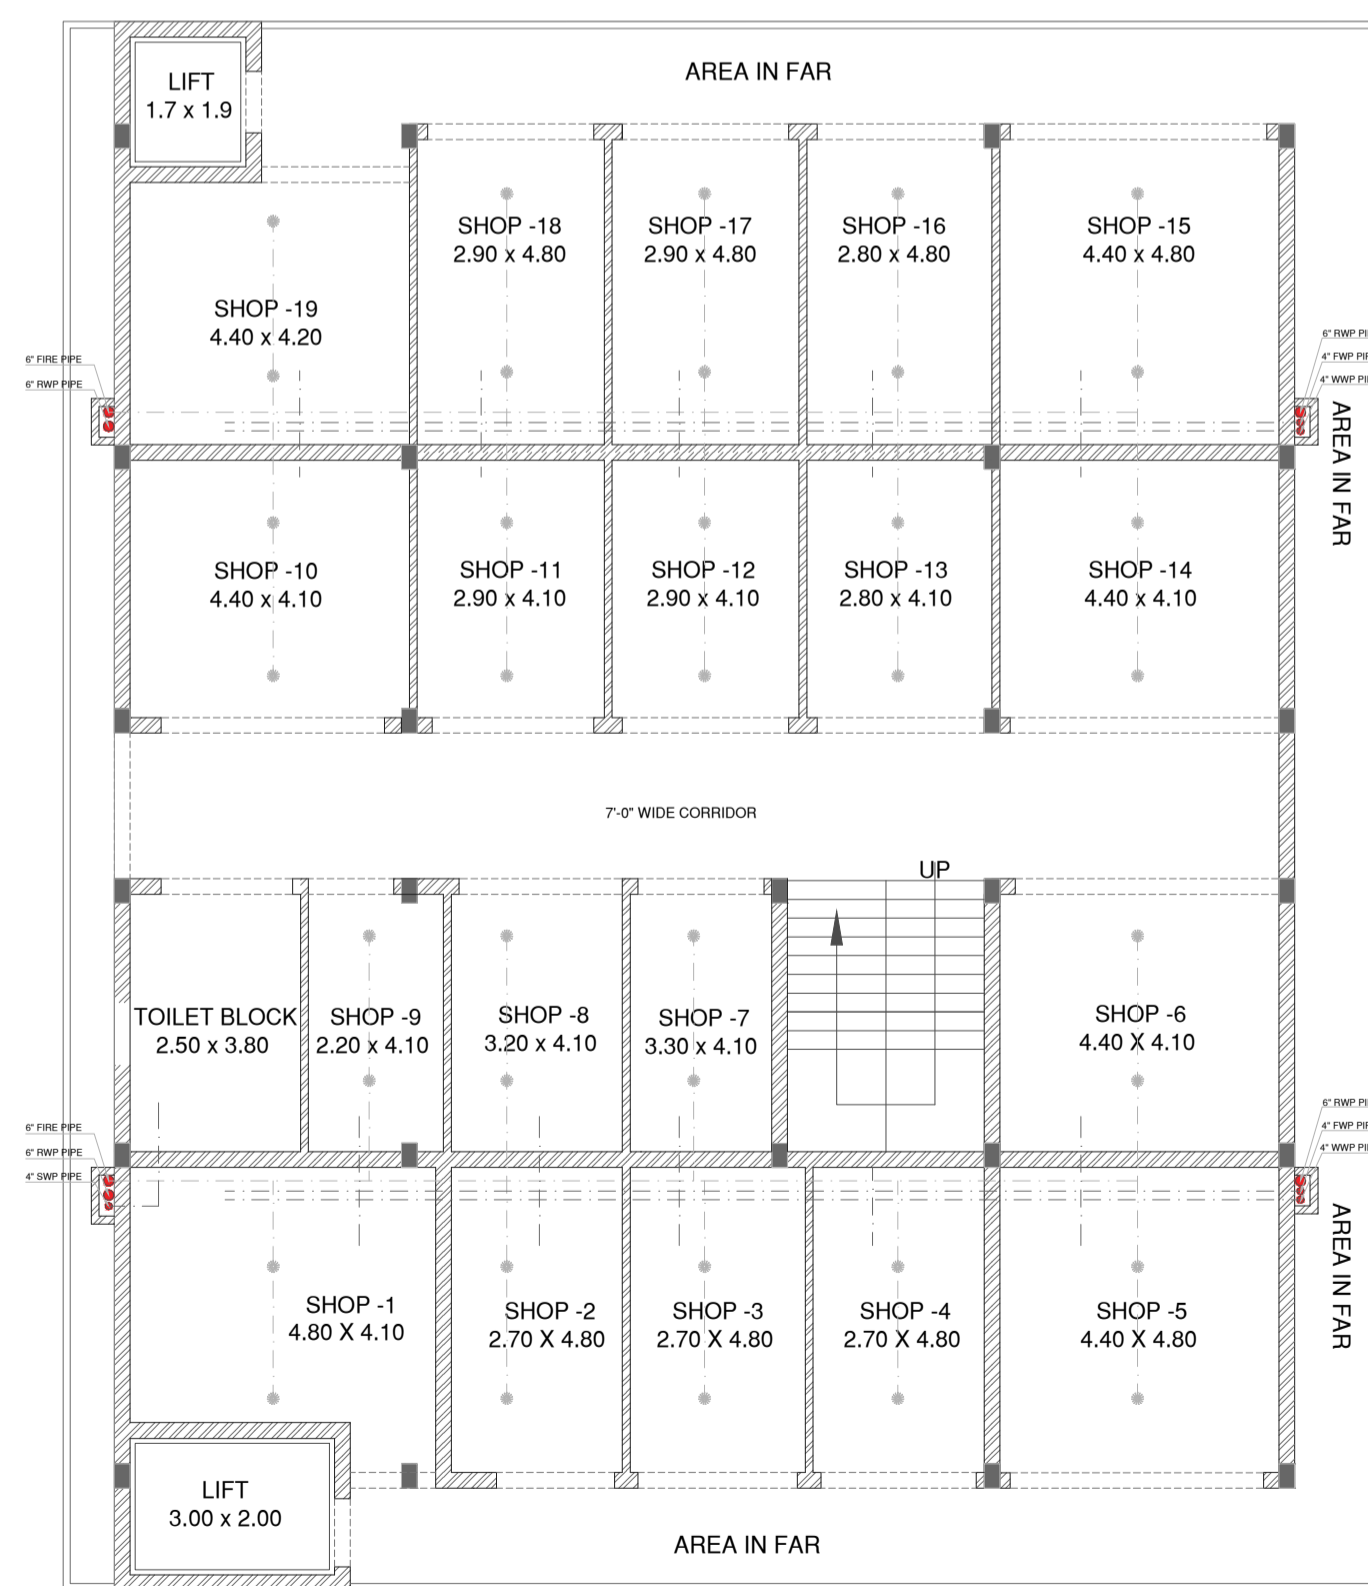


**FIRST FLOOR PLAN
PLUMBING & FIRE SHAFT PLAN**



**SECOND FLOOR PLAN
PLUMBING & FIRE SHAFT PLAN**

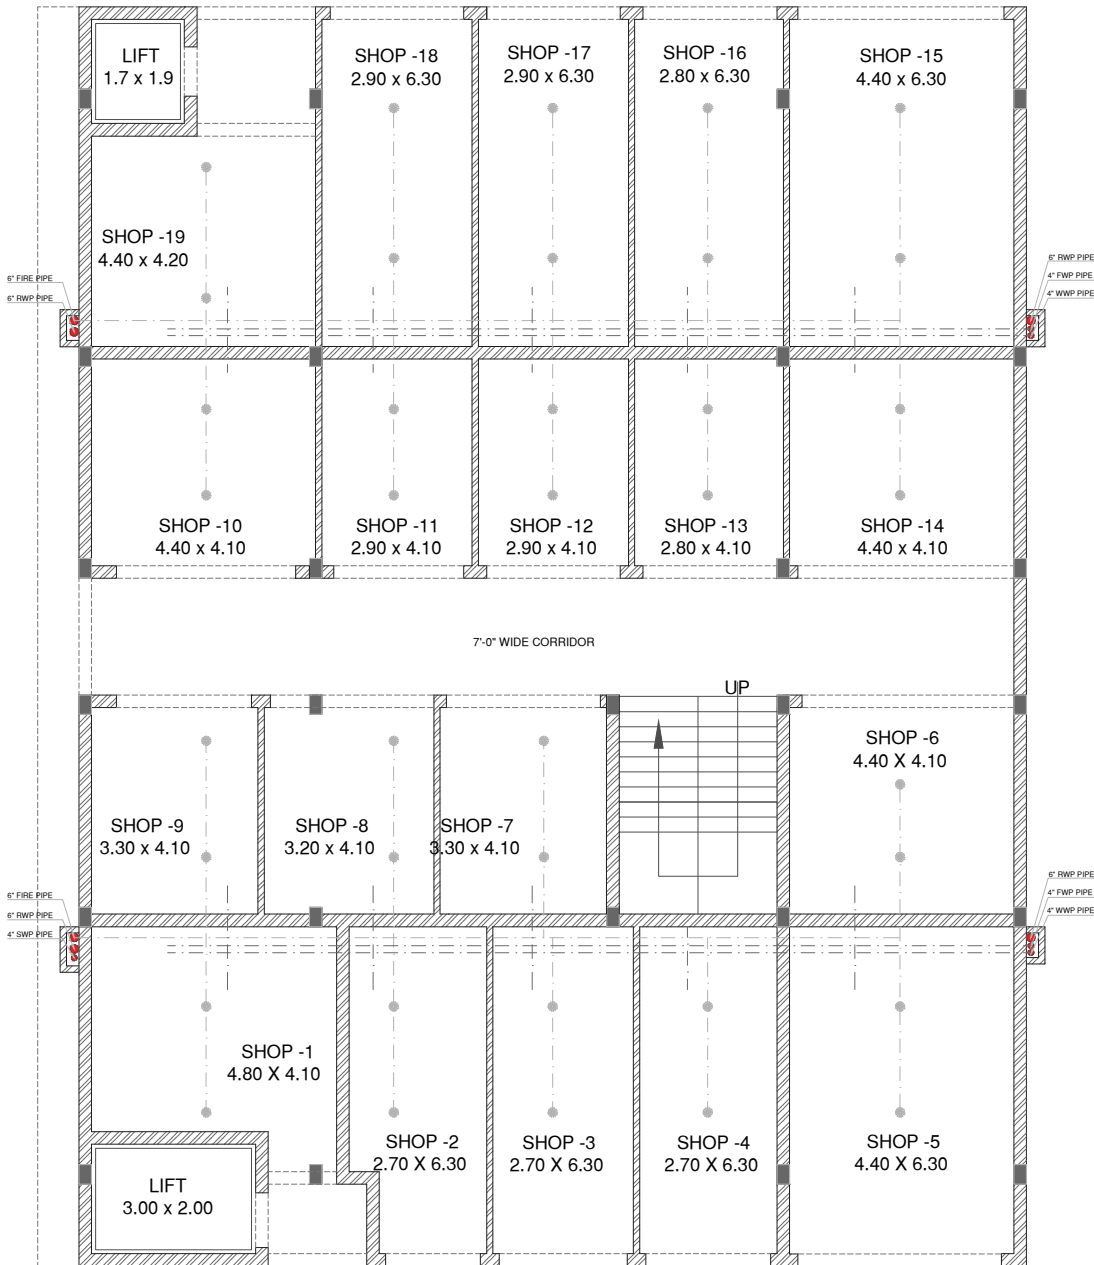

GROUND FLOOR PLAN PLUMBING & FIRE SHAFT PLAN

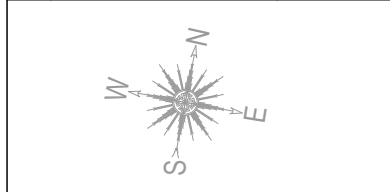

PROJECT
COMMERCIAL

DRAWING TITLE
GROUND FLOOR PLUMBING & FIRE PLAN

DEALT BY
ROHIT SINGH

DATE - 23-05-2024 REVISION NO. - 0

SCALE **DWG NO-01**

NTS
JANUS DESIGNS
NEAR GANPATI PLAZA, RAILWAY ROAD, HAPUR
Ph:07417857758,09997563895.
EMAIL: Jatinsgoel@gmail.com
WEB: www.janusdesigns.in