

PROJECT:-
PROPOSED GROUP HOUSING, of
Narmada Apartment at Sector-4,
Gomti Nagar Extension, Lucknow.

CLIENT:-
LUCKNOW DEVELOPMENT AUTHORITY



LEGEND

	5 TO 10W DOWN LIGHT
	900mm CEILING FAN
	BELL/HOOTER POINT
	WIFI POINT
	MIRROR LIGHT
	9W LED BULB
	20 WTUBE LIGHT
	A.C INDOOR
	A.C OUTDOOR
	GEYSER POINT
	01BA SOCKET WITH SWITCH
	20A AC SOCKET
	INTERCOM POINT
	TV OUTLET 1No OF 8A IN SOCKET & 2Nos OF 8A DEP SOCKET WITH SWITCH
	8A SOCKET (DEP)
	R.O. POINT
	EXHAUST FAN
	SWITCH BOARD
	DISTRIBUTION BOARD
	MCP POINT
	BULLET CAMERA
	VIDEO DISPLAY
	CALL BELL POINT
	NORMAL LIGHT WIRE
	EMERGENCY LIGHT WIRE
	A.C / GEYSER WIRE
	POWER WIRE
	INTERCOM WIRE
	WIFI WIRE
	TV WIRE
	CAMERA WIRE
	DISTRIBUTION BOARD CABLE

DRAWING TITLE

BASEMENT FLOOR PLAN

DRAWING NO.
0825478-RG-01-SB(SRE)-00P01

NORTH 	SCALE AS SHOWN	SHEET NO. 02
		DATE OCT-2025

MUNICIPAL SUBMISSION DRG.

This is to certify that the drawing is prepared as per the Master Plan 2021 of Lucknow & details provided to the architect by the client.



OWNER'S SIGN

ARCHITECT'S SIGN

Anupam Mittal
Shubhra Mittal

ARCHITECTURE
INTERIORS
INFRASTRUCTURE
ENGINEERING
MANAGEMENT

1st Floor Akash B. 31, Gokula Marg,
Lucknow-226001 (U.P.) (INDIA)
Ph: +91 522-4107255
Fax: +91 522-2208500
e-mail: admin@arinem.com

C-7, Green Park Est.
New Delhi-110016 (INDIA)
Ph: +91-11-2202288
e-mail: admin@arinem.com

ARINEM
CONSULTANCY SERVICES PVT.LTD.

PROJECT:-
PROPOSED GROUP HOUSING, of
Narmada Apartment at Sector-4,
Gomti Nagar Extension, Lucknow.

CLIENT:-
LUCKNOW DEVELOPMENT AUTHORITY



LEGEND

	8 TO 10W DOWN LIGHT
	600mm CEILING FAN
	BELL / HOOTER POINT
	WIFI POINT
	MIRROR LIGHT
	9 W LED BULB
	20 WTUBE LIGHT
	A.C.INDOOR
	A.C.OUTDOOR
	GEYSER POINT
	6/16A SOCKET WITH SWITCH
	20A AC SOCKET
	INTERCOM POINT
	TV OUTLET: 1No OF 6A WID SOCKET & 2Nos OF 8A DEP SOCKET WITH SWITCH
	6A SOCKET (DEF)
	R.O. POINT
	EXHAUST FAN
	SWITCH BOARD
	DISTRIBUTION BOARD
	MCP POINT
	BULLET CAMERA
	VIDEO DISPLAY
	CALL BELL POINT
	NORMAL LIGHT WIRE
	EMERGENCY LIGHT WIRE
	A.C / GEYSER WIRE
	POWER WIRE
	INTERCOM WIRE
	WIFI WIRE
	TV WIRE
	CAMERA WIRE
	DISTRIBUTION BOARD CABLE

DRAWING TITLE
PENTHOUSE LEVEL-01
FLOOR PLAN

DRAWING NO.
0825478-RG-01-SB(SRE)-00P06

NORTH 	SCALE AS SHOWN	SHEET NO. 07
		DATE OCT-2025

MUNICIPAL SUBMISSION DRG.

This is to certify that the drawing is prepared as per the Master Plan 2021 of Lucknow & details provided to the architect by the client.



OWNER'S SIGN

ARCHITECT'S SIGN

Anupam Mittal
Shubhra Mittal

ARCHITECTURE
INTERIORS
INFRASTRUCTURE
ENGINEERING
MANAGEMENT

1st Floor Akash B. 31, Gokula Marg,
Lucknow-226001 (U.P.) (INDIA)
Ph: +91 522-4107251
Fax: +91 522-2208500
e-mail: admin@arinem.com

ARINEM
CONSULTANCY SERVICES PVT.LTD.

PROJECT:-
PROPOSED GROUP HOUSING, of
Narmada Apartment at Sector-4,
Gomti Nagar Extension, Lucknow.

CLIENT:-

LUCKNOW DEVELOPMENT AUTHORITY



LEGEND

	5 TO 10W DOWN LIGHT
	600mm CEILING FAN
	BELL / HOOTER POINT
	WIFI POINT
	MIRROR LIGHT
	9 W LED BULB
	20 W TUBE LIGHT
	A.C. INDOOR
	A.C. OUTDOOR
	GEYSER POINT
	6/15A SOCKET WITH SWITCH
	30A AC SOCKET
	INTERCOM POINT
	TV OUTLET 1No OF 6A INDOOR SOCKET & 2Nos OF 8A DEF. SOCKET WITH SWITCH
	8A SOCKET (DEF.)
	R.O. POINT
	EXHAUST FAN
	SWITCH BOARD
	DISTRIBUTION BOARD
	MCP POINT
	BULLET CAMERA
	VIDEO DISPLAY
	CALL BELL POINT
	NORMAL LIGHT WIRE
	EMERGENCY LIGHT WIRE
	A.C. / GEYSER WIRE
	POWER WIRE
	INTERCOM WIRE
	WIFI WIRE
	TV WIRE
	CAMERA WIRE
	DISTRIBUTION BOARD CABLE

DRAWING TITLE

PENTHOUSE LEVEL-02
FLOOR PLAN

DRAWING NO.

0825478-RG-01-SB(SRE)-00P07

NORTH



SCALE

AS SHOWN

SHEET NO.

08

DATE

OCT-2025

MUNICIPAL SUBMISSION DRG.

 
This is to certify that the drawing is prepared as per the Master Plan 2021 of Lucknow & details provided to the architect by the client.



OWNER'S SIGN

ARCHITECT'S SIGN

Anupam Mittal
Shubhra Mittal




1st Floor Akash B. 31, Gokula Marg,
Lucknow-226001 (U.P.) (INDIA)
Ph: +91 522-4107255
Fax: +91 522-2208000
e-mail: admin@arinem.com

C-7, Green Park Est.
New Delhi-110016 (INDIA)
Ph: +91-11-2202288
e-mail: admin@arinem.com


ARINEM
CONSULTANCY SERVICES PVT.LTD.

UNIT-TYPE-1

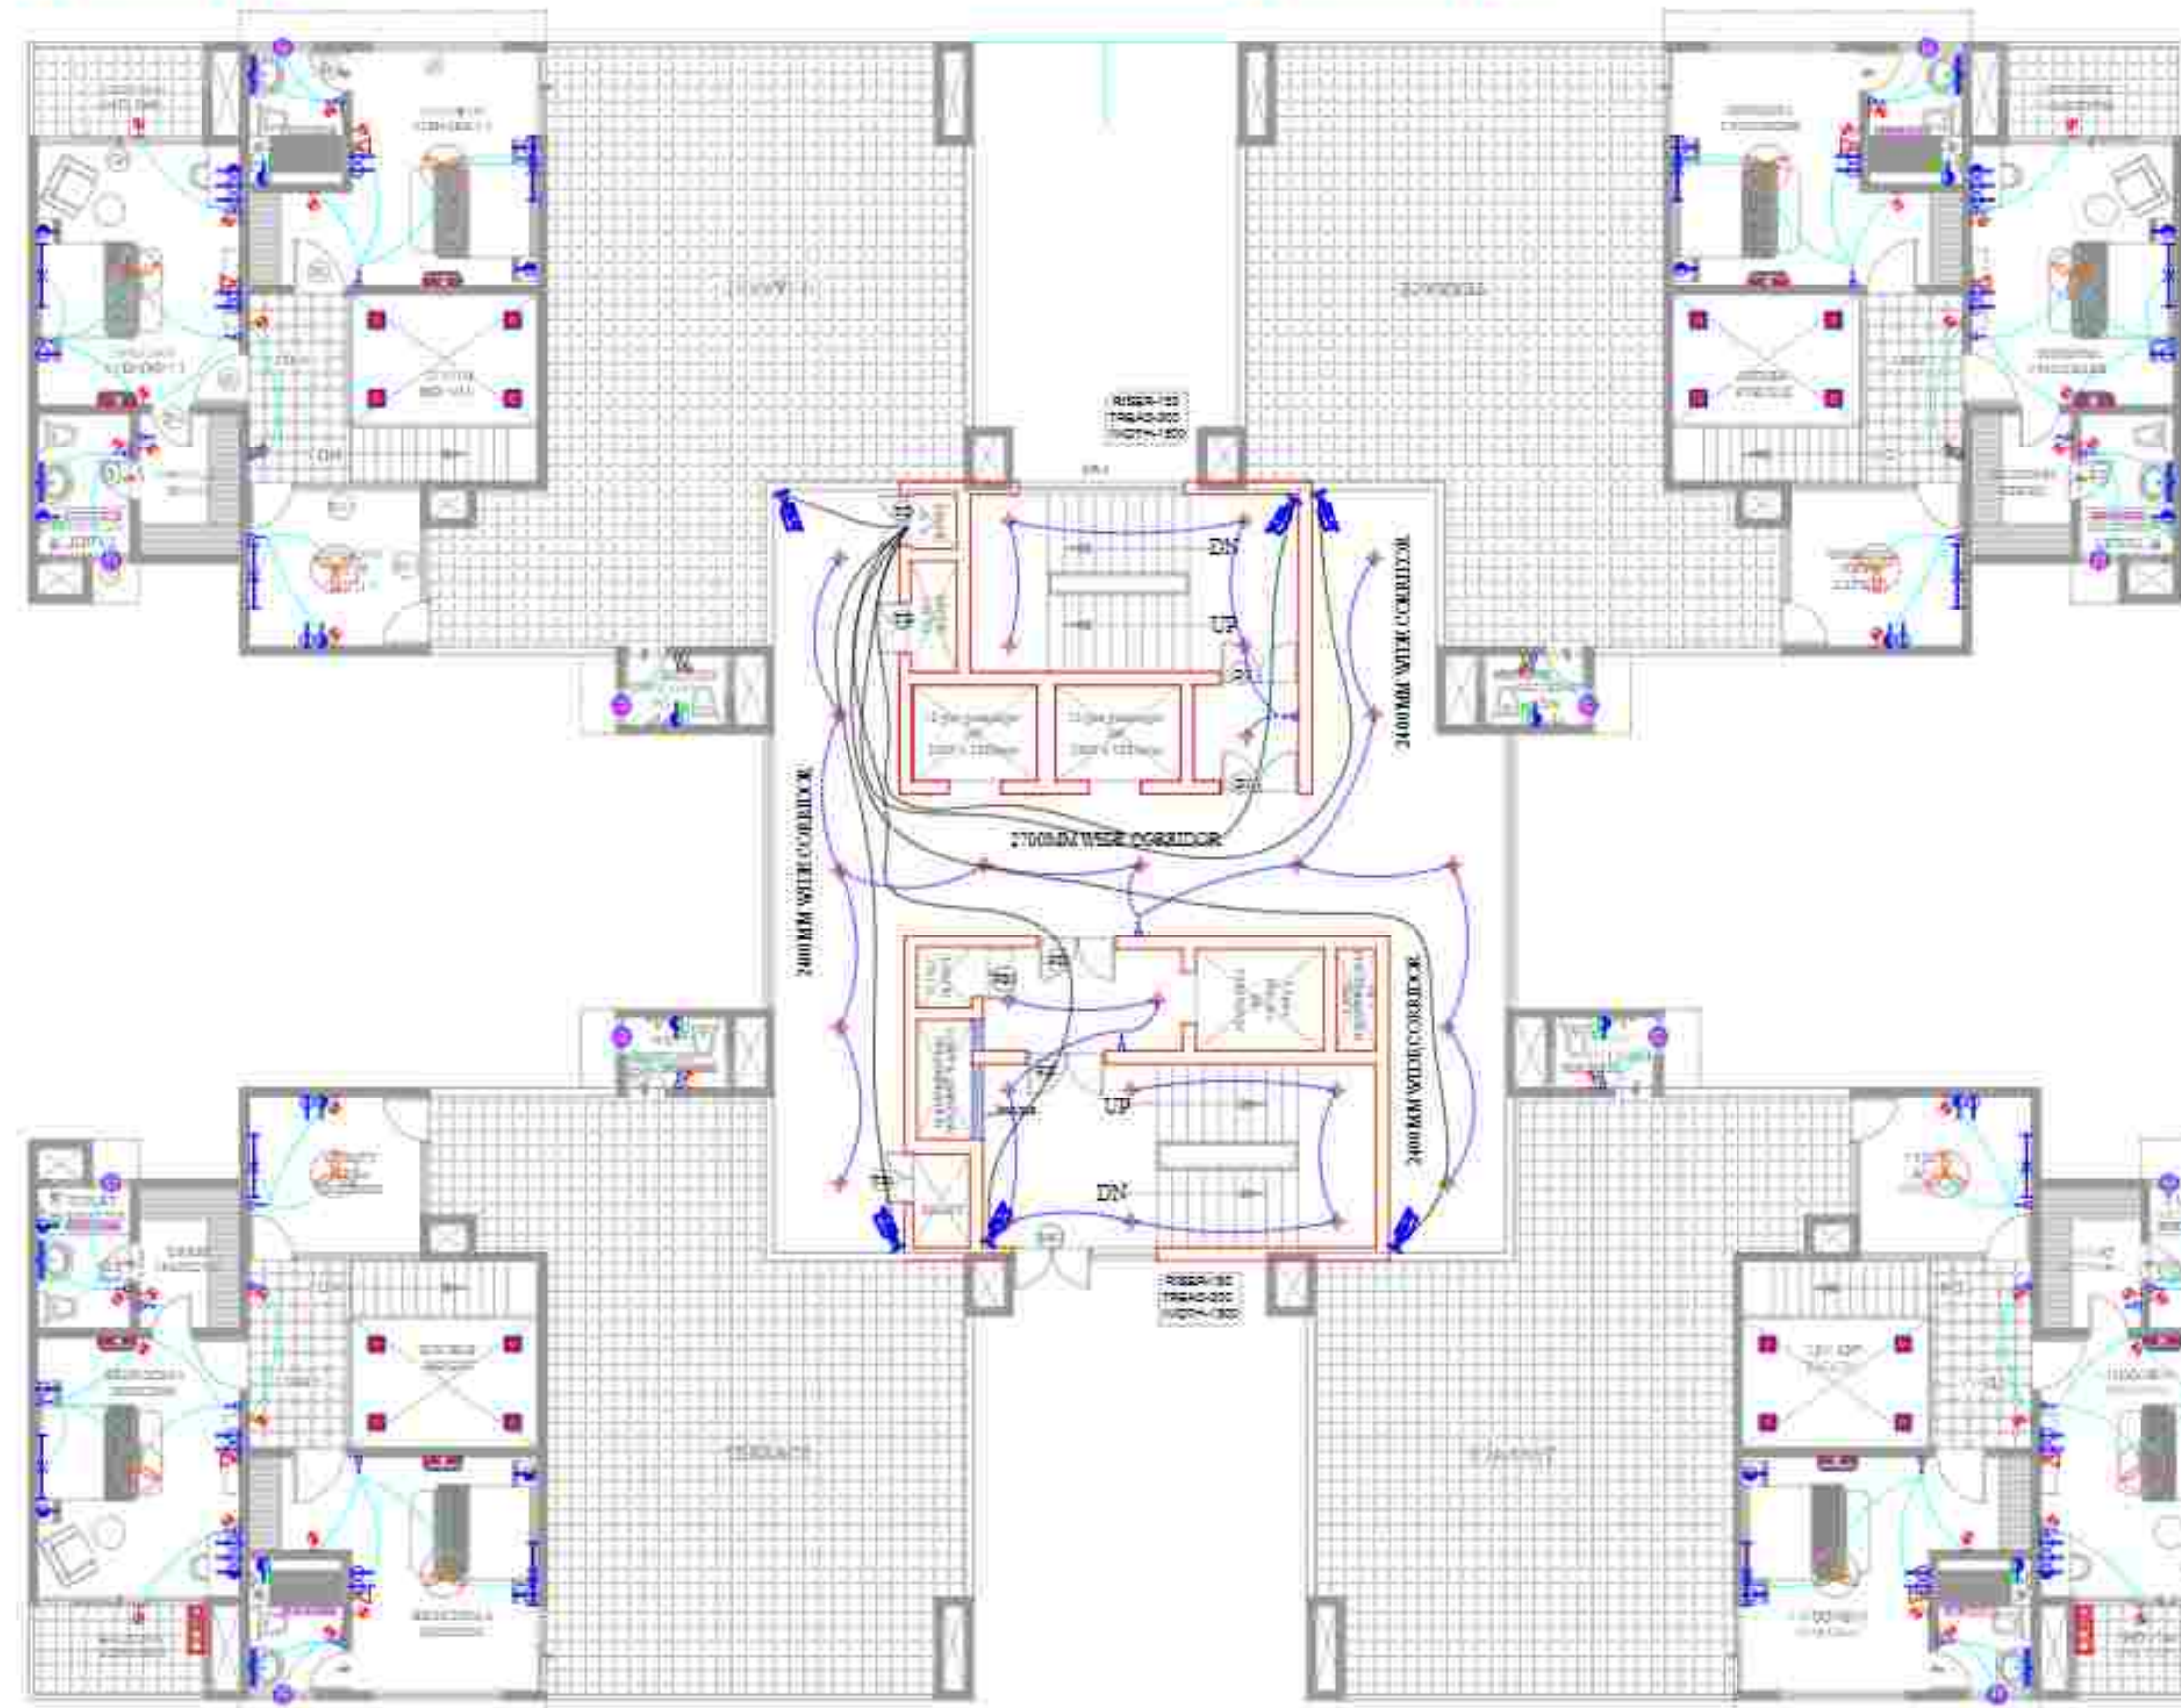


UNIT-TYPE-1

UNIT-TYPE-1

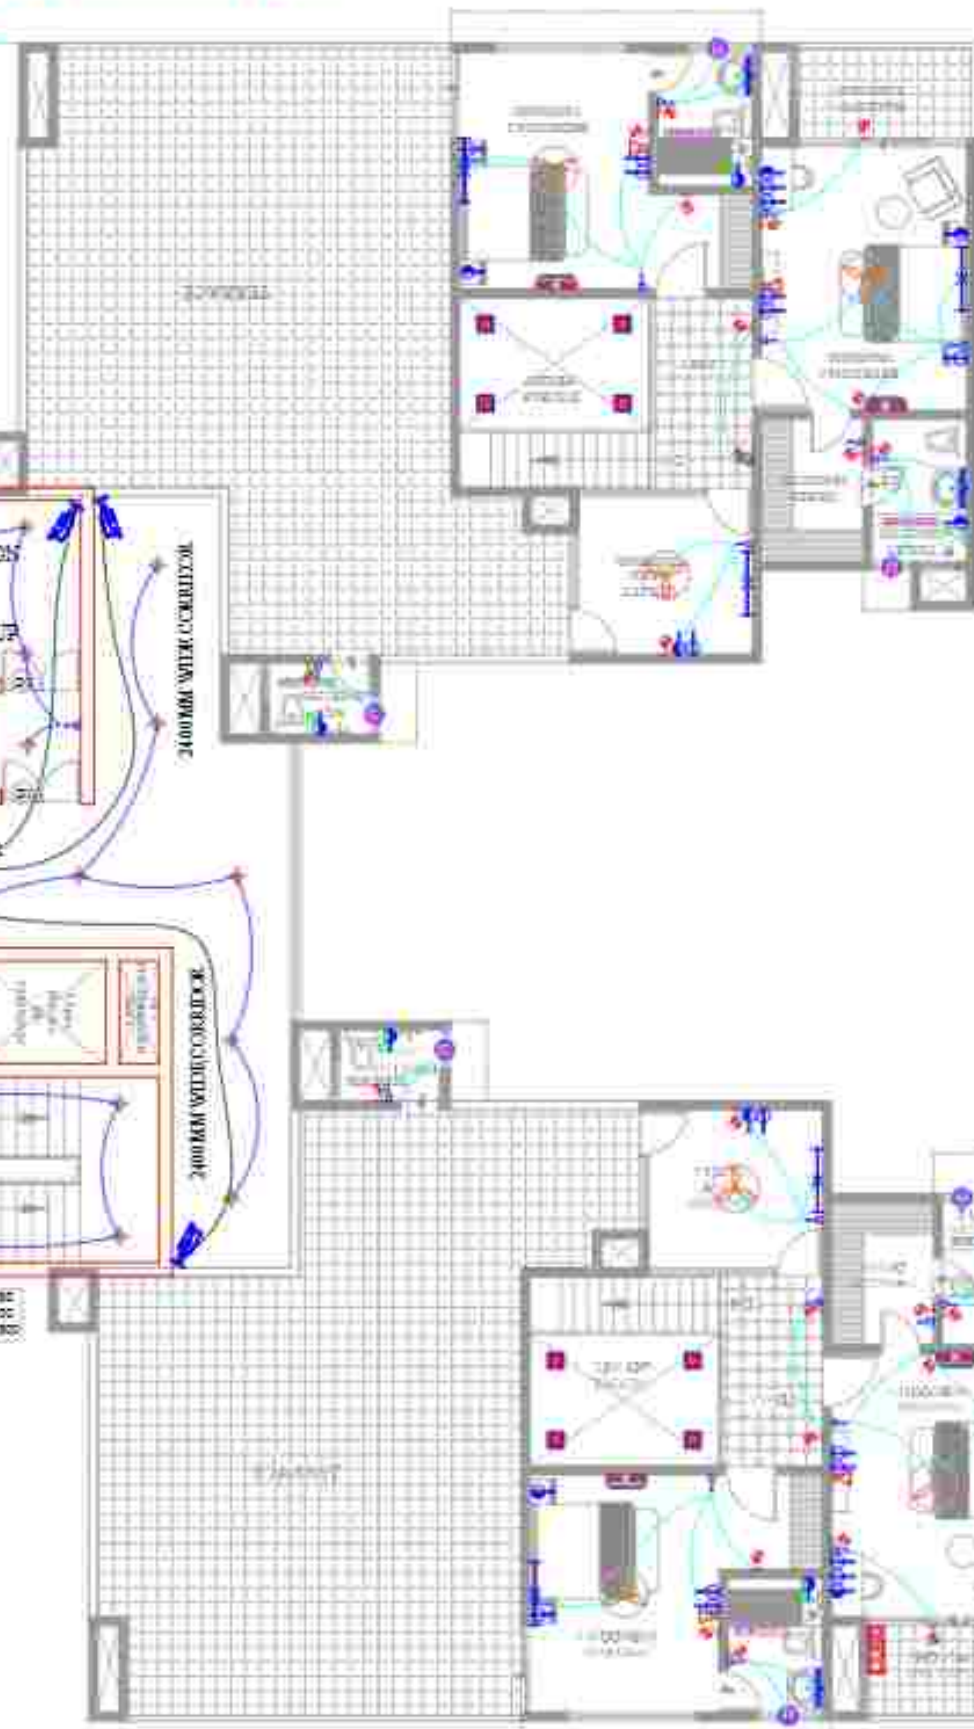


UNIT-TYPE-1

UNIT-TYPE-1

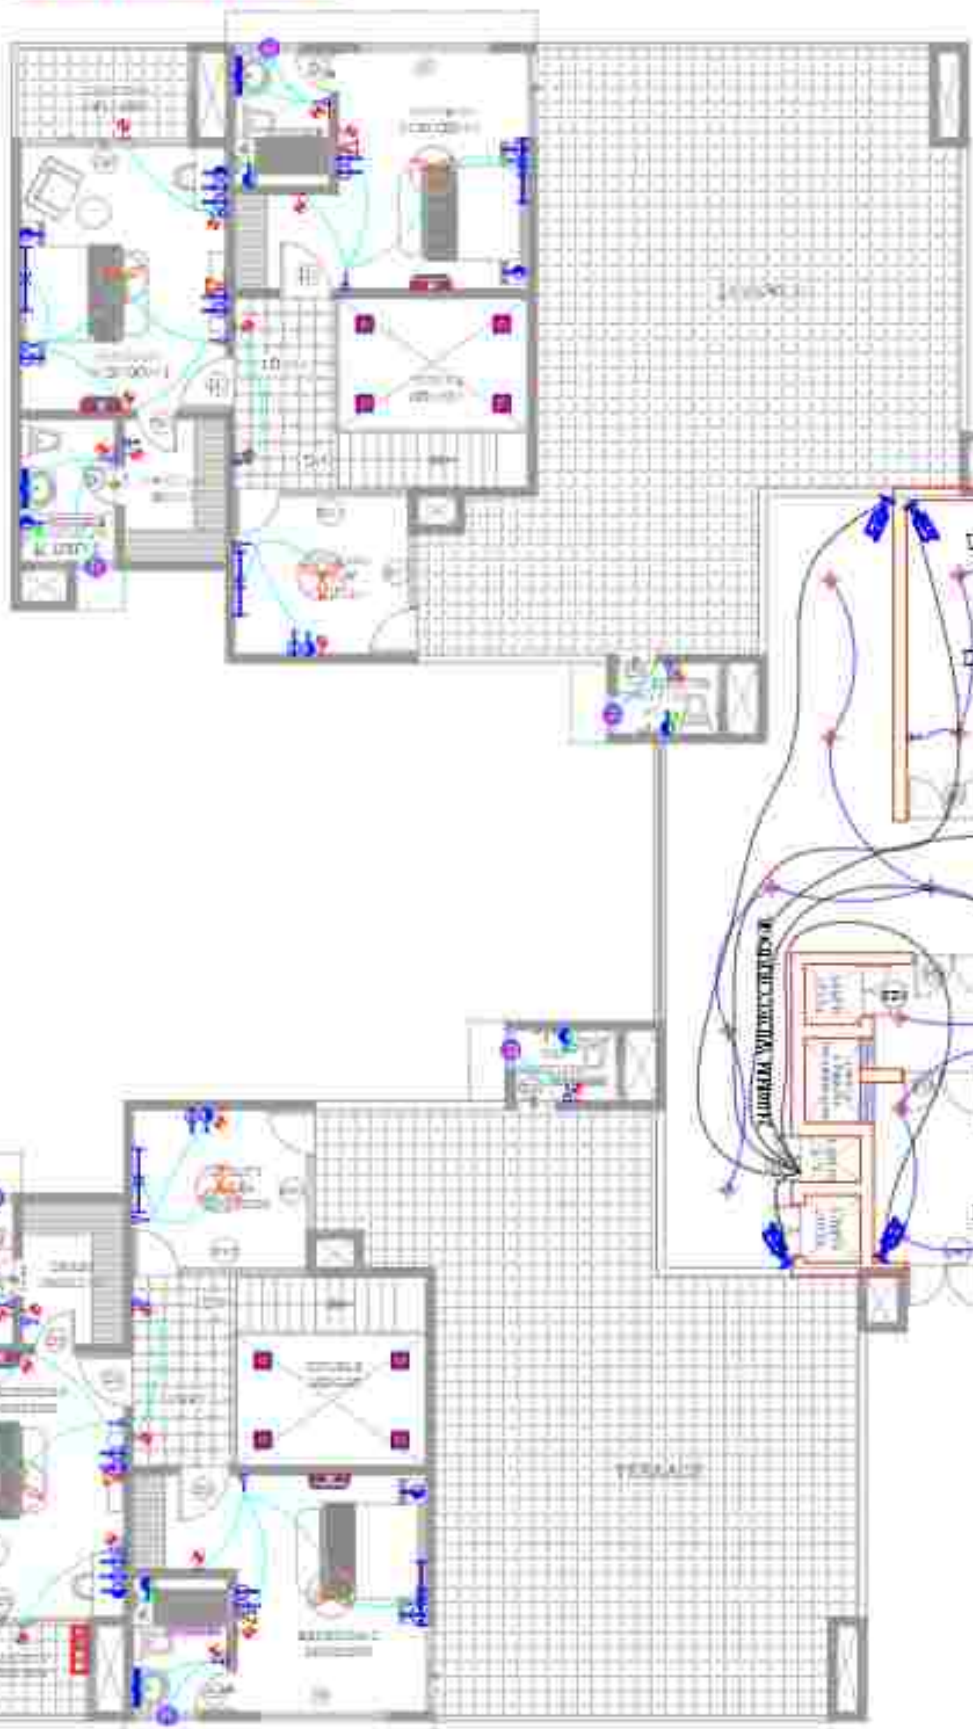


UNIT-TYPE-1

UNIT-TYPE-2

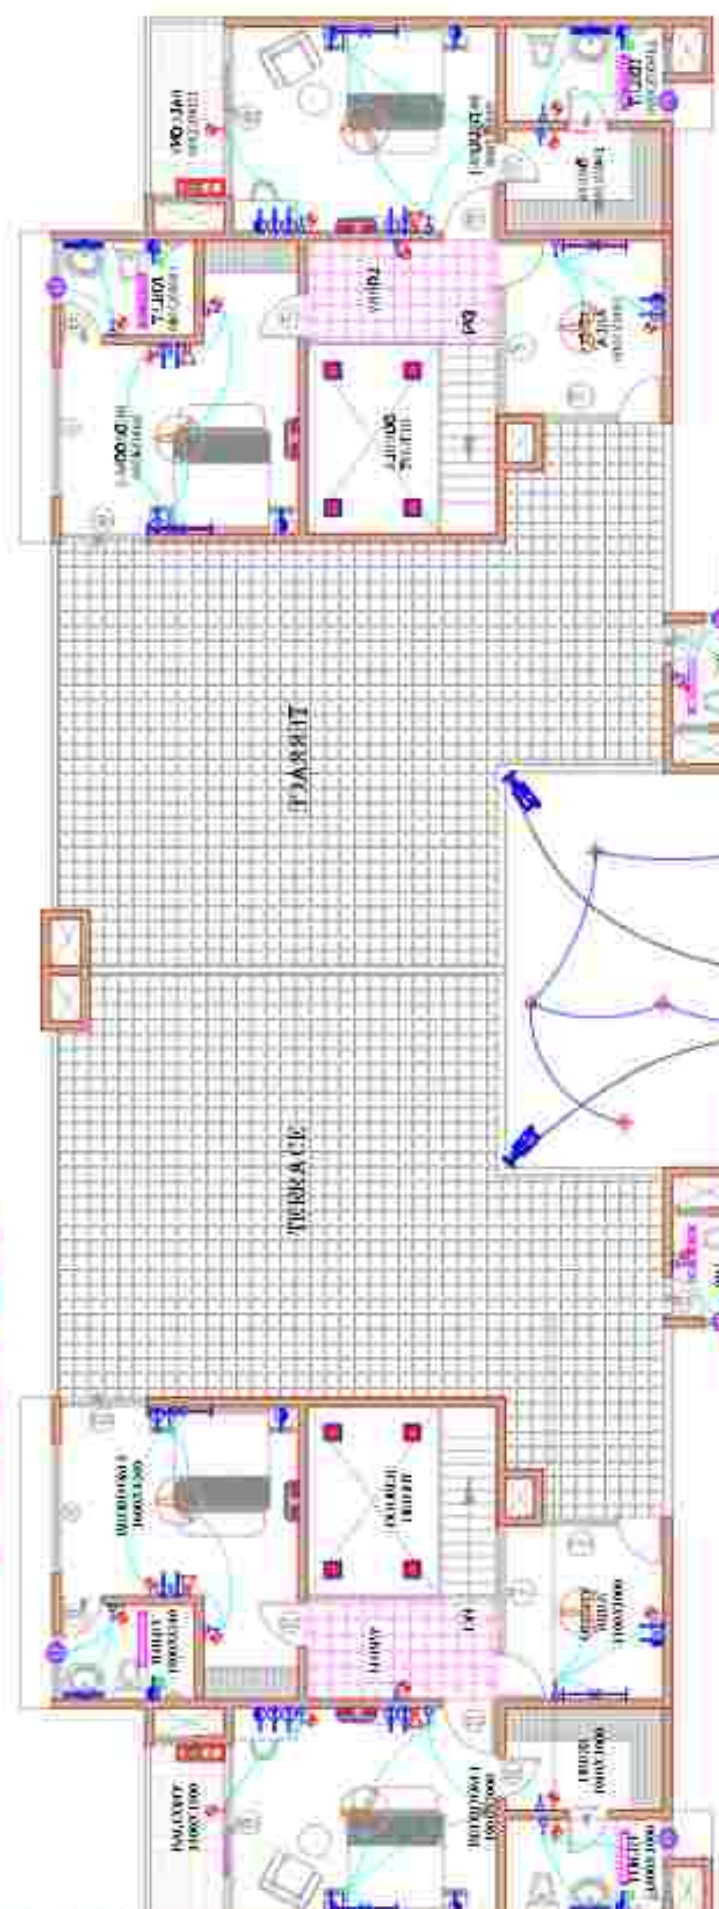

UNIT-TYPE-2

UNIT-TYPE-2

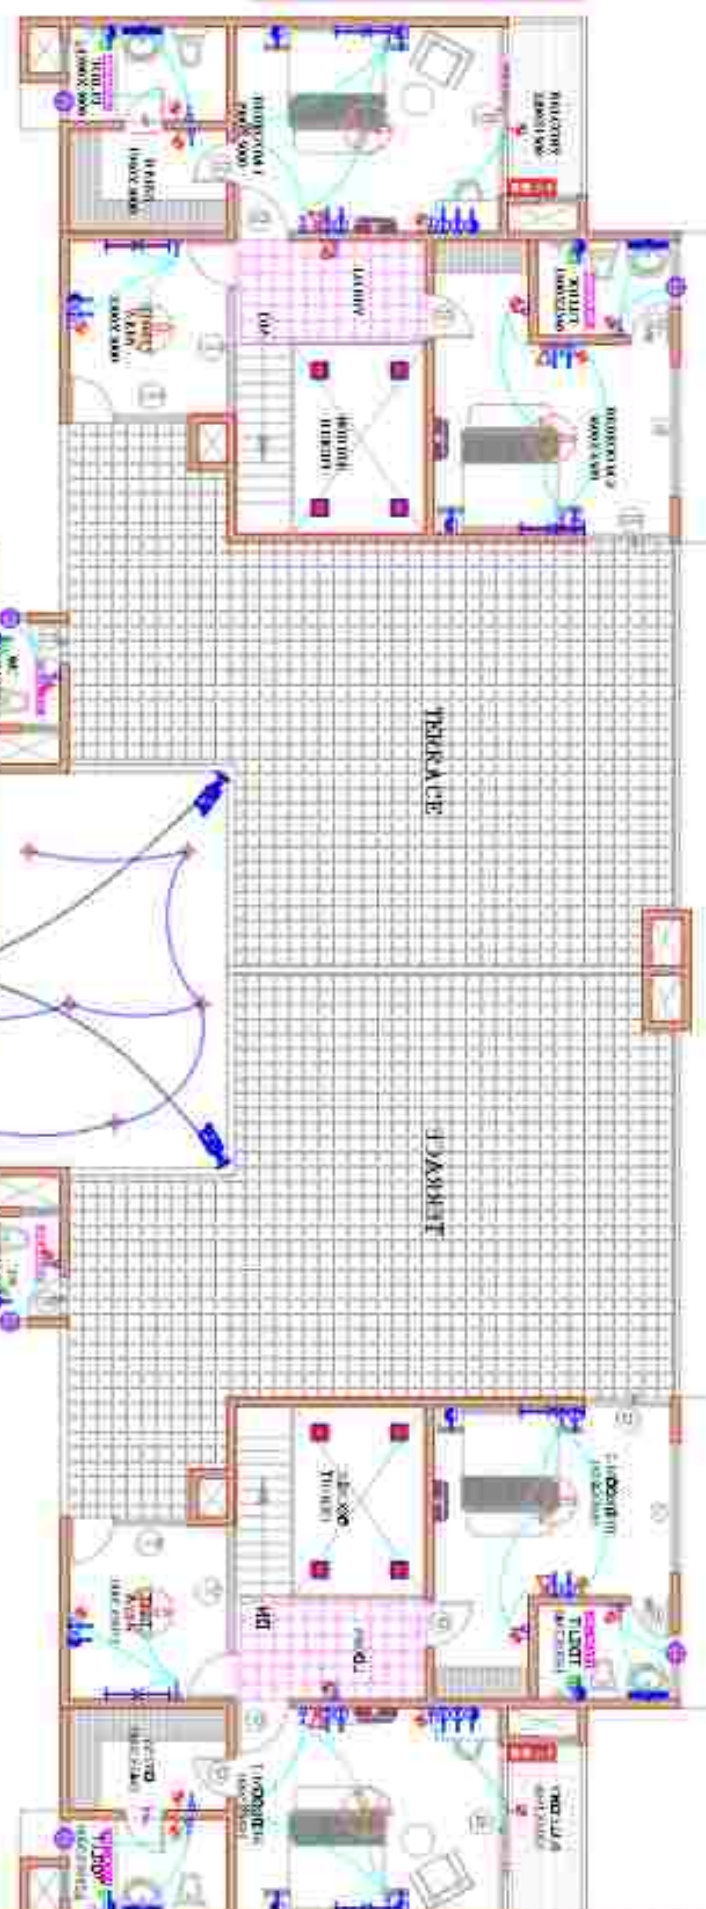

UNIT-TYPE-2

50MM EXPANSION
JOINT

PROJECT:-
PROPOSED GROUP HOUSING, of
Narmada Apartment at Sector-4,
Gomti Nagar Extension, Lucknow.

CLIENT:-

LUCKNOW DEVELOPMENT AUTHORITY



LEGEND

	5 TO 10W DOWN LIGHT
	900mm CEILING FAN
	BELL / HOOTER POINT
	WIFI POINT
	MIRROR LIGHT
	9 W LED BULB
	20 W TUBE LIGHT
	A.C. INDOOR
	A.C. OUTDOOR
	GEYSER POINT
	1/4 BA SOCKET WITH SWITCH
	20A AC SOCKET
	INTERCOM POINT
	TV OUTLET, 1 No. OF BA AND SOCKET & 2 Nos. OF BA DEF. SOCKET WITH SWITCH
	BA SOCKET (DEF)
	R.O. POINT
	EXHAUST FAN
	SWITCH BOARD
	DISTRIBUTION BOARD
	MCP POINT
	BULLET CAMERA
	VIDEO DISPLAY
	CALL BELL POINT
	NORMAL LIGHT WIRE
	EMERGENCY LIGHT WIRE
	A.C. / GEYSER WIRE
	POWER WIRE
	INTERCOM WIRE
	WIFI WIRE
	TV WIRE
	CAMERA WIRE
	DISTRIBUTION BOARD CABLE

DRAWING TITLE

PODIUM FLOOR PLAN

DRAWING NO.

0825478-RG-01-SB(SRE)-00P03

NORTH



SCALE

AS SHOWN

SHEET NO.

04

DATE

OCT-2025

MUNICIPAL SUBMISSION DRG.

This is to certify that the drawing is prepared as per the Master Plan 2021 of Lucknow & details provided to the architect by the client.



OWNER'S SIGN

ARCHITECT'S SIGN

Anupam Mittal
Shubhra Mittal

ARCHITECTURE
INTERIORS
INFRASTRUCTURE
ENGINEERING
MANAGEMENT

1st Floor Akash B. 31, Gokula Marg,
Lucknow-226001 (U.P.) (INDIA)
Ph. +91 522-410725
Fax. +91 522-220800
e-mail: admin@arinem.com

C-7, Green Park Est.
New Delhi-110028 (INDIA)
Ph. +91-11-2202288
e-mail: admin@arinem.com

ARINEM
CONSULTANCY SERVICES PVT.LTD.

LUCKNOW DEVELOPMENT AUTHORITY

	5 TO 10W DOWN LIGHT
	900mm CEILING FAN
	BELL / HOOTER POINT
	WIFI POINT
	MIRROR LIGHT
	9 W LED BULB
	20 W TUBE LIGHT
	A.C. INDOOR
	A.C. OUTDOOR
	GEYSER POINT
	8/15A SOCKET WITH SWITCH
	20A AC SOCKET
	INTERCOM POINT
	TV OUTLET, 1No OF 6A IND SOCKET & 2Nos OF 8A DEF SOCKET WITH SWITCH
	6A SOCKET (DEF)
	R.D. POINT
	EXHAUST FAN
	SWITCH BOARD
	DISTRIBUTION BOARD
	MCP POINT
	BULLET CAMERA
	VIDEO DISPLAY
	CALL BELL POINT
	NORMAL LIGHT WIRE
	EMERGENCY LIGHT WIRE
	A.C. / GEYSER WIRE
	POWER WIRE
	INTERCOM WIRE
	WIFI WIRE
	TV WIRE
	CAMERA WIRE
	DISTRIBUTION BOARD CABLE

	SCALE	SHEET NO.
	AS SHOWN	06
		DATE
		OCT-2025

This is to certify that the drawing is prepared as per the Master Plan 2021 of Lucknow & details provided to the architect by the client.



ARCHITECT'S SIGN

	1st Floor, Akash II, 31, Gokhale Marg, Lucknow-226001 UP (INDIA) Ph: +91-522-4147212 Fax: +91-522-2358930 e-mail: admin@arinem.com	C-7, Green Park Ext., New Delhi-110016 (INDIA) Ph: +91-11-2552529 E-mail: admin@arinem.com
ARCHITECTURE INTERIORS INFRASTRUCTURE ENGINEERING MANAGEMENT	ARINEM CONSULTANCY SERVICES PVT.LTD.	



PROJECT:-
PROPOSED GROUP HOUSING, of
Narmada Apartment at Sector-4,
Gomti Nagar Extension, Lucknow.

CLIENT:-
LUCKNOW DEVELOPMENT AUTHORITY



LEGEND

	5 TO 10W DOWN LIGHT
	600mm CEILING FAN
	BELL / HOOTER POINT
	WIFI POINT
	MIRROR LIGHT
	9W LED BULB
	20 W TUBE LIGHT
	A.C INDOOR
	A.C OUTDOOR
	GEYSER POINT
	0/15A SOCKET WITH SWITCH
	20A AC SOCKET
	INTERCOM POINT
	TV OUTLET 1No OF 8A IN SOCKET & 2Nos OF 8A DEP SOCKET WITH SWITCH
	8A SOCKET (DEP)
	R.O. POINT
	EXHAUST FAN
	SWITCH BOARD
	DISTRIBUTION BOARD
	MCP POINT
	BULLET CAMERA
	VIDEO DISPLAY
	CALL BELL POINT
	NORMAL LIGHT WIRE
	EMERGENCY LIGHT WIRE
	A.C / GEYSER WIRE
	POWER WIRE
	INTERCOM WIRE
	WIFI WIRE
	TV WIRE
	CAMERA WIRE
	DISTRIBUTION BOARD CABLE

DRAWING TITLE

STILT FLOOR PLAN

DRAWING NO.
0825478-RG-01-SB(SRE)-00P02

NORTH	SCALE	SHEET NO.
	AS SHOWN	03
		DATE
		OCT-2025

MUNICIPAL SUBMISSION DRG.

This is to certify that the drawing is prepared as per the Master Plan 2021 of Lucknow & details provided to the architect by the client.



OWNER'S SIGN

ARCHITECT'S SIGN

Anupam Mittal
Shubhra Mittal

1st Floor Akash B. 31, Gokula Marg,
Lucknow-226001 (U.P.) (INDIA)
Ph: +91 522-4107255
Fax: +91 522-2208500
e-mail: admin@arinem.com

ARCHITECTURE
INTERIORS
INFRASTRUCTURE
ENGINEERING
MANAGEMENT

ARINEM
CONSULTANCY SERVICES PVT.LTD.



LUCKNOW DEVELOPMENT AUTHORITY

	5 TO 10W DOWN LIGHT
	600mm CEILING FAN
	BELL / GONG POINT
	WIFI POINT
	MIRROR LIGHT
	9 W LED BULB
	20 W TUBE LIGHT
	A.C. INDOOR
	A.C. OUTDOOR
	GEYSER POINT
	6/15A SOCKET WITH SWITCH
	20AAC SOCKET
	INTERCOM POINT
	TV OUTLET, 1No. OF 6A IN/OUT SOCKET & 2Nos. OF 6A DEP. SOCKET WITH SWITCH
	6A SOCKET (DEP)
	R.O. TAP
	EXHAUST FAN
	SWITCH BOARD
	DISTRIBUTION BOARD
	MCP POINT
	BULLET CAMERA
	VIDEO DISPLAY
	CALL BELL POINT
	NORMAL LIGHT WIRE
	EMERGENCY LIGHT WIRE
	A.C. / GEYSER WIRE
	POWER WIRE
	INTERCOM WIRE
	WIFI WIRE
	TV WIRE
	CAMERA WIRE
	DISTRIBUTION BOARD CABLE

TERRACE FLOOR PLAN

0825478-RG-01-SB(SRE)-00P08



AS SHOV

08

OCT-2025

This is to certify that the drawing is prepared as per the Master Plan 2021 of Lucknow & details provided to the architect by the client.



ARCHITECT'S SIGN

1st Floor Akash II, 31, Gokhale Marg,
Lucknow-226001 UP (INDIA)
Ph: +91 522-4107252
Fax: +91 522-2508050
e-mail: admin@arjuncam.com

C-7, Green Park Ext.
New Delhi-110016 (INDIA)
Ph: 011-41502599
E-mail: arjun@arjun.com

ARCHITECTURE

INTERIORS	PROJECT MANAGEMENT	
INFRASTRUCTURE		
ENGINEERING		
MANAGEMENT		



LUCKNOW DEVELOPMENT AUTHORITY

	3 TO 10W DOWN LIGHT
	900mm CEILING FAN
	BELL / HOOTER POINT
	WIFI POINT
	MIRROR LIGHT
	9 W LED BULB
	20 W TUBE LIGHT
	A.C. INDOOR
	A.C. OUTDOOR
	GEYSER POINT
	818A SOCKET WITH SWITCH
	20A AC SOCKET
	INTERCOM POINT
	TV OUTLET, 1No of 8A IN/OUT SOCKET & 2Nos of 8A DEP SOCKET WITH SWITCH
	8A SOCKET (DEP)
	R.O. POINT
	EXHAUST FAN
	SWITCH BOARD
	DISTRIBUTION BOARD
	MCP POINT
	BULLET CAMERA
	VIDEO DISPLAY
	CALL BELL POINT
	NORMAL LIGHT WIRE
	EMERGENCY LIGHT WIRE
	A.C. / GEYSER WIRE
	POWER WIRE
	INTERCOM WIRE
	WIFI WIRE
	TV WIRE
	CAMERA WIRE
	DISTRIBUTION BOARD CABLE

0825478-RG-01-SB(SRE)-00P04



AS SHOWN

05

DATE _____

OCT-2025

This is to certify that the drawing is prepared as per the Master Plan 2021 of Lucknow & details provided to the architect by the client.



ARCHITECT'S SIGN

C-7, Green Park Est.
New York 11201 (800) 224-
PR 013-41500259.
E-mail: 3000@att.net

ARCHITECTURE INTERIORS	PH: +91 522-4101251 Fax: +91 522-2308650 e-mail: admin@arinem.com	PH: 074-4122259 E-mail: admin@arinem.com
INFRASTRUCTURE ENGINEERING MANAGEMENT	 ARINEM CONSULTANCY SERVICES PVT.LTD.	

