


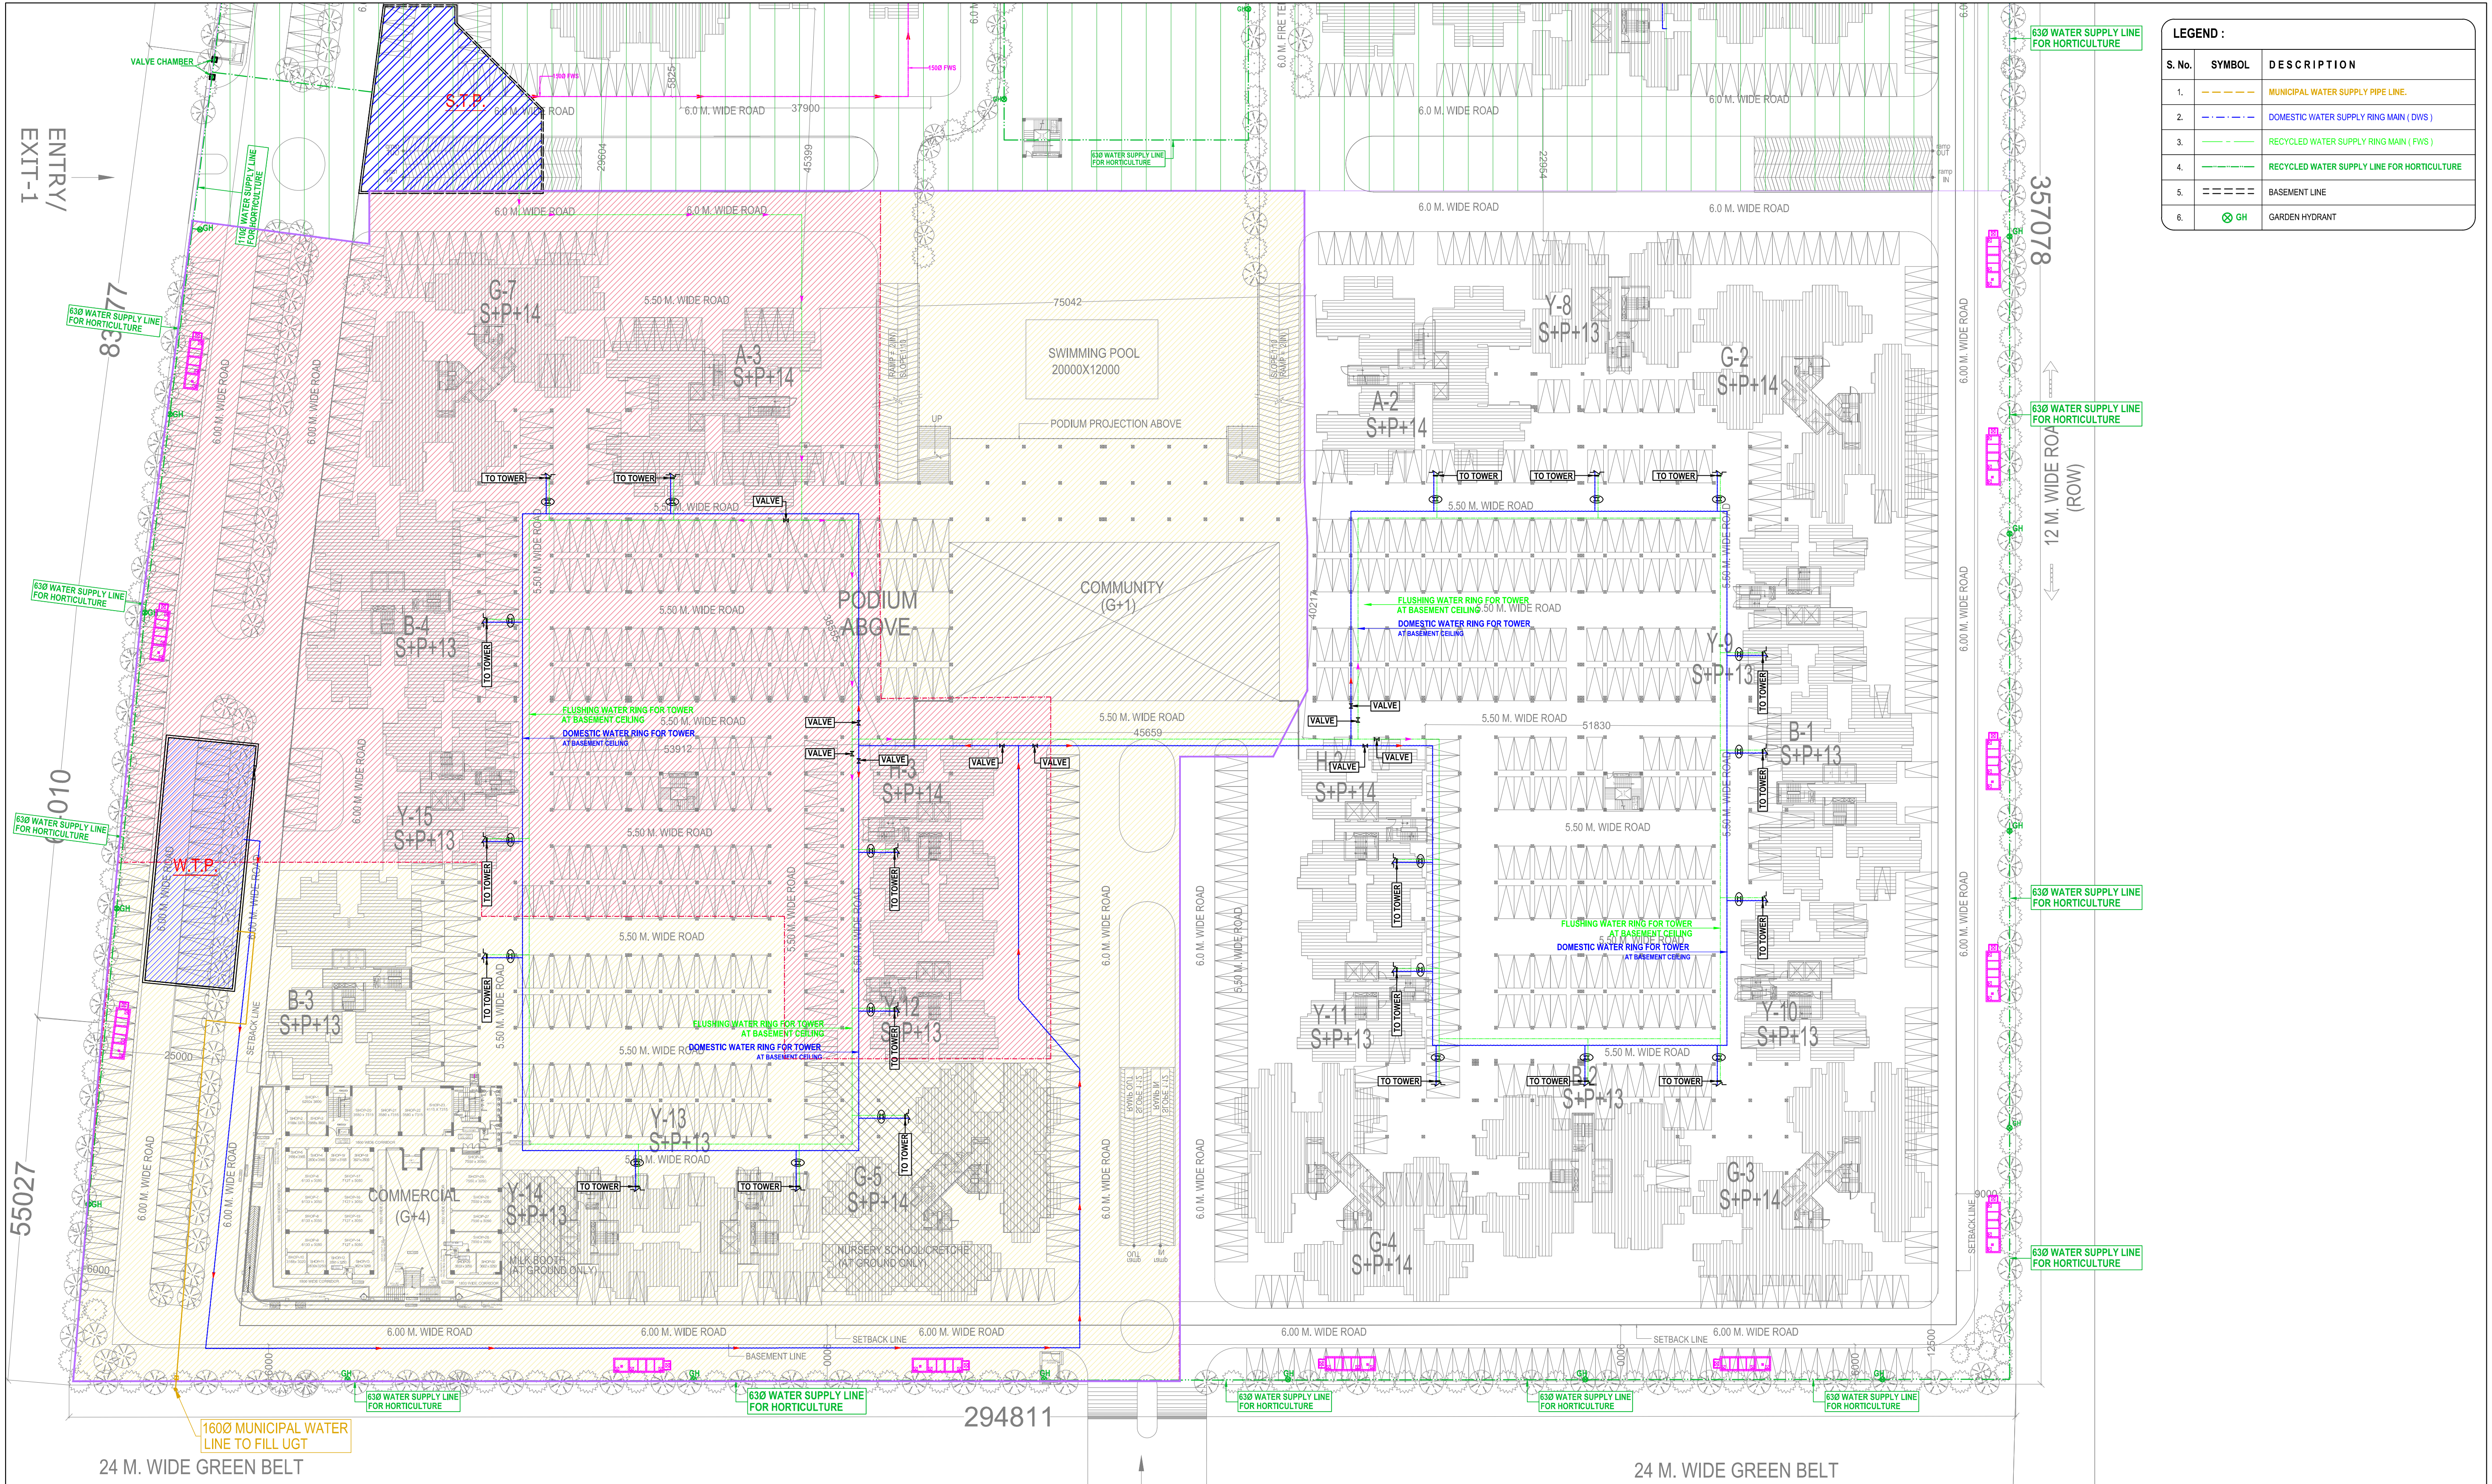

| LEGEND : |        |                                             |
|----------|--------|---------------------------------------------|
| S. No.   | SYMBOL | DESCRIPTION                                 |
| 1.       | ---    | MUNICIPAL WATER SUPPLY PIPE LINE.           |
| 2.       | ---    | DOMESTIC WATER SUPPLY RING MAIN ( DWS )     |
| 3.       | ---    | RECYCLED WATER SUPPLY RING MAIN ( FWS )     |
| 4.       | ---    | RECYCLED WATER SUPPLY LINE FOR HORTICULTURE |
| 5.       | ---    | BASEMENT LINE                               |
| 6.       | GH     | GARDEN HYDRANT                              |

|  |                                                                      |
|--|----------------------------------------------------------------------|
|  | COMPLETED PHASE                                                      |
|  | PHASE, EROS SAMPOORNAM 1 SHOWN THUS<br>AREA 16,380.00 Sqm. (Approx.) |
|  | PHASE, EROS SAMPOORNAM 2 SHOWN THUS<br>AREA 13,534.00 Sqm. (Approx.) |

| rev. no.                                                            | date | revision |
|---------------------------------------------------------------------|------|----------|
| project<br><b>EROS SAMPOORNAM GROUP HOUSING</b><br>at GREATER NOIDA |      |          |
| title<br><b>PHASE - III &amp; IV<br/>SITE PLAN</b>                  |      |          |
| subtitle<br><b>EXTERNAL WATER SUPPLY SYSTEM</b>                     |      |          |

|                                       |                                       |
|---------------------------------------|---------------------------------------|
| drawing released for                  |                                       |
| <input type="checkbox"/> APPROVAL     | <input type="checkbox"/> SUBMISSION   |
| <input type="checkbox"/> ADVANCE COPY | <input type="checkbox"/> CONSTRUCTION |
| drg. no.<br>CES / ES / SP / PL-05     | drawn by<br>Arjun                     |
| scale<br>A1@ : 475                    | designed by<br>Shakir Sabbir          |
| date<br>NOV2018                       | checked by<br>Anand Havelia           |

|                                                                                                                                                                                                                                                                                                       |  |
|-------------------------------------------------------------------------------------------------------------------------------------------------------------------------------------------------------------------------------------------------------------------------------------------------------|--|
| architects<br><b>VAIBHAVJAIN &amp; ASSOCIATES</b><br>195, RAM VIHAR, DELHI-110092<br>PHONE/FAX :- 42518322, 22377102<br>E mail :- avinash@nae.co.in, info@nae.co.in                                                                                                                                   |  |
| services consultant<br><b>Consummate Engineering Services (P) Ltd.</b><br>Noida Office : B - 67, Sector - 67, Noida - 201 301<br>Tel : (0120) 2993500 ( 30 Lines )<br>Lko Office : R 006, Rontas Plumeria, Gomti Nagar, Lucknow<br>Tel : (0522) 6515455<br>e mail : mail@cespln, website : www.cespln |  |