


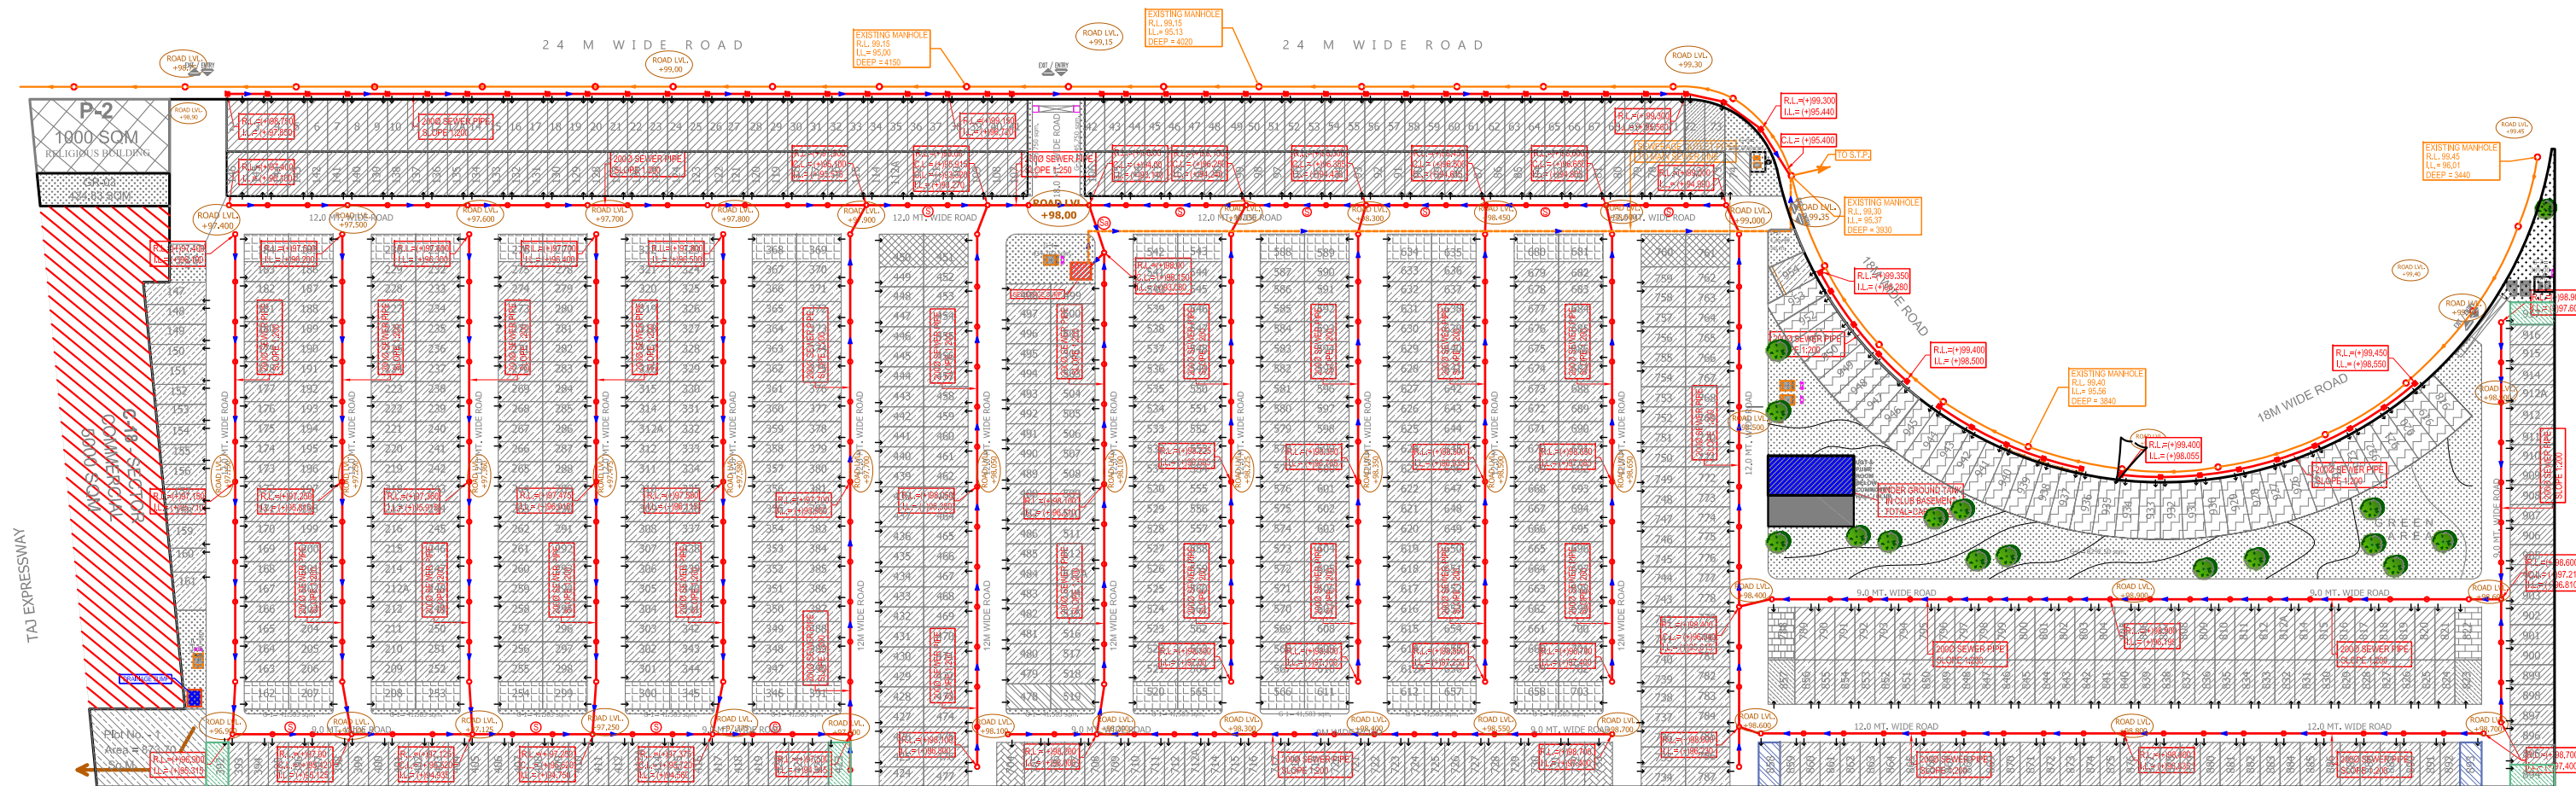

OTHER PROPERTY

LEGEND :		
S. No.	SYMBOL	DESCRIPTION
1.	M.H.	MANHOLE
2.	—○—	SEWER LINE
3.	—○—	EXISTING SEWER MANHOLE
4.	—○—	MANHOLE (900x800mm)
5.	—○—	2000 SEWER PIPE (SLOPE 1:200)
6.	—○—	2500 SEWER PIPE (SLOPE 1:250)
7.	R.L.	ROAD LEVEL
8.	I.L.	INVERT LEVEL
9.	C.L.	CONNECTION LEVEL

PROPOSED
VICTORIAN VILLAS
7TH PARK VIEW- GAUR
YAMUNA CITY-
GREATER NOIDA



Title :
SITE PLAN

Subtitle :
EXTERNAL SEWERAGE LAYOUT

Drawing Released For :

☐ APPROVAL
☐ ADVANCE COPY
☒ SUBMISSION
☐ CONSTRUCTION

Drg. No :
GYC / 7th / SP - 01

Date :
27.07.2020

Scale :
A1@1:1050

Drawn By :
S.Bhandari

Design By :
Shakir Shabbir

Ckd By :
Anand Havelia

architects
BRIJ (INDIA) ARCHITECTS
F-89, GREEN PARK, NEW DELHI -16.
Ph. +91-11-26853815, 26858307, Fax : +91-11-26850788
E-mail : biarch.atwin@gmail.com
Website: www.atwin.in

services consultant
Consummate Engineering Services (P) Ltd.
cespl
Noida Office : B - 67, Sector - 67, Noida - 201 301
Tel : (0120) 26943500 (24 Lines)
Lko. Office : R 006, Rohtas Plumeria, Gomti Nagar, Lucknow
e mail : mail@cespl.in, website : www.cespl.in

Drg.No.- 7th PV - 01