


TYPICAL FLOOR ELECTRICAL DRAWING

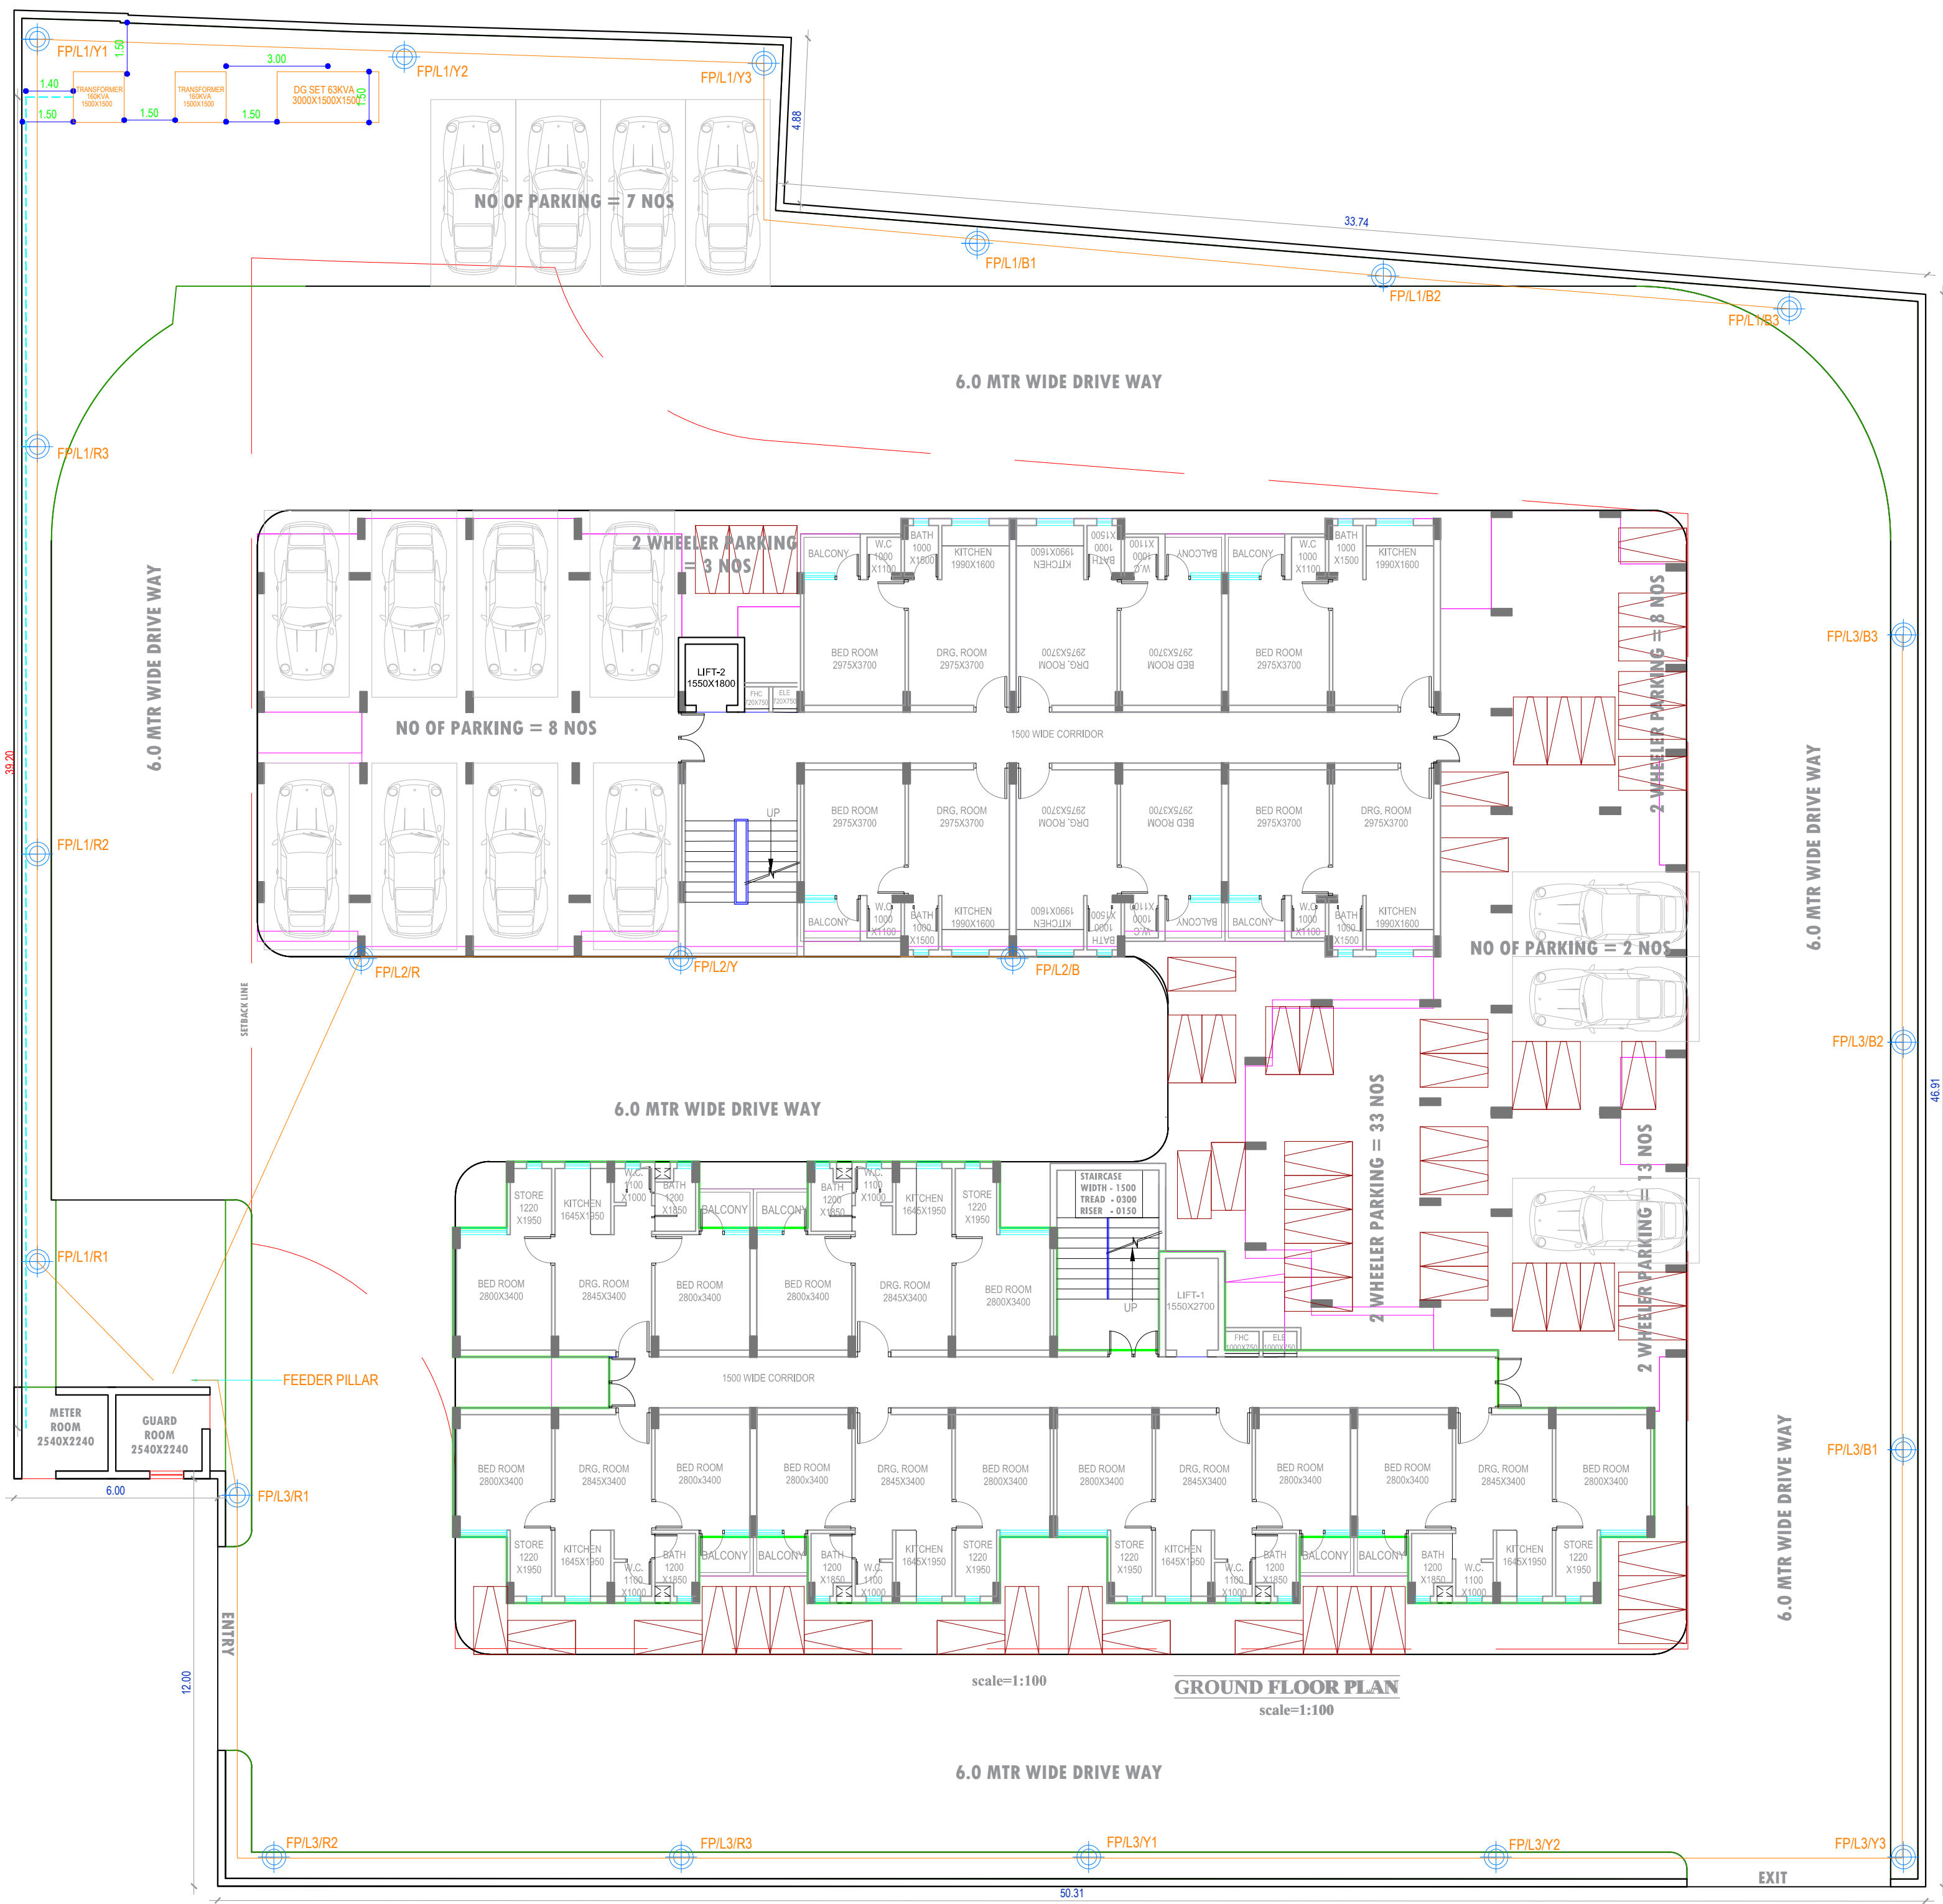

ELECTRICAL LEGEND :-

1



FEEDER PILLAR

2



7 METER POLE

- * ALL DIMENSIONS ARE IN MILLIMETERS UNLESS NOTED OTHERWISE SPECIFIED.
- * DO NOT SCALE THE DRAWING. ALL MEASUREMENTS ARE TO BE CHECKED & VERIFIED ON DRAWING LAYOUT.
- * THIS DRAWING SHALL BE READ IN CONJUNCTION WITH OTHER RELEVANT DRAWINGS AND BOQ AND SPECIFICATIONS.
- * ANY DISCREPANCIES IN DIMENSIONS BETWEEN DRAWINGS MUST BE CLARIFIED WITH THE CONSULTANTS PRIOR TO EXECUTION.

DRAWING TITLE :-

EXTERNAL ELECTRICAL
DRAWING

DATE :-

26-11-2018

SCALE :-

N.T.S.

DRAWN BY :-

KIRTI JHA

CHECKED BY :-

MOHIT JAYSWAL



BUILDING MEP CONSULTANT
TRIVENI CONSULTING ENGINEERS
FLAT NO.-C AVON RESIDENCY
A1/8, SECTOR-H ALIGANJ
LUCKNOW
triveniconsultants.lko@gmail.com