


LEGEND:-	
FIRE HYDRANT MS PIPE	
FIRE SPRINKLER MS PIPE	
BALL VALVE	
EXTERNAL FIRE HYDRANT	
EXTERNAL FIRE HOSE CABINAT	
FIRE HOSE CABINAT	
UPRIGHT SPRINKLER HEAD	
PENDENT SPRINKLER HEAD	
SIDE WALL SPRINKLER HEAD	
MANNUAL CALL POINT	
HOOTER	
FIRE EXINGUISHER	
FLOW SWITCH	
ISOLATION VALVE	
4 WAY FIRE BRIGADE INLET	

SYMBOL	DESCRIPTION
	DISTRIBUTION BOX
	SWITCH BOARD (5A SOCKET & SWITCHES)
	15 A SOCKET WITH SWITCH
	5A POWER SOCKET WITH SWITCH
	BELL PUSH, DND, MMR
	CEILING EXHAUST FAN
	SPLIT AC
	TOILET MIRROR LIGHT 1x18w
	KEY TAG 4x2"
	TELEPHONE AS PER FURNITURE LAYOUT
	CEILING LIGHT
	POLE LIGHT
	WALL BRACKET LED LIGHT 4x4"
	1 x 14 W MIRROR LIGHT 7-0"
	5A BS WALL LIGHT SWITCH, USB CHARGING, TYPE C CHARGING SWITCHES FOR CEILING LIGHT @HT. 2'-0"
	5A BS WALL LIGHT SWITCH, SWITCHES FOR CEILING LIGHTS, TELEPHONE, 25A AC SWITCH, SKIRTING LIGHT @HT. 2'-0"
	5A 2 NOS. SOCKET +1 NOS. 15A SWITCH, TV COAXIAL SOCKET, LAN @HT. 4'-0"
	SIDE WALL SPRINKLER HEAD
	PENDENT SPRINKLER HEAD
	SMOKE DETECTOR
	SKIRTING LIGHT +1'-0"
	2 NOS. 15A SWITCH SOCKET +1 NOS. 5A SWITCH FOR LIGHT @HT. 3'-0"
	SPIKE LIGHT
	3 x 1.5 SQMM LIGHT CONTROL CU. WIRE
	3 x 1.5 SQMM 2 WAY LIGHT CONTROL WIRE
	3 x 2.5 SQMM CU. WIRE FOR AC IDU
	3 x 4.0 SQMM CU. WIRE FOR POWER CIRCUIT
	3 x 2.5 SQMM CU. WIRE FOR LIGHT CIRCUIT
	CAT-5 LAN WIRE RJ-45 JACK TO LAN SWITCH
	2 PAIR TELEPHONE WIRE RJ-11 JACK TO TTB
	RG-6 TV CABLE SETUP BOX TO TV SPLITTER
	CAT-5 CCTV CABLE CCTV CAMERA TO NVR

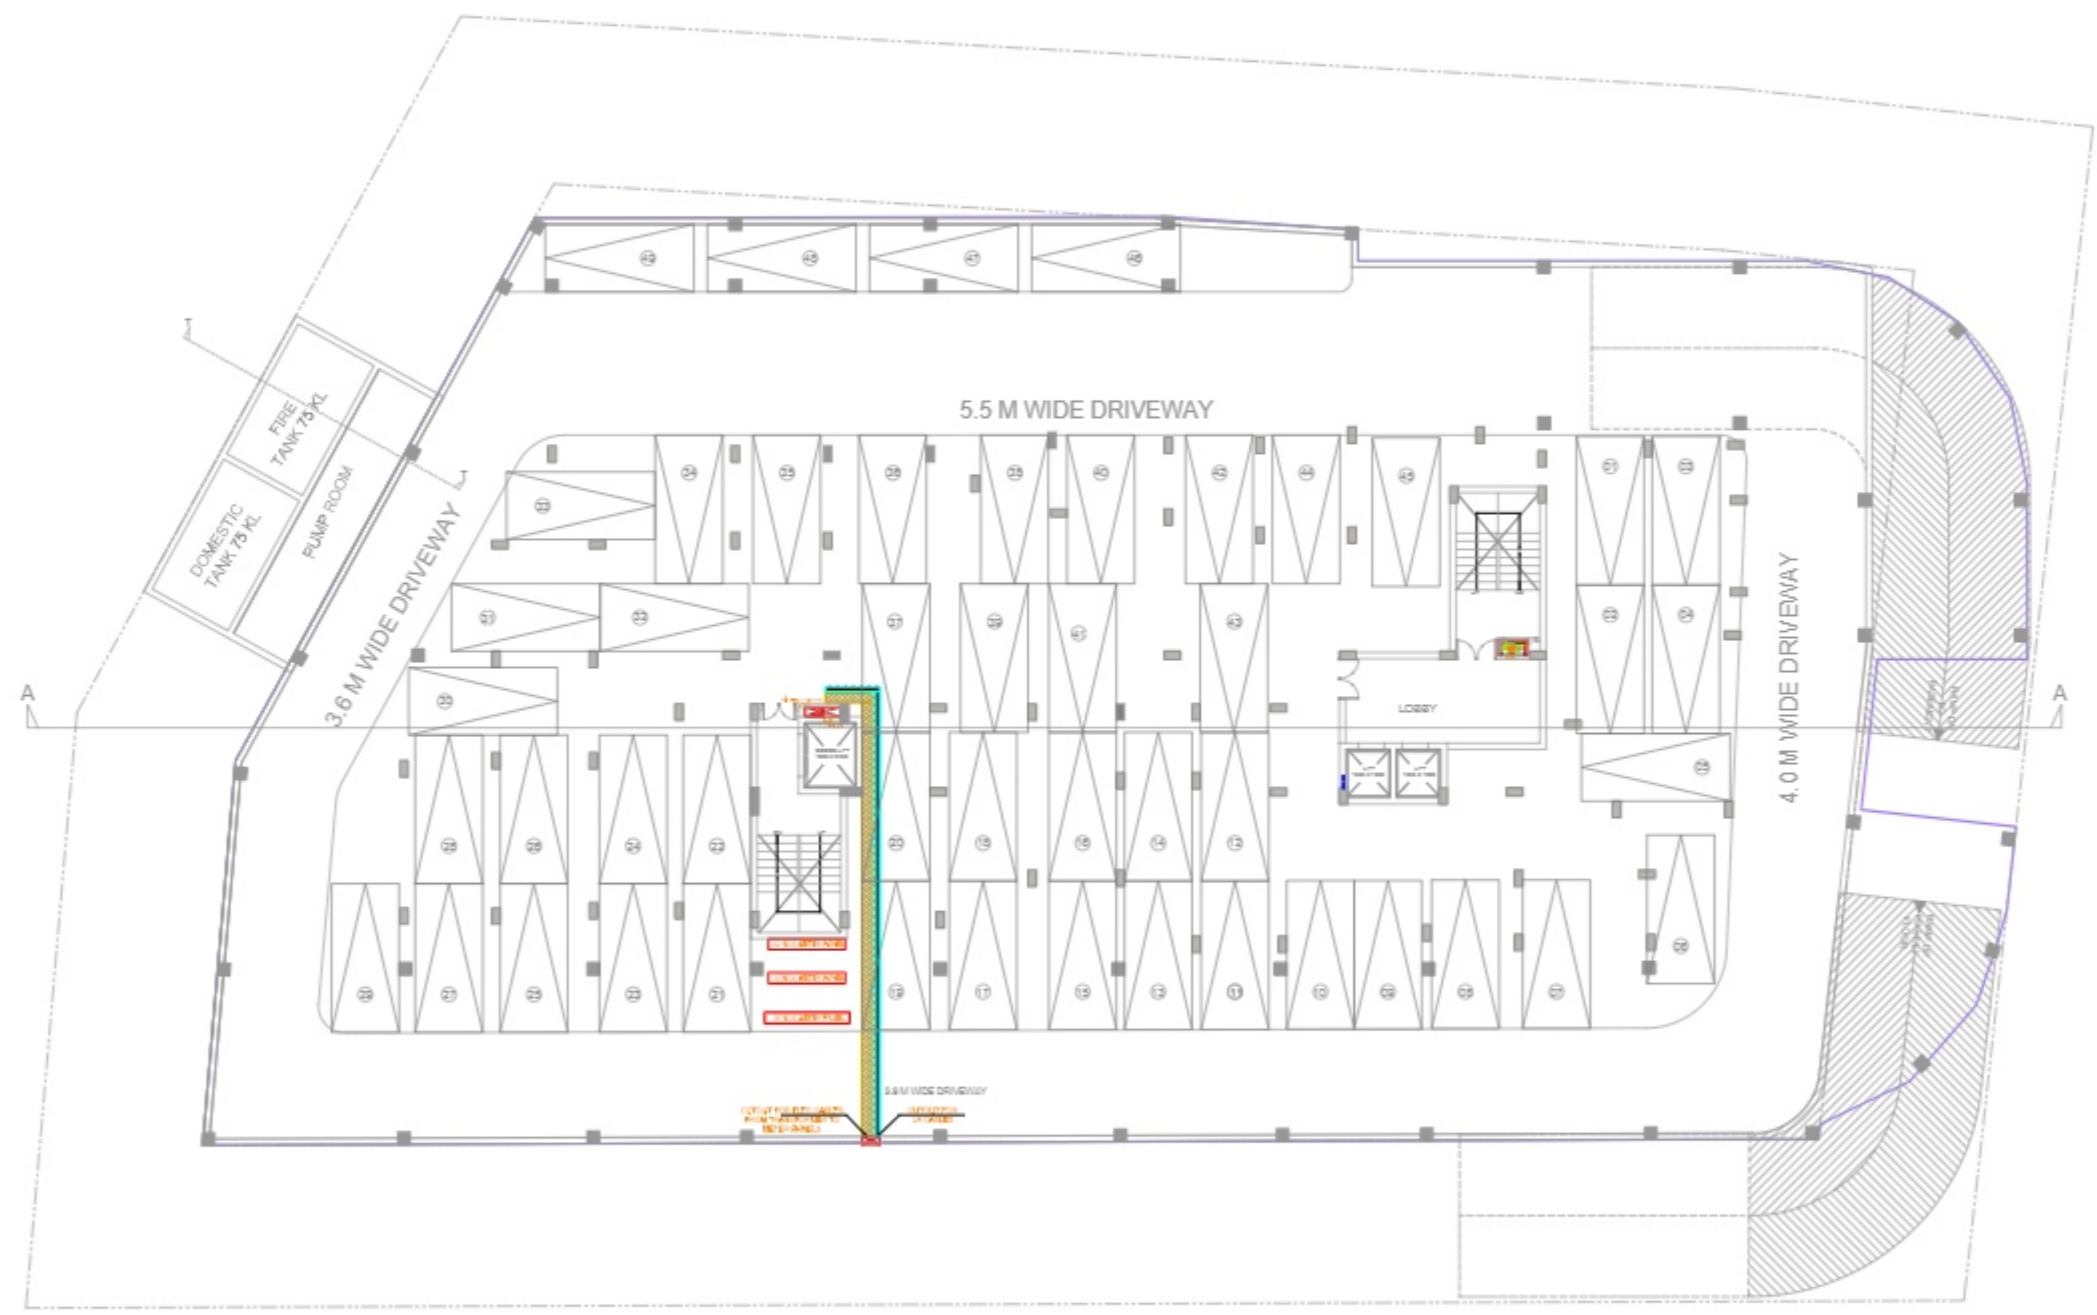

BASEMENT FLOOR ELECTRICAL LAYOUT

For HKDGANPATI INFRASTRUCTURE LLP

 Designated Partner



NOTES

- * THIS DRAWING IS THE PROPERTY OF AVIGHNA ASSOCIATES AND IS NOT TO BE REPRODUCED, COPIED OR HANDLED OVER TO A THIRD PARTY OR USED FOR ANY OTHER PURPOSE OTHER THAN THAT FOR WHICH IT IS INTENDED.
- * DIMENSIONS ARE TO BE READ AND NOT MEASURED.
- * ASSUME ANY MISSING DIMENSION FROM SITE.
- * STRUCTURE & WALL ASSETS ACTUALS.
- * WALLS 1" THICK UNLESS NOTED OTHERWISE.
- * PLEASE BRING ANY DISCREPANCY IN DRAWING TO ARCHITECT BEFORE COMMENCING WORK AT SITE.
- * REFER SITE DRAWING FOR REINFORCEMENT.
- * REFER COLUMN SCHEDULE DRAWING FOR DEMARCATION OF COLUMNS & EXCAVATION.
- * SECTION PROVIDED FOR LEVELS.

LEGEND		
SNO	SYMBOLS	DESCRIPTION

CLIENT:-
 HKD GANPATI
 BRAHMADEO APARTMENT

PROJECT:-
 HKD GANPATI
 BRAHMADEO APARTMENT

DWG. TITLE:-
 BASEMENT FLOOR
 ELECTRICAL LAYOUT PLAN


SCALE	N.T.S.	NORTH	REV.
DATE	04-03-2023		
DRG. STATUS	07.A		
DEALT BY	PRANJAN		DES. NO.
CHECKED BY	KUNAL		AS-0907-01



LEGEND:-

FIRE HYDRANT MS PIPE	
FIRE SPRINKLER MS PIPE	
BALL VALVE	
EXTERNAL FIRE HYDRANT	
EXTERNAL FIRE HOSE CABINAT	
FIRE HOSE CABINAT	
UPRIGHT SPRINKLER HEAD	
PENDENT SPRINKLER HEAD	
SIDE WALL SPRINKLER HEAD	
MANNUAL CALL POINT	
HOOTER	
FIRE EXINGUISHER	
FLOW SWITCH	
ISOLATION VALVE	
4 WAY FIRE BRIGADE INLET	

SYMBOL	DESCRIPTION
	DISTRIBUTION BOX
	SWITCH BOARD (5A SOCKET & SWITCHES)
	15 A SOCKET WITH SWITCH
	5A POWER SOCKET WITH SWITCH
	BELL PUSH,DND,MNR
	CEILING EXHAUST FAN
	SPLIT AC
	TOILET MIRROR LIGHT 1x18w
	KEY TAG 4x2"
	TELEPHONE AS PER FURNITURE LAYOUT
	CEILING LIGHT
	POLE LIGHT
	WALL BRACKET LED LIGHT 4x4"
	1 x 14 W MIRROR LIGHT 7'-0"
	5A BSB WALL LIGHT SWITCH, USB CHARGING, TYPE C CHARGING SWITCHES FOR CEILING LIGHT @HT. 2'-0"
	5A BSB WALL LIGHT SWITCH, SWITCHES FOR CEILING LIGHTS, TELEPHONE, 25A AC SWITCH, SKIRTING LIGHT @HT. 2'-0"
	5A 2NBS SOCKET +1 NOS 15A SWITCH, TV COAXIAL SOCKET, LAN @HT. 4'-0"
	SIDE WALL SPRINKLER HEAD
	PENDENT SPRINKLER HEAD
	SMOKE DETECTOR
	SKIRTING LIGHT +1'-0"
	2NBS 15A SWITCH SOCKET +1 NOS 5A SWITCH FOR LIGHT @HT. 3'-0"
	SPIKE LIGHT
	3 x 1.5 SQMM LIGHT CONTROL CU. WIRE
	3 x 1.5 SQMM 2 WAY LIGHT CONTROL WIRE
	3 x 2.5 SQMM CU. WIRE FOR AC IDU
	3 x 4.0 SQMM CU. WIRE FOR POWER CIRCUIT
	3 x 2.5 SQMM CU. WIRE FOR LIGHT CIRCUIT
	CAT-5 LAN WIRE RJ-45 JACK TO LAN SWITCH
	2 PAIR TELEPHONE WIRE RJ-11 JACK TO TTB
	RG-6 TV CABLE SETUP BOX TO TV SPLITTER
	CAT-5 CCTV CABLE CCTV CAMERA TO NVR

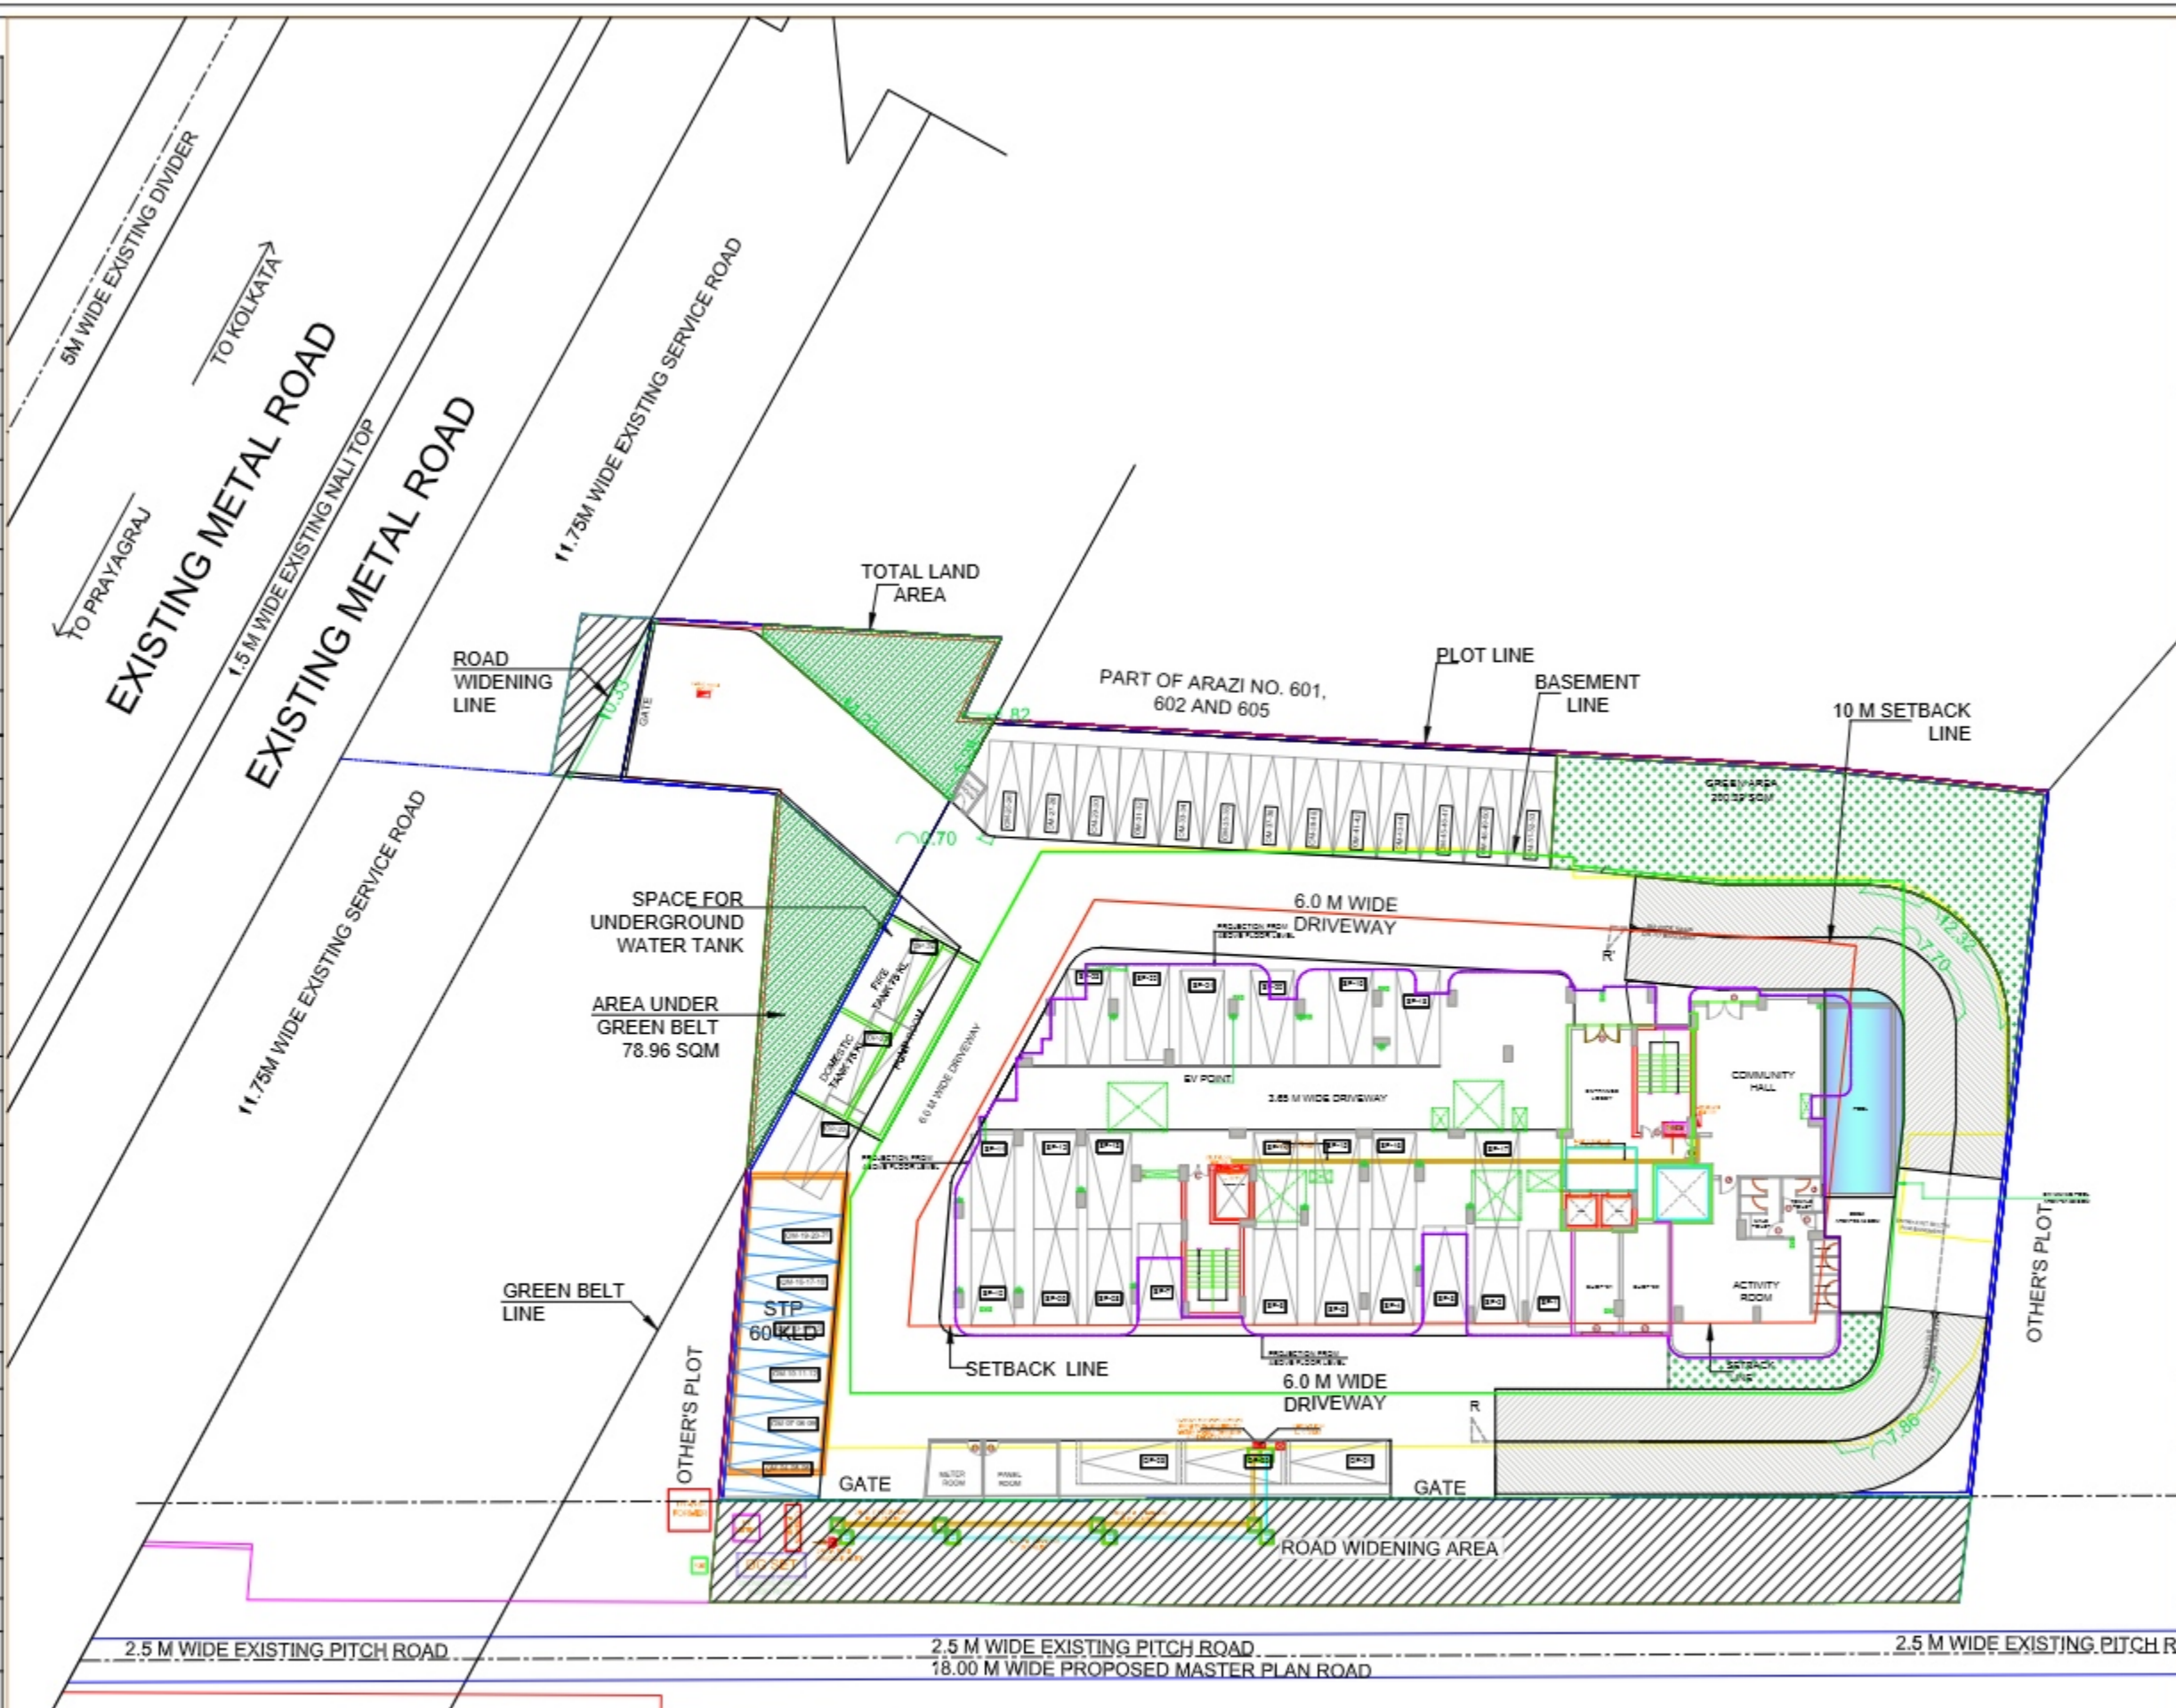

GROUND FLOOR ELECTRICAL LAYOUT

For HKDGANPATI INFRASTRUCTURE LLP

 Designated Partner



NOTES

- * THIS DRAWING IS THE PROPERTY OF AVIGHNA ASSOCIATES AND IS NOT TO BE REPRODUCED, COPIED OR HANDS OVER TO A THIRD PARTY OR USED FOR ANY OTHER PURPOSE OTHER THAN THAT FOR WHICH IT IS INTENDED.
- * DIMENSIONS ARE TO BE READ AND NOT MEASURED.
- * ASSUME ANY MISSING DIMENSION FROM SITE.
- * STRUCTURES & WALL ASSETS ACTUALS.
- * WALLS 1" THICK UNLESS NOTED OTHERWISE.
- * PLEASE BRING ANY DISCREPANCY IN DRAWING TO ARCHITECT BEFORE COMMENCING WORK AT SITE.
- * REFER SITE DRAWING FOR REINFORCEMENT.
- * REFER COLUMN SCHEDULE DRAWING.
- * THIS DRAWING IS STRICTLY FOR DEMARCATION OF COLUMNS & EXCAVATION.
- * SECTION PROVIDED FOR LEVELS.

LEGEND

SNO	SYMBOLS	DESCRIPTION

CLIENT:-
 HKD GANPATI
 BRAHMADEO APARTMENT

PROJECT:-
 HKD GANPATI
 BRAHMADEO APARTMENT

DWG. TITLE:-
 SITE PLAN ELECTRICAL
 LAYOUT PLAN


avighna associates
 ARCHITECTS, INTERIORS DESIGNERS & PLANNERS
 1001, 2nd Floor, Sector 3, Gurgaon, Haryana
 Phone: 01294-500000, 01294-500001
 Email: avighna@avighna.com

SCALE	N.T.S	NORTH	REV.
DATE	04-03-2023		
DRG. STATUS	D.T.A.		
DEALT BY	PRANJAN	DRG. NO.	
CHECKED BY	ADARSH	AS-020201	

LEGEND:-

FIRE HYDRANT MS PIPE	
FIRE SPRINKLER MS PIPE	
BALL VALVE	
EXTERNAL FIRE HYDRANT	
EXTERNAL FIRE HOSE CABINAT	
FIRE HOSE CABINAT	
UPRIGHT SPRINKLER HEAD	
PENDENT SPRINKLER HEAD	
SIDE WALL SPRINKLER HEAD	
MANNUAL CALL POINT	
HOOTER	
FIRE EXINGUISHER	
FLOW SWITCH	
ISOLATION VALVE	
4 WAY FIRE BRIGADE INLET	

SYMBOL	DESCRIPTION
	DISTRIBUTION BOX
	SWITCH BOARD (5A SOCKET & SWITCHES)
	15 A SOCKET WITH SWITCH
	5A POWER SOCKET WITH SWITCH
	BELL PUSH, DND, MMR
	CEILING EXHAUST FAN
	SPLIT AC
	TOILET MIRROR LIGHT 1x18w
	KEY TAG 4x2"
	TELEPHONE AS PER FURNITURE LAYOUT
	CEILING LIGHT
	POLE LIGHT
	WALL BRACKET LED LIGHT 4x4"
	1 x 14 W MIRROR LIGHT 7'-0"
	5A BS WALL LIGHT SWITCH, USB CHARGING, TYPE C CHARGING, SWITCHES FOR CEILING LIGHT @HT. 2'-0"
	5A BS WALL LIGHT SWITCH, SWITCHES FOR CEILING LIGHTS, TELEPHONE, 25A AC SWITCH, SKIRTING LIGHT @HT. 2'-0"
	5A 2 NOS. SOCKET -1 NOS. 15A SWITCH, TV COAXIAL SOCKET, LAN @HT. 4'-0"
	SIDE WALL SPRINKLER HEAD
	PENDENT SPRINKLER HEAD
	SMOKE DETECTOR
	SKIRTING LIGHT 4x1'-0"
	2 NOS. 15A SWITCH SOCKET -1 NOS. 5A SWITCH FOR LIGHT @HT. 3'-0"
	SPIKE LIGHT
	3 x 1.5 SQMM LIGHT CONTROL CU. WIRE
	3 x 1.5 SQMM 2 WAY LIGHT CONTROL WIRE
	3 x 2.5 SQMM CU. WIRE FOR AC IDU
	3 x 4.0 SQMM CU. WIRE FOR POWER CIRCUIT
	3 x 2.5 SQMM CU. WIRE FOR LIGHT CIRCUIT
	CAT-5 LAN WIRE RJ-45 JACK TO LAN SWITCH
	2 PAIR TELEPHONE WIRE RJ-11 JACK TO TTB
	RG-6 TV CABLE SETUP BOX TO TV SPLITTER
	CAT-5 CCTV CABLE CCTV CAMERA TO NVR

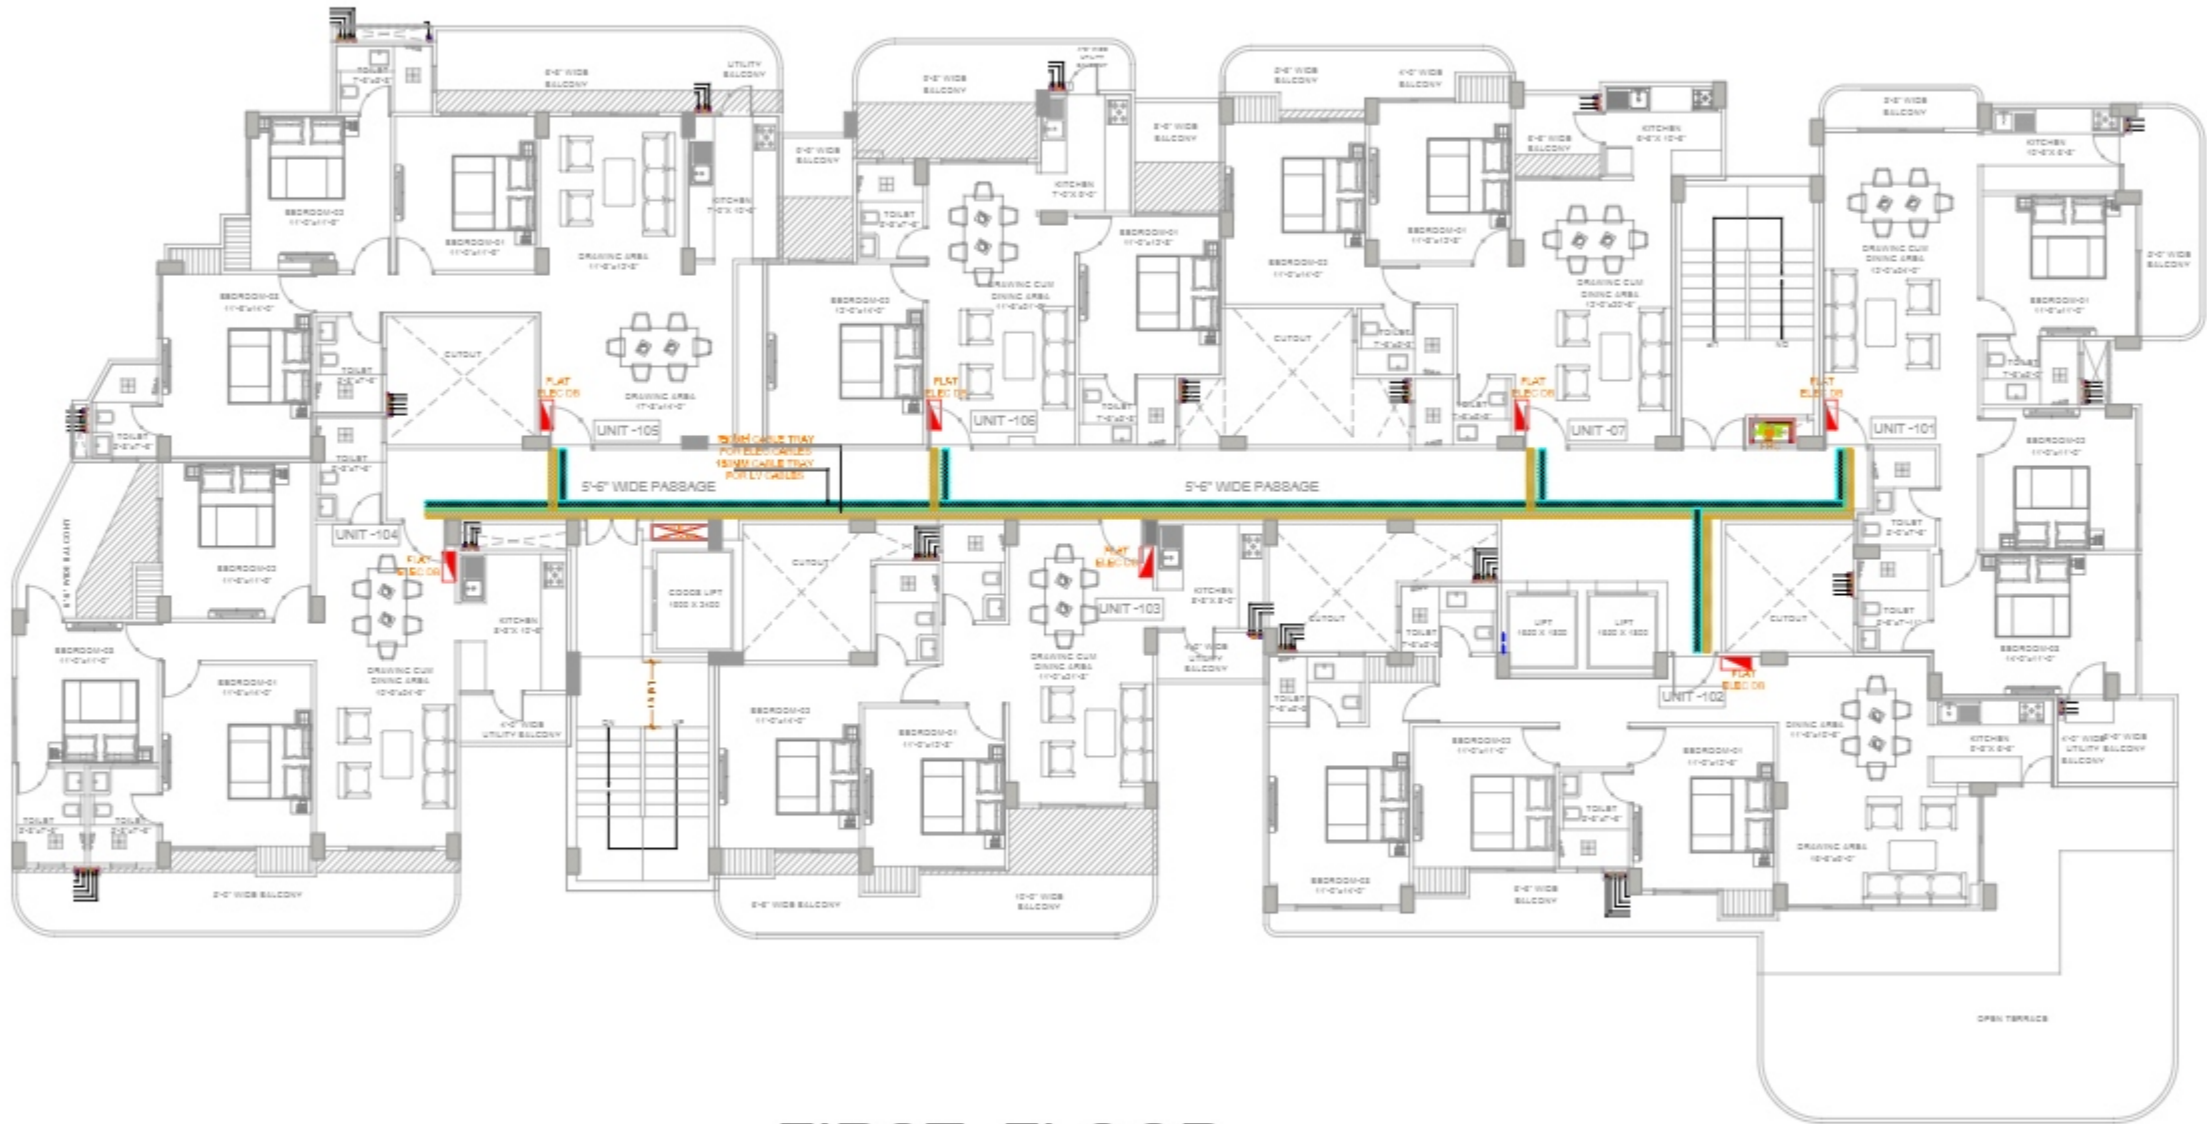

FIRST FLOOR ELECTRICAL LAYOUT

For HKDGANPATI INFRASHAPERS LLP

 Designated Partner



- NOTES**
- * THIS DRAWING IS THE PROPERTY OF AVIGNHA ASSOCIATES AND IS NOT TO BE REPRODUCED, COPIED OR HANDS OVER TO A THIRD PARTY OR USED FOR ANY OTHER PURPOSES OTHER THAN THAT FOR WHICH IT IS INTENDED.
 - * DIMENSIONS ARE TO BE READ AND NOT MEASURED.
 - * ASSUME ANY MISSING DIMENSION FROM SITE.
 - * STRUCTURE & WALL ASBITE ACTUALS.
 - * WALLS 1" THICK UNLESS NOTED OTHERWISE.
 - * PLEASE BRING ANY DISCREPANCY IN DRAWING TO ARCHITECT BEFORE COMMENCING WORK AT SITE.
 - * REFER SITE DRAWING FOR REINFORCEMENT.
 - * REFER COLLUM SCHEDULE DRAWING
 - * THIS DRAWING IS STRICTLY FOR DEMARCATION OF COLUMNS & CIRCUMAVATION.
 - * SECTION PROVIDED FOR LEVELS.

LEGEND

SNO	SYMBOLS	DESCRIPTION

CLIENT:-
 HKD GANPATI
 BRAHMADEO APARTMENT

PROJECT:-
 HKD GANPATI
 BRAHMADEO APARTMENT

DWG. TITLE:-
 FIRST FLOOR ELECTRICAL LAYOUT PLAN


avignha associates
 ARCHITECTS, INTERIORS DESIGNERS & PLANNERS
 10th Floor, 10th Cross, 10th Main, 10th Stage, 10th Block, 10th Sector, 10th Phase, 10th Colony, 10th Locality, 10th Area, 10th Zone, 10th Region, 10th State, 10th Country.

SCALE	N.T.S.	NORTH	REV.
DATE	04-03-2023		
DRG. STATUS	07-A		
DEALT BY	PRANJAN	DRG. NO.	
CHECKED BY	KUNAL	AS-0907-01	

LEGEND:-

FIRE HYDRANT MS PIPE	
FIRE SPRINKLER MS PIPE	
BALL VALVE	
EXTERNAL FIRE HYDRANT	
EXTERNAL FIRE HOSE CABINAT	
FIRE HOSE CABINAT	
UPRIGHT SPRINKLER HEAD	
PENDENT SPRINKLER HEAD	
SIDE WALL SPRINKLER HEAD	
MANNUAL CALL POINT	
HOOTER	
FIRE EXINGUISHER	
FLOW SWITCH	
ISOLATION VALVE	
4 WAY FIRE BRIGADE INLET	

SYMBOL	DESCRIPTION
	DISTRIBUTION BOX
	SWITCH BOARD (5A SOCKET & SWITCHES)
	15 A SOCKET WITH SWITCH
	5A POWER SOCKET WITH SWITCH
	BELL PUSH, DND, MMR
	CEILING EXHAUST FAN
	SPLIT AC
	TOILET MIRROR LIGHT 1x18w
	KEY TAG 4x2"
	TELEPHONE AS PER FURNITURE LAYOUT
	CEILING LIGHT
	POLE LIGHT
	WALL BRACKET LED LIGHT 4x4"
	1 x 14 W MIRROR LIGHT 7'-0"
	5A/15A WALL LIGHT SWITCH, USB CHARGING, TYPE C CHARGING SWITCHES FOR CEILING LIGHT @HT. 2'-0"
	5A/15A WALL LIGHT SWITCH, SWITCHES FOR CEILING LIGHTS, TELEPHONE, 25A AC SWITCH, SKIRTING LIGHT @HT. 2'-0"
	5A/2NOS. SOCKET -1 NOS 15A SWITCH, TV COAXIAL SOCKET, LAN @HT. 4'-0"
	SIDE WALL SPRINKLER HEAD
	PENDENT SPRINKLER HEAD
	SMOKE DETECTOR
	SKIRTING LIGHT 4x1'-0"
	2NOS 15A SWITCH SOCKET +1 NOS 5A SWITCH FOR LIGHT @HT 3'-0"
	SPIKE LIGHT
	3 x 1.5 SQMM LIGHT CONTROL CU. WIRE
	3 x 1.5 SQMM 2 WAY LIGHT CONTROL WIRE
	3 x 2.5 SQMM CU. WIRE FOR AC IDU
	3 x 4.0 SQMM CU. WIRE FOR POWER CIRCUIT
	3 x 2.5 SQMM CU. WIRE FOR LIGHT CIRCUIT
	CAT-5 LAN WIRE RJ-45 JACK TO LAN SWITCH
	2 PAIR TELEPHONE WIRE RJ-11 JACK TO TTB
	RG-6 TV CABLE SETUP BOX TO TV SPLITTER
	CAT-5 CCTV CABLE CCTV CAMERA TO NVR

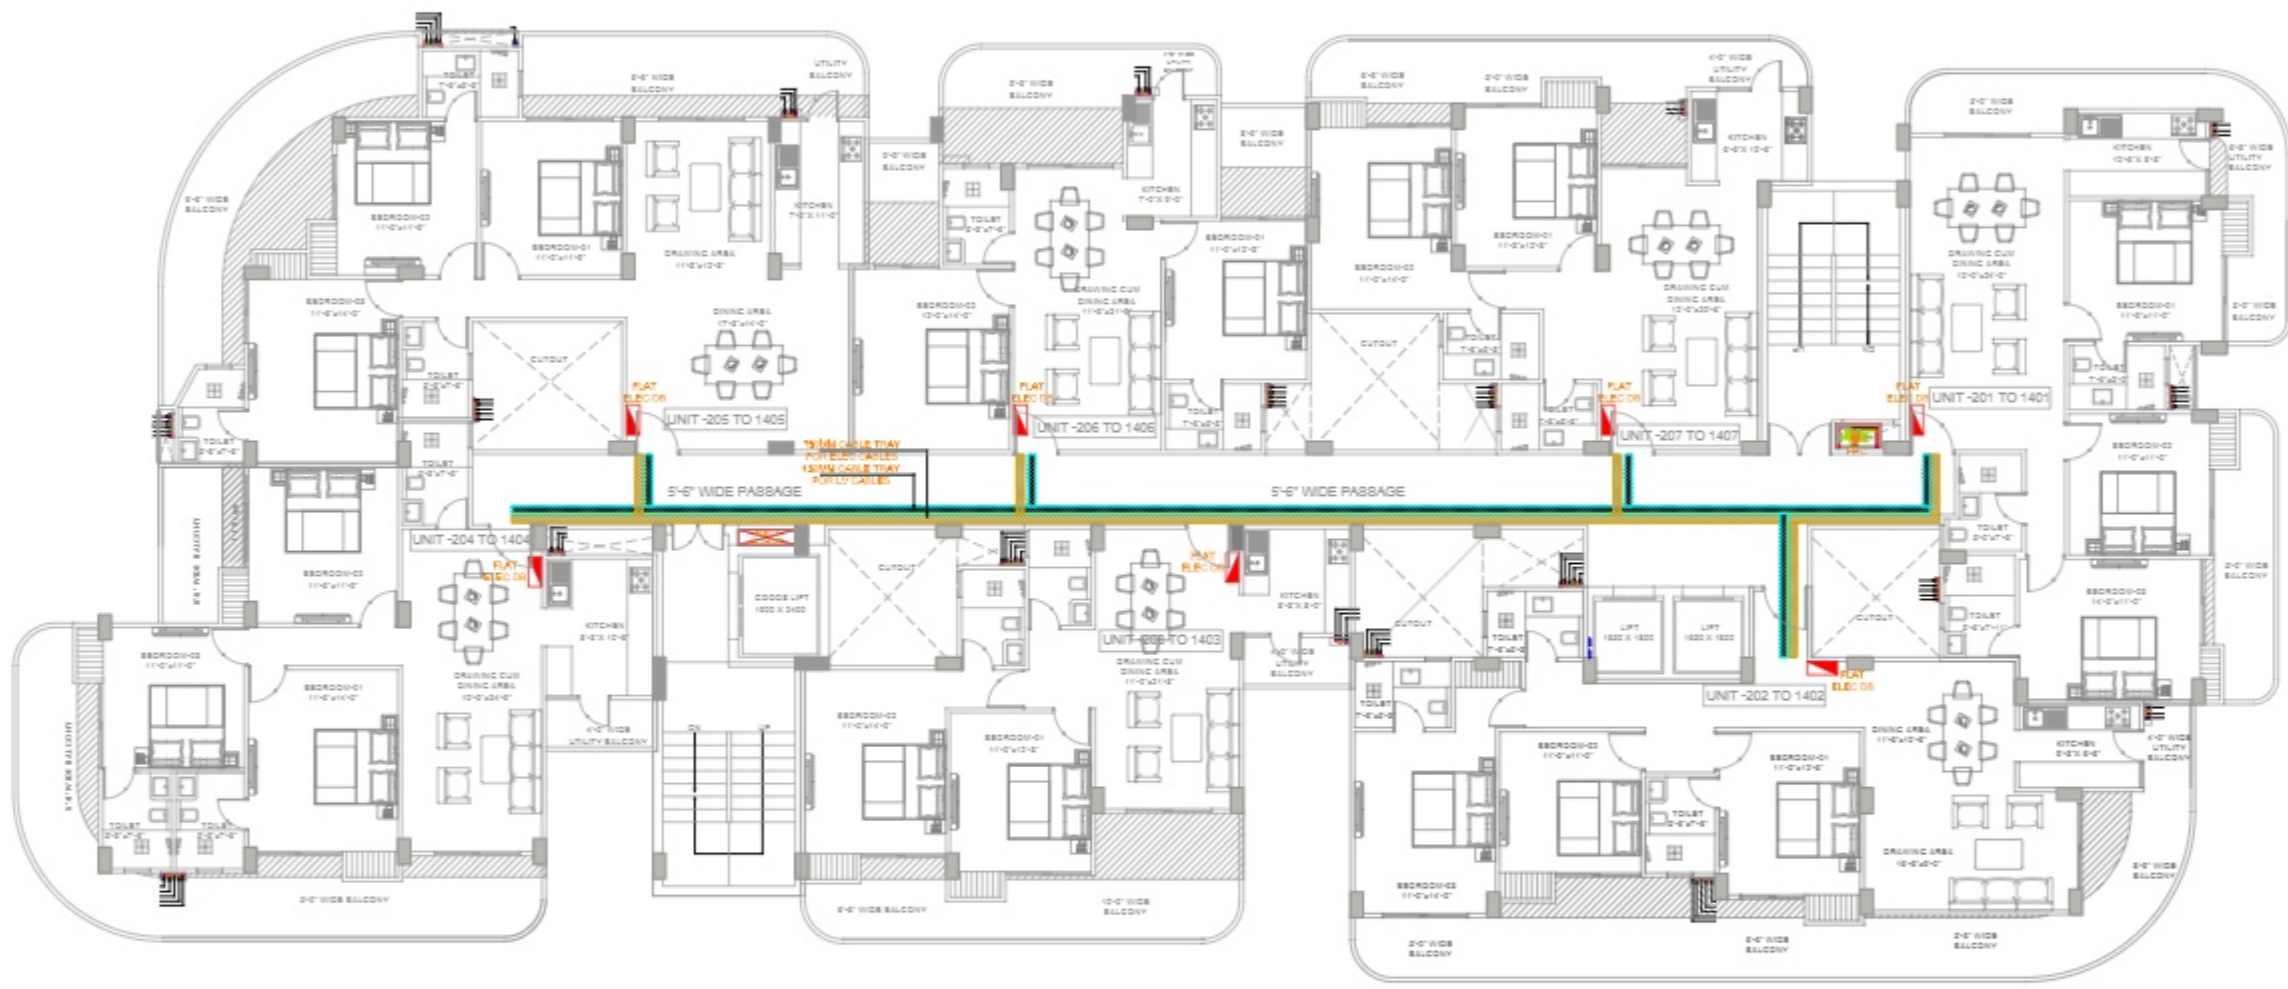

TYPICAL FLOOR ELECTRICAL LAYOUT

For HKDGANPATI INFRASHAPERS LLP
Kunal Kataria
 Designated Partner



- NOTES**
- * THIS DRAWING IS THE PROPERTY OF AVIGHNA ASSOCIATES AND IS NOT TO BE REPRODUCED, COPIED OR HANDS OVER TO A THIRD PARTY OR USED FOR ANY OTHER PURPOSE OTHER THAN THAT FOR WHICH IT IS INTENDED.
 - * DIMENSIONS ARE TO BE READ AND NOT MEASURED.
 - * ASSUME ANY MISSING DIMENSION FROM SITE.
 - * STRUCTURE & WALL ASBTS ACTUALS.
 - * WALLS 1" THICK UNLESS NOTED OTHERWISE.
 - * PLEASE BRING ANY DISCREPANCY IN DRAWING TO ARCHITECT BEFORE COMMENCING WORK AT SITE.
 - * REFER SITE DRAWING FOR REINFORCEMENT.
 - * REFER COLUMN SCHEDULE DRAWING.
 - * THIS DRAWING IS STRICTLY FOR DEMARCATION OF COLUMNS & EXCAVATION.
 - * SECTION PROVIDED FOR LEVELS.

LEGEND

SNO	SYMBOLS	DESCRIPTION

CLIENT:-
 HKD GANPATI
 BRAHMADEO APARTMENT

PROJECT:-
 HKD GANPATI
 BRAHMADEO APARTMENT


DWG. TITLE:-
 TYPICAL FLOOR
 ELECTRICAL LAYOUT PLAN

avighna associates
 ARCHITECTS, INTERIORS DESIGNERS & PLANNERS
 1001, 2nd floor, Block 3, Sector 10, Gurgaon
 Haryana, India. Phone: +91 99100 10000
 Email: avighnaassociates@gmail.com

SCALE	N.T.S	NORTH	REV.
DATE	04-03-2023		
DRG. STATUS	DT.A		
DEALT BY	PRASHANT	DRG. NO.	
CHECKED BY	KUNAL	AS-0907-01	

LEGEND:-	
FIRE HYDRANT MS PIPE	
FIRE SPRINKLER MS PIPE	
BALL VALVE	
EXTERNAL FIRE HYDRANT	
EXTERNAL FIRE HOSE CABINAT	
FIRE HOSE CABINAT	
UPRIGHT SPRINKLER HEAD	
PENDENT SPRINKLER HEAD	
SIDE WALL SPRINKLER HEAD	
MANNUAL CALL POINT	
HOOTER	
FIRE EXINGUISHER	
FLOW SWITCH	
ISOLATION VALVE	
4 WAY FIRE BRIGADE INLET	

SYMBOL	DESCRIPTION
	DISTRIBUTION BOX
	SWITCH BOARD (5A SOCKET & SWITCHES)
	15 A SOCKET WITH SWITCH
	5A POWER SOCKET WITH SWITCH
	BELL PUSH, DND, MMR
	CEILING EXHAUST FAN
	SPLIT AC
	TOILET MIRROR LIGHT 1x18w
	KEY TAG 4x2"
	TELEPHONE AS PER FURNITURE LAYOUT
	CEILING LIGHT
	POLE LIGHT
	WALL BRACKET LED LIGHT 4x4"
	1 x 14 W MIRROR LIGHT 7-0"
	5A BSB WALL LIGHT SWITCH, USB CHARGING, TYPE C CHARGING, SWITCHES FOR CEILING LIGHT @HT. 2'-0"
	5A BSB WALL LIGHT SWITCH, SWITCHES FOR CEILING LIGHTS, TELEPHONE, 25A AC SWITCH, SKIRTING LIGHT @HT. 2'-0"
	5A 2 NOS. SOCKET +1 NOS. 15A SWITCH, TV COAXIAL SOCKET, LAN @HT. 4'-0"
	SIDE WALL SPRINKLER HEAD
	PENDENT SPRINKLER HEAD
	SMOKE DETECTOR
	SKIRTING LIGHT +1'-0"
	2 NOS. 15A SWITCH SOCKET +1 NOS. 5A SWITCH FOR LIGHT @HT. 3'-0"
	SPIKE LIGHT
	3 x 1.5 SQMM LIGHT CONTROL CU. WIRE
	3 x 1.5 SQMM 2 WAY LIGHT CONTROL WIRE
	3 x 2.5 SQMM CU. WIRE FOR AC IDU
	3 x 4.0 SQMM CU. WIRE FOR POWER CIRCUIT
	3 x 2.5 SQMM CU. WIRE FOR LIGHT CIRCUIT
	CAT-5 LAN WIRE RJ-45 JACK TO LAN SWITCH
	2 PAIR TELEPHONE WIRE RJ-11 JACK TO TTB
	RG-6 TV CABLE SETUP BOX TO TV SPLITTER
	CAT-5 CCTV CABLE CCTV CAMERA TO NVR

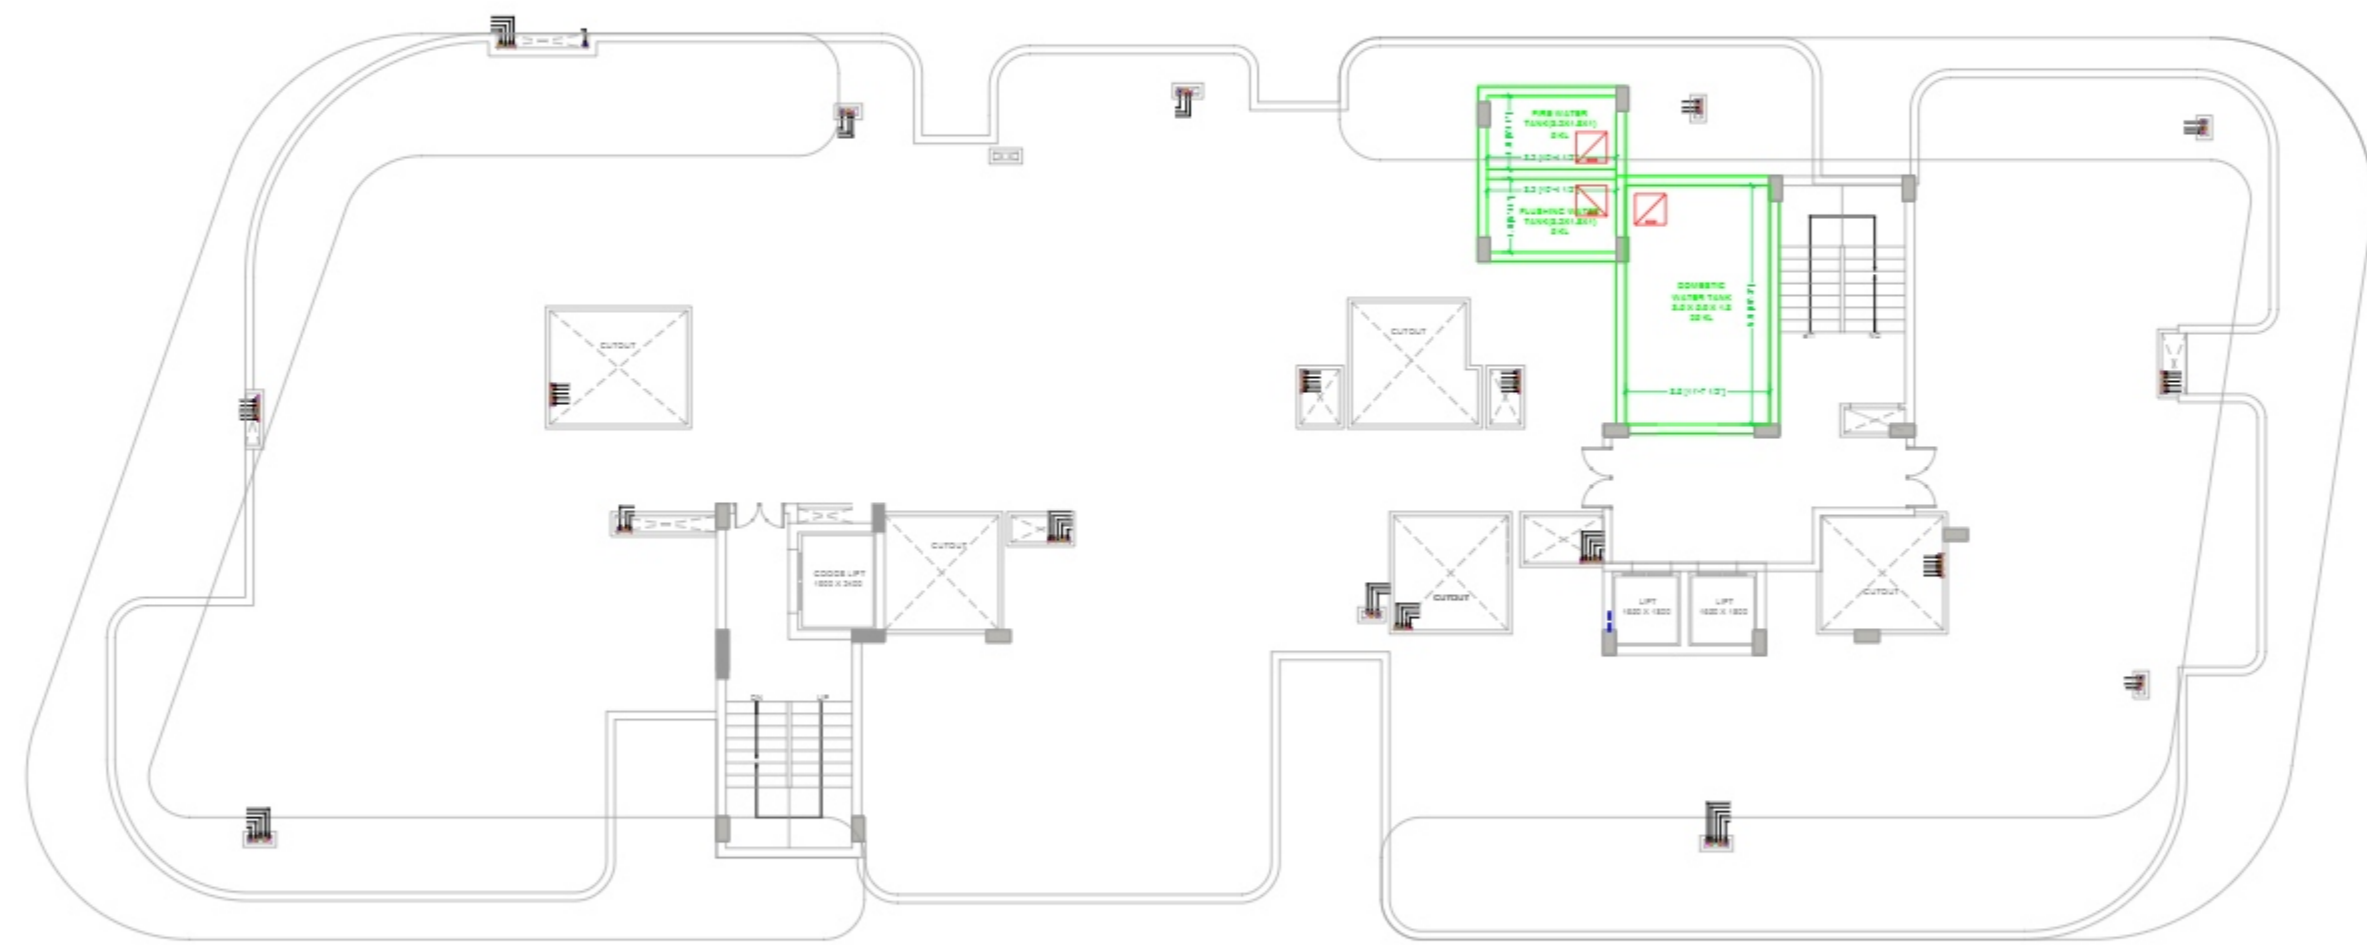

TERRACE FLOOR ELECTRICAL LAYOUT

For HKDGANPATI INFRASHAPERS LLP
[Signature]
 Designated Partner



NOTES

- * THIS DRAWING IS THE PROPERTY OF AVIGHNA ASSOCIATES AND IS NOT TO BE REPRODUCED, COPIED OR HANDS OVER TO A THIRD PARTY OR USED FOR ANY OTHER PURPOSE OTHER THAN THAT FOR WHICH IT IS INTENDED.
- * DIMENSIONS ARE TO BE READ AND NOT MEASURED.
- * ASSUME ANY MISSING DIMENSION FROM SITE.
- * STRUCTURE & WALL ASBTS ACTUALS.
- * WALLS 1" THICK UNLESS NOTED OTHERWISE.
- * PLEASE BRING ANY DISCREPANCY IN DRAWING TO ARCHITECT BEFORE COMMENCING WORK AT SITE.
- * REFER SITE DRAWING FOR REINFORCEMENT.
- * REFER COLUMN SCHEDULE DRAWING
- * THIS DRAWING IS STRICTLY FOR DEMARCATION OF COLUMNS & EXCAVATION.
- * SECTION PROVIDED FOR LEVELS.

LEGEND		
SNO	SYMBOLS	DESCRIPTION

CLIENT:-
 HKD GANPATI
 BRAHMADEO APARTMENT

PROJECT:-
 HKD GANPATI
 BRAHMADEO APARTMENT

DWG. TITLE:-
 TERRACE FLOOR
 ELECTRICAL LAYOUT PLAN

avighna associates
 ARCHITECTS, INTERIORS DESIGNERS & PLANNERS
 Studio: 2nd floor, 2nd & 3rd, 1st, 2nd, 3rd, 4th, 5th, 6th, 7th, 8th, 9th, 10th, 11th, 12th, 13th, 14th, 15th, 16th, 17th, 18th, 19th, 20th, 21st, 22nd, 23rd, 24th, 25th, 26th, 27th, 28th, 29th, 30th, 31st, 32nd, 33rd, 34th, 35th, 36th, 37th, 38th, 39th, 40th, 41st, 42nd, 43rd, 44th, 45th, 46th, 47th, 48th, 49th, 50th, 51st, 52nd, 53rd, 54th, 55th, 56th, 57th, 58th, 59th, 60th, 61st, 62nd, 63rd, 64th, 65th, 66th, 67th, 68th, 69th, 70th, 71st, 72nd, 73rd, 74th, 75th, 76th, 77th, 78th, 79th, 80th, 81st, 82nd, 83rd, 84th, 85th, 86th, 87th, 88th, 89th, 90th, 91st, 92nd, 93rd, 94th, 95th, 96th, 97th, 98th, 99th, 100th

SCALE	N.T.S.	NORTH	REV.
DATE	04-03-2023		
DRG. STATUS	07.A		
DEALT BY	PRANJAN		DRG. NO.
CHECKED BY	KUNAL		AS-0107-01