


RM WATER PIPE

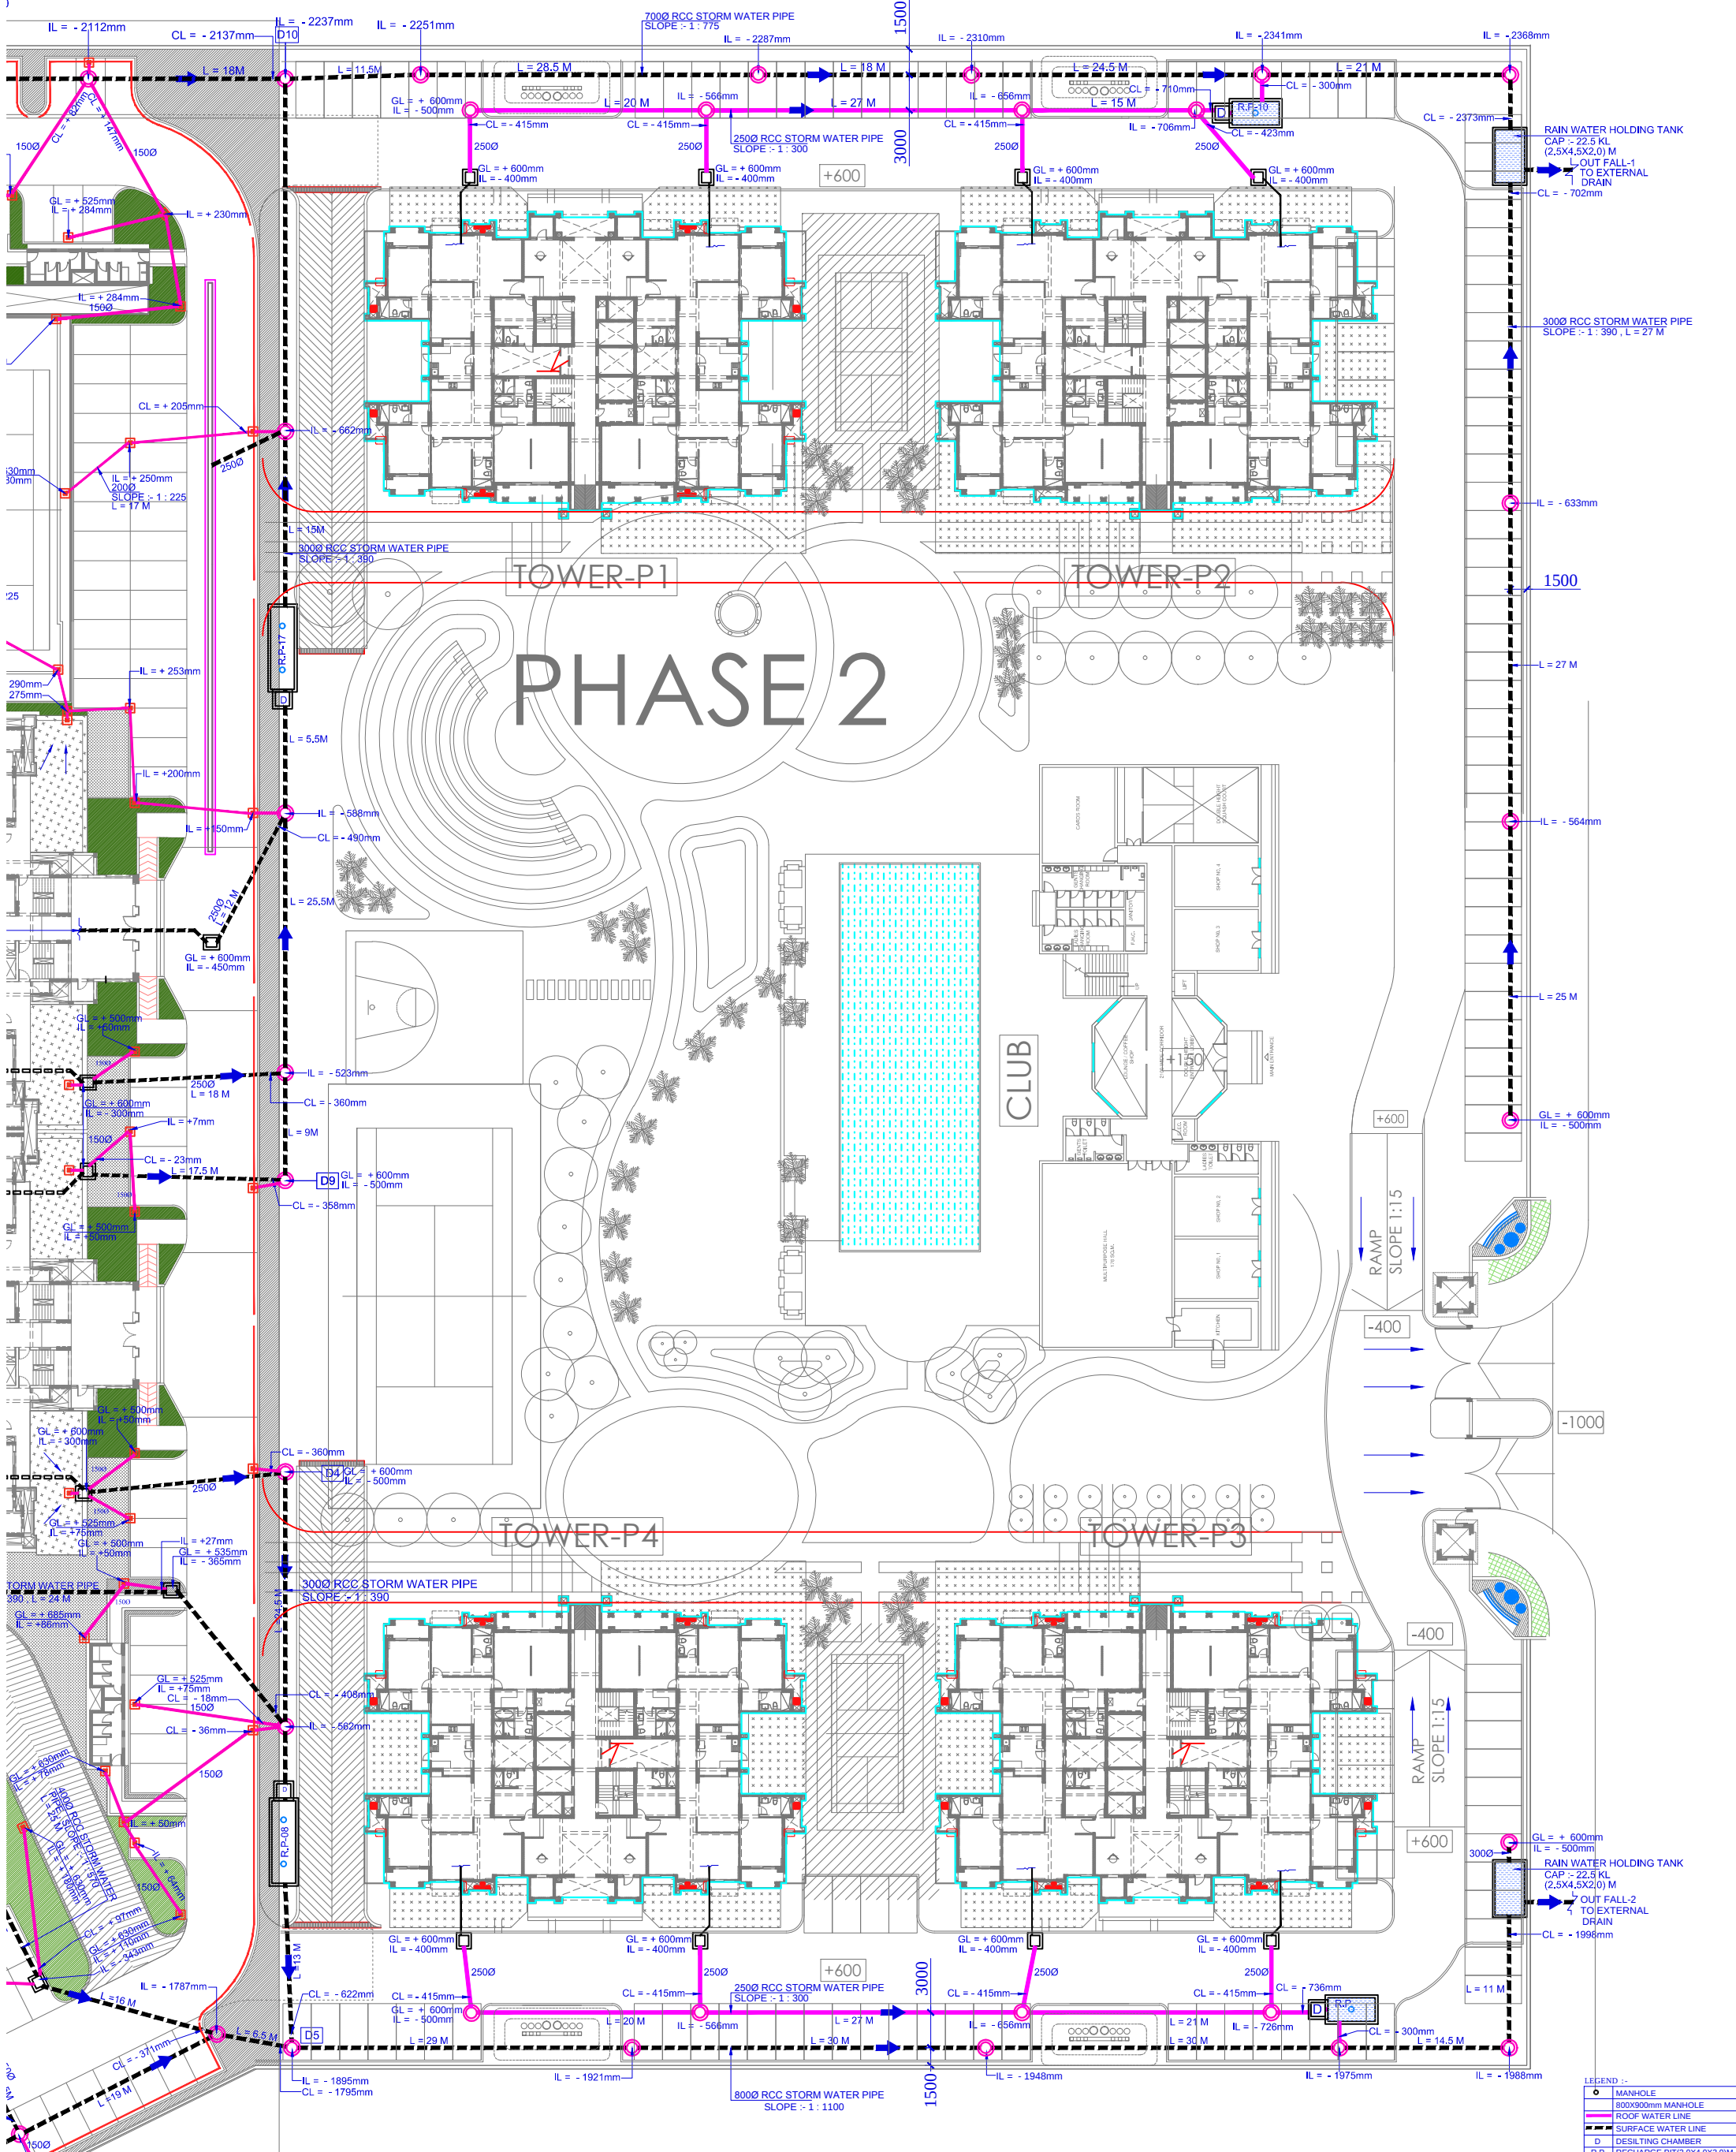

LEGEND :-

○	MANHOLE
○	800x900mm MANHOLE
—	ROOF WATER LINE
—	SURFACE WATER LINE
D	DESILTING CHAMBER
R.P.	RECHARGE PIT (2.0x4.0x3.0)M
CB	CATCH BASIN
CH	CHAMBER (300x600)mm
COP	CLEAN OUT PLUG
B.O.P.	BOTTOM OF PIPE LEVEL
B.O.C.	BOTTOM OF CUTOFF
G.L.	GROUND LEVEL
C.L.	CONNECTION LEVEL
I.L.	INVERT LEVEL

SIZE OF MANHOLE WITH REFERENCE TO DEPTH

DEPTH	SIZE OF M.H.
0.91m TO 1.67m	910mm DIA
1.68m TO 2.29m	1220mm DIA
2.30m TO 9.00m	1520mm DIA

PROJECT

ATS PRISTINE PHASE-2
SECTOR- 150
NOIDA

SHEET TITLE

SITE PLAN (PHASE-2)
(STORM WATER LAYOUT)