



NOTE. TOILET SUNK
ALL TOILET SHALL BEE 350mm
SUNK + FLOOR FINISH

NOTE. TOILET SUNK
ALL TOILET SHALL BEE 350mm SUNK + FLOOR FINISH

PLUMBING LEGEND:-

- (1) 110 OD uPVC SOIL & VENT PIPE
- (2) 110 OD uPVC WASTE & VENT PIPE
- (3) 75 OD uPVC ANTISYPHONAGE PIPE
- (4) DOMESTIC WATER DN TAKE PIPE
- (5) FLUSHING WATER DN TAKE PIPE
- (6) HOT WATER DN TAKE PIPE FROM SOLAR
- (7) DOMESTIC WATER RISER PIPE
- (8) FLUSHING WATER RISER PIPE
- (9) 110 OD uPVC RAIN WATER PIPE FOR TERRACE
- (10) 110 OD uPVC RAIN WATER PIPE FOR BALCONY
HORIZONTAL GRATING FOR BALCONY RAIN WATER

P1 = 150x150 CUTOUT
FT = FLOOR TRAP
FD = FLOOR DRAIN

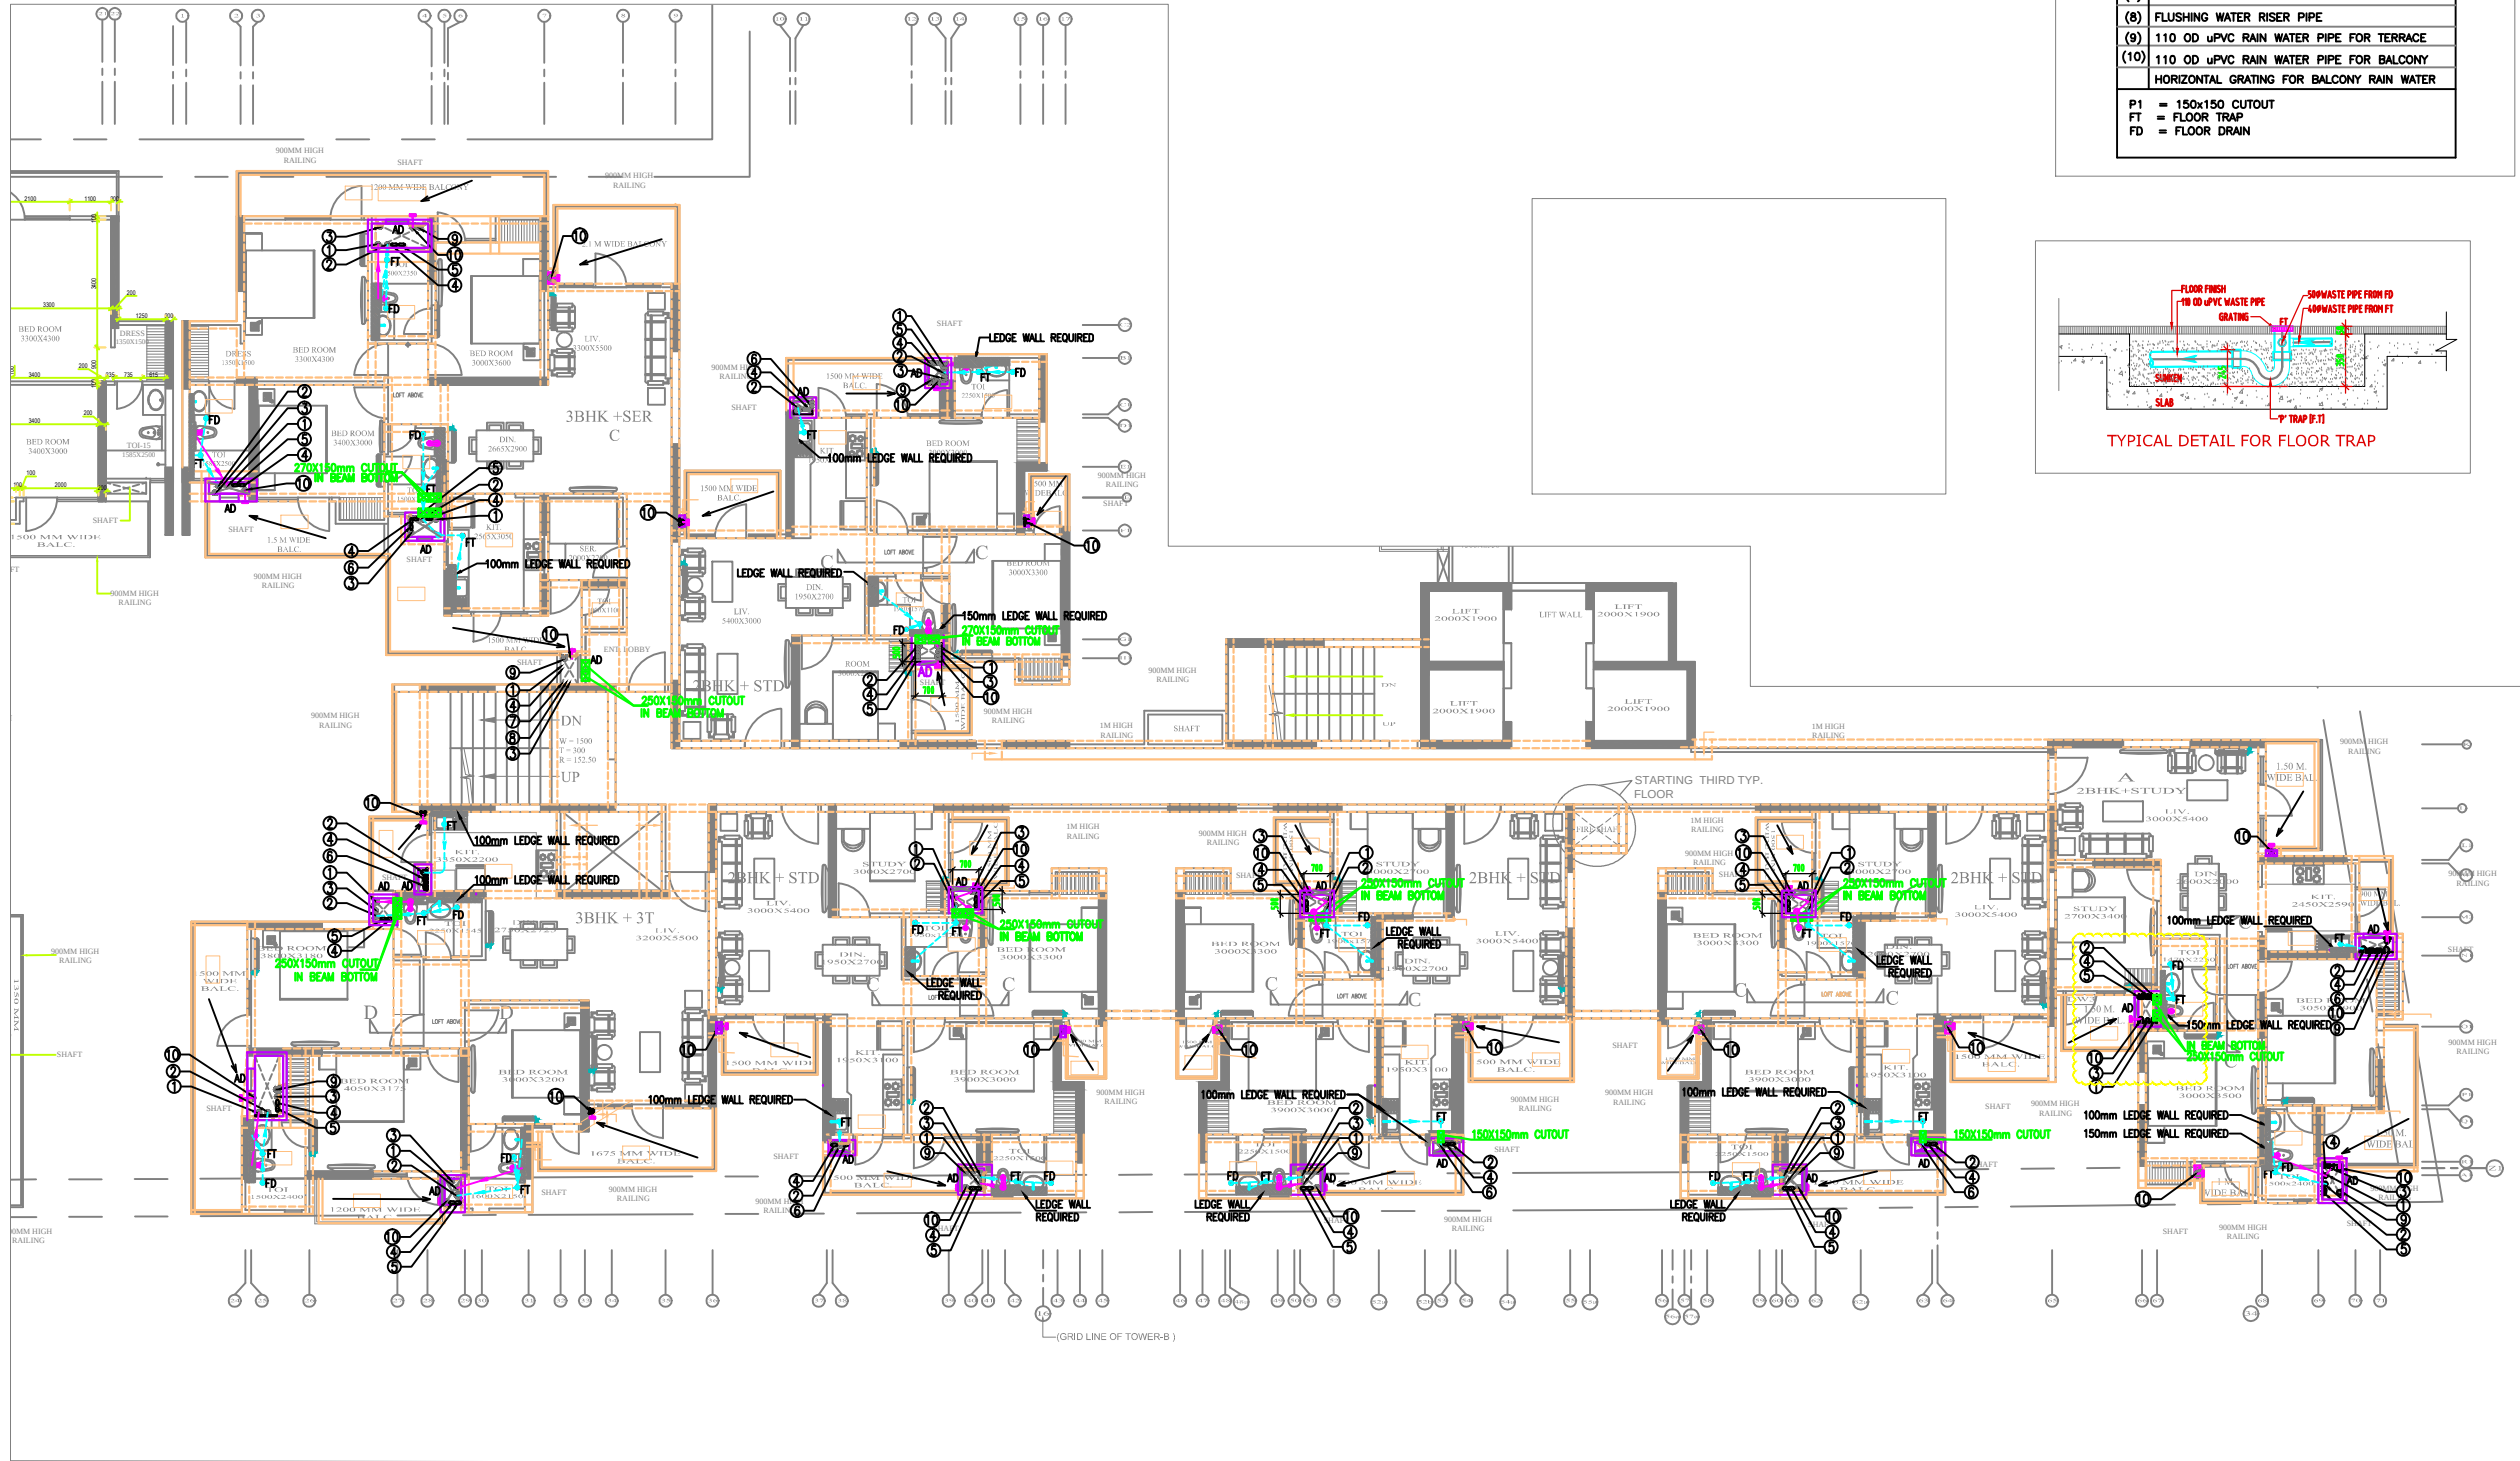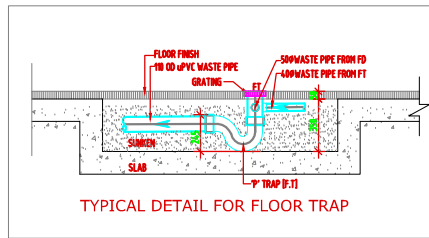

REVISIONS	DATE

CLIENT :

REAL ANCHOR PVT.LTD.

PROJECT :

PROPOSED APARTMENT FOR
M/S WORLD RESIDENCY
AT INDIRAPURAM

Building Services (MEP) Consultants

SNC

MEP Consulting Engineers

Sunil Nayyar Consultants Pvt.

Head Office : 206- 206A & 305A-305B, 2nd & 3rd Floor

Time Centre, DLF Golf Course Road,
Sector-54, Gurgaon-122002, Haryana (India)

Tele : +91-124-4803800 (30 Lines)

Fax : +91-124-4803817
E-mail : sncgurgaon@snc.co.in

URL : www.snc.co.in

□ Delhi ■ Gurgaon

SCALE	1000
-------	------

SCALE	1:100
DATE	12.11.13
CHK	JOSHI
DRN	SURENDRA

DRG. TITLE :

TOWER -B
TYPICAL FLOOR PLAN
DRAINAGE LAYOUT




DRG. NO.
SNC/WR/TB/PL-03

ARCHITECTS:

DIMENSIONS & DESIGNS
architects,engineers&interior designers

D-669, Chittranjan Park
NEW DELHI-110019 (INDIA)
PH: 011-26274473, 011-26274474

DDW

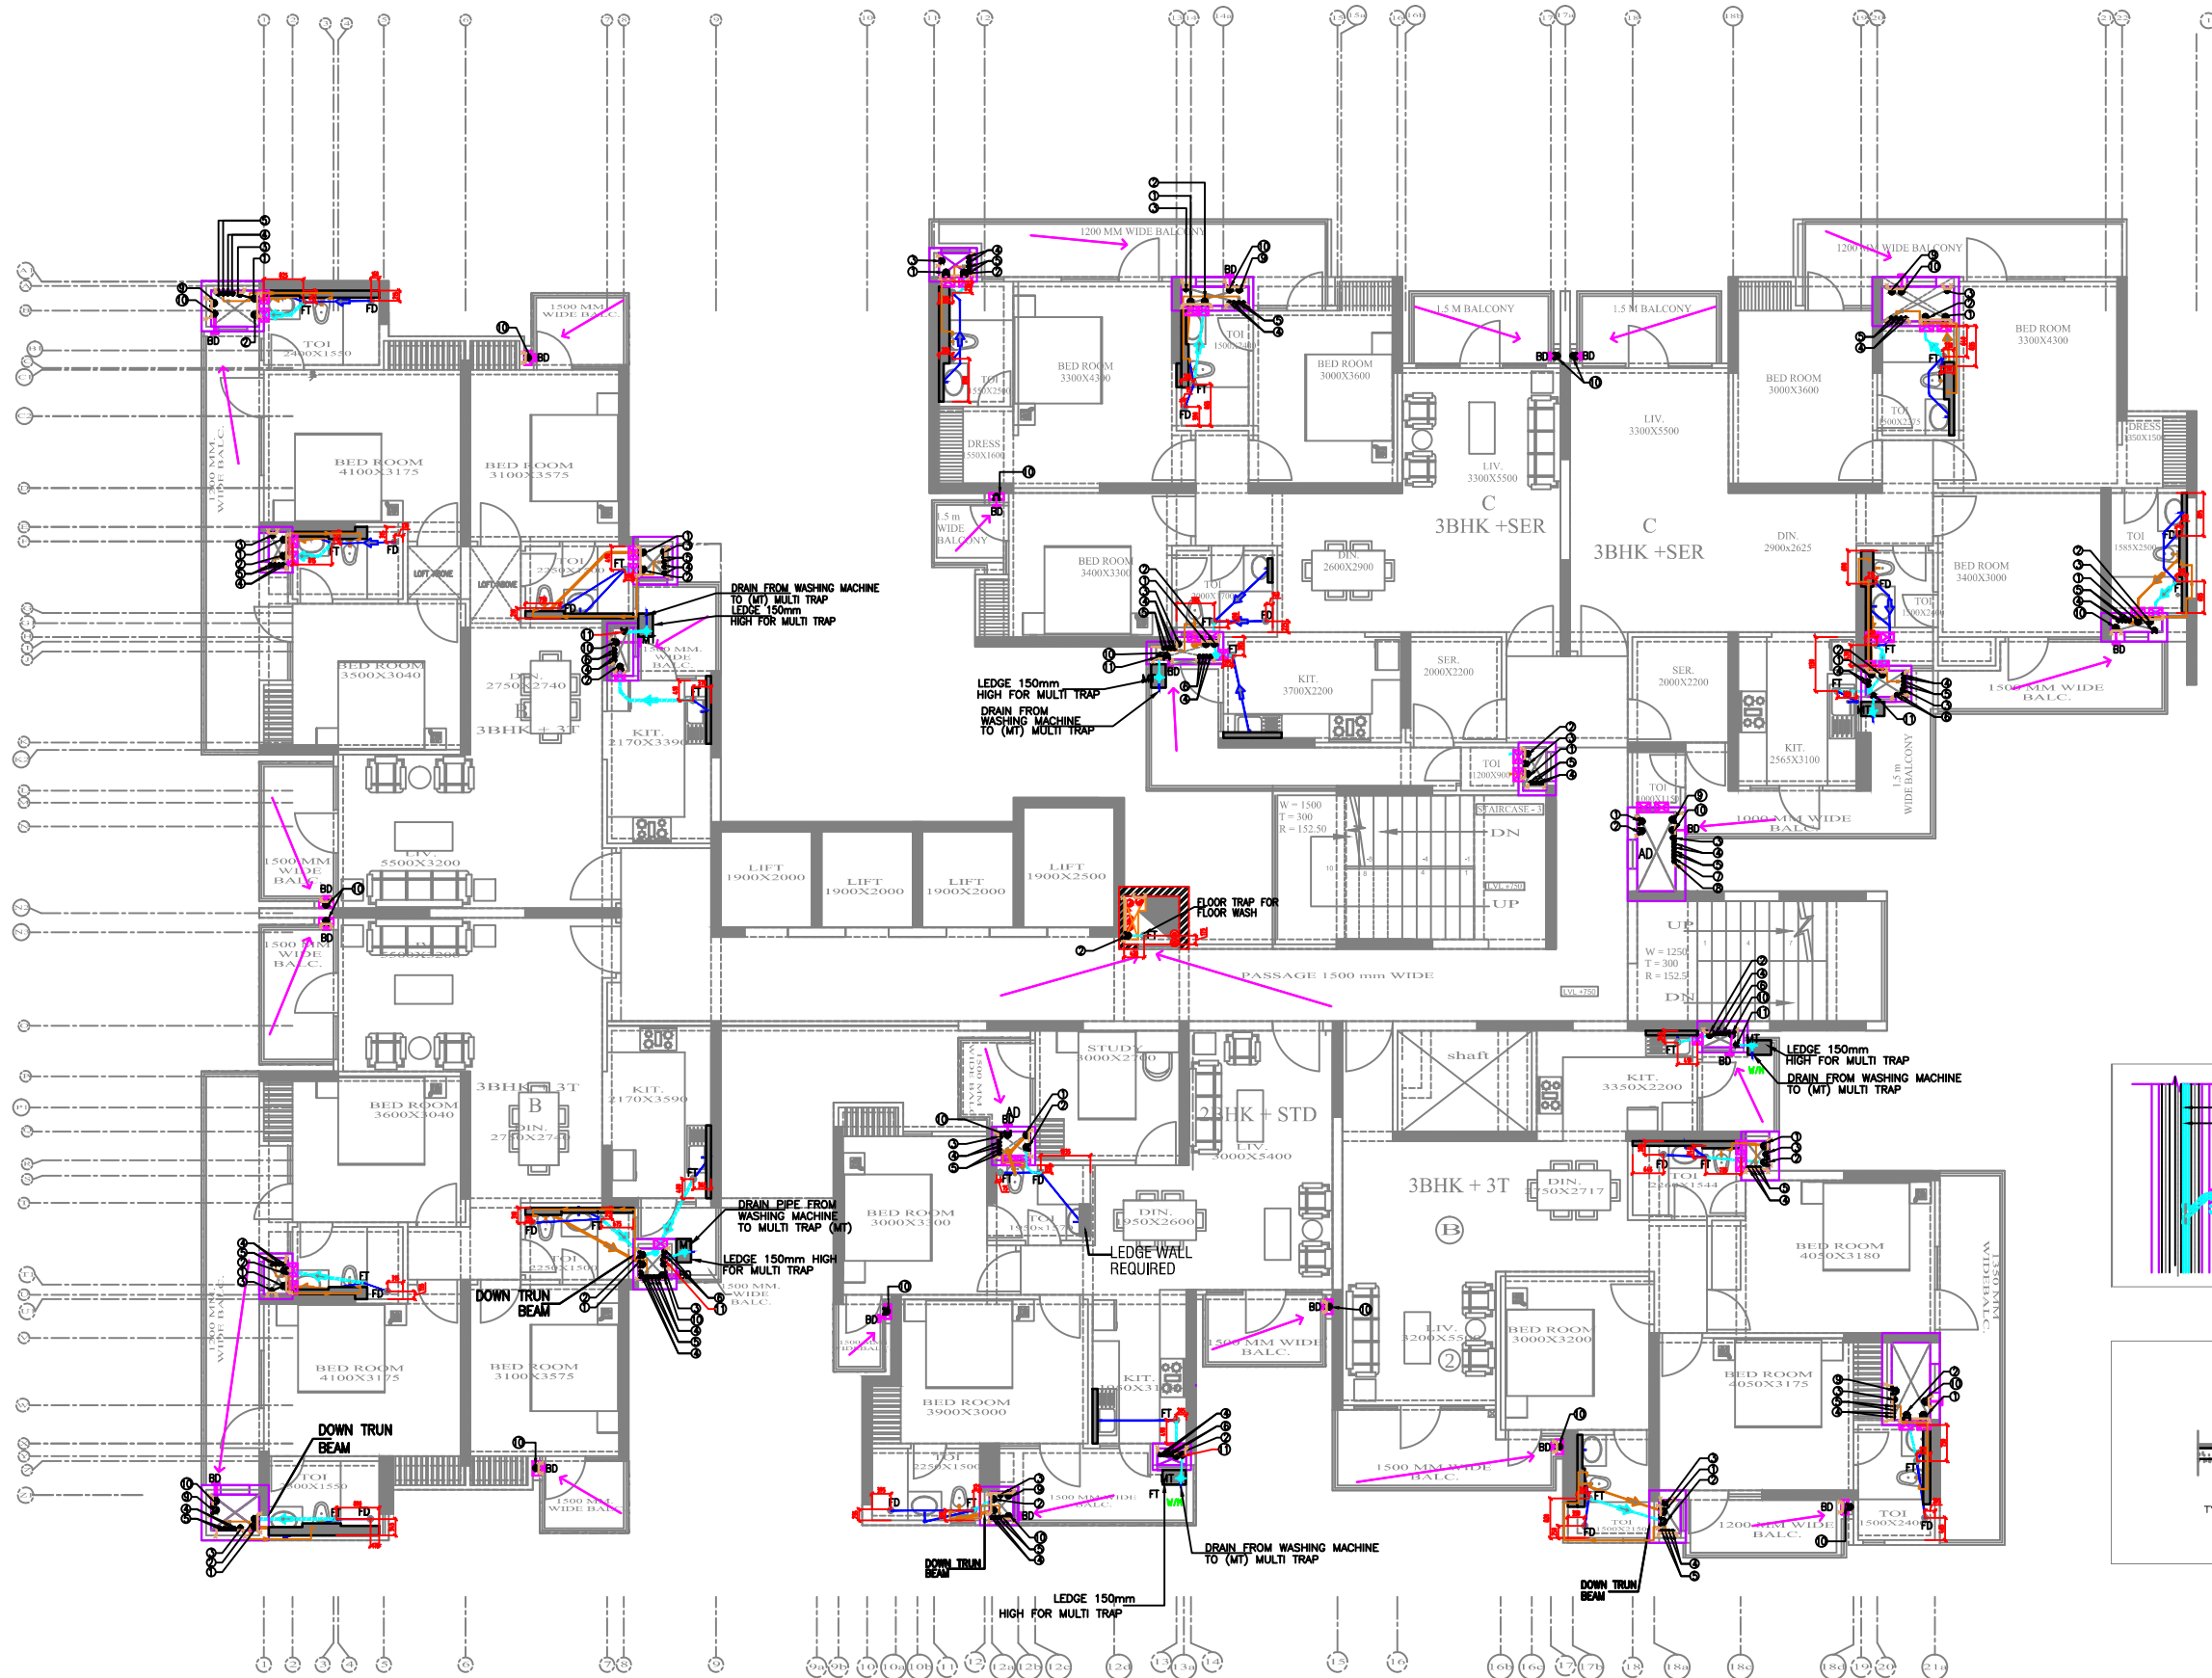

LEGEND FOR VERTICAL PIPES:	
(1)	110 OD uPVC SOIL & VENT PIPE
(2)	110 OD uPVC WASTE & VENT PIPE
(3)	75 OD uPVC ANTISYPHONAGE PIPE
(4)	DOMESTIC WATER DN TAKE PIPE
(5)	FLUSHING WATER DN TAKE PIPE
(6)	HOT WATER DN TAKE PIPE FROM SOLAR
(7)	DOMESTIC WATER RISER PIPE
(8)	FLUSHING WATER RISER PIPE
(9)	110 OD uPVC RAIN WATER PIPE FOR TERRACE
(10)	110 OD uPVC RAIN WATER PIPE FOR BALCONY
(11)	75# WASTE PIPE FOR WASHING MACHINE DRAIN.

PIPE DIA	DESCRIPTION
110 OD	SOIL PIPE FROM WATER CLOSET TO HORIZONTAL / VERTICAL STACK
110 OD	WASTE PIPE FROM FLOOR TRAP TO VERTICAL STACK
40 OD	WASTE PIPE FROM WASH BASIN TO FLOOR TRAP
50 OD	WASTE PIPE FROM SINK TO FLOOR TRAP
63 OD	WASTE PIPE FROM FLOOR DRAIN TO FLOOR TRAP

LEGEND FOR HORIZONTAL PIPES:	
—	SOIL LINE
—	WASTE LINE
—	DOM. WATER SUPPLY LINE
—	HOT WATER SUPPLY LINE
—	FLUSHING WATER SUPPLY LINE
—	VALVE/GATE VALVE

PLUMBING LEGEND:-	
●	FT FLOOR TRAP / URINAL TRAP
○	FD FLOOR DRAIN
—	BD HORIZONTAL GRATING FOR BALCONY DRAIN
—	MT MULTI TRAP FOR WASHING MACHINE
—	P1 150x150 CUTOUT FOR F.T., F.D. AND W.C.
—	BALCONY TAP FOR WASHING MACHINE HT 750 MM

REV NO.	DATE	DESCRIPTION
R-01	31.03.17	AS PER ARCHITECT/ SITE COMMENTS

REVISIONS

CLIENT :
REAL ANCHOR PVT.LTD.

PROJECT :
PROPOSED APARTMENT FOR
M/S WORLD RESIDENCY
AT INDIRAPURAM



MEP CONSULTANTS :-

KKSC
KISHOR KUMAR SERVICES CONSULTANTS

CONTRACTOR:-
JAPIN JACOB WIRE DRAWING PVT.LTD.
(FIRE FIGHTING & CONSULTING DIVISION)

DRG. TITLE:-
TOWER -A
TYPICAL FLOOR PLAN
(PLUMBING SERVICES LAYOUT)

DRAWN UMESH	SCALE 1:75	REVISION NO. R-01
DRG. TITLE:- RAM KUMAR	DRG. NO. SH-PL-TR-A-DR-02	

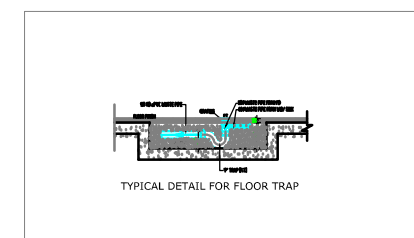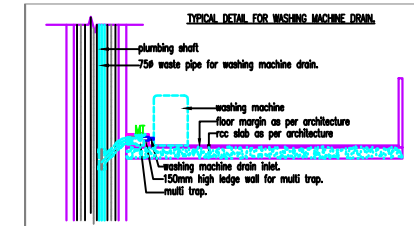

SHOP DRAWING