


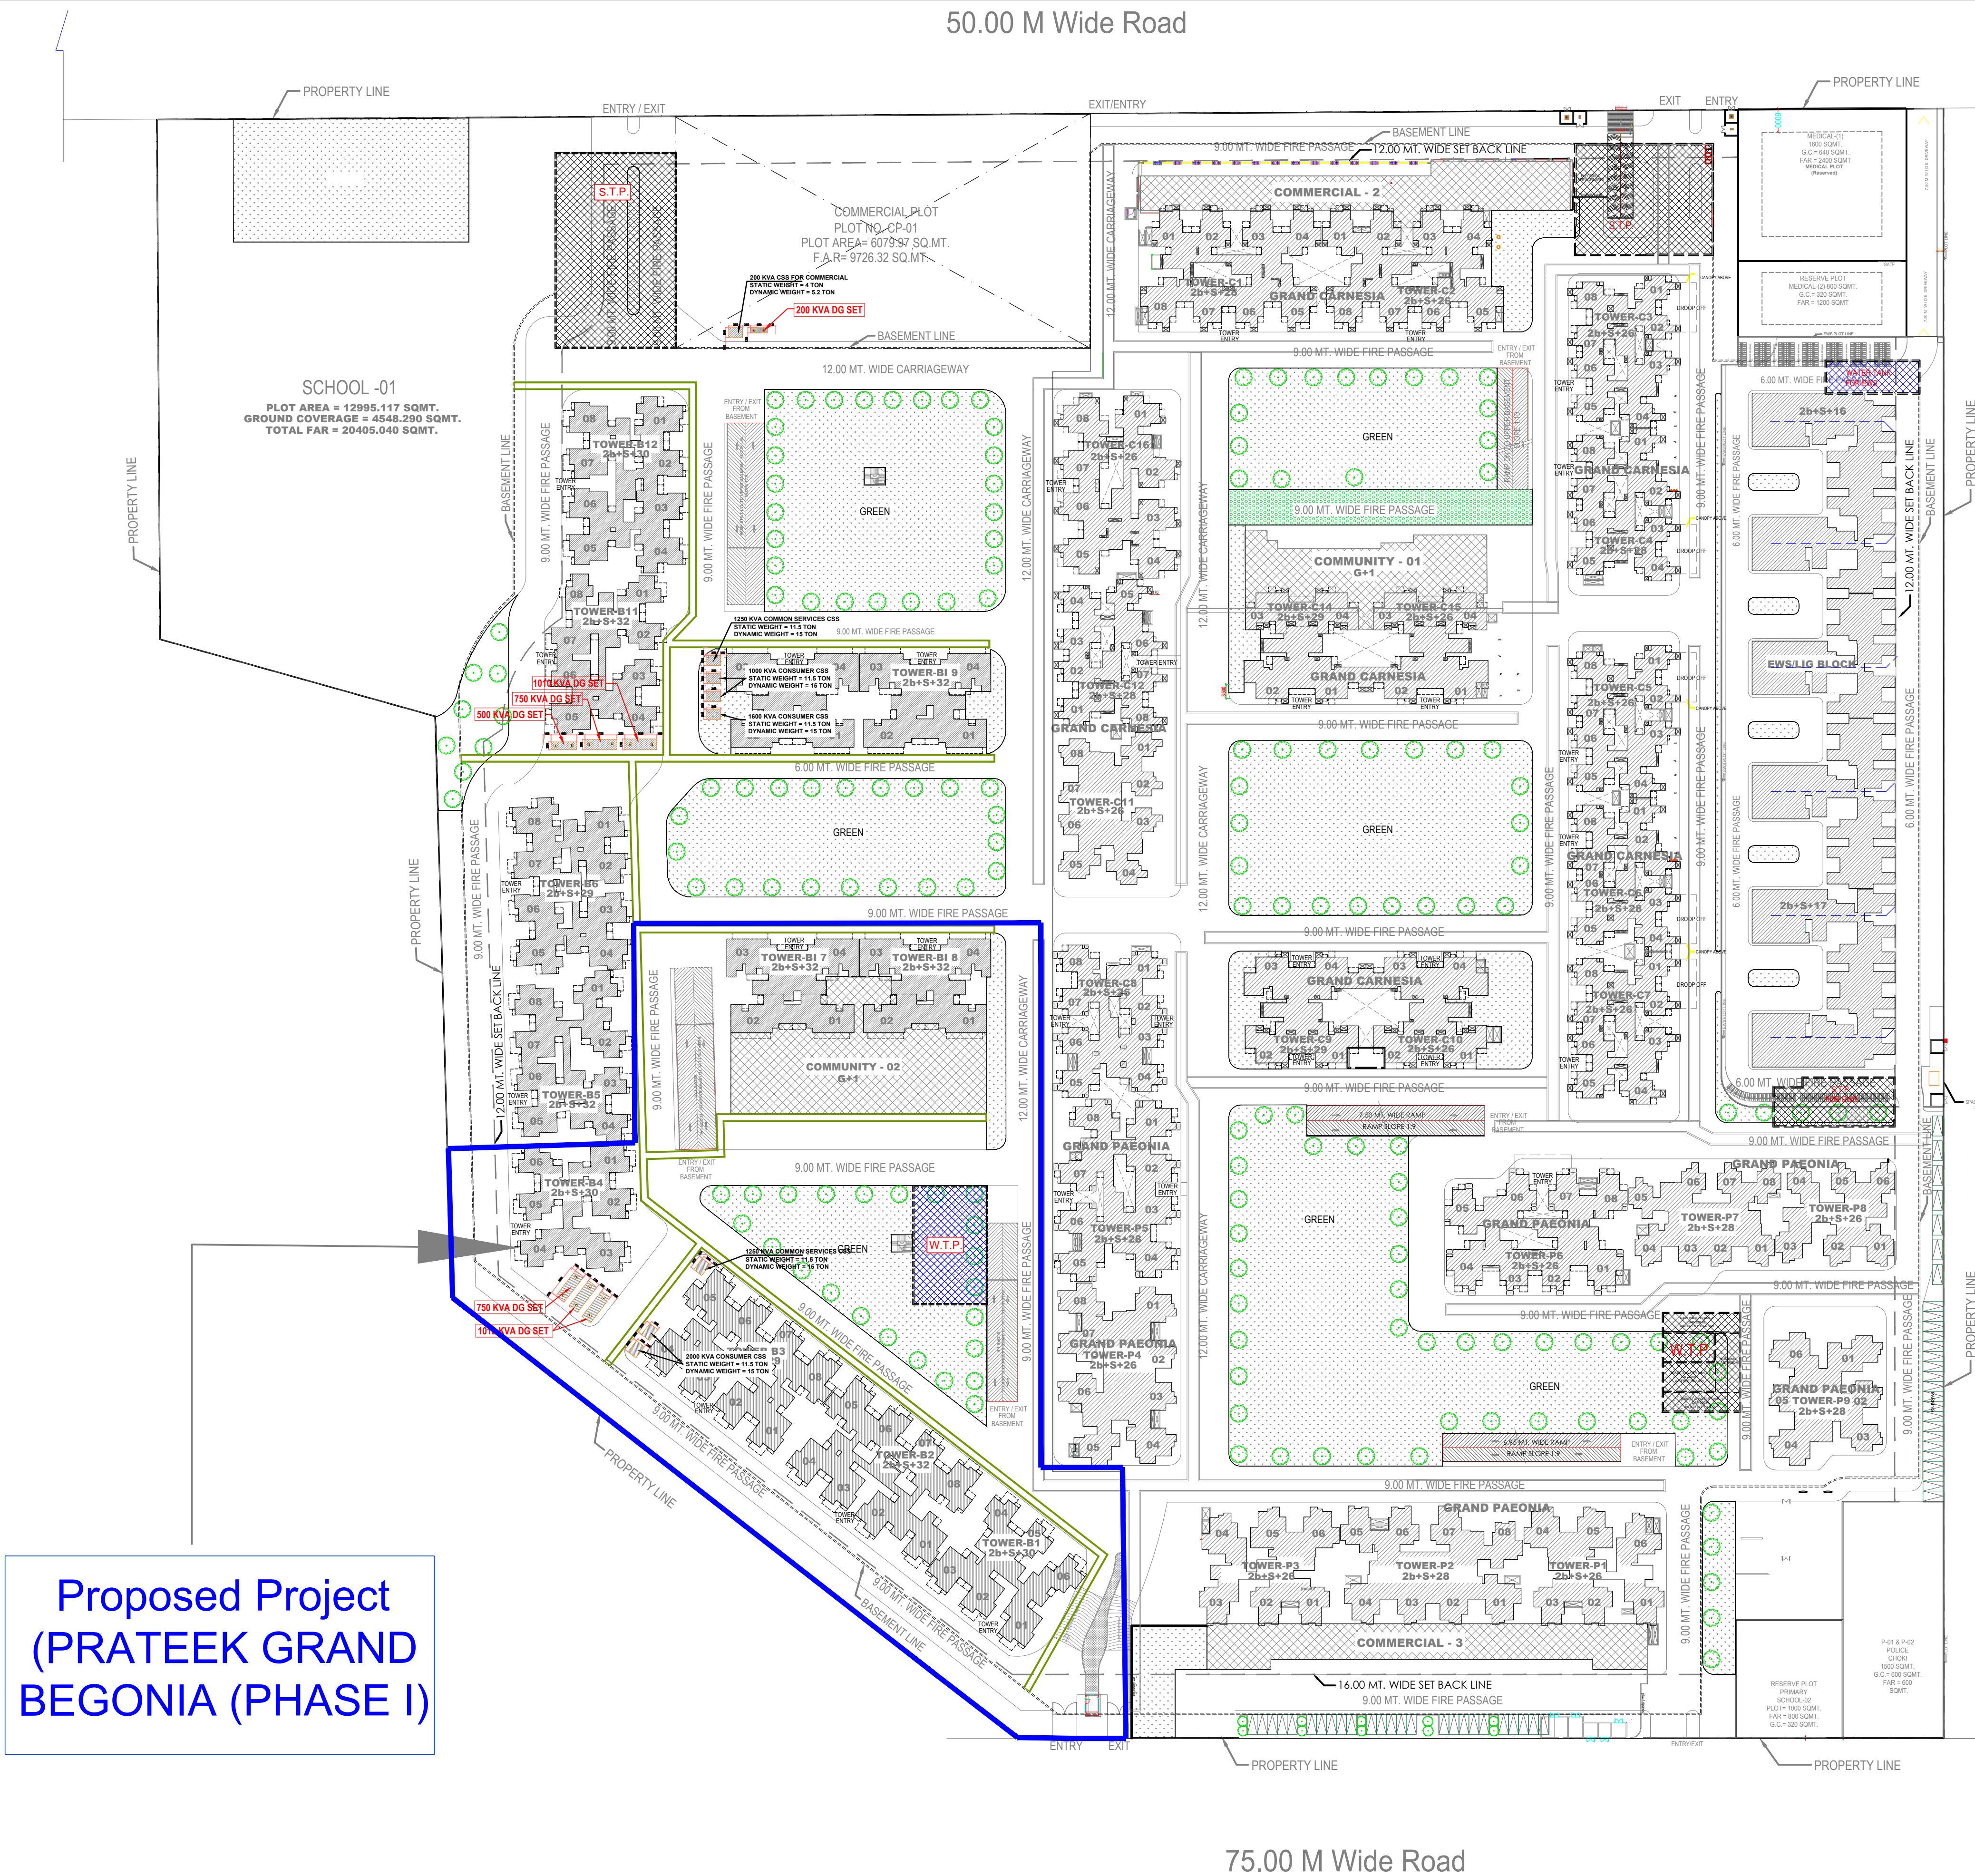

Proposed Project
(PRATEEK GRAND
BEGONIA (PHASE I))

Rev. No.	Date	Revision

project
PRATEEK GRAND CITY
SIDDHARTH VIHAR , GHAZIABAD

title
SITE PLAN

subtitle
EXTERNAL ELECTRICAL DRAWING

drawing released for
☐ APPROVAL ☒ SUBMISSION
☐ ADVANCE COPY ☐ CONSTRUCTION

drg. no. PGC / SP / PL - 04 drawn by Samsher Singh

scale 1:900 @ A1 designed by M.Mansoor

date 02.05.2022 checked by ANAND HAVELIA

architects
Architect Hafeez Contractor
29 Bank Street, Bombay 23, Tel: +91 22 22661920 ----- fax: +91 22 22664737
www.architecthafeezcontractor.com email: hafeez@hcontractor.com

services consultant
Consummate Engineering Services (P) Ltd.
Noida Office : B - 67, Sector - 67, Noida - 201 301
Tel : (0120) 2593300 (30 Lines)
Lko Office : R 006, Rohas Plumeria, Gomti Nagar, Lucknow
e mail : mail@cespln, website : www.cespln