


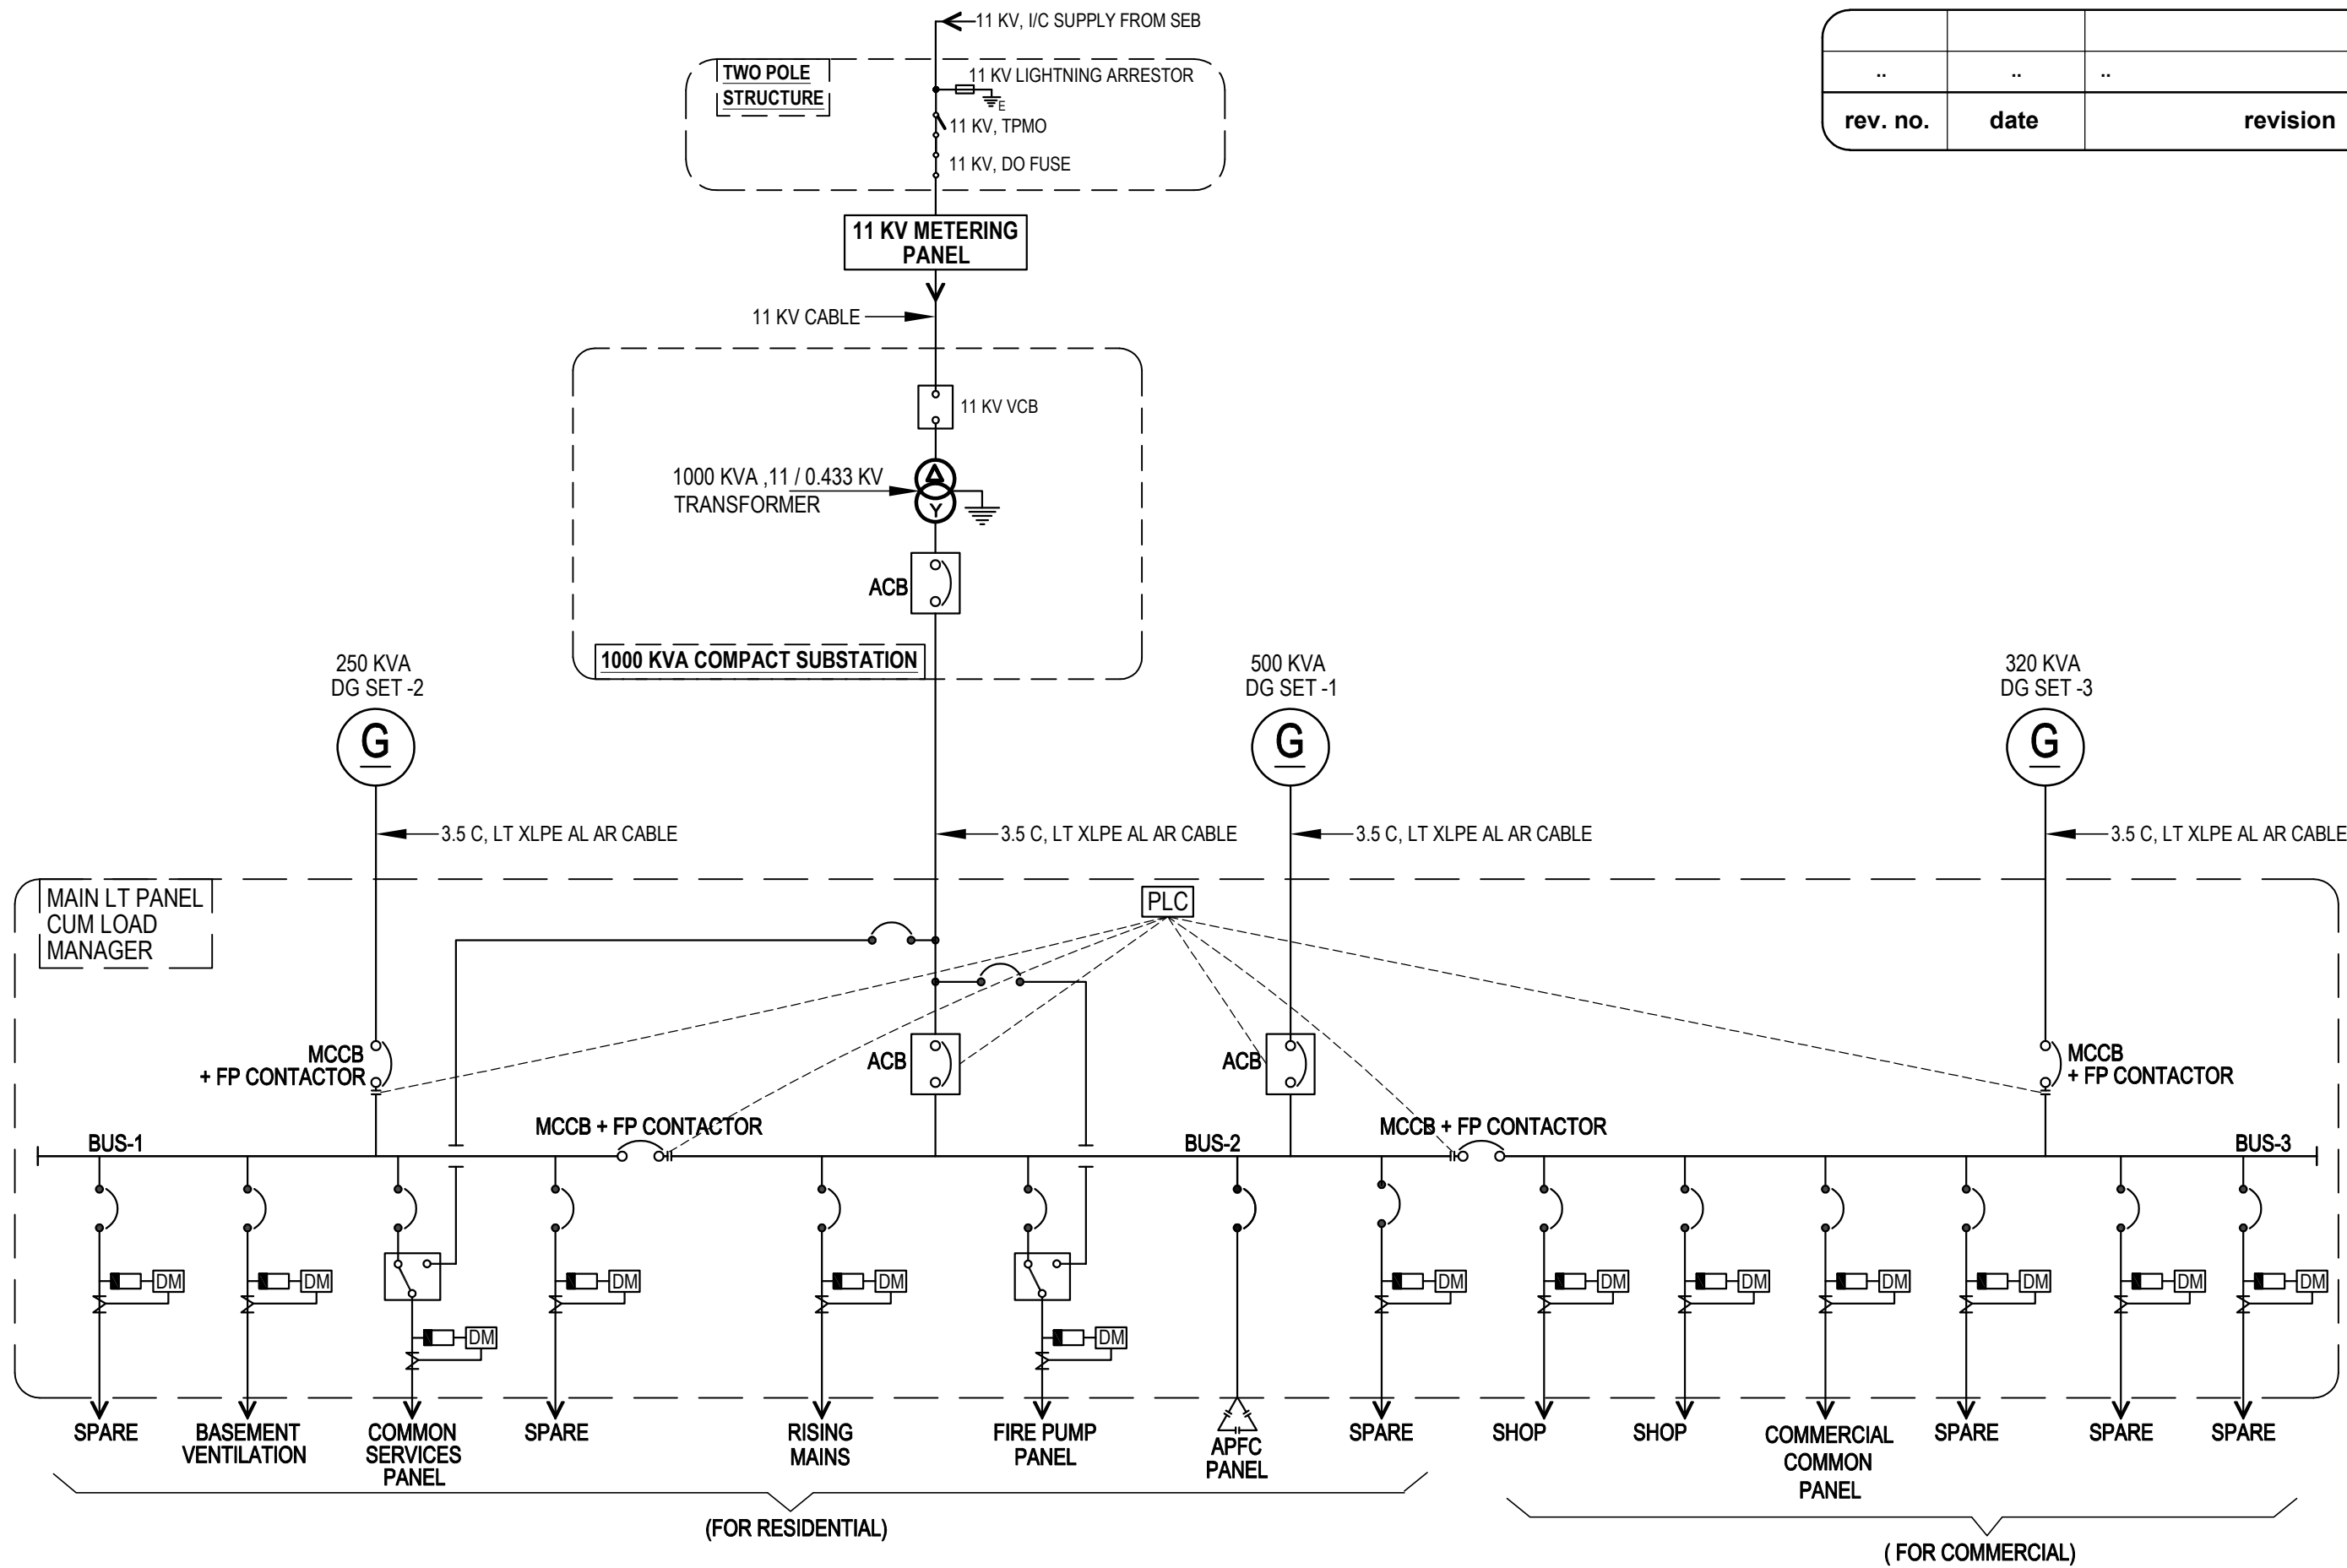

..	..	..
rev. no.	date	revision

project **GROUP HOUSING / COMMERCIAL & PROPOSED NEW BLOCK GROUP HOUSING ON PLOT-TCG 3 / 3, VIBHUTI KHAND, AT GOMTI NAGAR, LUCKNOW**

title **ELECTRICAL DRAWING
MAIN SINGLE LINE DIAGRAM**

drg. no.
ST / LKO / EE - 02

date
Dec. 2017

scale
N.T.S.

released for
INFORMATION

drawn by
Mandeep

ckd by
Anand Havelia

architects
DESIGN GROUP
ARCHITECTS ENGINEERS INT.DESIGNERS
HALWASIYA COURT HAZRATGANJ LUCKNOW

services consultant
Consummate Engineering Services (P) Ltd.
Noida Office : B - 67, Sector - 67, Noida - 201 301, Tel : (0120) 6943500 (24 Lines)
Lko. Office : R 006, Rohtas Plumeria, Gomti Nagar, Lucknow,
e mail : mail@cespl.in, website : www.cespl.in

1) Clear height of 11 KV Meter / VCB room shall be minimum 3.6 mtr.

