



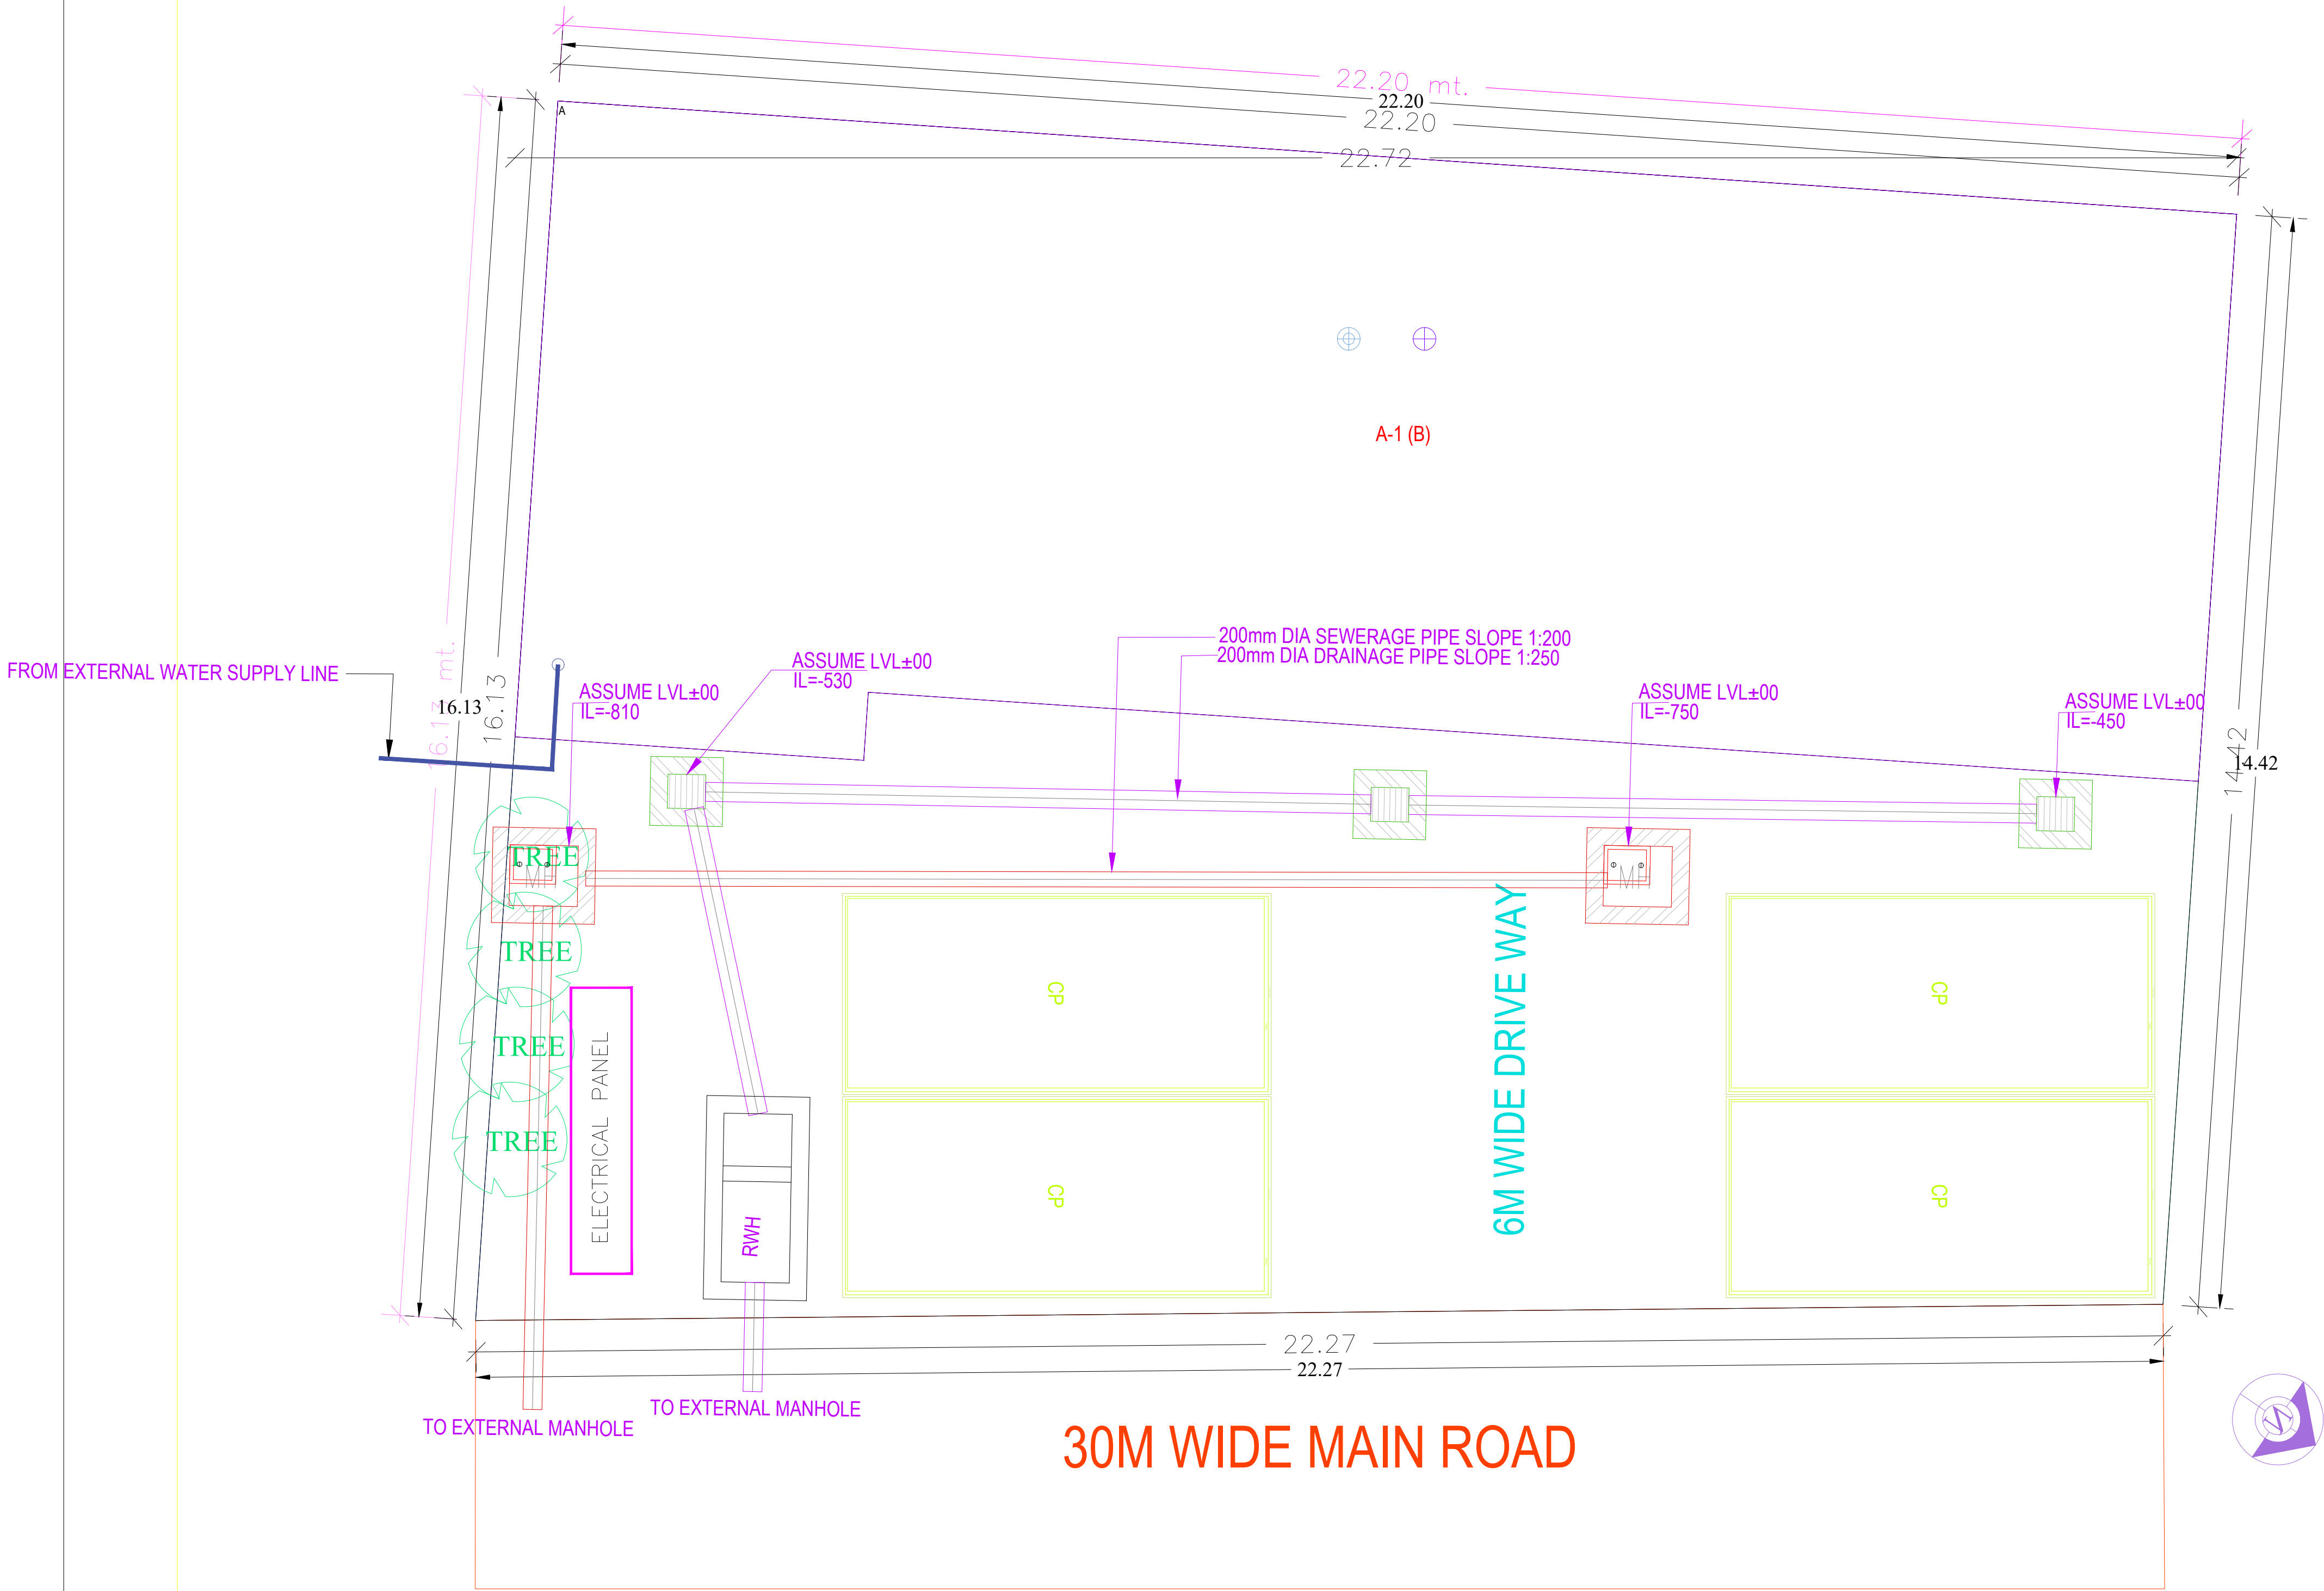

SITE PLAN

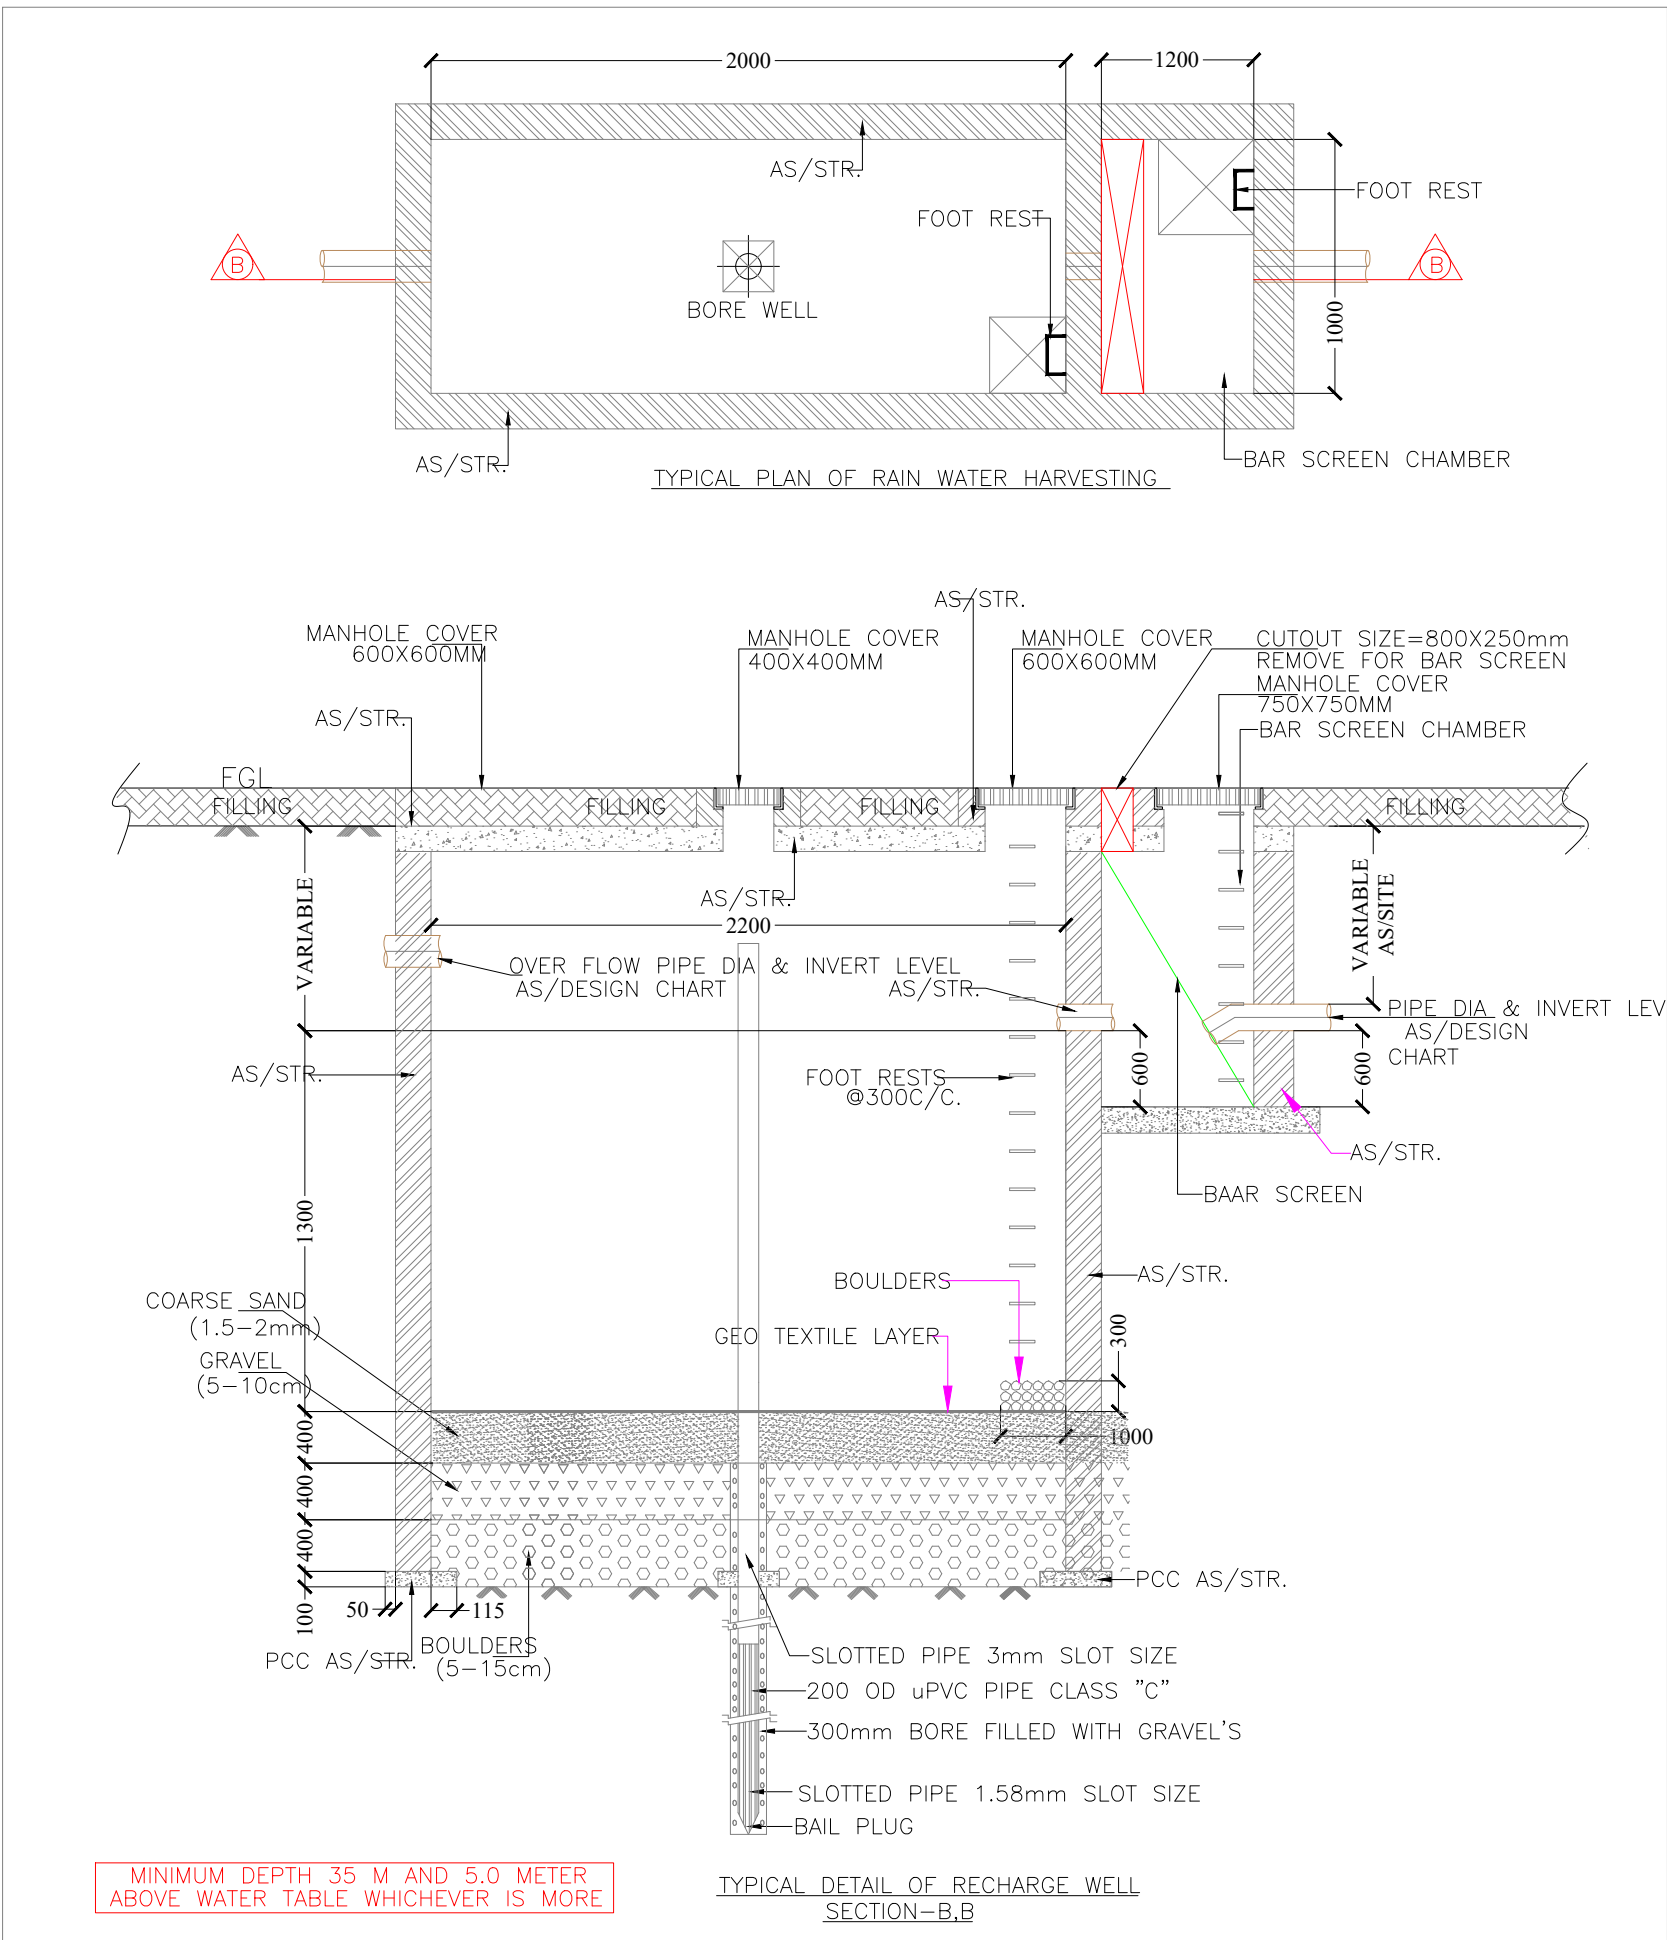

LEGENDS FOR PLUMBING:-	
	RAIN WATER HARVESTING PIT
	MANHOLE FOR DRAINAGE
	MANHOLE FOR SEWERAGE
	DRAINAGE LINE
	SEWERAGE LINE
	WATER SUPPLY LINE

LEGENDS FOR ELECTRICAL:-	
	ELECTRICAL PANEL

COPY	REV.	DATE	DESCRIPTION
PROJECT			
PROPOSED SECTOR SHOPPING 2 AT KHASRA NO.:1231,1232,1233,1234,1242,1243,1244,1245 & 1252VILLAGE - NOOR NAGAR GHAZIABAD (U.P.)			
CLIENT			
FOR BABA CONSTRUCTION PRIVATE LTD.			
ARCHITECTS			
SINGLA ARCHITECTS & ASSOCIATES EROS MARKET PLACE, PLOT NO-02, SHOP - 87 1ST FLOOR SHAKTI KHAND - 2, INDIRAPURAM, GHAZIABAD (U.P.) Mob: 9971998445 e-mail : gsingla32@gmail.com,			
DRAWING TITLE			
EXTERNAL SERVICES PLAN			
SCALE		DRAWN BY	
AS SPECIFIED		APPROVED BY	
GAURAV SINGLA			
DRG.NO.	BABA-AR-DR-01		