


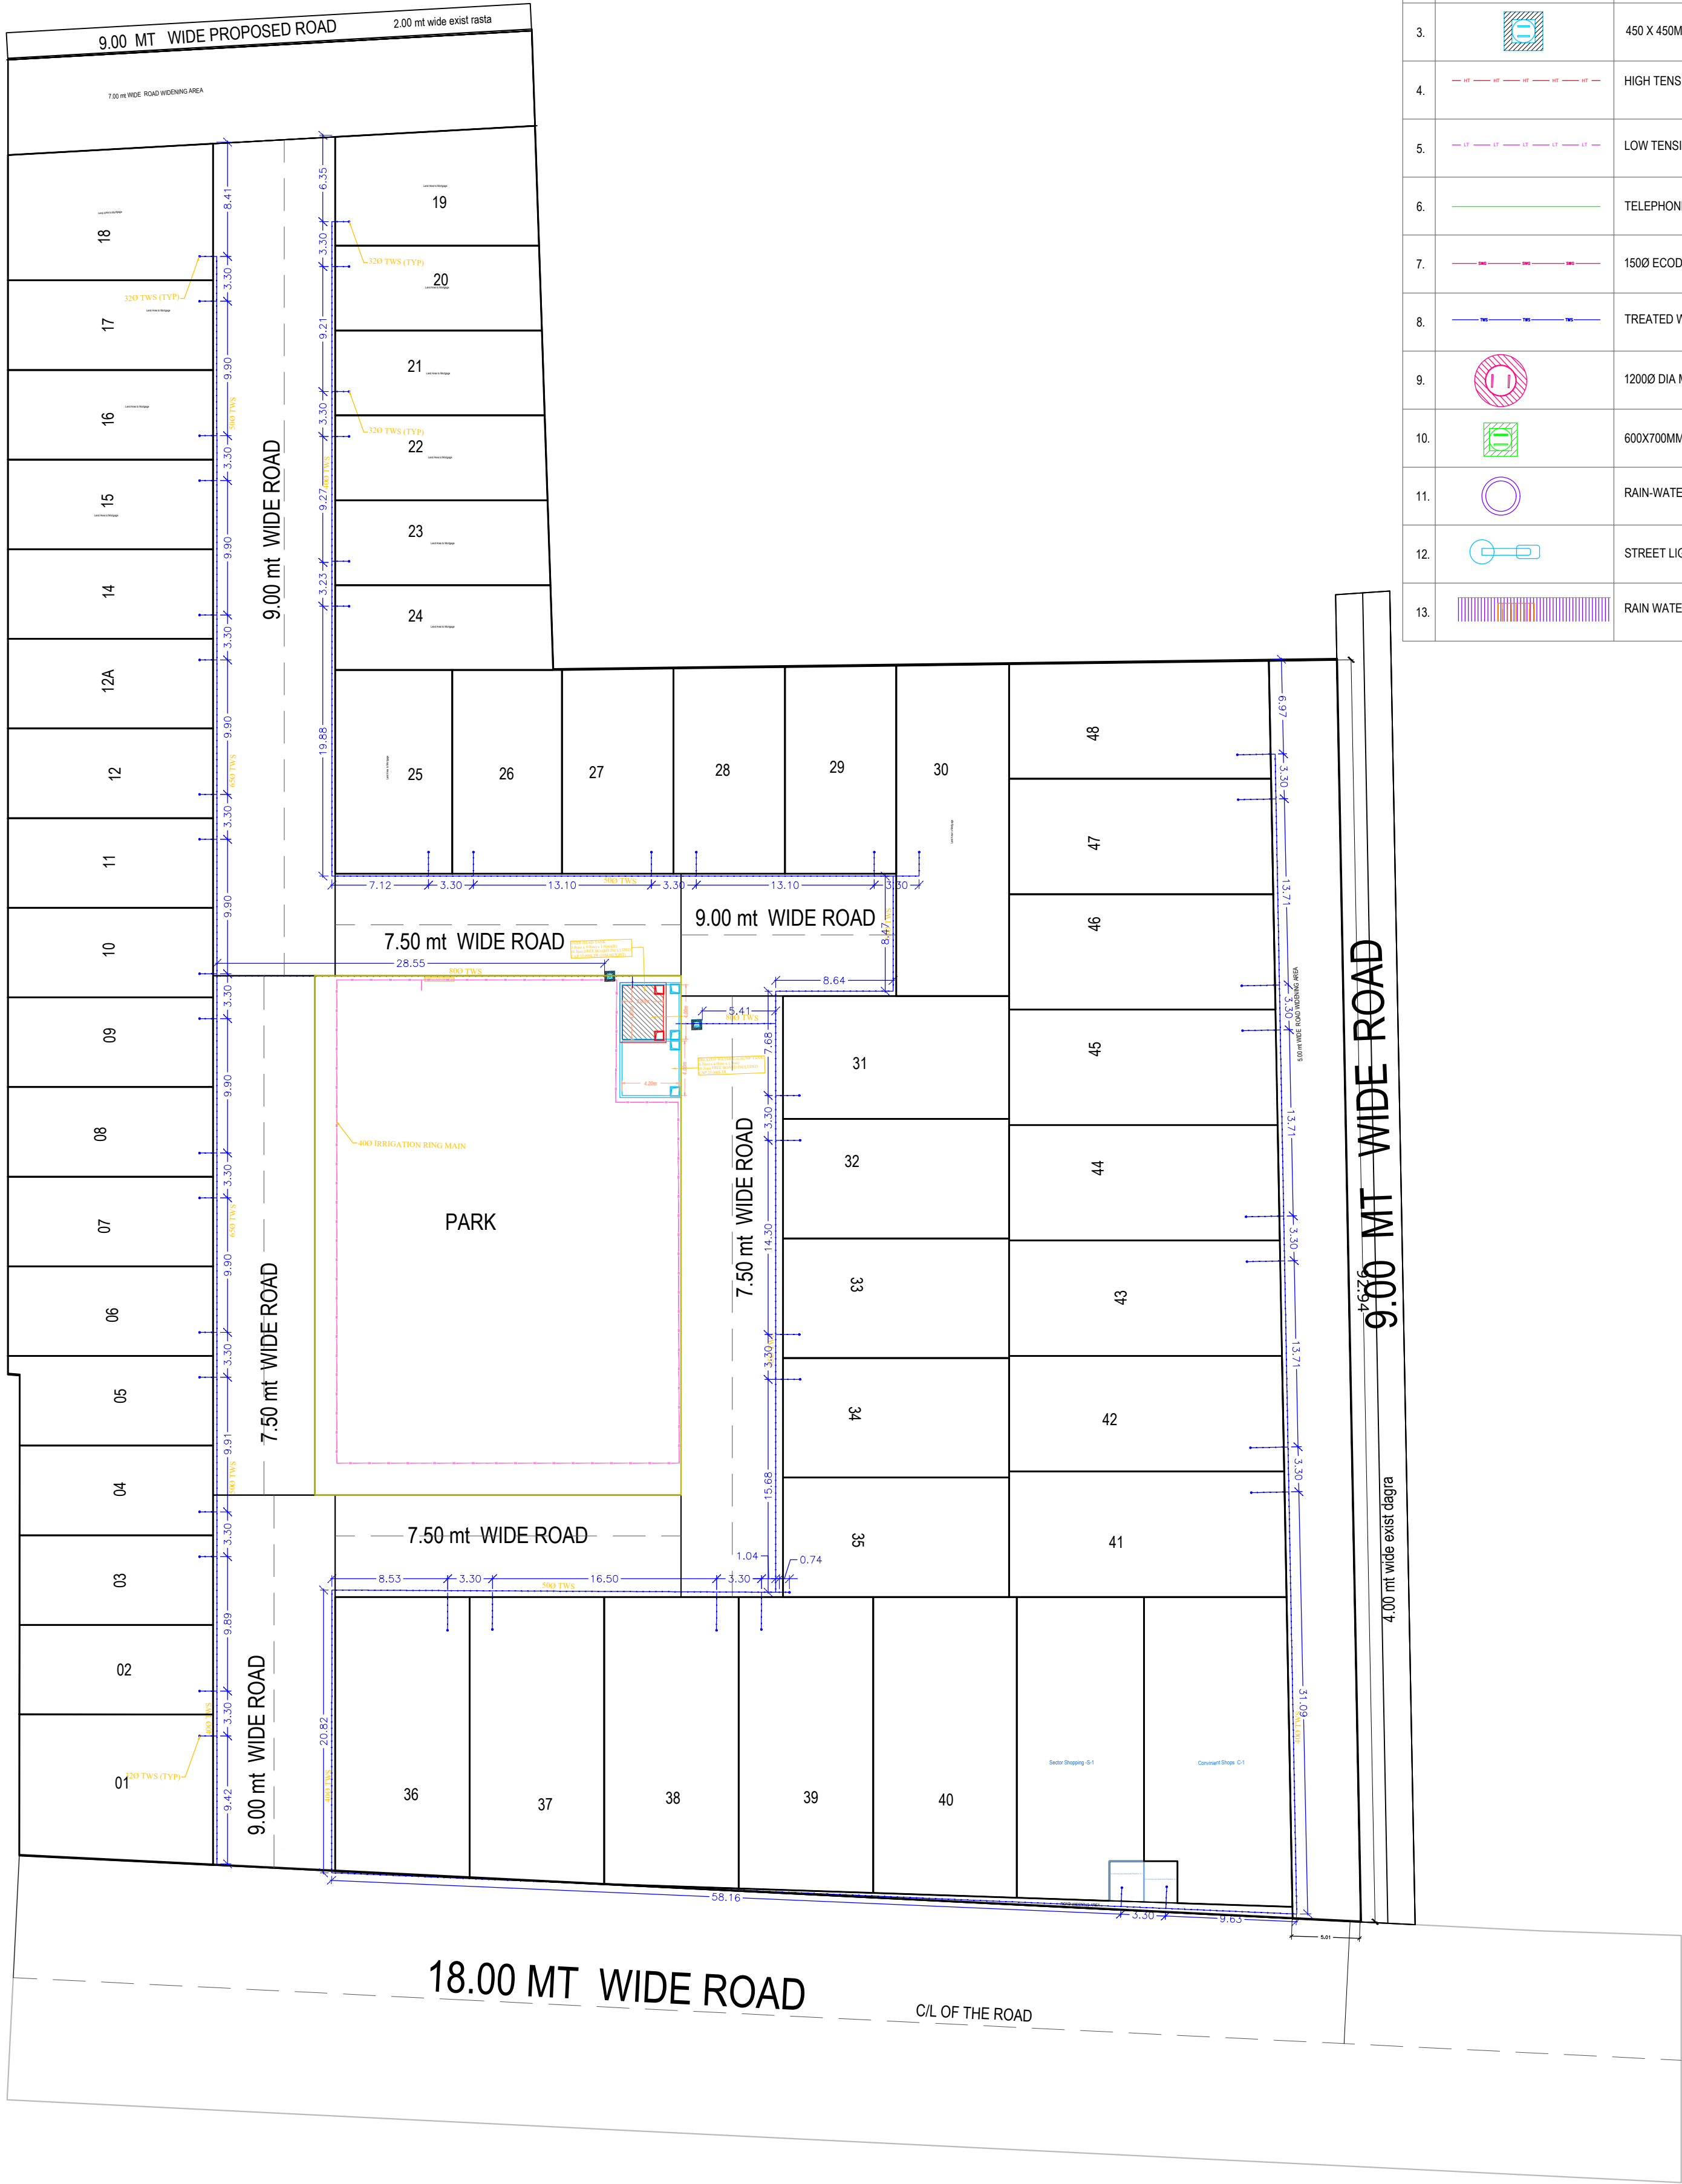

LEGEND		
1.	IL	INVERT LEVEL
2.	GL	GROUND LEVEL
3.		450 X 450MM VALVE CHAMBER
4.		HIGH TENSION WIRE
5.		LOW TENSION WIRE
6.		TELEPHONE CABLE
7.		1500 ECODRAIN PIPE
8.		TREATED WATER SUPPLY PIPE
9.		12000 DIA MANHOLE CHAMBER
10.		600X700MM ELECTRIC CHAMBE
11.		RAIN-WATER SOAK PIT
12.		STREET LIGHT
13.		RAIN WATER DRAIN

ARCHITECTURE CONSULTANT		PROJECT TITLE		CLIENT NAME	DWG. REFERENCE	DRAWING NUMBER	REV	ORIENTATION	
Drawn By	AR. AYUSHI JAIN	GROUP HOUSING		DRAWING TITLE SITE PLAN- WATER SERVICES LAYOUT					
Checked By	AR. ANKUR CHHABRA								
Drawing Status	IN PROCESS			DATE 21.04.2025	SCALE N.T.S	UNIT METRIC	STATUS IN PROCESS		