


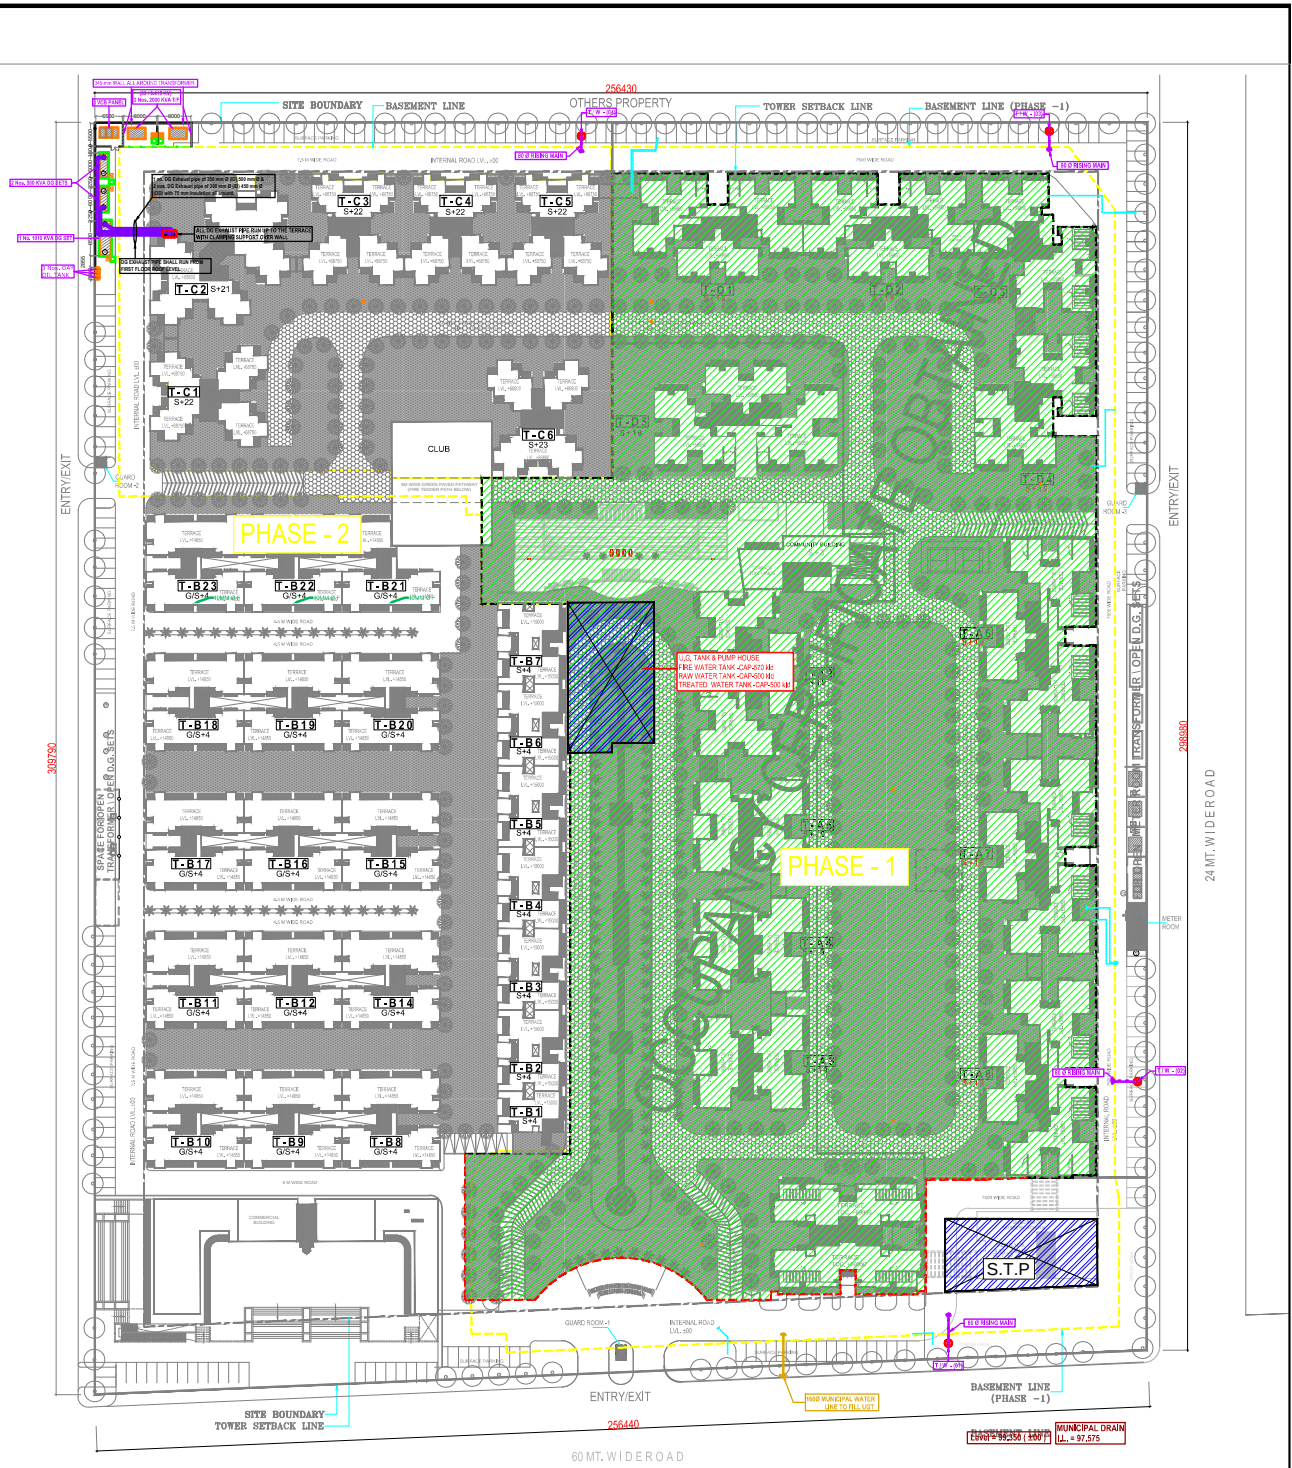

NOTE:
CLEAR HEIGHT OF ROLLING SHUTTER = 3000 MM (MIN) FROM FFL

IMPORTANT NOTES:

1. TRANSFORMER & DG SETS FOUNDATION SHALL BE GIVEN BY VENDOR.
2. VCB PANEL SIZE SHALL BE GOT APPROVED FROM CONSULTANT BEFORE PLACEMENT OF ORDER.
3. EXACT LOCATION OF CABLE TRENCH SHALL BE FINALIZED AFTER GETTING THE DETAIL OF GROUND PLATE BY HT PANEL.

NOTES: FOR HT, LT & VCB ROOM

- 1) Clear height of 33 KV Meter room shall be minimum 3.6 mtr. below clear beam.
- 2) Pitch Level of Meter room & VCB room shall be 600 mm above final finished ground level.
- 3) Trench depth shall be finalized after receiving foundation detail of HT Meter Panel & 33 KV VCB Panel.
- 4) Ventilation to be planned as per architecture accordingly.

Project
PROPOSED GROUP HOUSING
FOR NIRALA HOUSING PVT. LTD.
Plot no. GH-03, sector 16, GREATER NOIDA

title
ELECTRICAL DRAWING
subsite
MEP SETTING-OUT LAYOUT
AT SITE PLAN

Drawing released for
☐ APPROVAL
☐ ADVANCE COPY
☒ SUBMISSION
☐ CONSTRUCTION

deg. no.
NIRALA / ELEC / EXT - 01
scale
A1@1:500
date
January, 2020

Drawn by
Najmul
designed by
Alamgir Ur Rehman
checked by
Anand Hossain

architects
BHATNAGAR AND ASSOCIATES
BUILDING NO-A2, CHATRAPUR ENCLAVE,
PHASE-2, NERULDUNG-110004

services consultant
Consummate Engineering Services (P) Ltd.
Noida Office : B-07, Sector-07, Noida - 201 301
Tel : (0120) 2330300 (24 Lines)
Uttar Office : B-08, Noida Phase-01, Gazi Nagar, Lucknow
e-mail : mail@cespi.in, website : www.cespi.in