


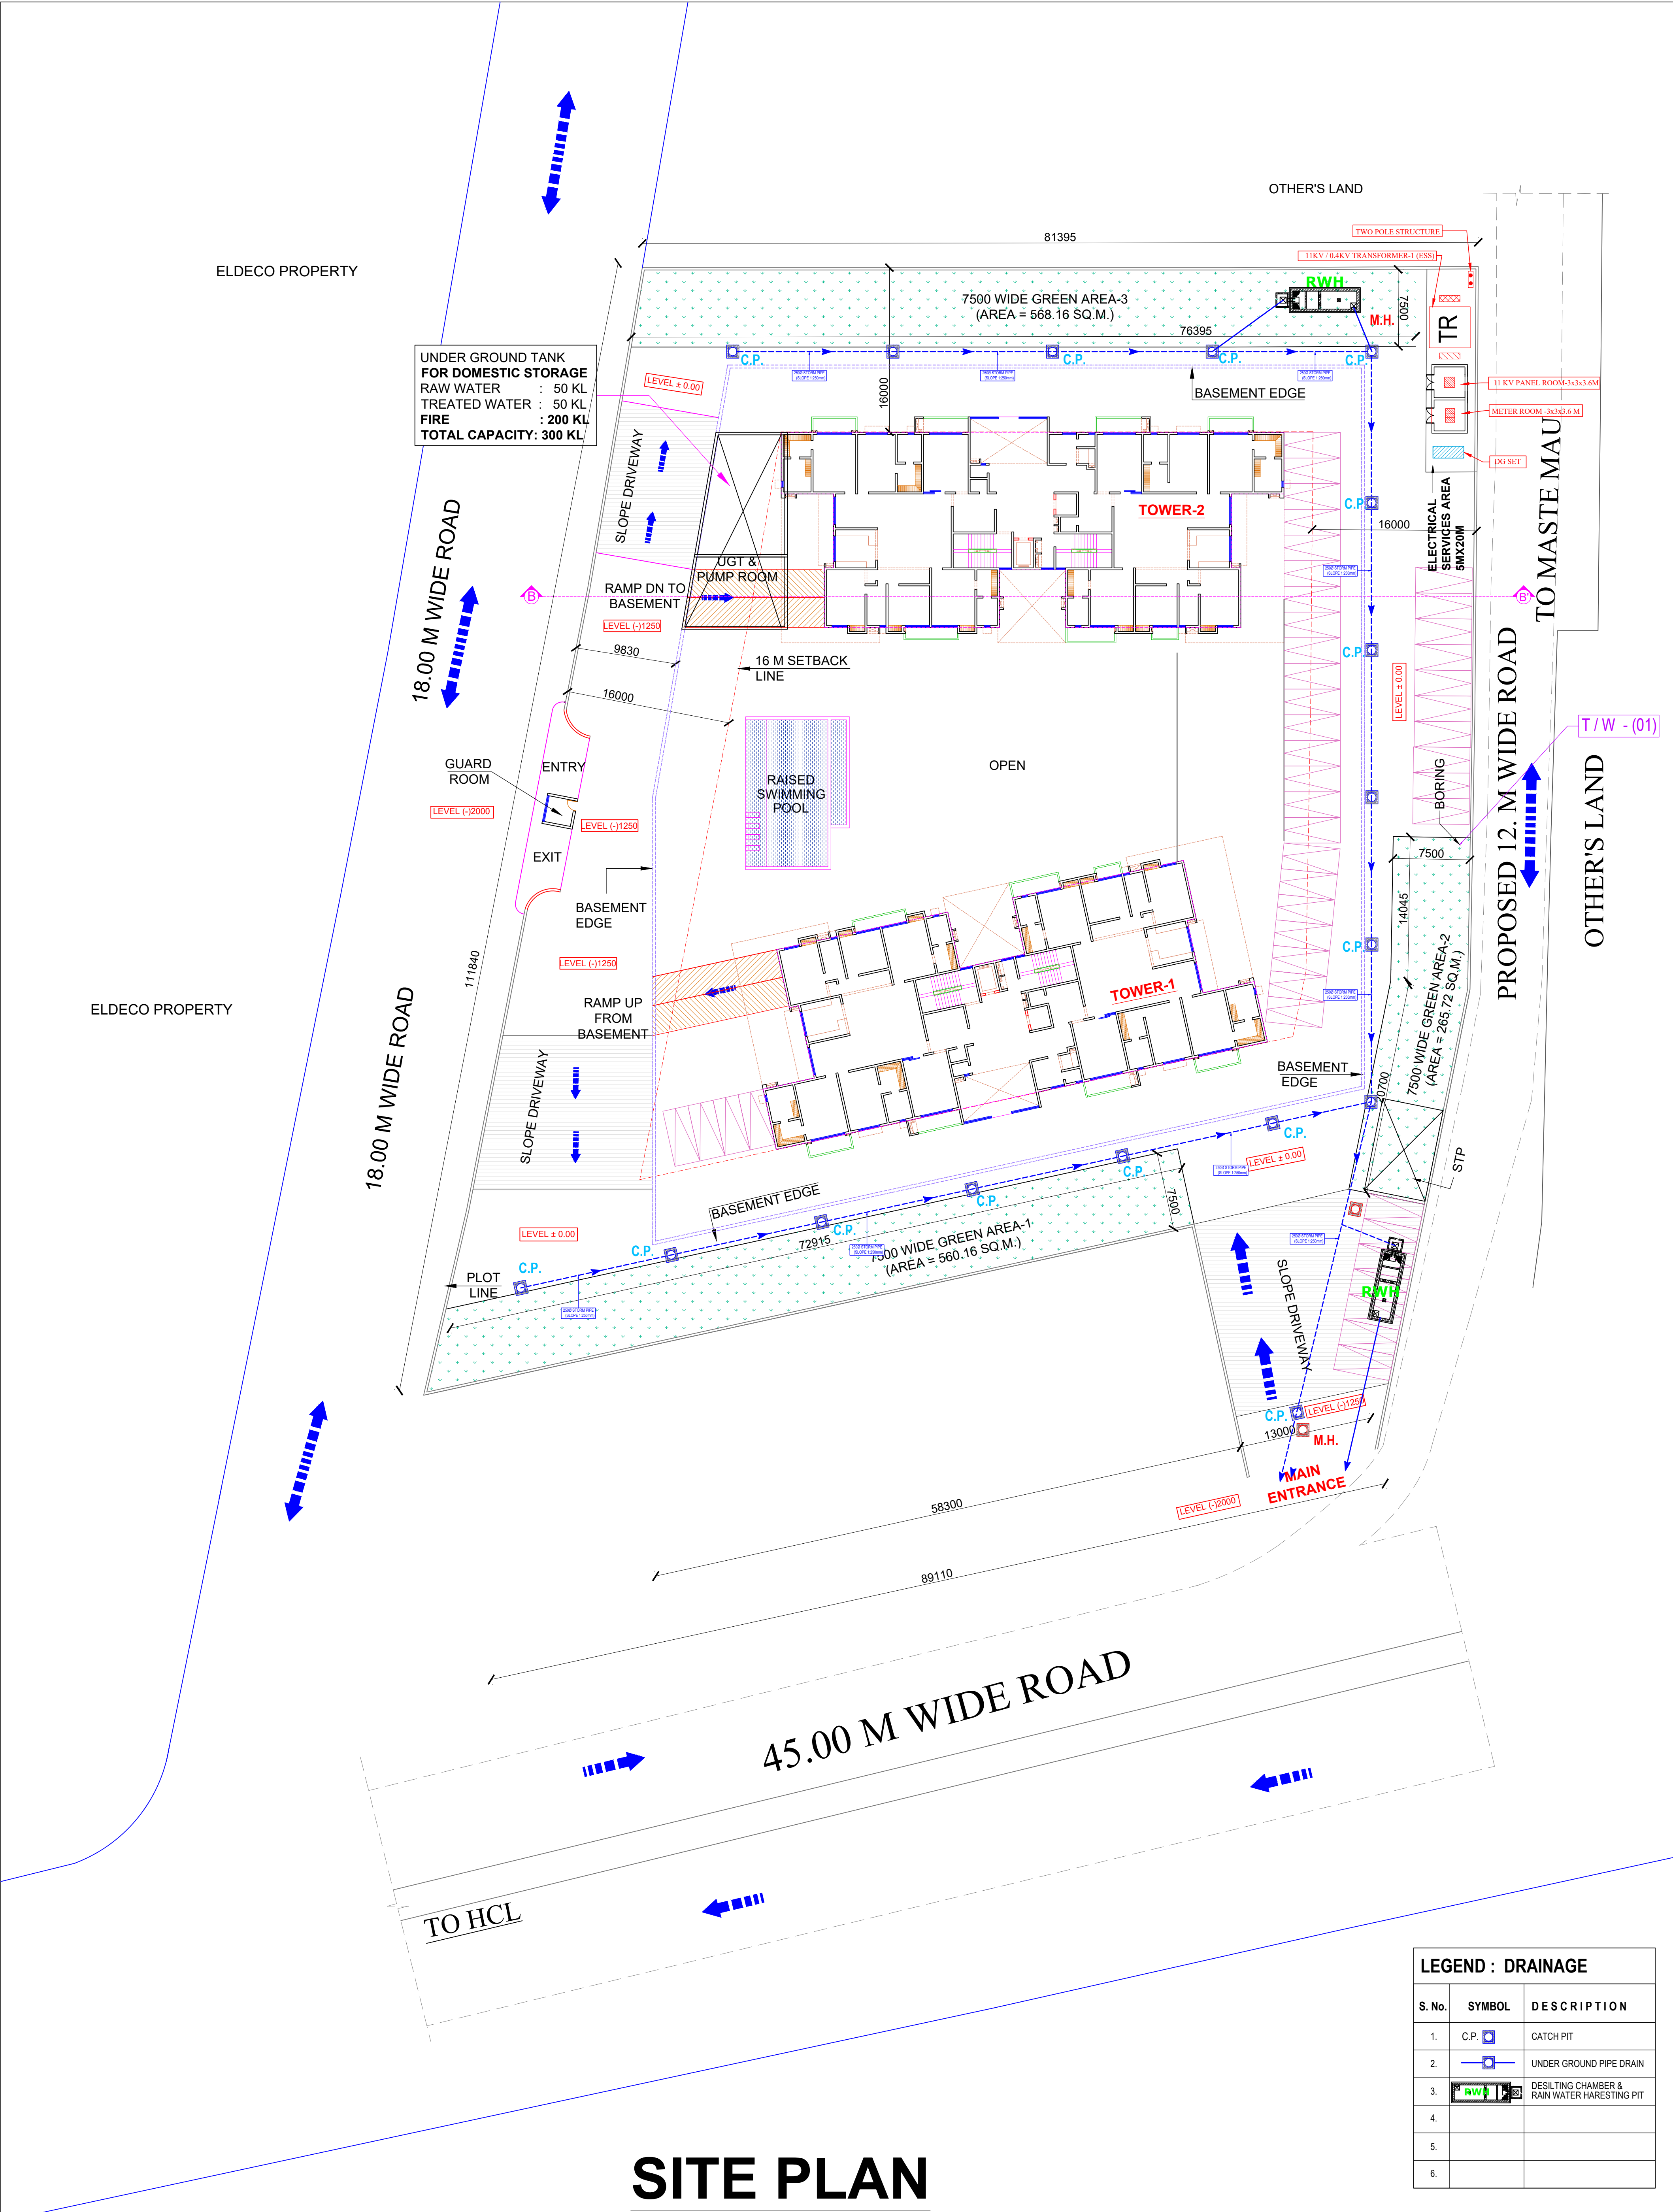

SITE PLAN

LEGEND : DRAINAGE		
S. No.	SYMBOL	DESCRIPTION
1.	C.P.	CATCH PIT
2.		UNDER GROUND PIPE DRAIN
3.		DESILTING CHAMBER & RAIN WATER HARVESTING PIT
4.		
5.		
6.		

Job title :
PROPOSED GROUP HOUSING FOR CHINMAY DEVELOPERS THROUGH PARTNER
MR. RAVI BANSAL ON KHASRA NO. 477,478,479KA, 611 AND 612 OF VILLAGE MASTEMAU, PARGANA
AND TEHSEEL MOHANLALGANJ, LUCKNOW

Drg title :
SITE PLAN
DRAINAGE SYSTEM



ARCHITECTS:
VISHAL & ASSOCIATES
3/77, Viraj Khand, Gomti Nagar, Lucknow
Mob : 9839447965,9839097571