


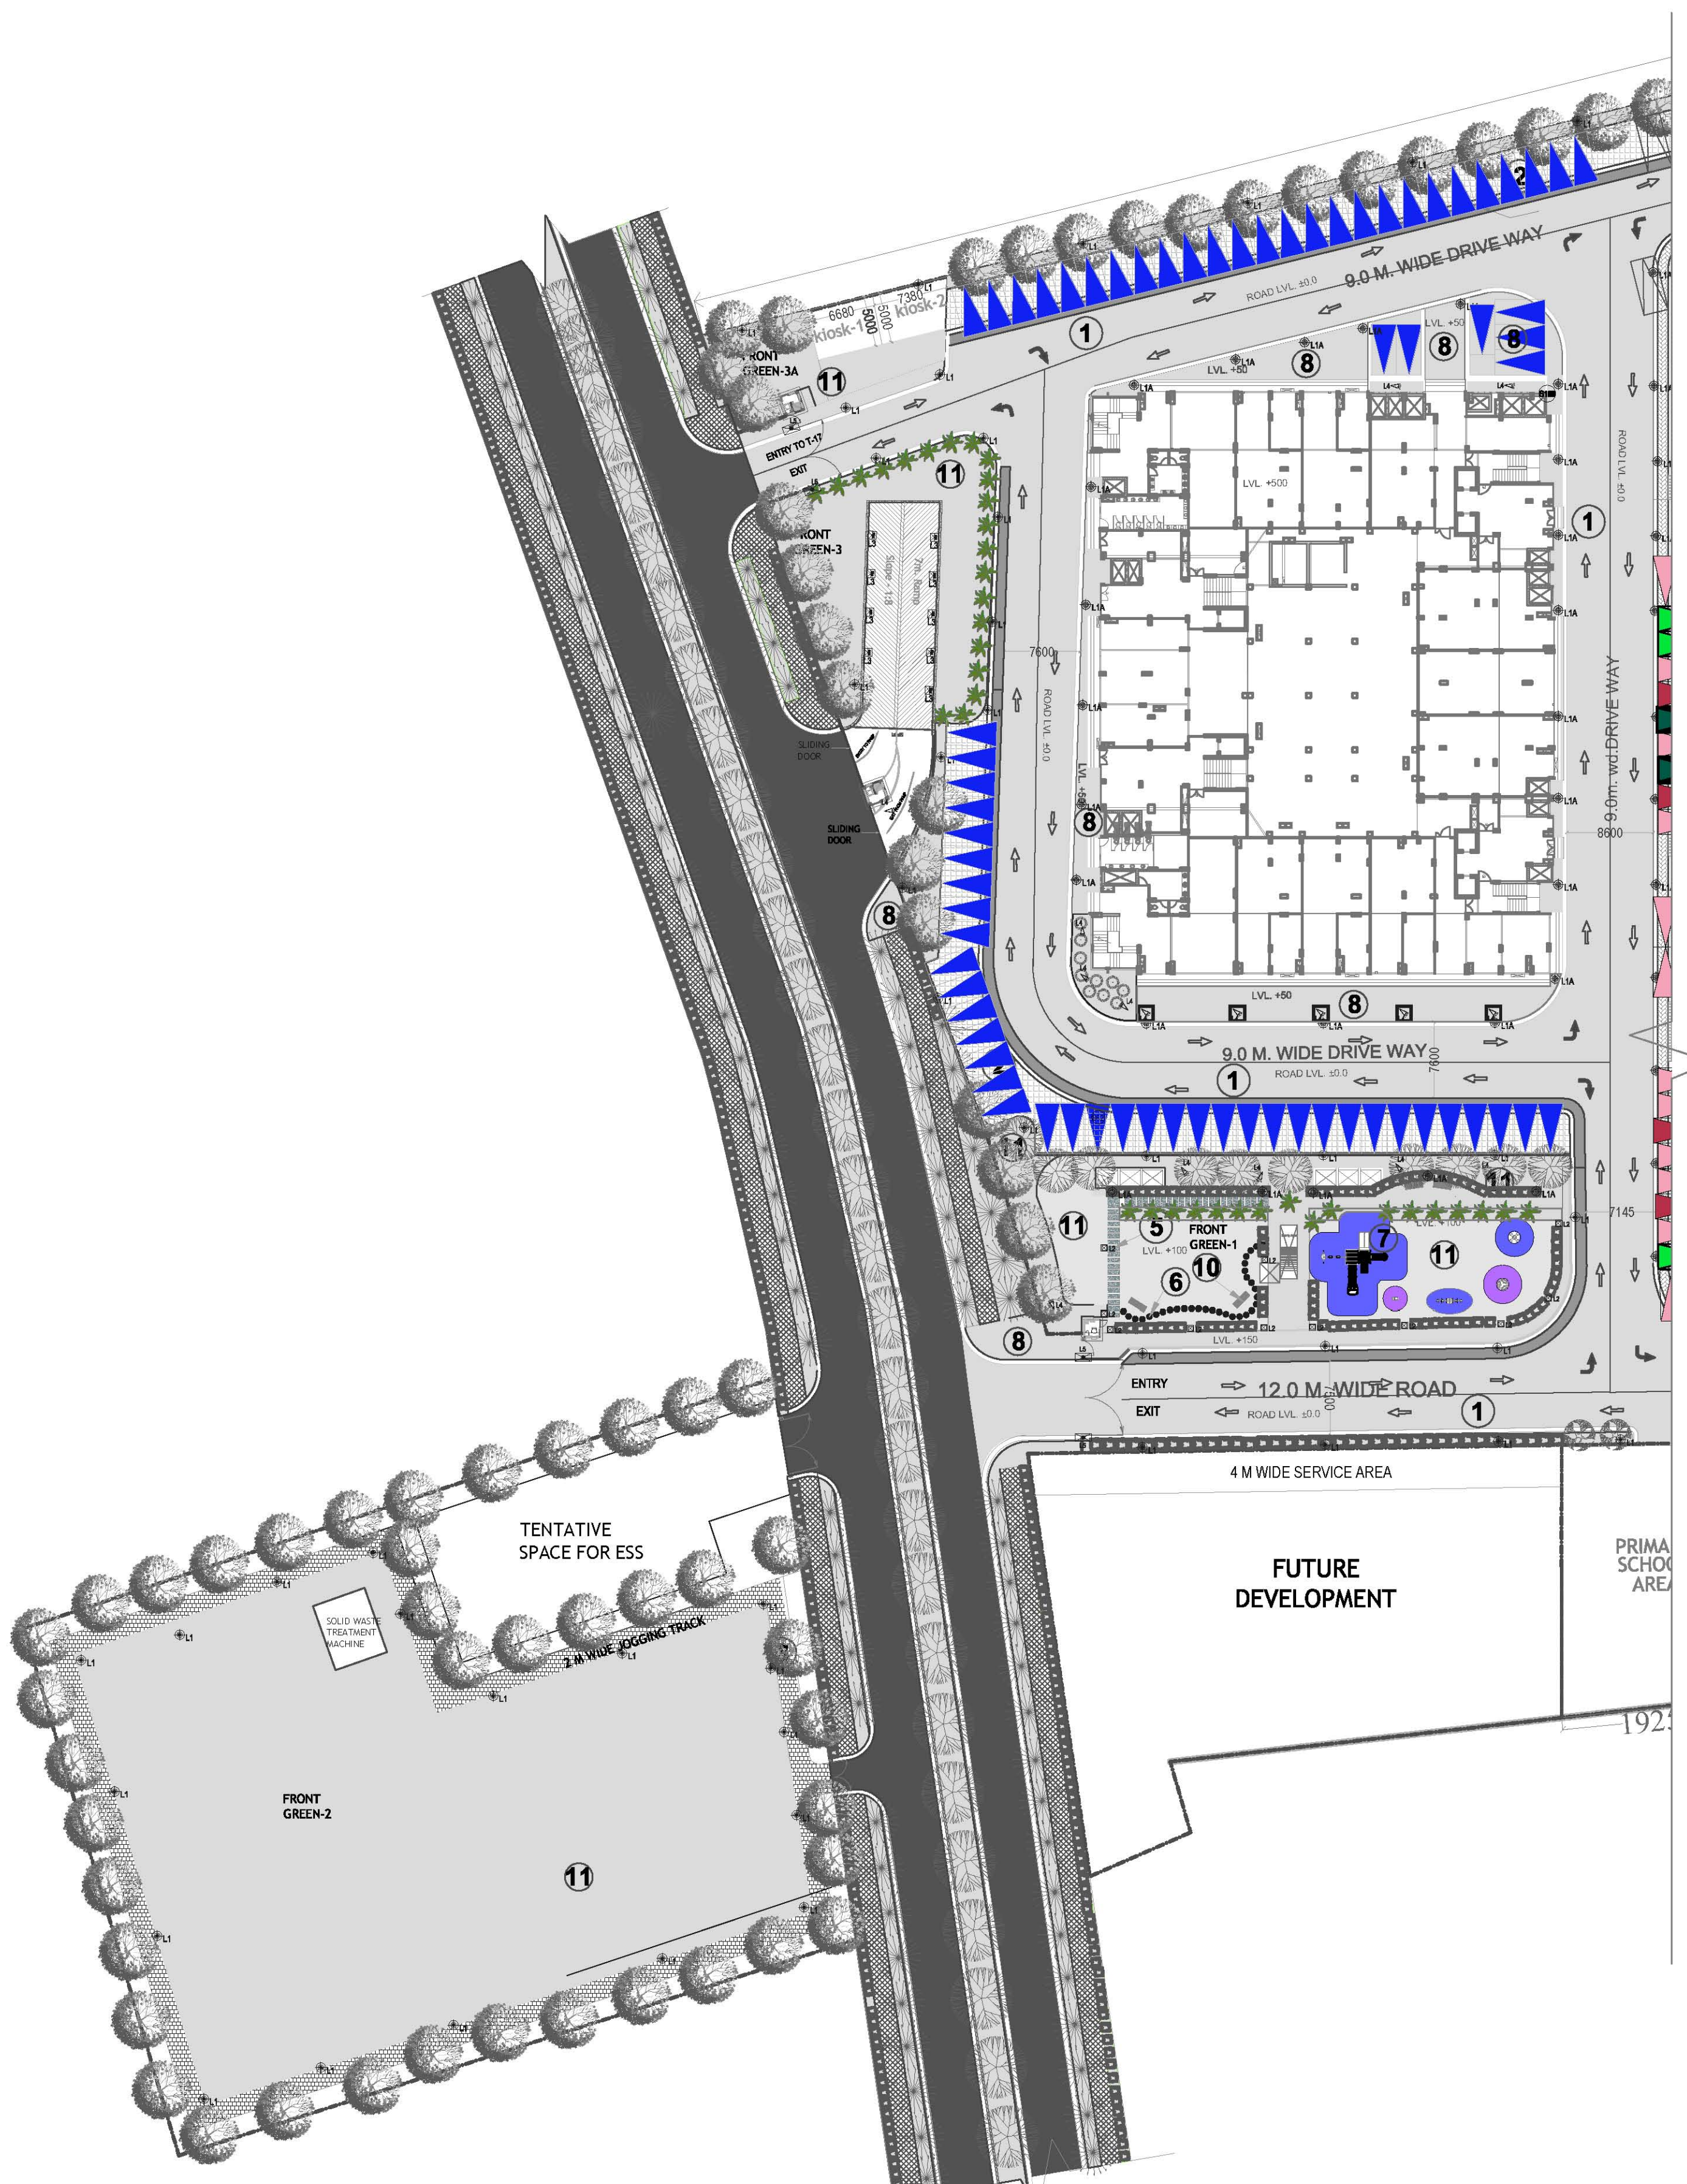

PROJECT	DWG TITLE	REVISION			OWNER'S	STRUCTURAL CONSULTANT	ELECTRICAL CONSULTANT :	PHE CONSULTANT :	HVAC CONSULTANT :	ARCHITECT :	DEALT BY
River Height Group Housing At Noor Nagar, Rajnagar Extension, Ghaziabad (U.P.)	SITE PLAN	REV.	PARTICULAR	DATE	M/s CarolInfrastructure Pvt. Ltd.	 B PERCEPTIONS Plot, QUARTERMASTER, VIKAS SARAO, D.I.H., 110092. 11 n65 SECTOR-11, VASUNDHARA, NEW DELHI - 4283014, Tel/Fax : +91-11-2754543 e-mail : bperceptions@gmail.com	 SUN ENTERPRISES 134, 1st Floor, Shankar Road Market, New Rajinder Nagar, New Delhi - 110086 Tel/Fax : +91-11-4283014, +4283014, E-Mail : sunentiares@yahoo.com sunentiares@gmail.com	 Plumbing & Fire Consultants DEPAK ASSOCIATES 220, SECTOR- S-A, DWARKA PHASE-I, NEW DELHI - 110078 PH : +25369495, 9810087476	 HARVEY CONSULTANCY SERVICES Plot-2, Sector-16, Gurgaon, Haryana C-2, Sector-16, Gurgaon, Haryana Phone : +91-122-4028127 Fax : +91-122-4028128 e-mail : hcs@hcsconsultants.com	 architect interior designers & planners Plot-2nd flr, dhruv plaza c-2 sector-13, vasundhara, ghz. phone 0120-4208127, +91 9811132248 website : www.creative-line.co.in, email : ar.pandeep004@yahoo.com	VIKAS
											CHECKED BY
											NAVDEEP
											DATE
											01-03-2014
											SCALE
											N.T.S
											REV NO.
											R0
											DWG NO.