


50.00 M Wide Road

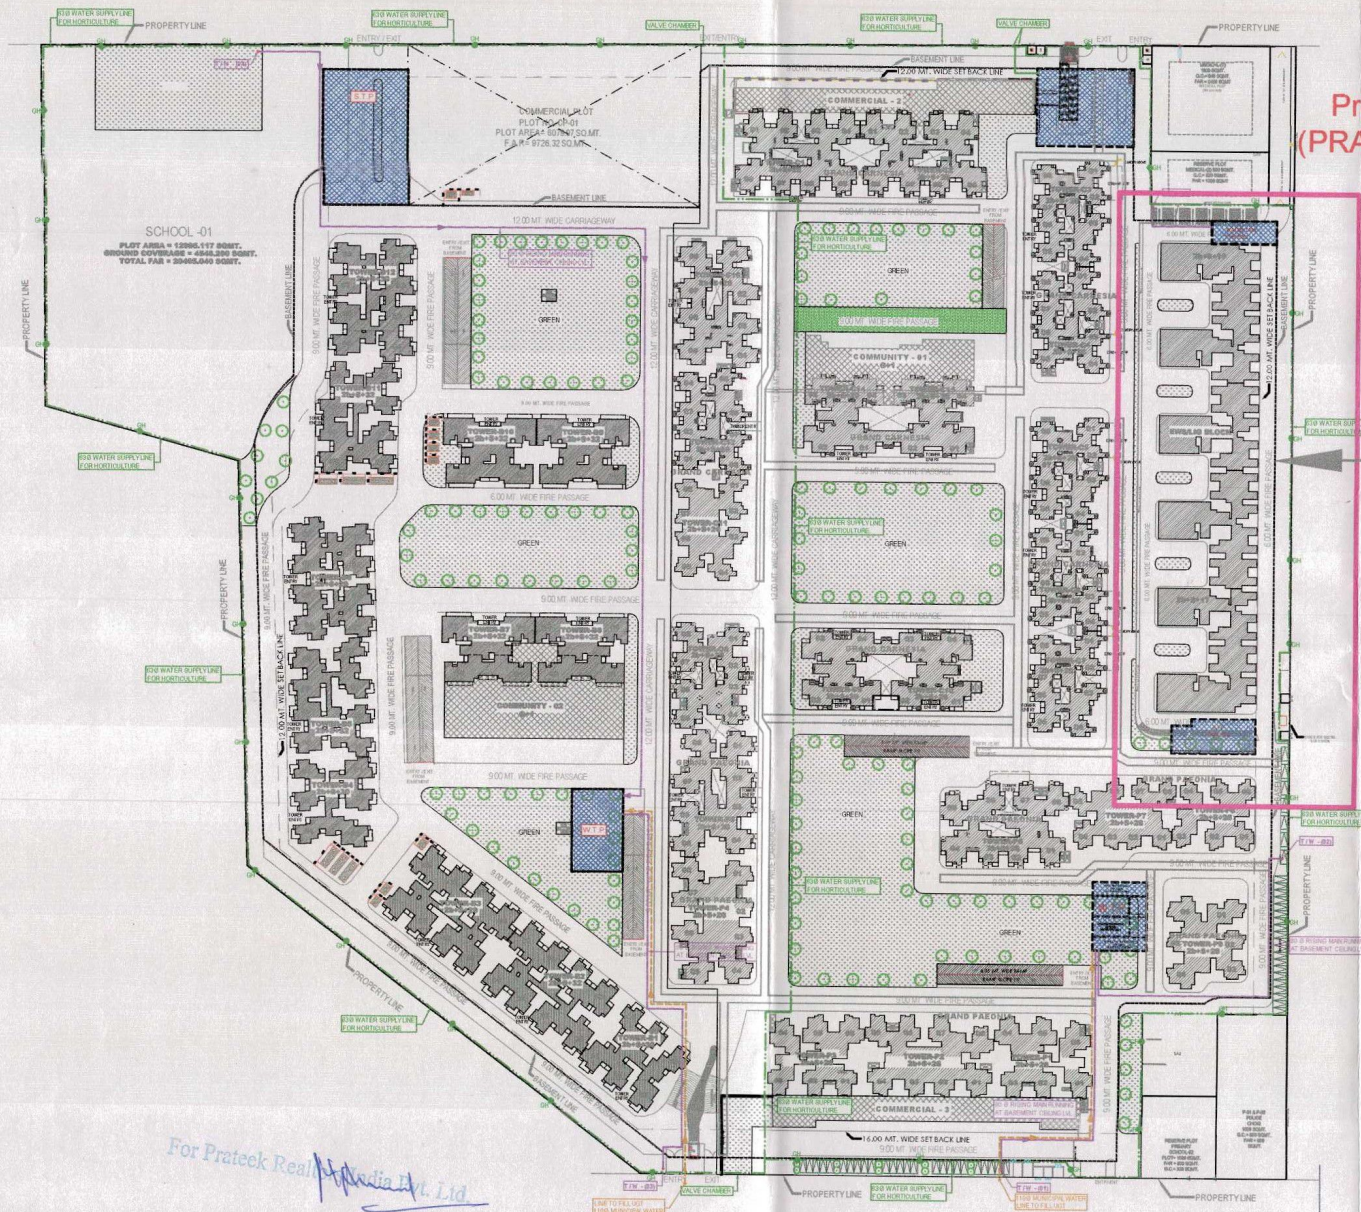

Proposed Project
(PRATEEK AURELIA)
EWS & LIG

LEGEND :		
S. No.	SYMBOL	DESCRIPTION
1.		PROPOSED WATER LINE (1/2 inch dia. to 1 inch dia.)
2.		RECYCLED WATER SUPPLY LINE
3.		RECYCLED WATER SUPPLY LINE FOR HORTICULTURE
4.		PROPOSED FIRE WELL
5.		GARDEN FIRE WELL
6.		MASONRY CHAMBER FOR ISOLATING VALVE
7.		BASEMENT FIRE WELL

Rev. No.	Date	Revision
----------	------	----------

project
PRATEEK GRAND CITY
SIDHARTH VIHAR , GHAZIABAD

title
SITE PLAN

sub title
EXTERNAL WATER SUPPLY LAYOUT

drawing released for
☐ APPROVAL ☒ SUBMISSION
☐ ADVANCE COPY ☐ CONSTRUCTION

drw. no. POC / SP / PL - 03 drawn by S. Bhargava

scale 1:900 @ A1 designed by Shashil Shukla

date 02.05.2022 checked by ANAND HAVELIA

architects
Architect Hafeez Contractor
25 Bank Street, Connaught Place, New Delhi - 110022
www.architecthfeezcontractor.com email: htc@hfeezcontractor.com

services consultant
Consummate Engineering Services (P) Ltd.
Head Office: E-47, Sector-47, Noida - 201301
Tel: (91) 90 2800000, 28 000000
Local Office: E-108, Sector-108, Noida
email: me@cespl.com, website: www.cespl.com

For Prateek Real Estate Pvt. Ltd.

Authorized Signatory

75.00 M Wide Road