


TERRACE

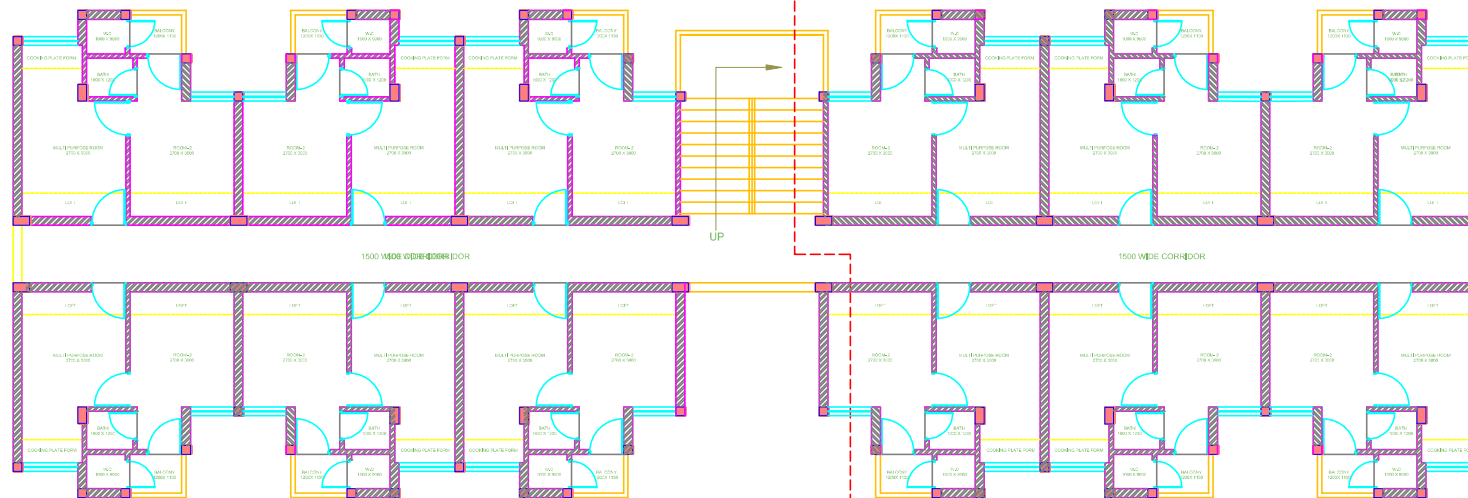

TYPICAL FLOOR PLAN

- NOTE:
1. ALL DIMENSIONS ARE IN MM. UNLESS OTHERWISE SPECIFIED.
 2. WRITTEN DIMENSIONS & LEVELS ARE TO BE TAKEN IN PREFERENCE.
 3. THIS DRAWING IS THE COPYRIGHT OF THE DESIGN FIRM AND SHOULD NOT BE REPRODUCED WITHOUT THE PERMISSION OF THE ARCHITECT.
 4. ANY DISCREPANCIES IN THE DRAWING SHOULD BE IMMEDIATELY BROUGHT INTO THE NOTICE OF THE ARCHITECT.
 5. FOR PLUMBING & ELECTRICAL DETAILS PLEASE REFER OUR DRAWINGS.

DATE	DATE	REVISION

PROJECT TITLE:
**PROPOSED DESIGN OF
 PRADHAN MANTRI AWAS YOJNA (URBAN)
 AT KARARI, JHANSI**

DRAWING TITLE:
**TYPICAL FLOOR PLAN &
 TERRACE PLAN**

ARCHITECT:
ONAR ARCH
 ARCHITECTURE, INTERIOR, LANDSCAPE
 1, JEEVAN VIHAR, CIVIL LINE, JHANSI 208001
 E-MAIL: onararch@gmail.com

JOB No.	ARCH. DWG. No.	REV.
ONAR-05	A-05-	
SCALE:	DESIGN BY:	
	AS SHOWN	VIKAS
DATE:	CHECKED BY:	
17-08-2018	YOGENDRA	