
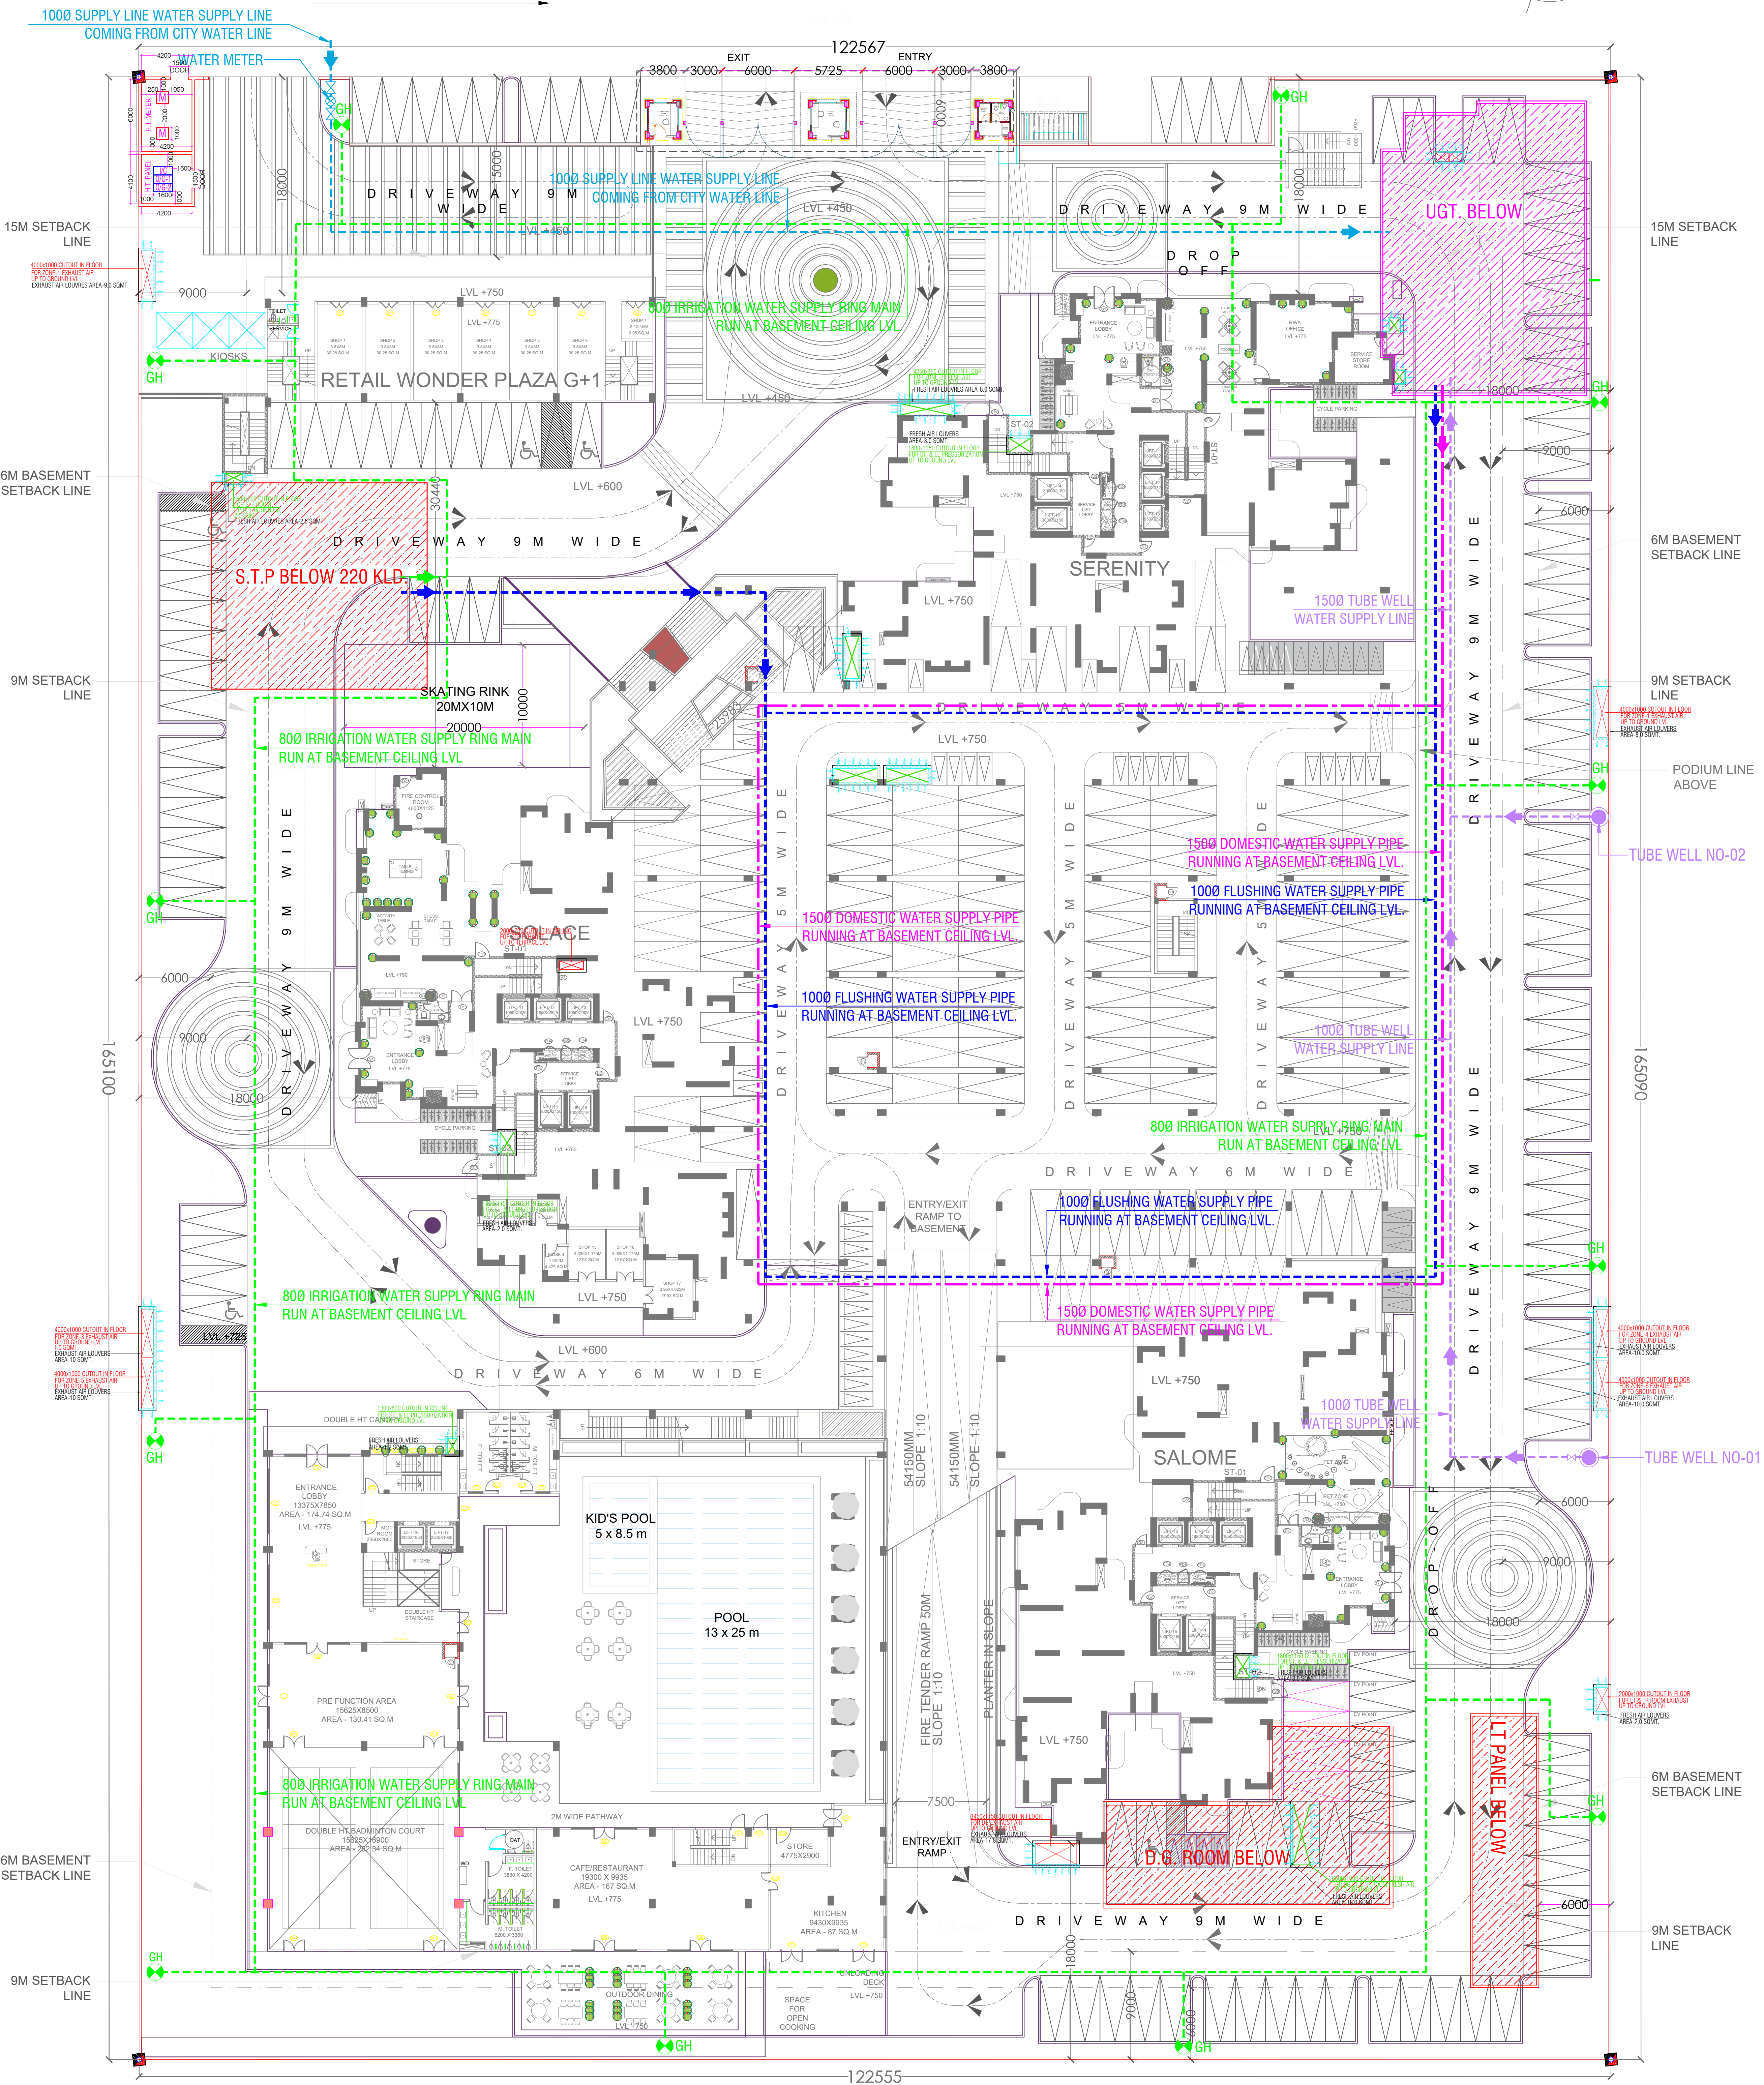


2 4 M W I D E R O A D

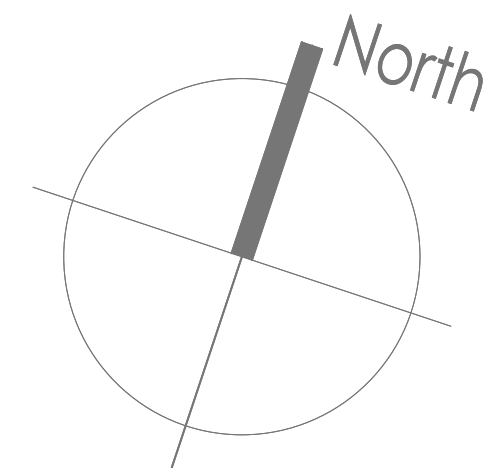

ELDECO SONHA PROJECTS LTD.
201-212, 2nd Floor, Splendor Forum,
Jasola District Centre, New Delhi - 110 025

Architect
ARCOP

ARCOP ASSOCIATES PVT LTD
Plot No. 305, Sector-32, Institutional Area, Gurugram, Haryana,
122001, India
Tel: 91-124-4595500
91-124-4595550
Fax: 91-124-4595550

MEP Consultant
PARADISE CONSULTANTS
PLOT NO. 129, POCKET-2, BASEMENT
JASOLA VIHAR, NEW DELHI-110025
PH: 011-46132800, 41030619
E-mail: mep@paradiseconsultants.com

Disclaimer
Drawings and written material appearing herein constitute original and unpublished work of the Consultant and may not be duplicated, used or disclosed without written consent of the Consultant.

Notes
1. Unless otherwise mentioned all dimensions are in Millimeters.
2. Unless otherwise mentioned all levels including finished floor levels are in Meters.
3. Unless otherwise mentioned all dimensions are shown exclusive of linings & frames.
4. Dimensions are not to be scaled from the drawing.
5. Any discrepancies, either between written dimensions and site dimensions or within these drawings should be brought to the immediate attention of the consultant before executing the works.
6. This drawing is to be read in conjunction with all other documentation forming the construction document.

No	Date	Description
Revisions		

PLUMBING SERVICES LEGEND:


- STORM WATER MANHOLE (600 x 600) MM
- STORM WATER MANHOLE (800 x 800) MM
- SEWER MANHOLE (800 x 900) MM
- SEWER MANHOLE (800 x 800) MM
- EXTERNAL SEWER LINE
- EXTERNAL STORM WATER LINE
- DOMESTIC WATER SUPPLY LINE
- FLUSHING WATER SUPPLY LINE
- EXTERNAL FIRE HYDRANT LINE
- MUNICIPAL LINE WATER SUPPLY
- MUNICIPAL LINE WATER SUPPLY
- GARDEN IRRIGATION WATER SUPPLY LINE
- EXTERNAL FIRE HYDRANT (750x600x250) MM
- GARDEN HYDRANT
- D.T. DISPERSION TRENCH SIZE- (5000X2500) MM
- D.C. DESILTING CHAMBER (2500 X 1500) MM
- VALVE WITH CHAMBER
- NON RETURN VALVE WITH CHAMBER (N.R.V.)

No	Date	Description
Revisions		

Drawing Status

SUBMISSION DRAWING

Key Plan

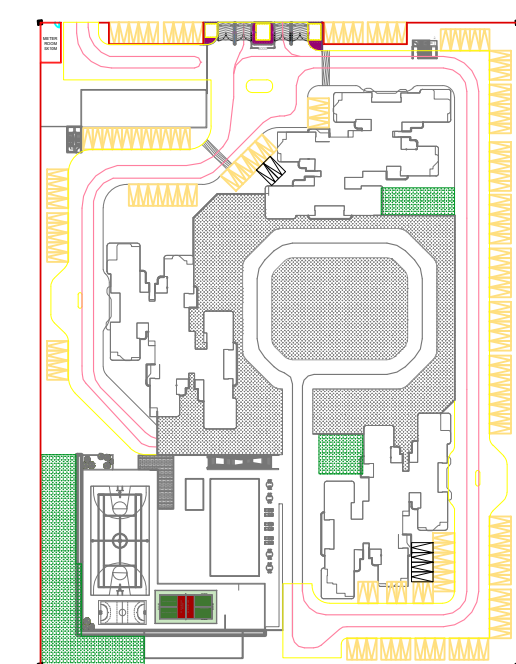

Project Name
ELDECO WHISPERS OF WONDER

Project Address
PLOT NO. GH-1A/2, SEC. 22D, YAMUNA EXPRESS WAY,
INDUSTRIAL DEVELOPMENT AUTHORITY, GAUTAM BUDDH
NAGAR, U.P. - 203201

Drawing Title
**SITE PLAN
WATER SUPPLY LAYOUT**

Project No. 24.ED2.GN

Scale 1:300

Date MAY 07, 2025

Drawing No. PL-PC-EWOW-SITE-WS-103

XX XX X XXX

SHEET SIZE A1 : 841 X 594