
 


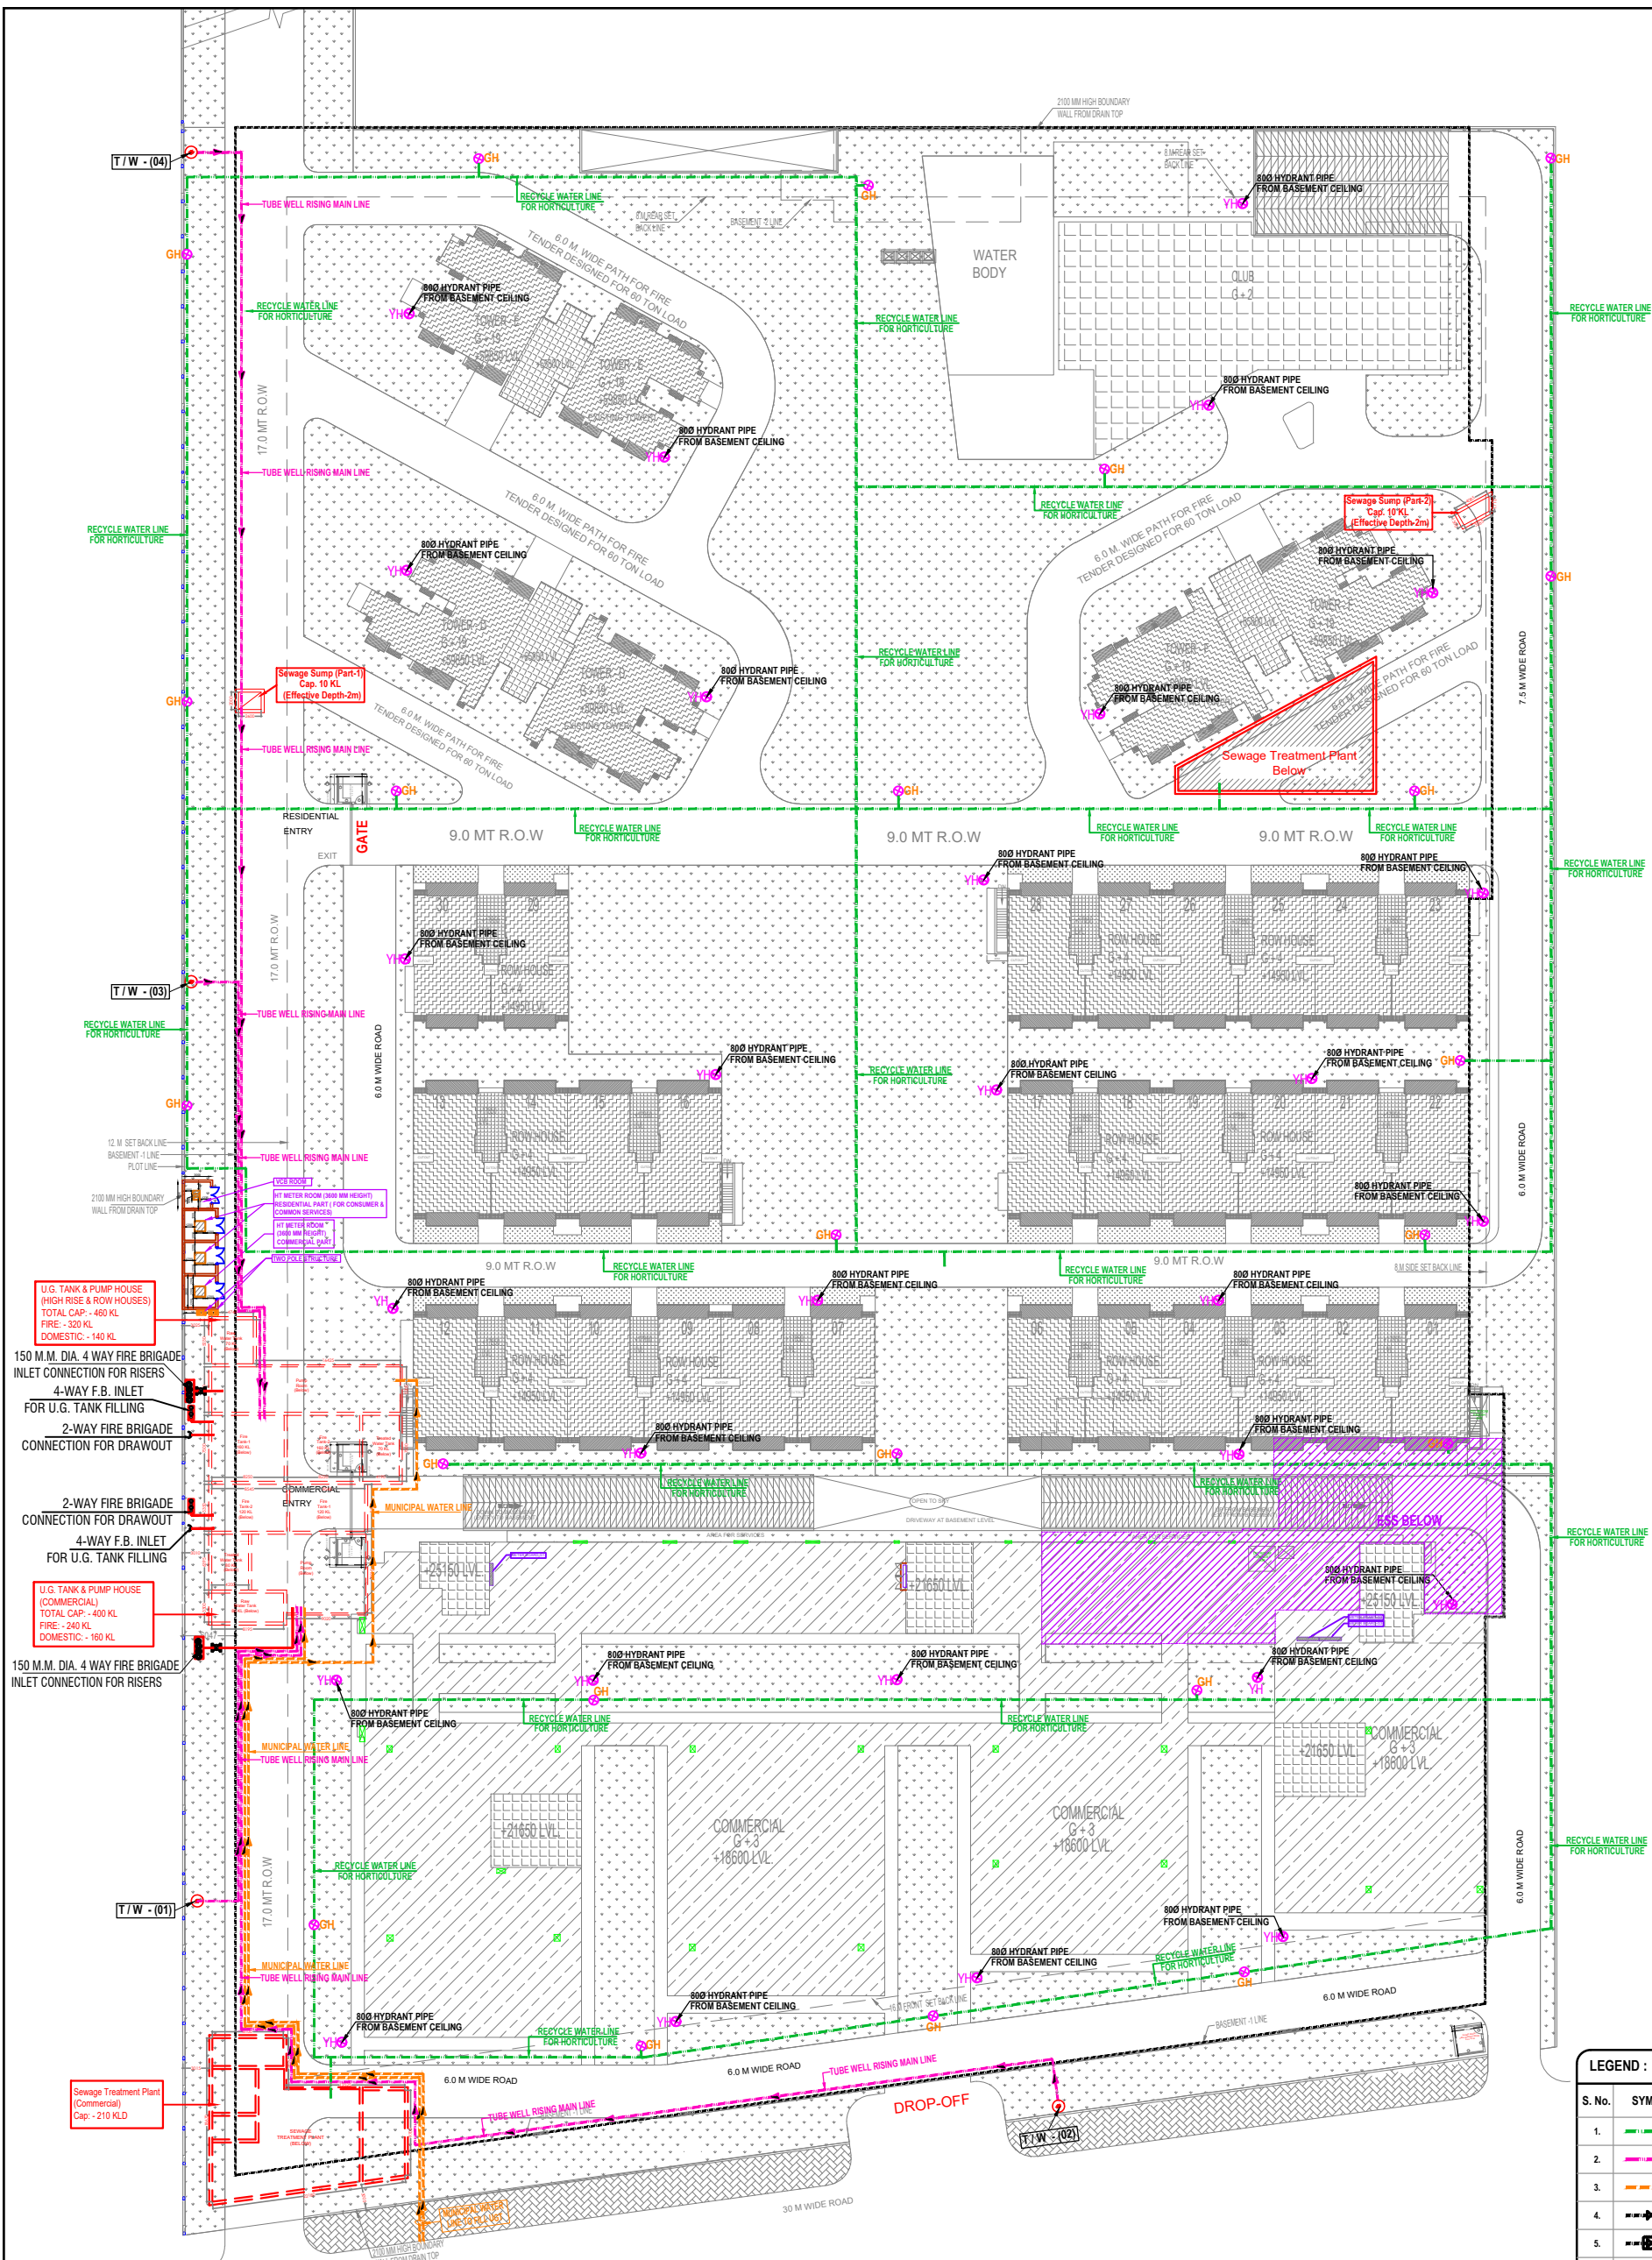

LEGEND :		
S. No.	SYMBOL	DESCRIPTION
1.		RECYCLED WATER SUPPLY PIPE LINE
2.		RISING MAIN WATER PIPE LINE
3.		MUNICIPAL WATER SUPPLY PIPE LINE
4.		ISOLATING VALVE
5.		MASONRY CHAMBER FOR ISOLATING VALVE
6.		PROPOSED TUBE WELL
7.		BASEMENT LINE
8.		GARDEN HYDRANT

LEGEND : FIRE SYSTEM		
S. No.	SYMBOL	DESCRIPTION
1.		FIRE LINE
2.		YARD HYDRANT CONNECT TO BASEMENT FIRE LINE 63 M.M. DIA. SINGLE HEADED HYDRANT VALVE WITH 2 NOS. 15 M. LONG, 63 M.M. DIA. FIRE HOSE PIPE & 1 NO. BRANCH PIPE WITH NOZZLE
3.		FIRE BRIGADE CONNECTION
4.		BUTTERFLY VALVE
5.		NONRETURN VALVE (CHECK VALVE)



Rev. no.	Date	Revision

Project

PROPOSED SPORTS CITY NEOWORLD FOR M/S LOGIX INFRADEVELOPERS PVT.LTD. AT PLOT NO: SC - 01/B, SECTOR -150, NOIDA, UP.

Title

SITE PLAN

Subtitle

EXTERNAL WATER SUPPLY SYSTEM
RESIDENTIAL & COMMERCIAL

Drawing released for

☐ APPROVAL
☐ ADVANCE COPY
☒ SUBMISSION
☐ CONSTRUCTION

Dwg. no.

LOGIX / EX / S-03

Scale

1 : 400 @ A1

Date

Dec. 2019

Drawn by

Kulwant

Designed by

R.K.

Checked by

Anand Havelia

Architects

Confluence

B-421, NEW FRIENDS COLONY, N.D-65, INDIA
PH: +91-11-46130600 ccs@confluence.com Member of IGC
urban design hospitality interiors

Services Consultant

Consummate Engineering Services (P) Ltd.

Noida Office : B - 67, Sector - 67, Noida - 201 301
Tel : (0120) 6943500 (23 Lines)
Lko. Office : R 006, Rohtas Plumeria, Gomti Nagar, Lucknow
Tel : (0522) 4025902
e mail : mail@cespl.in, website : www.cespl.in