



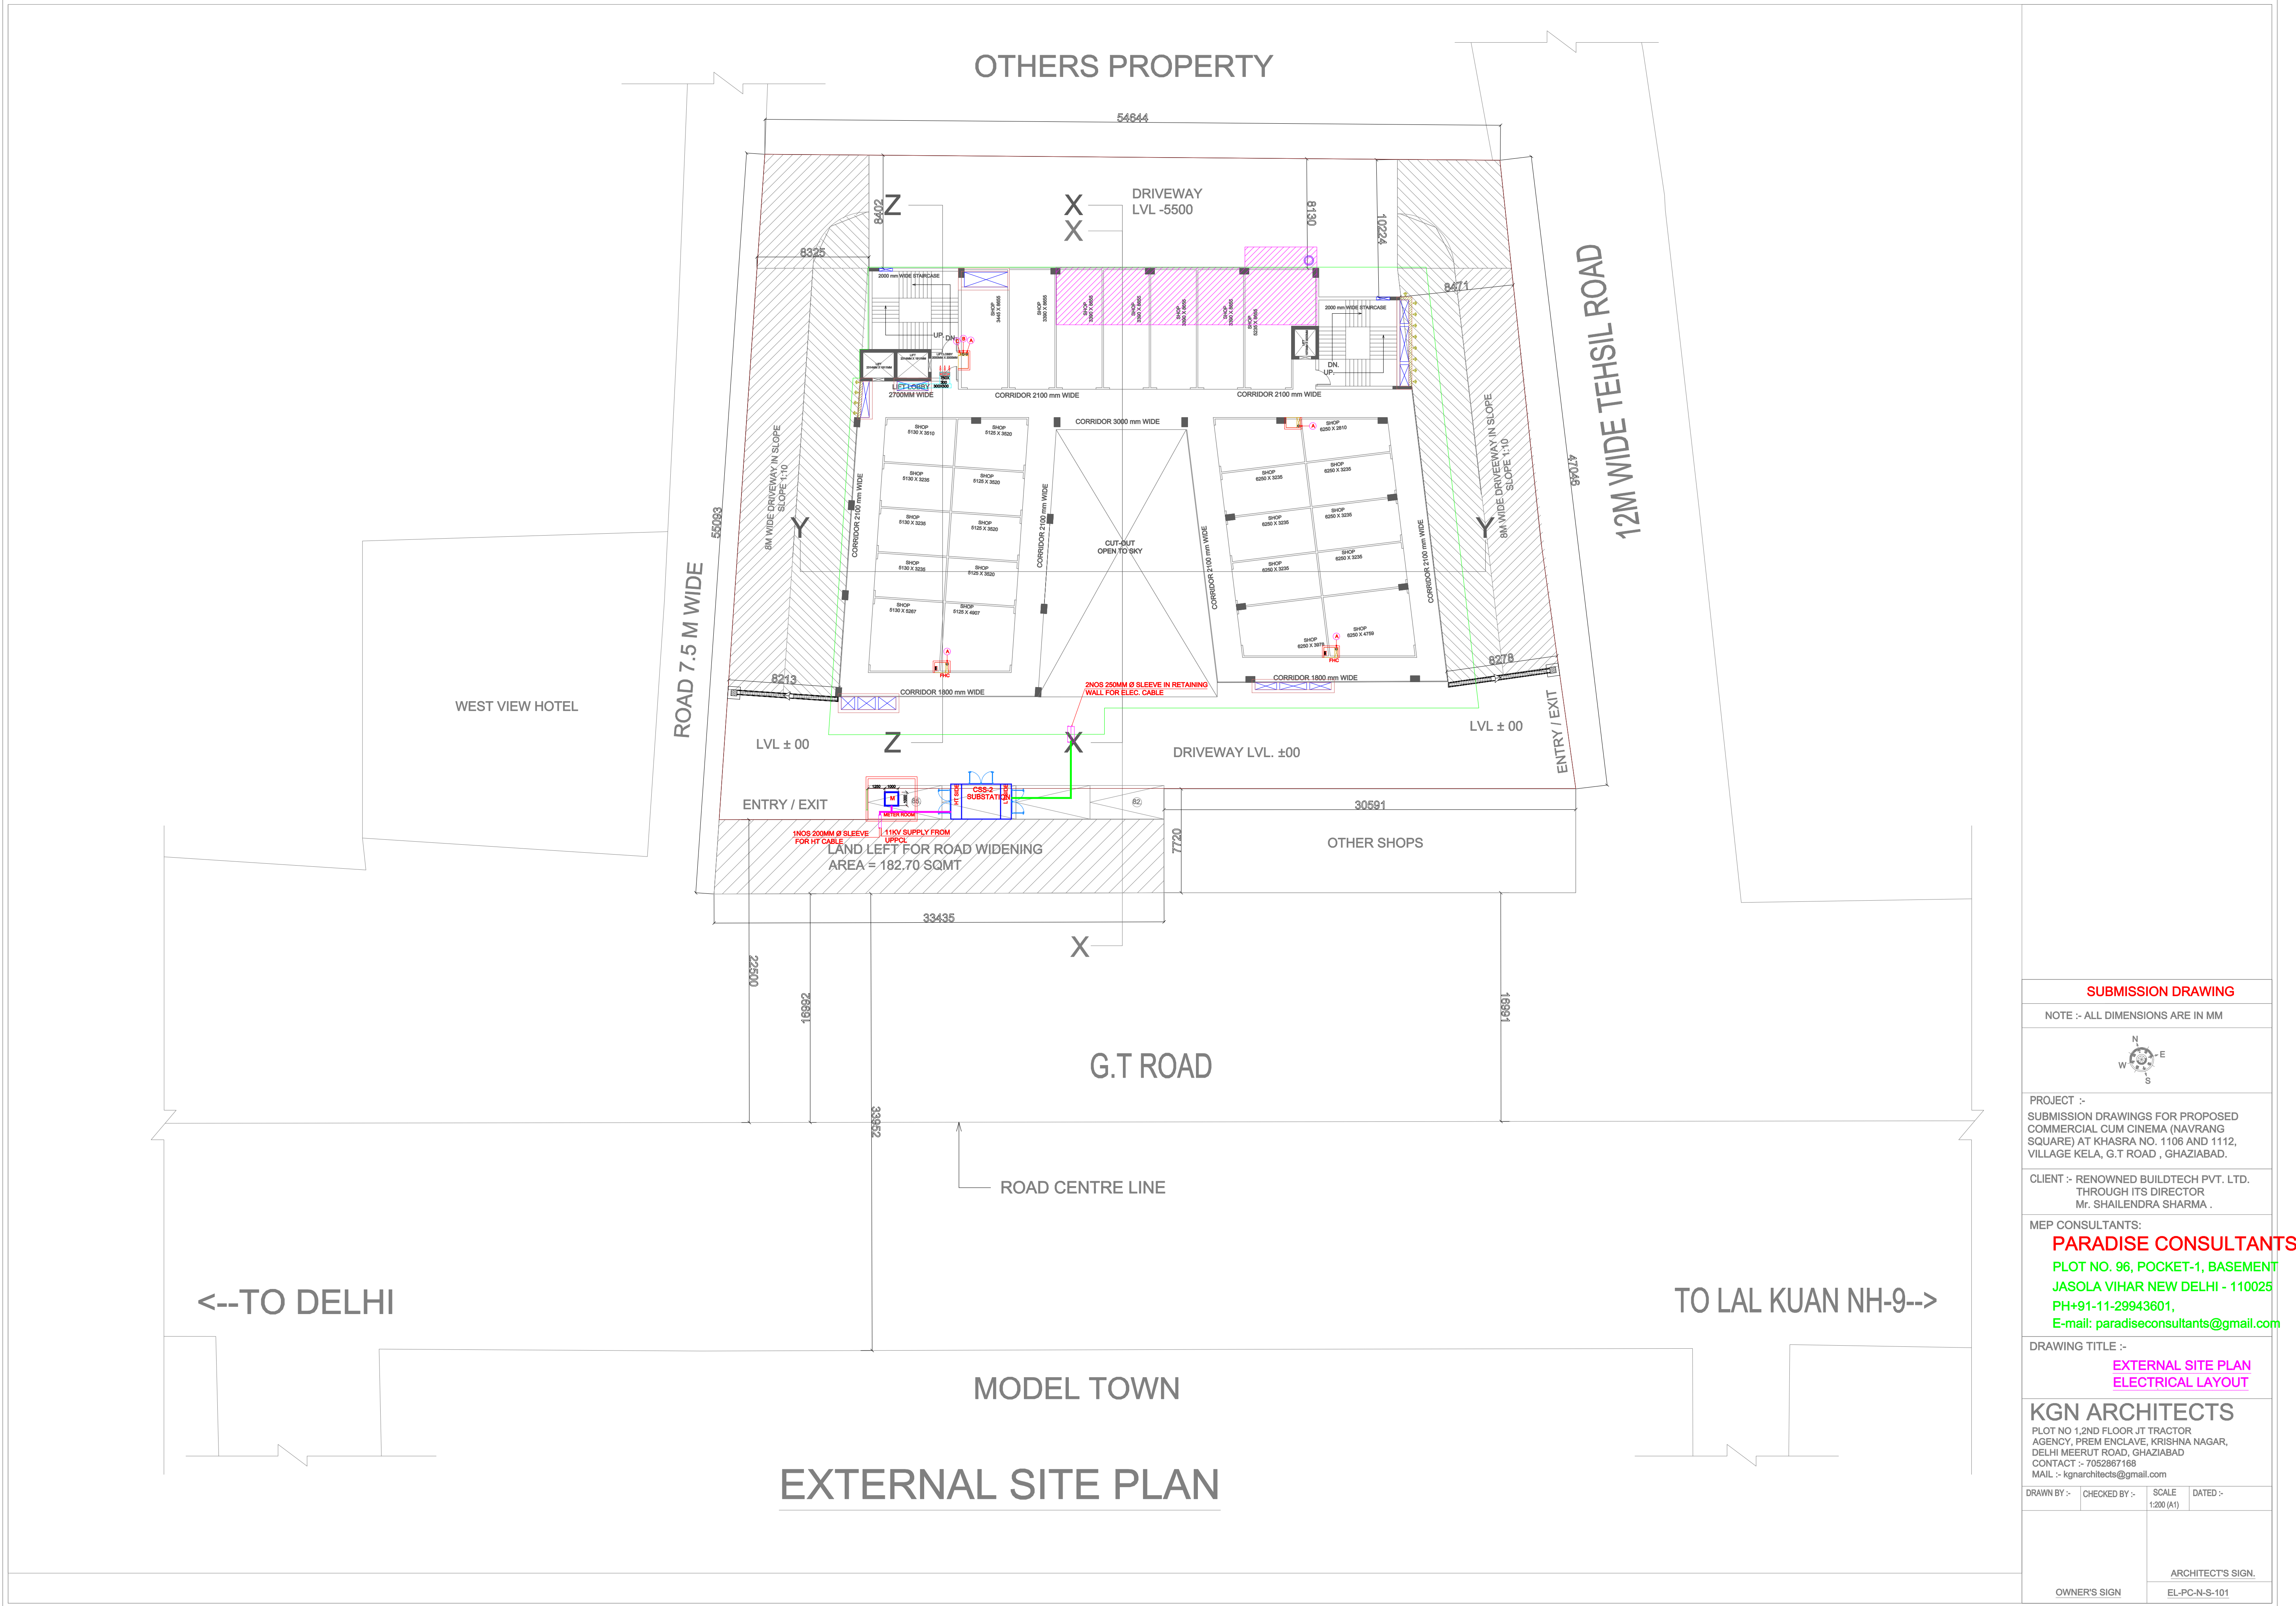

SUBMISSION DRAWING

NOTE :- ALL DIMENSIONS ARE IN MM

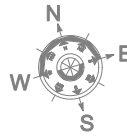

PROJECT :-
SUBMISSION DRAWINGS FOR PROPOSED
COMMERCIAL CUM CINEMA (NAVRANG
SQUARE) AT KHASRA NO. 1106 AND 1112,
VILLAGE KELA, G.T. ROAD , GHAZIABAD.

CLIENT :- RENOWNED BUILDTech PVT. LTD.
THROUGH ITS DIRECTOR
Mr. SHAILENDRA SHARMA .

MEP CONSULTANTS:
PARADISE CONSULTANTS
PLOT NO. 96, POCKET-1, BASEMENT
JASOLA VIHAR NEW DELHI - 110025
PH+91-11-29943601,
E-mail: paradiseconsultants@gmail.com

DRAWING TITLE :-
**EXTERNAL SITE PLAN
ELECTRICAL LAYOUT**

KGN ARCHITECTS
PLOT NO 1, 2ND FLOOR JT TRACTOR
AGENCY, PREM ENCLAVE, KRISHNA NAGAR,
DELHI MEERUT ROAD, GHAZIABAD
CONTACT :- 7052867188
MAIL :- kgnarchitects@gmail.com

DRAWN BY :-	CHECKED BY :-	SCALE 1:200 (A1)	DATED :-
OWNER'S SIGN		ARCHITECT'S SIGN. EL-PC-N-S-101	