


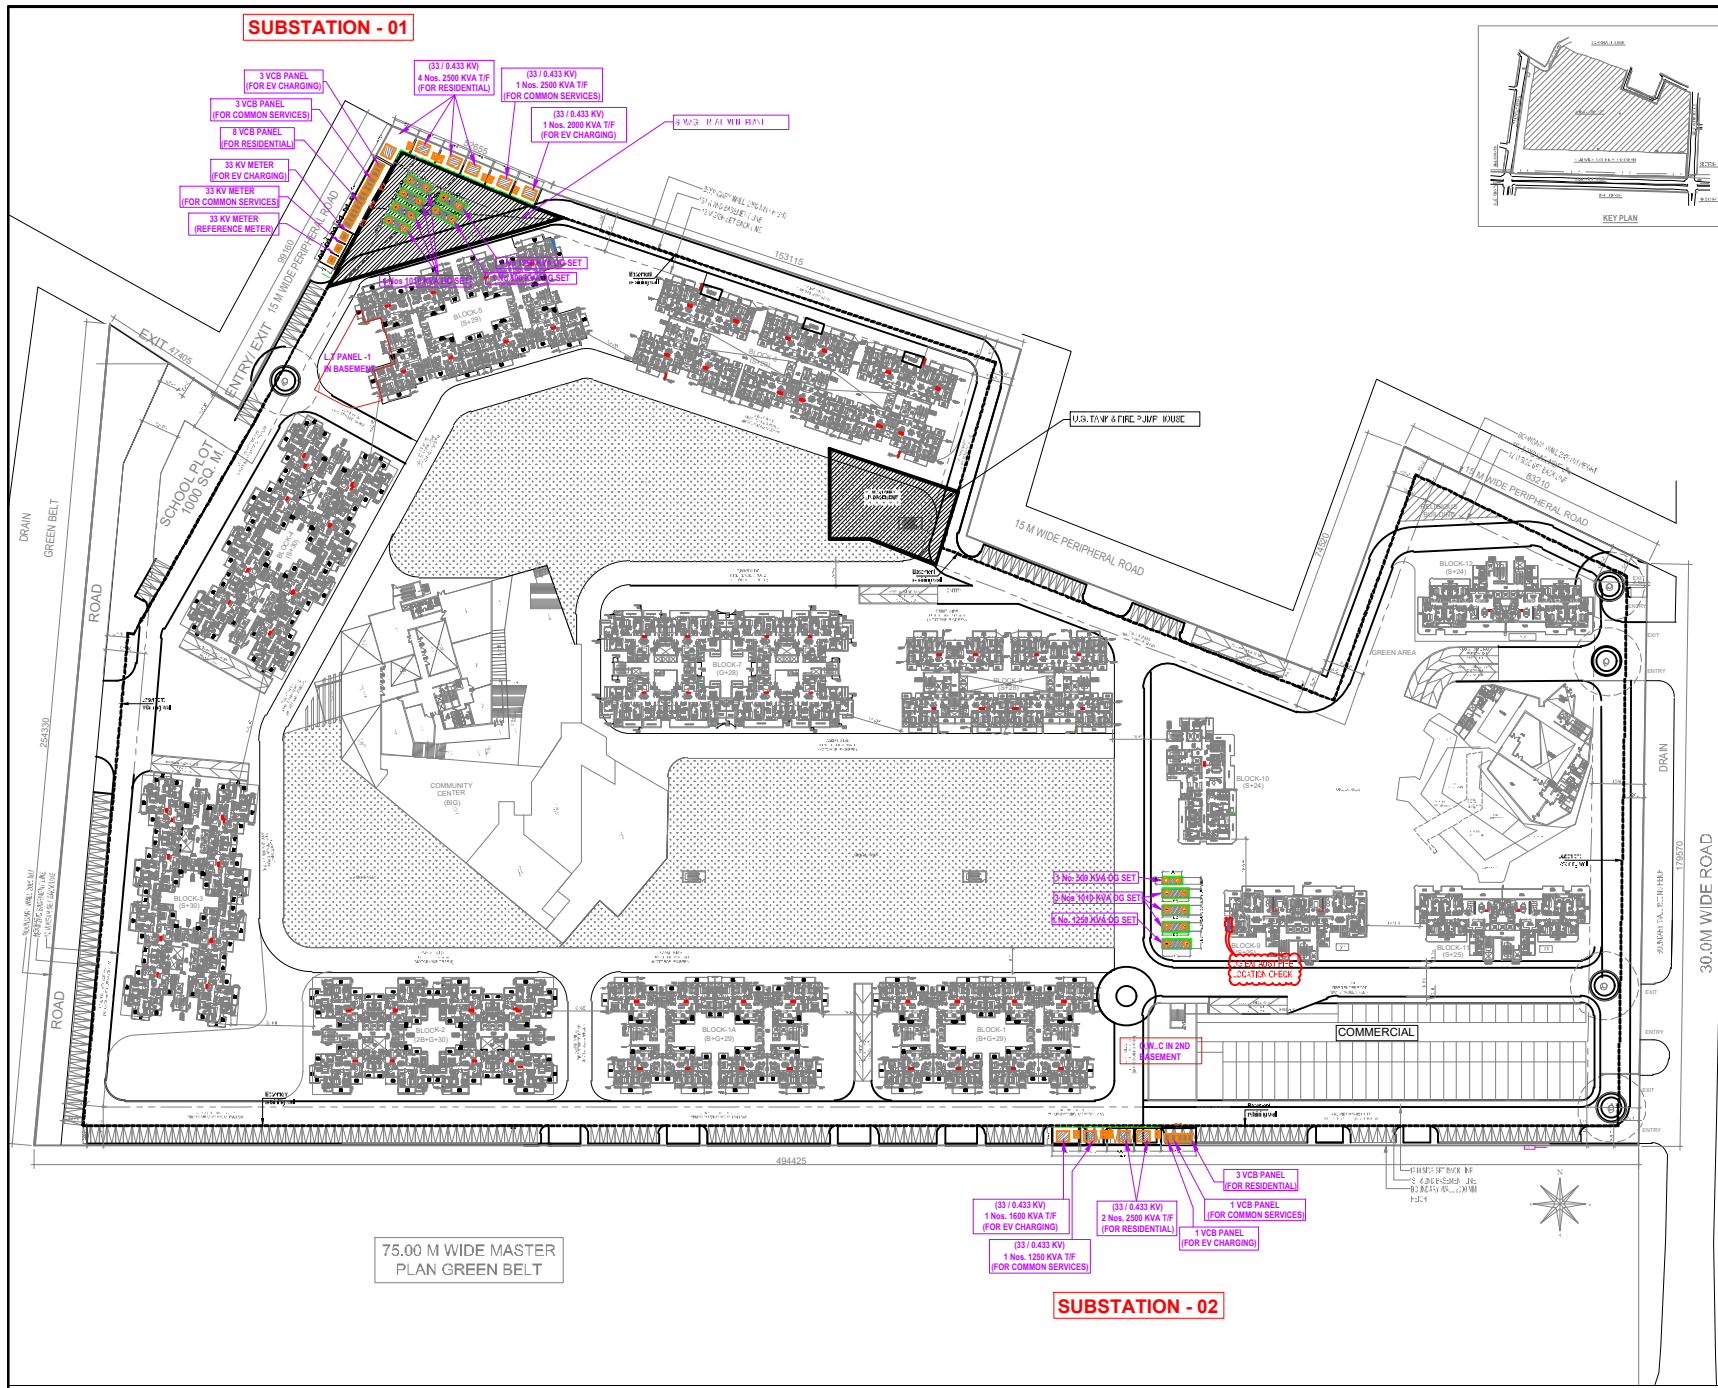

LEGEND:

S. No.	SYMBOL	DESCRIPTION
1.	C.P.	CATCH PIT
2.		UNDER GROUND DRAIN

Rev. No.

Date

Revision

Project :

PROPOSED GROUP HOUSING
FOR MIS AMBIENCE PVT. LTD. AT PLOT NO.-GH-01,
SECTOR-115, NOIDA, (U.P.)

Title :

LAYOUT PLAN

Subtitle :

ELECTRICAL LAYOUT

Drawing Released For :

☐ APPROVAL
 ☐ ADVANCE COPY
 ☒ SUBMISSION
 ☐ CONSTRUCTION

Dwg. No. :

IVORY COUNTY / ES-01

Scale :

1:750

Date :

May 2023

Drawn By :

Amal Kumbh

Design By :

Sanjay Goyal

Ckd By :

Anand Havelia

Architects :

Services Consultant :