


PRODUCED BY AN AUTODESK EDUCATIONAL PRODUCT

PRODUCED BY AN AUTODESK EDUCATIONAL PRODUCT

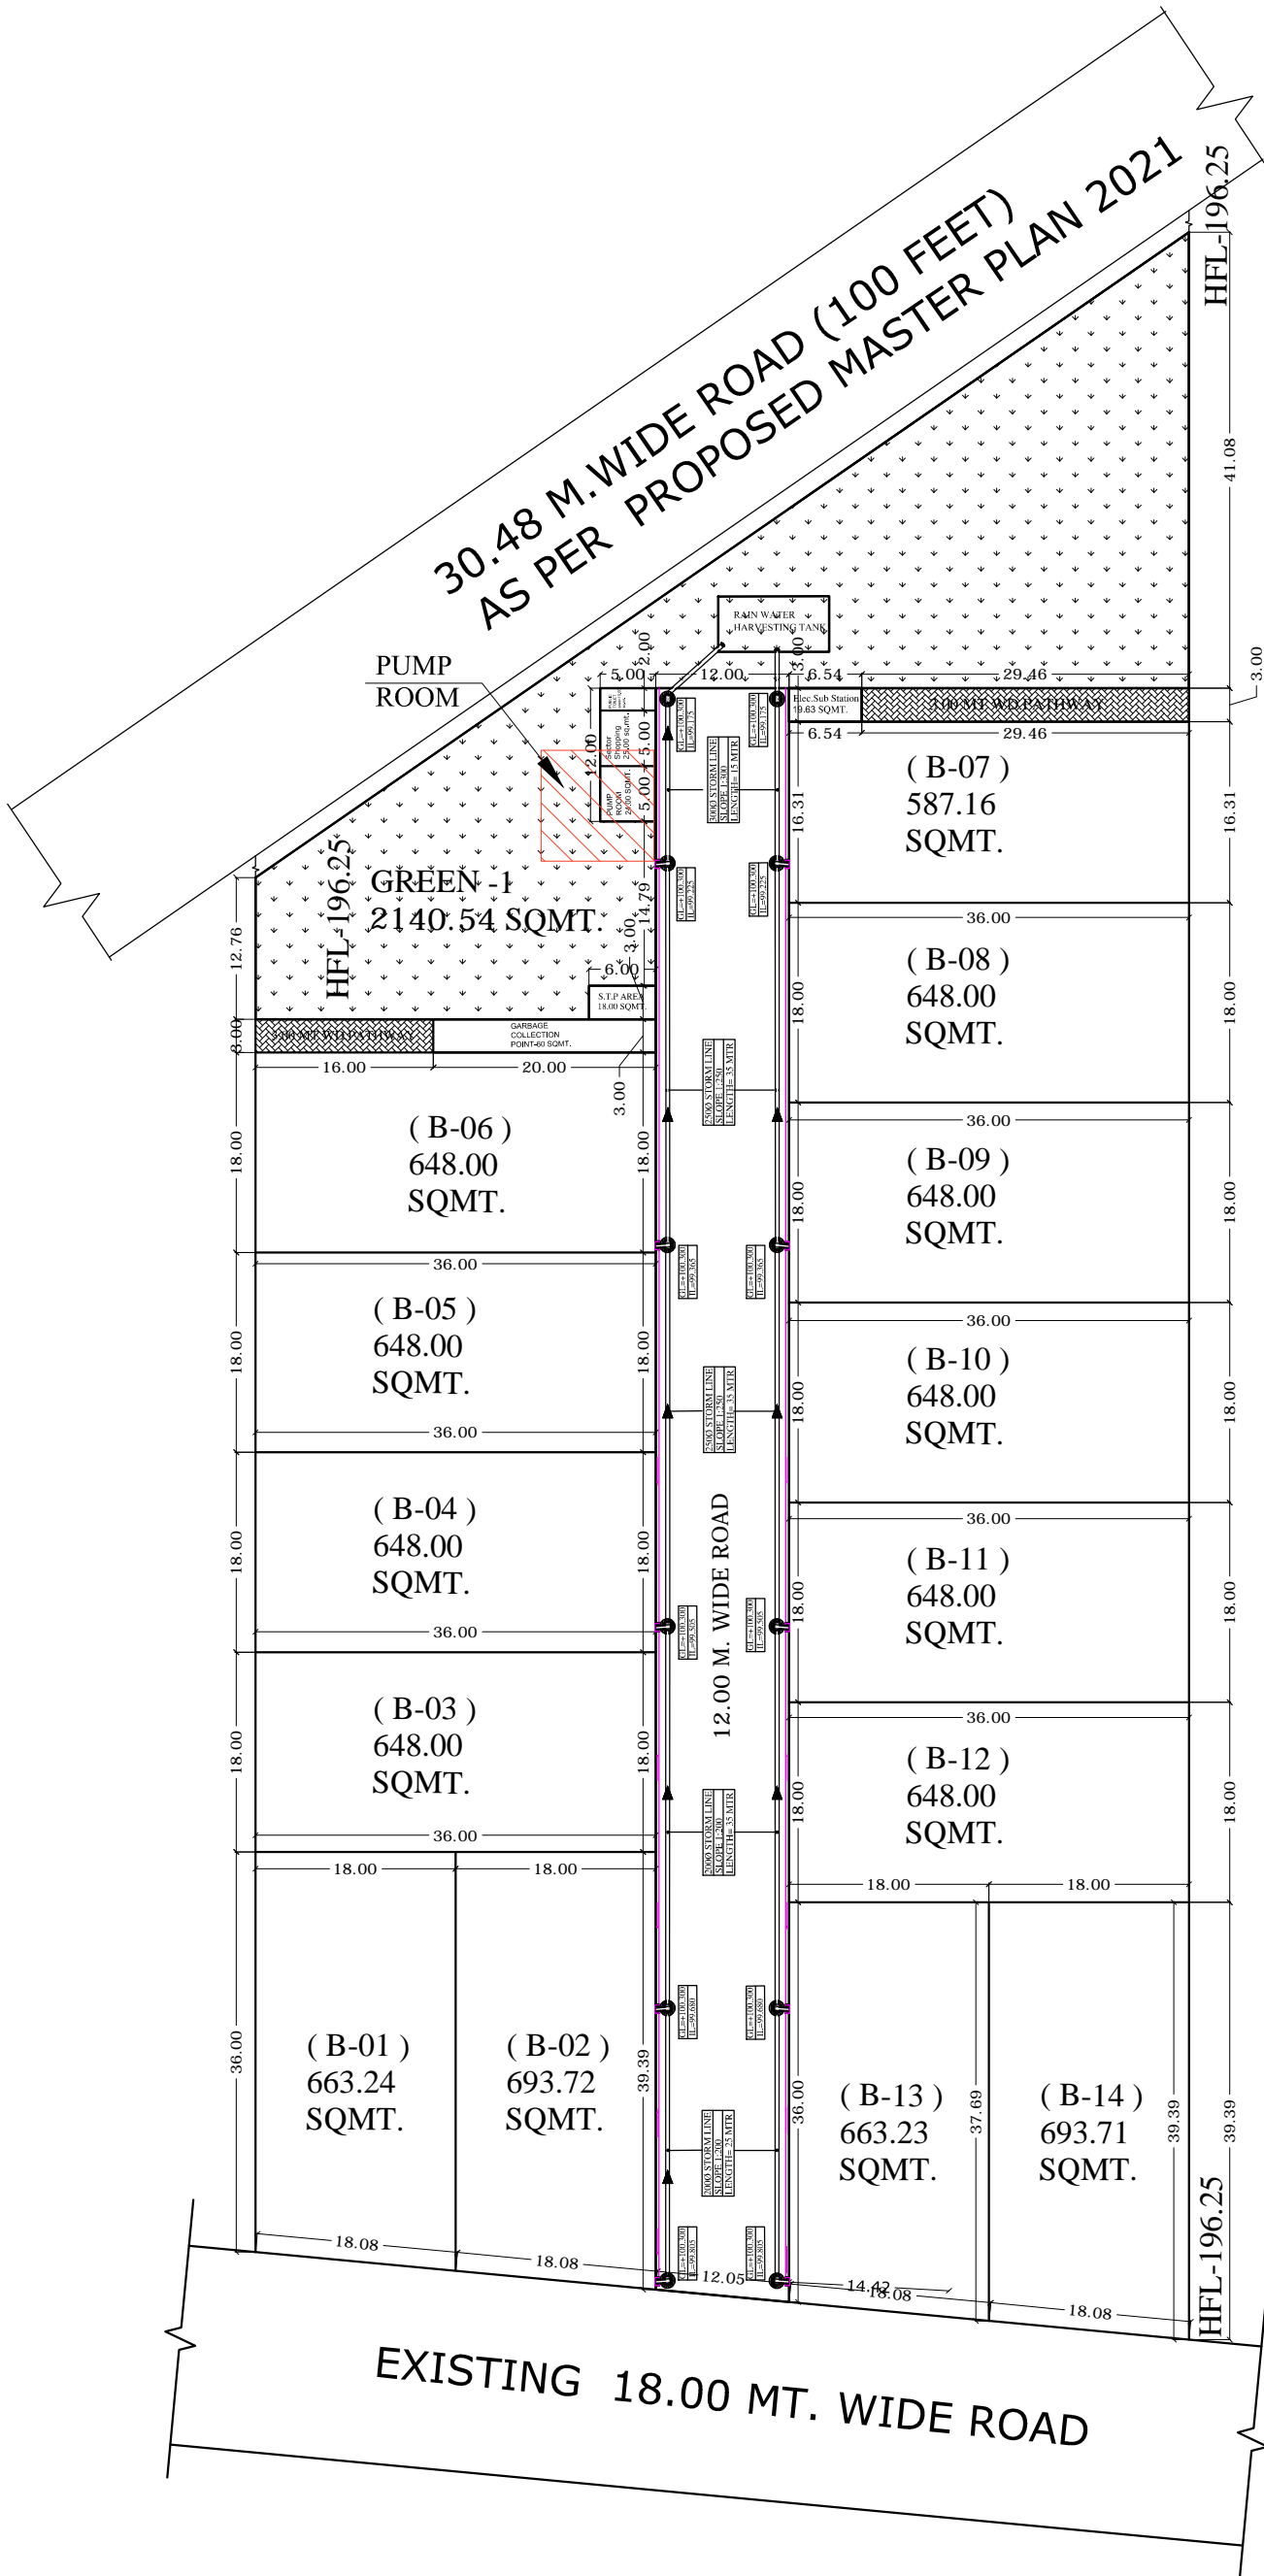

PLUMBING LEGEND-EXTERNAL	
SEWER MANHOLE	
STORM MANHOLE	
CATCH BASIN SIZE 450X500 MM	
SEWER LINE	
STORM LINE	
IRRIGATION LINE	
VALVE CHAMBER 450X450X450MM	
HARVESTING PIT- 4M DIA., 2M W.D	
DESELTING CHAMBER- 1.5 X1 M	
NON RETURN VALVE	
VALVE	
GARDEN HYDRANT.	
TAP FOR CAR/ROAD WASH.	

CLIENT:	P.S. GREEN	PROJECT:	RESIDENTIAL LAYOUT AT HARTHALA AHTMALI MORADABAD	DATE OF ISSUE:	15-12-23	DEALT BY:	AMITCHAND	ARCHITECT:	VINAYAK GUPTA B.ARCH./MARCH(LONDON)	 ARCHANA RAJ PLANNERS AND CONSULTANTS ARCHITECTURE INTERIORS LANDSCAPE TERRAZZO DESIGN
SHEET TITLE:	WATER SUPPLY PLAN			DRG NO:					PAVIT SHANKAR DUTT SHARMA MARG, OPP. CIVIL LINES POLICE STATION, MORADABAD MOB: +91 9359436900 E-MAIL: ajrc@autodesk.com, vinayk_gupta2002@yahoo.com	