

PROJECT
PROPOSED COMMERCIAL FLOORS AT EXISTING COMMERCIAL COMPLEX OF ROHTAS GROUP HOUSING ON PLOT NO. TC/G-4/4, AT VIBHUTI KHAND GOMTINAGAR LUCKNIW

SITE PLAN (SERVICES)

DATE	SCALE	RIVISION	SHEET NO.
MAR_2024			1/2
DRAWING NO.	SHEET SIZE		

01-EXISTING AREA SHOWN THUS
 02-PROPOSED AREA SHOWN THUS
 03-COMPOUNDED AREA SHOWN THUS


THIS IS TO CERTIFY THAT PROPOSED BUILDING HAS BEEN PREPARED ACCORDING TO THE INFORMATION GIVEN BY THE OWNER AND BUILDING BYE LAWS & MASTER PLAN 2031.

CONSULTANT

ARCHITECT

 Tarun Sen Singh
 Architect
 Reg.No.-CA/2013/60532


OWNER

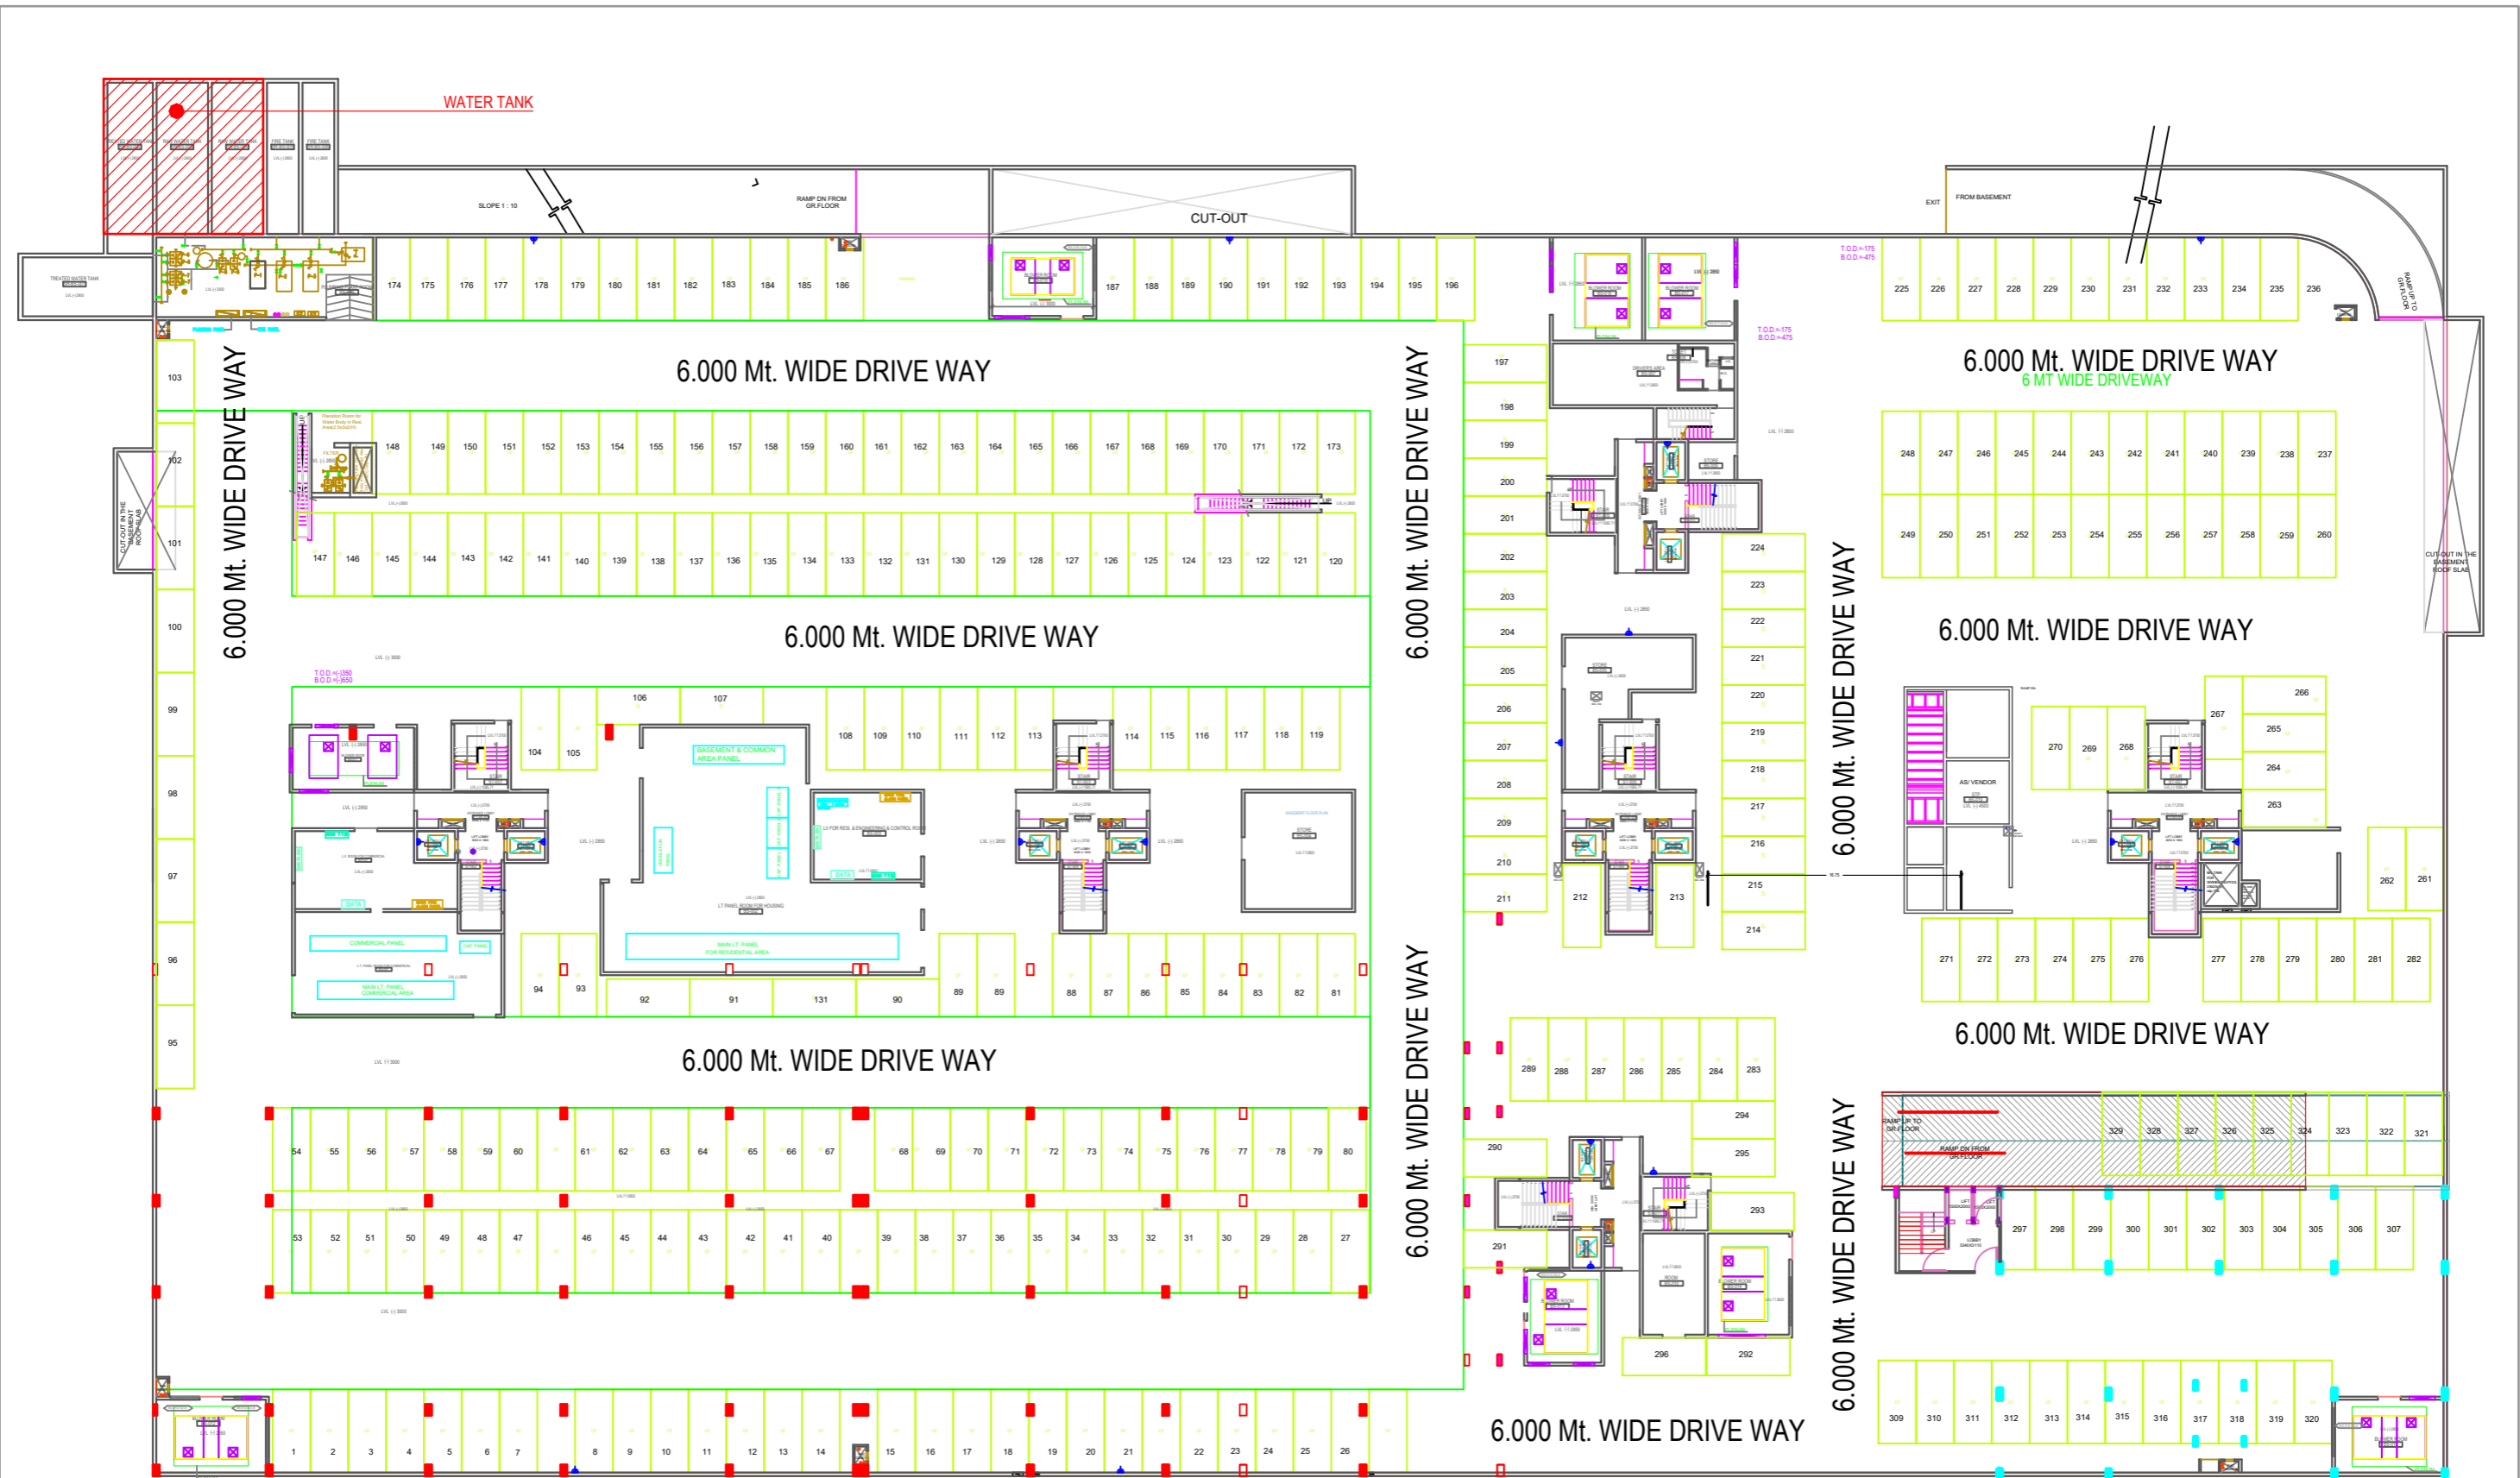

BASEMENT FLOOR PLAN

PROJECT:-
PROPOSED COMMERCIAL FLOORS AT EXISTING COMMERCIAL COMPLEX OF ROHTAS GROUP HOUSING ON PLOT NO. TC/G-4/4, AT VIBHUTI KHAND GOMTINAGAR LUCKNOW

TITLE:-
BASMENT FLOOR PLAN

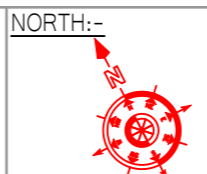

LEGEND:-

- 01-EXISTING AREA SHOWN THUS
- 02-PROPOSED AREA SHOWN THUS
- 03-COMPOUNDED AREA SHOWN THUS


Tarun Singh
 Tarun Sen Singh
 Architect
 Reg.No.-CA/2013/0592

LEGEND:- SEWERAGE

SL.	SYMBOL	DESCRIPTION
1.		SEWER LINE MAN HOLE 900X800
2.		G.T. (450X450)
3.		I.C. (600X600)
4.		150 Ø S.W.P. S=1 IN 100
5.		WATER SUPPLY LINE (CPVC)
6.		WEST WATER PIPE (UPVC)
7.		RAIN WATER PIPE (PVC)
8.		DIRECTION OF FLOW
9.		WASH BASIN
10.		EUROPEAN W.C.
11.		FLOOR TRAP/ FLOOR DRAIN
12.		SHOWER TAP
13.		ABLUTION TRAP
13.		GATE VALVE

LEGEND:- SEWERAGE


SL.	SYMBOL	LEGEND	DESCRIPTION
1.		Ⓜ	100 Ø RAIN WATER PIPE
2.		Ⓛ	50 Ø DOMESTIC WATER PIPE
3.		Ⓦ	100 Ø WASTE WATER PIPE
4.		Ⓢ	150 Ø SOIL WASTE PIPE

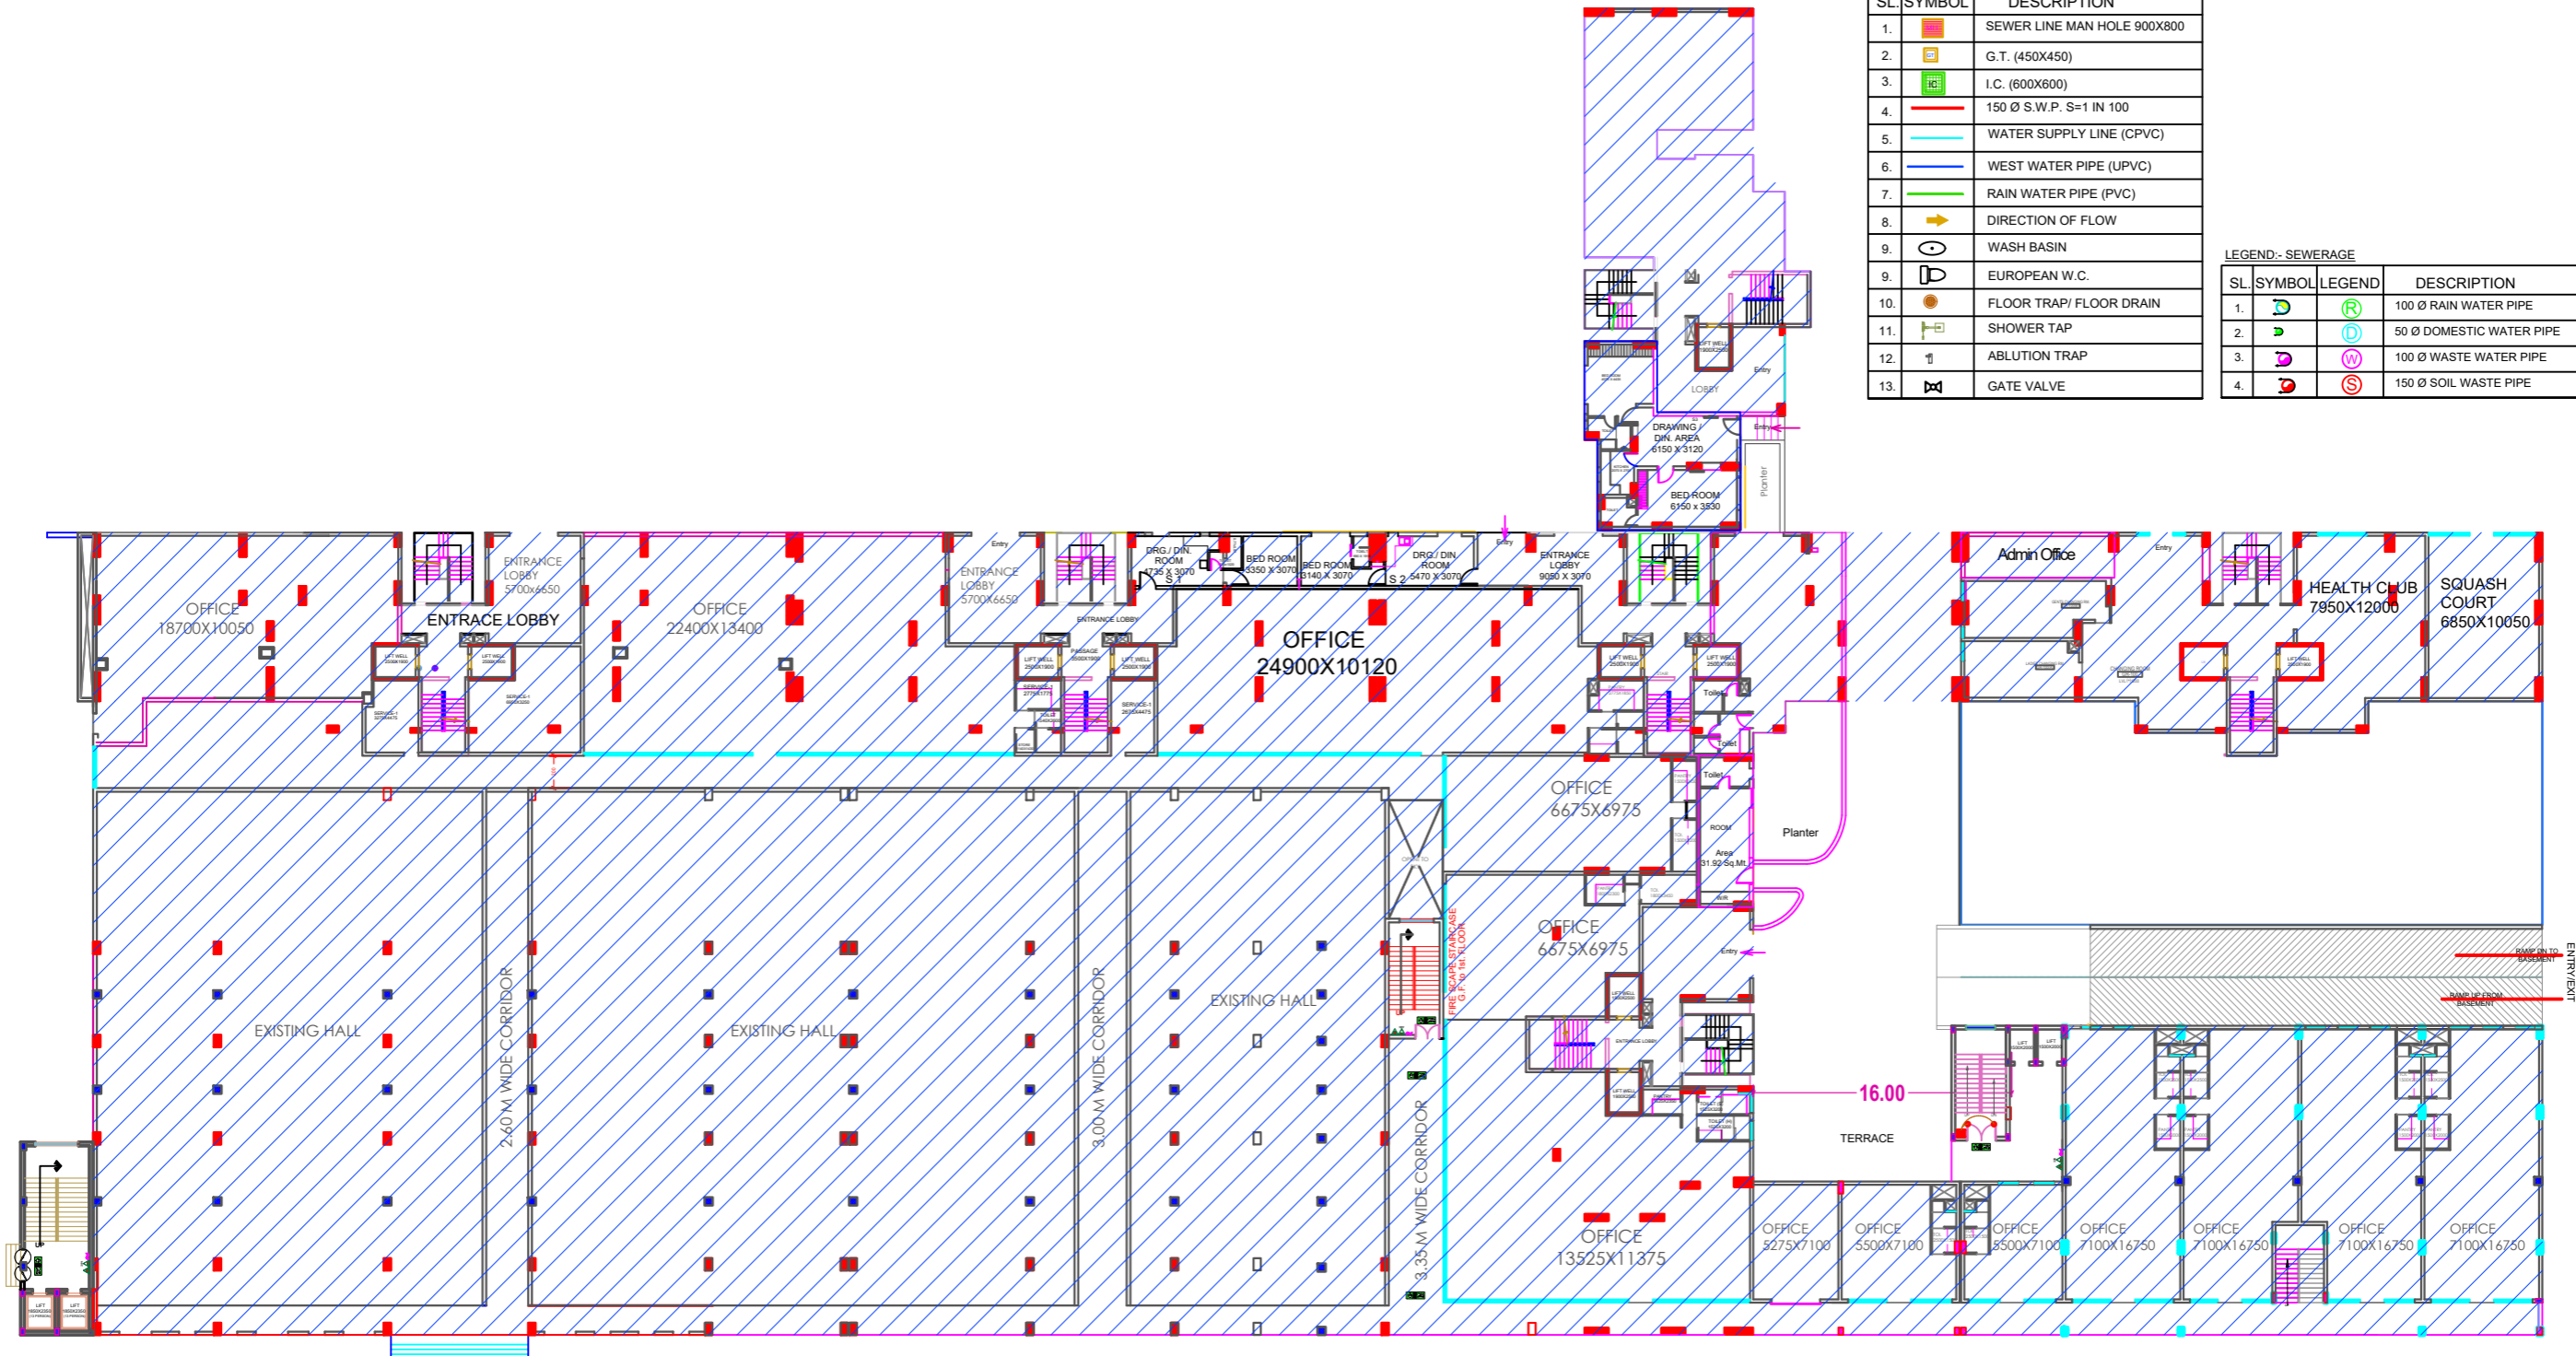

UPPER GROUND FLOOR PLAN

PROJECT:-
PROPOSED COMMERCIAL FLOORS AT EXISTING COMMERCIAL COMPLEX OF ROHTAS GROUP HOUSING ON PLOT NO. TC/G-4/4, AT VIBHUTI KHAND GOMTINAGAR LUCKNOW

TITLE:-
BASEMENT

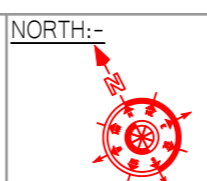

LEGEND:-

- 01-EXISTING AREA SHOWN THUS
- 02-PROPOSED AREA SHOWN THUS
- 03-COMPOUNDED AREA SHOWN THUS



Tarun Singh
 Tarun Sen Singh
 Architect
 Reg.No.-CA/2013/0532

LEGEND:- SEWERAGE

SL.	SYMBOL	DESCRIPTION
1.		SEWER LINE MAN HOLE 900X800
2.		G.T. (450X450)
3.		I.C. (600X600)
4.		150 Ø S.W.P. S=1 IN 100
5.		WATER SUPPLY LINE (CPVC)
6.		WEST WATER PIPE (UPVC)
7.		RAIN WATER PIPE (PVC)
8.		DIRECTION OF FLOW
9.		WASH BASIN
9.		EUROPEAN W.C.
10.		FLOOR TRAP/ FLOOR DRAIN
11.		SHOWER TAP
12.		ABLUTION TRAP
13.		GATE VALVE


LEGEND:- SEWERAGE

SL.	SYMBOL	LEGEND	DESCRIPTION
1.		(R)	100 Ø RAIN WATER PIPE
2.		(D)	50 Ø DOMESTIC WATER PIPE
3.		(W)	100 Ø WASTE WATER PIPE
4.		(S)	150 Ø SOIL WASTE PIPE

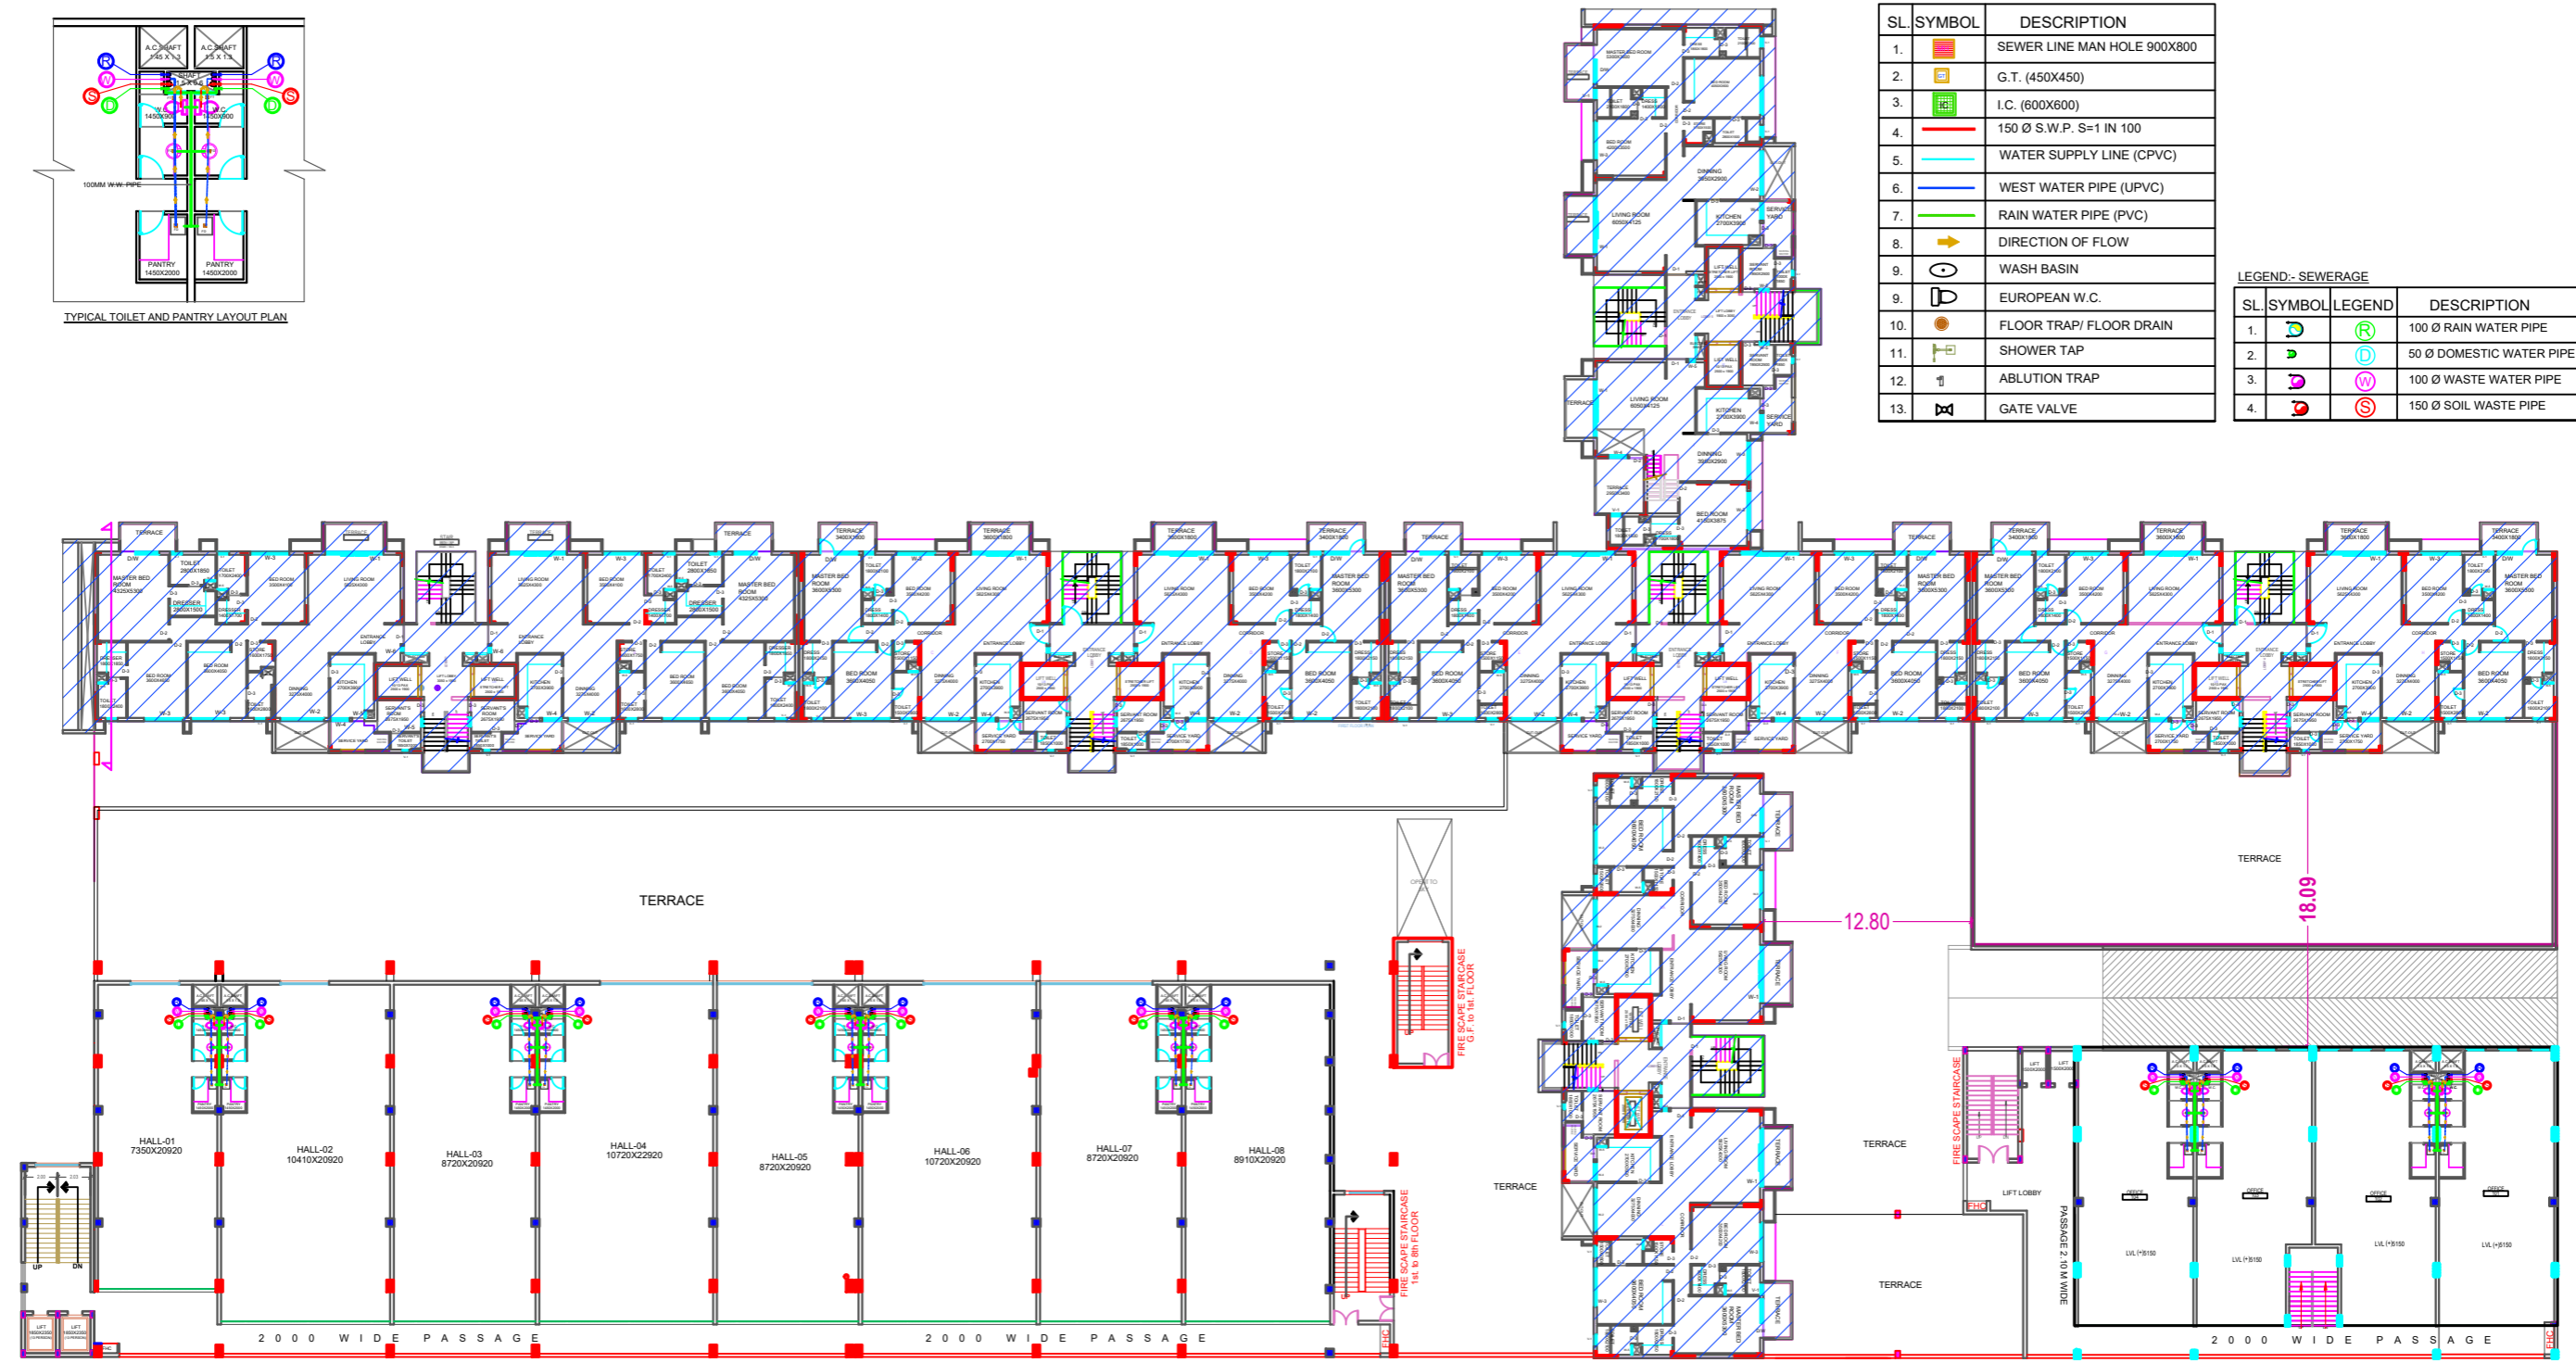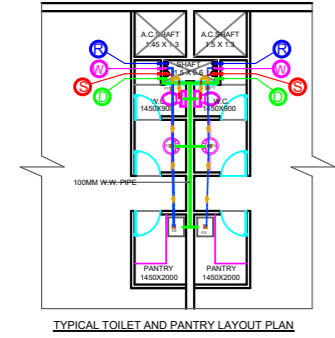

FIRST FLOOR PLAN

<p>PROJECT:- PROPOSED COMMERCIAL FLOORS AT EXISTING COMMERCIAL COMPLEX OF ROHTAS GROUP HOUSING ON PLOT NO. TC/G-4/4, AT VIBHUTI KHAND GOMTINAGAR LUCKNOW</p>	<p>TITLE:- PLUMBING FIRST FLOOR</p>	<p>NORTH:- </p>	<p>LEGEND:- 01-EXISTING AREA SHOWN THUS 02-PROPOSED AREA SHOWN THUS </p>	<p><i>Tarun Singh</i> Tarun Sen Singh Architect Reg.No.-CA/2013/00532</p>
--	---	----------------------	---	--

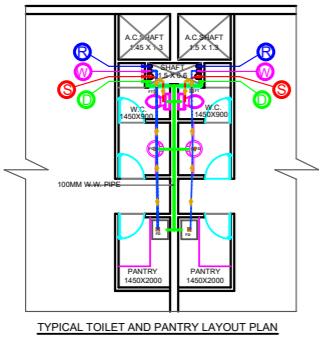


LEGEND:- SEWERAGE

SL.	SYMBOL	DESCRIPTION
1.		SEWER LINE MAN HOLE 900X800
2.		G.T. (450X450)
3.		I.C. (600X600)
4.		150 Ø S.W.P. S=1 IN 100
5.		WATER SUPPLY LINE (CPVC)
6.		WEST WATER PIPE (UPVC)
7.		RAIN WATER PIPE (PVC)
8.		DIRECTION OF FLOW
9.		WASH BASIN
9.		EUROPEAN W.C.
10.		FLOOR TRAP/ FLOOR DRAIN
11.		SHOWER TAP
12.		ABLUTION TRAP
13.		GATE VALVE

LEGEND:- SEWERAGE


SL.	SYMBOL	LEGEND	DESCRIPTION
1.		(R)	100 Ø RAIN WATER PIPE
2.		(D)	50 Ø DOMESTIC WATER PIPE
3.		(W)	100 Ø WASTE WATER PIPE
4.		(S)	150 Ø SOIL WASTE PIPE

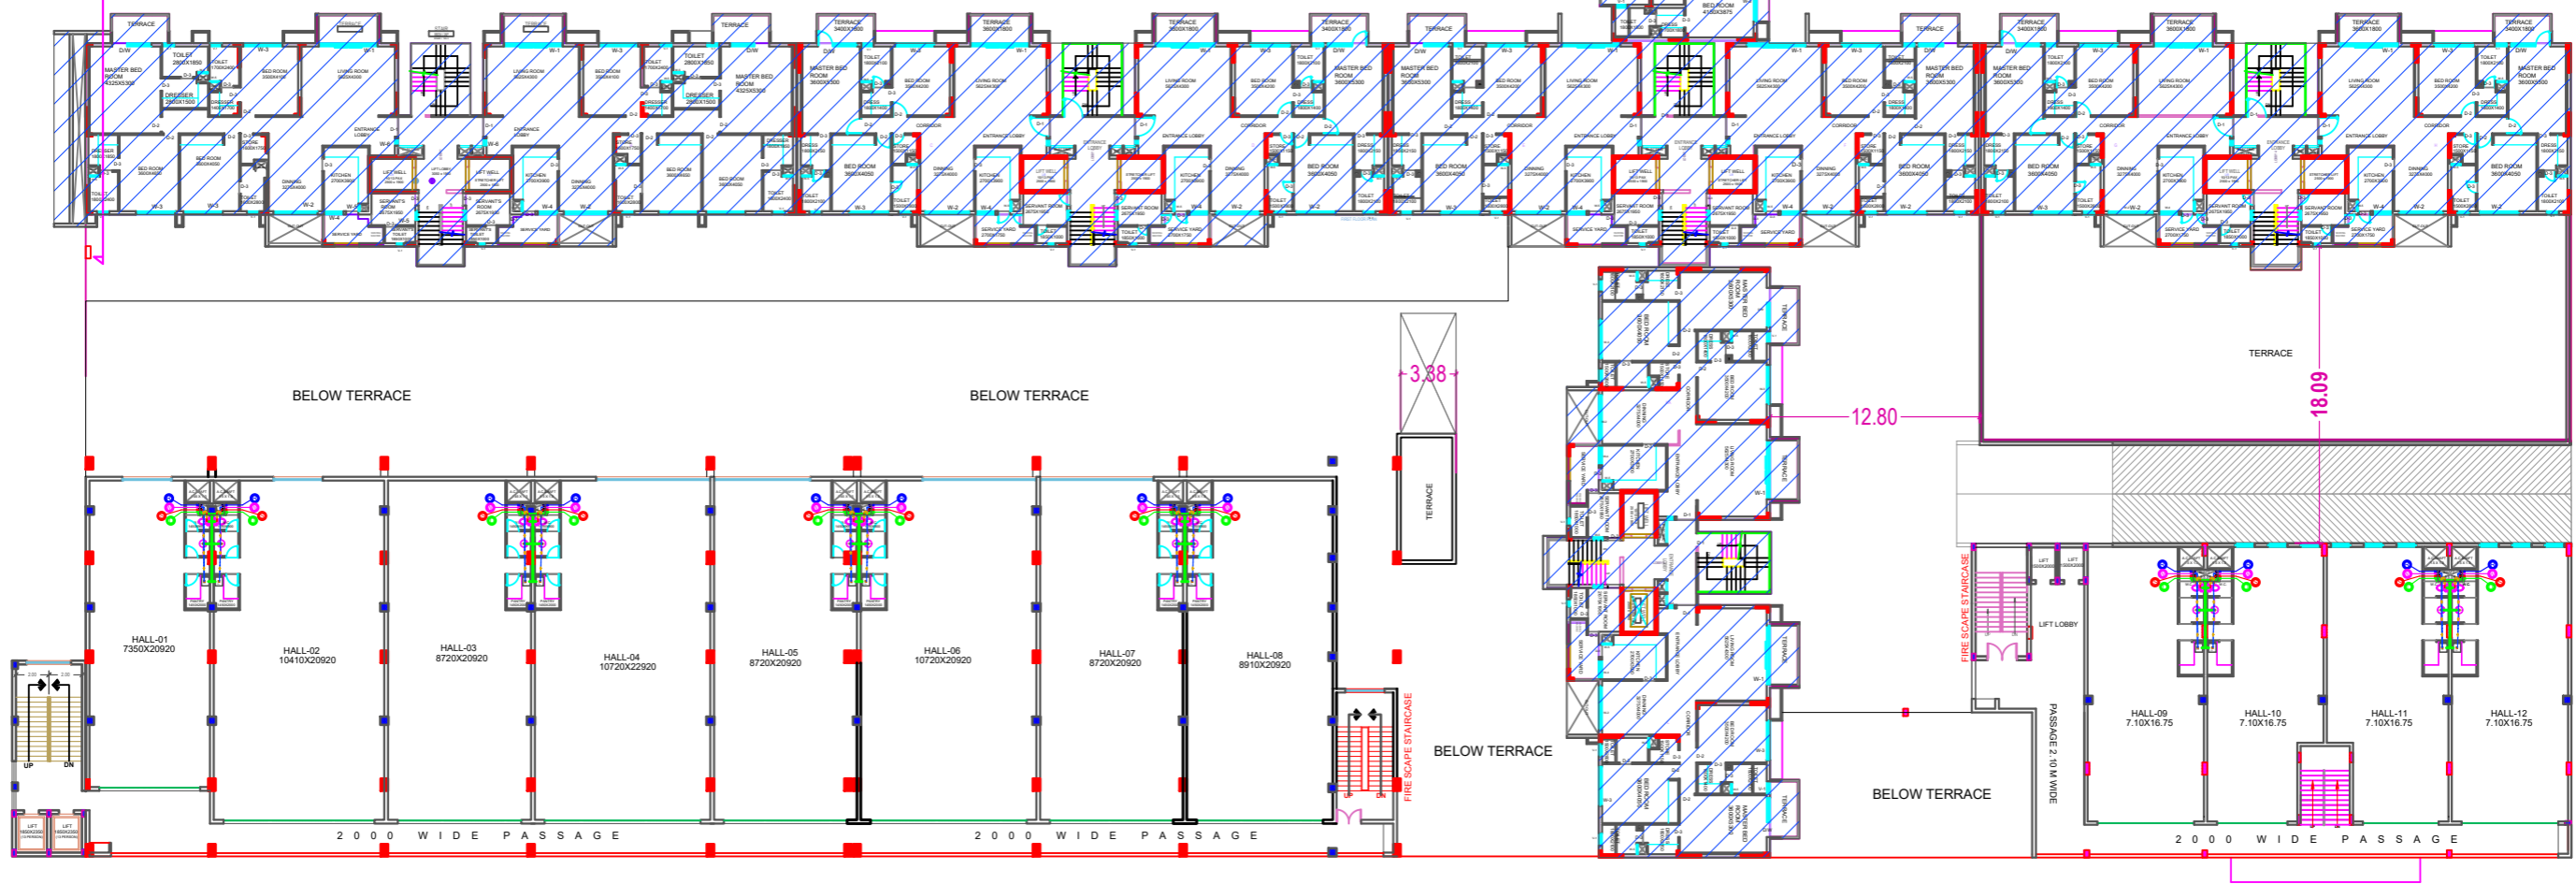


SECOND TO EIGHTH FLOOR PLAN

PROJECT:-
PROPOSED COMMERCIAL FLOORS AT EXISTING COMMERCIAL COMPLEX OF ROHTAS GROUP HOUSING ON PLOT NO. TC/G-4/4, AT VIBHUTI KHAND GOMTINAGAR LUCKNOW

TITLE:-
PLUMBING SECOND TO EIGHT FLOOR

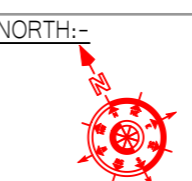

 LEGEND:-
 01-EXISTING AREA SHOWN THUS
 02-PROPOSED AREA SHOWN THUS



Tarun Singh
 Tarun Sen Singh
 Architect
 Reg.No.-CA/2013/0532

