


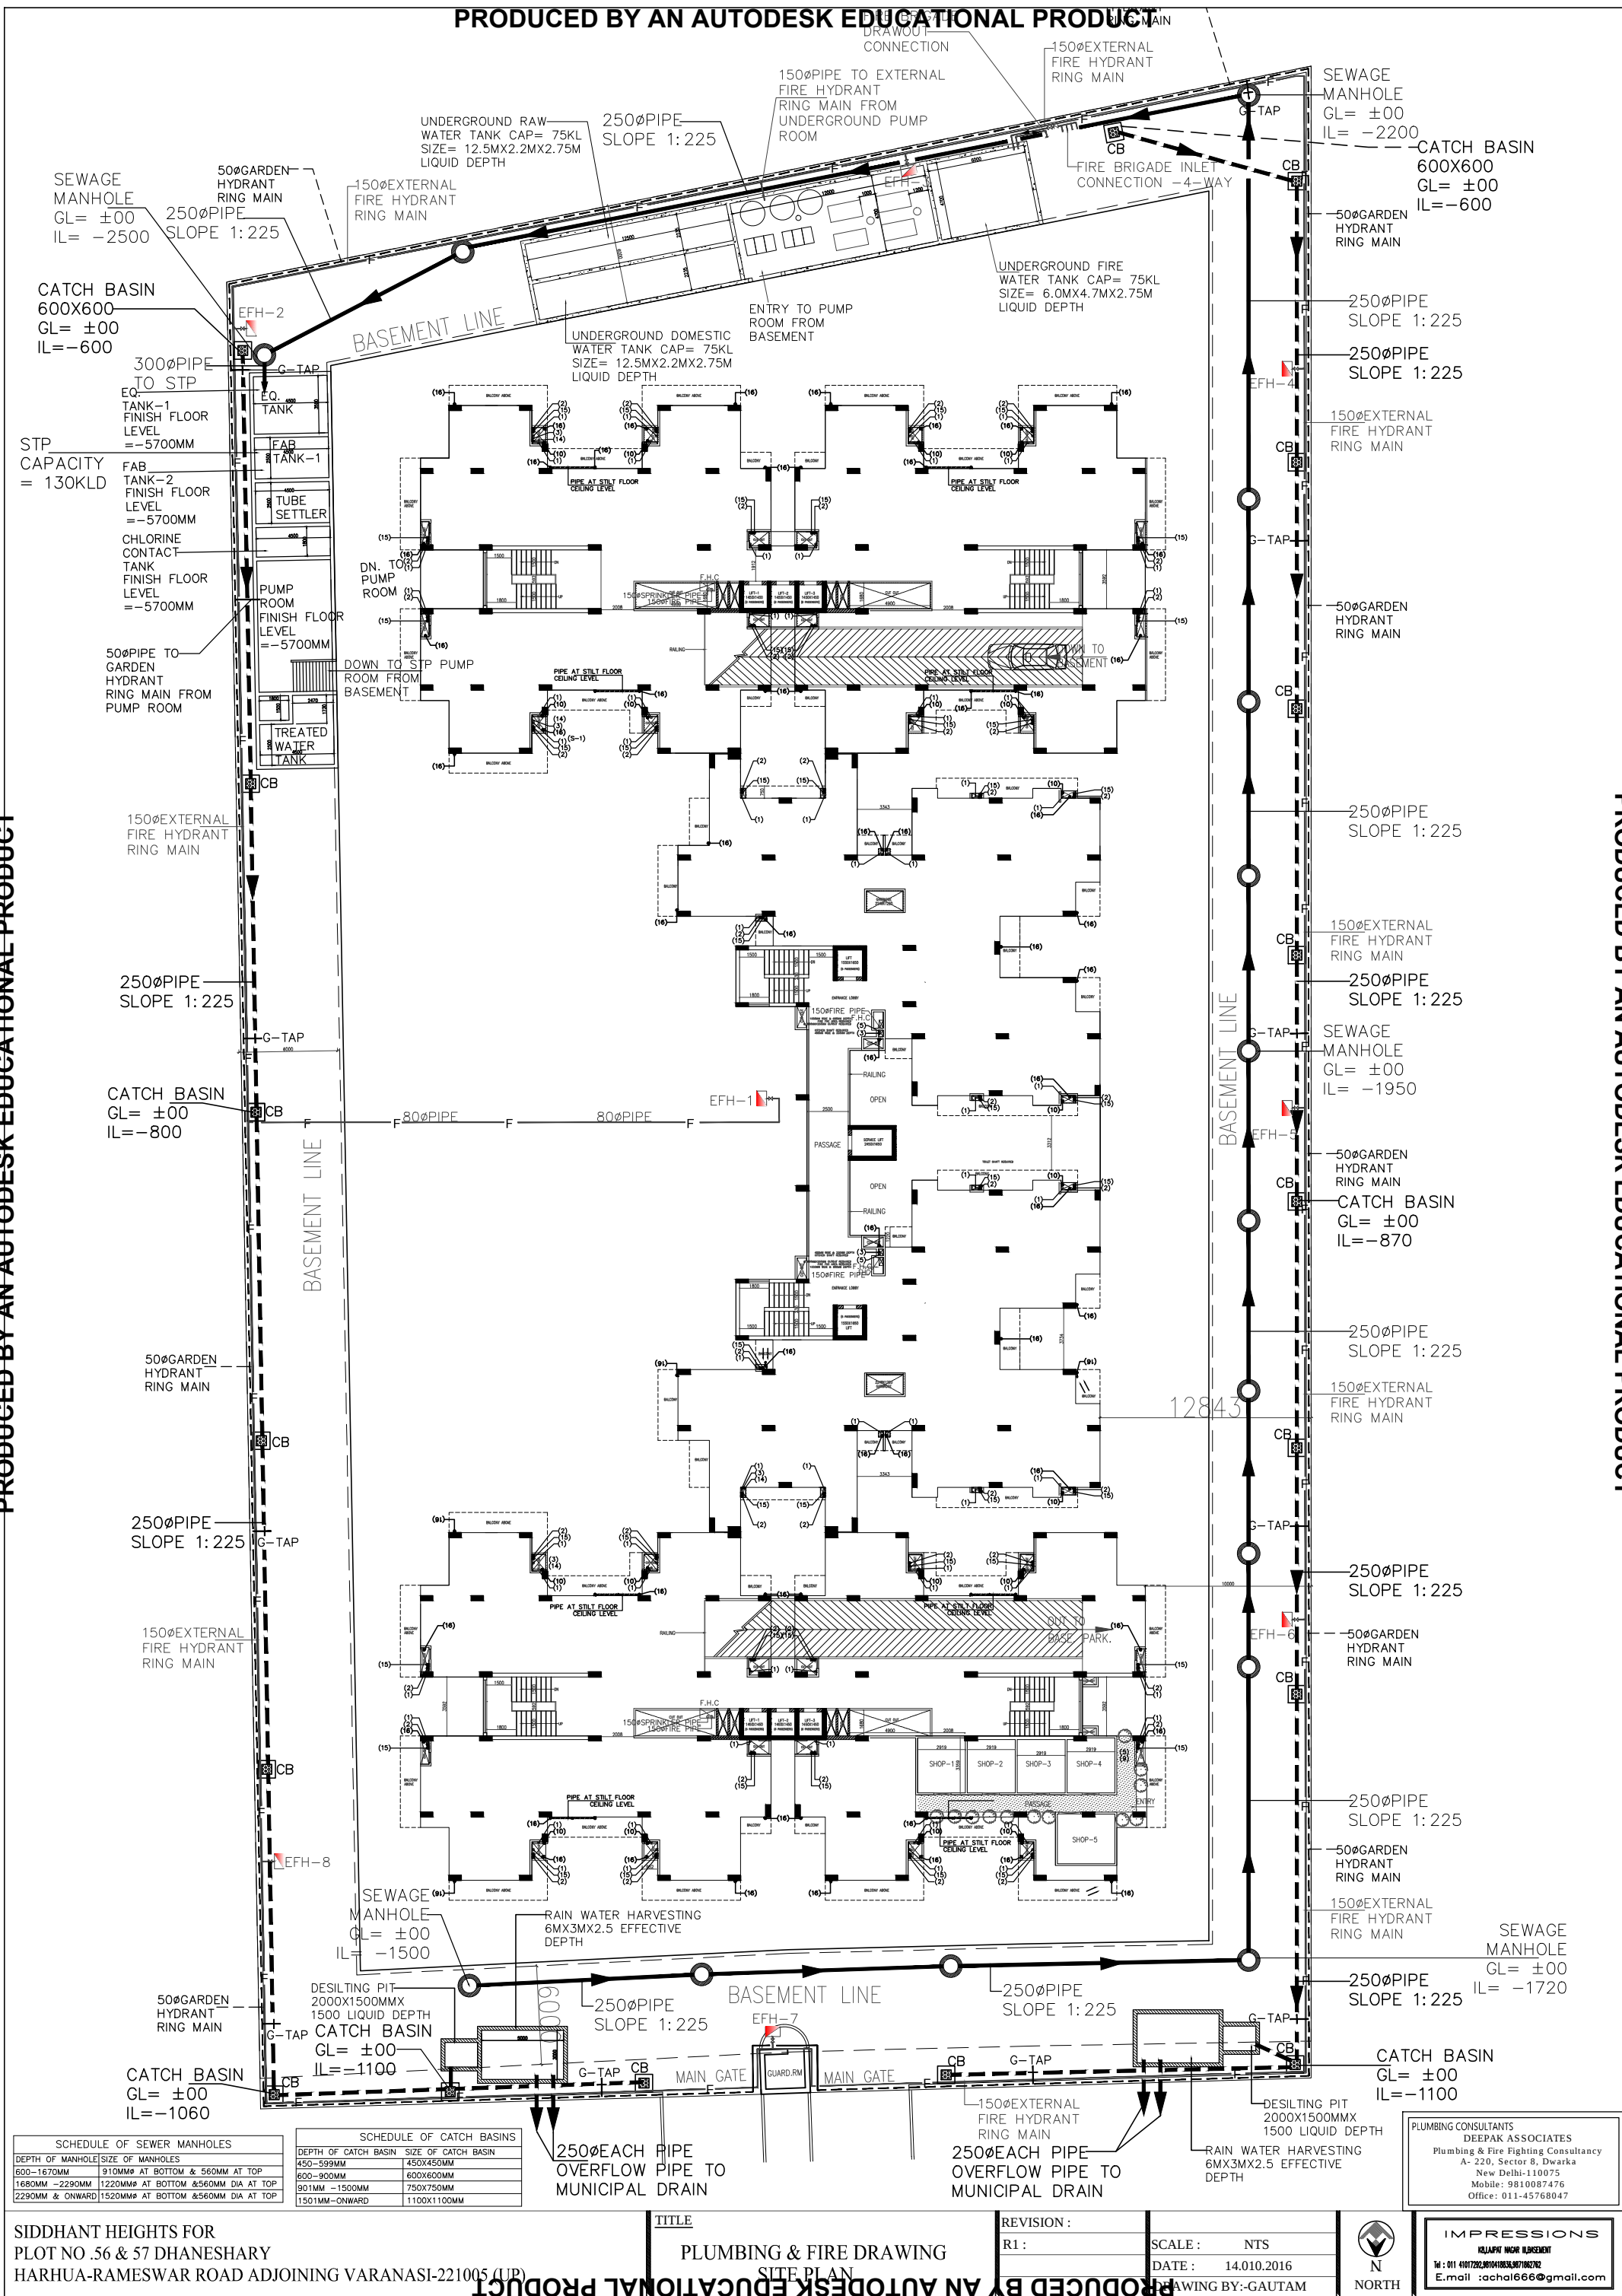

SCHEDULE OF SEWER MANHOLES	
DEPTH OF MANHOLE	SIZE OF MANHOLES
600-1670MM	910MM# AT BOTTOM & 560MM DIA AT TOP
1680MM -2290MM	1220MM# AT BOTTOM & 560MM DIA AT TOP
2290MM & ONWARD	1520MM# AT BOTTOM & 560MM DIA AT TOP

SCHEDULE OF CATCH BASINS	
DEPTH OF CATCH BASIN	SIZE OF CATCH BASIN
450-599MM	450X450MM
600-900MM	600X600MM
901MM -1500MM	750X750MM
1501MM-ONWARD	1100X1100MM

SIDDHANT HEIGHTS FOR
PLOT NO .56 & 57 DHANESHARY
HARHUA-RAMESWAR ROAD ADJOINING VARANASI-221005 (UP)

TITLE
PLUMBING & FIRE DRAWING
SITE PLAN

REVISION :
R1 :
SCALE : NTS
DATE : 14.010.2016
DRAWING BY: GAUTAM

PLUMBING CONSULTANTS
DEEPAK ASSOCIATES
Plumbing & Fire Fighting Consultancy
A- 220, Sector 8, Dwarka
New Delhi-110075
Mobile: 9810087476
Office: 011-45768047

IMPRESSIONS
KALJAPRI NAGAR BUREAU
Tel : 011 41017292, 01101803307/982762
E.mail : aachal666@gmail.com