


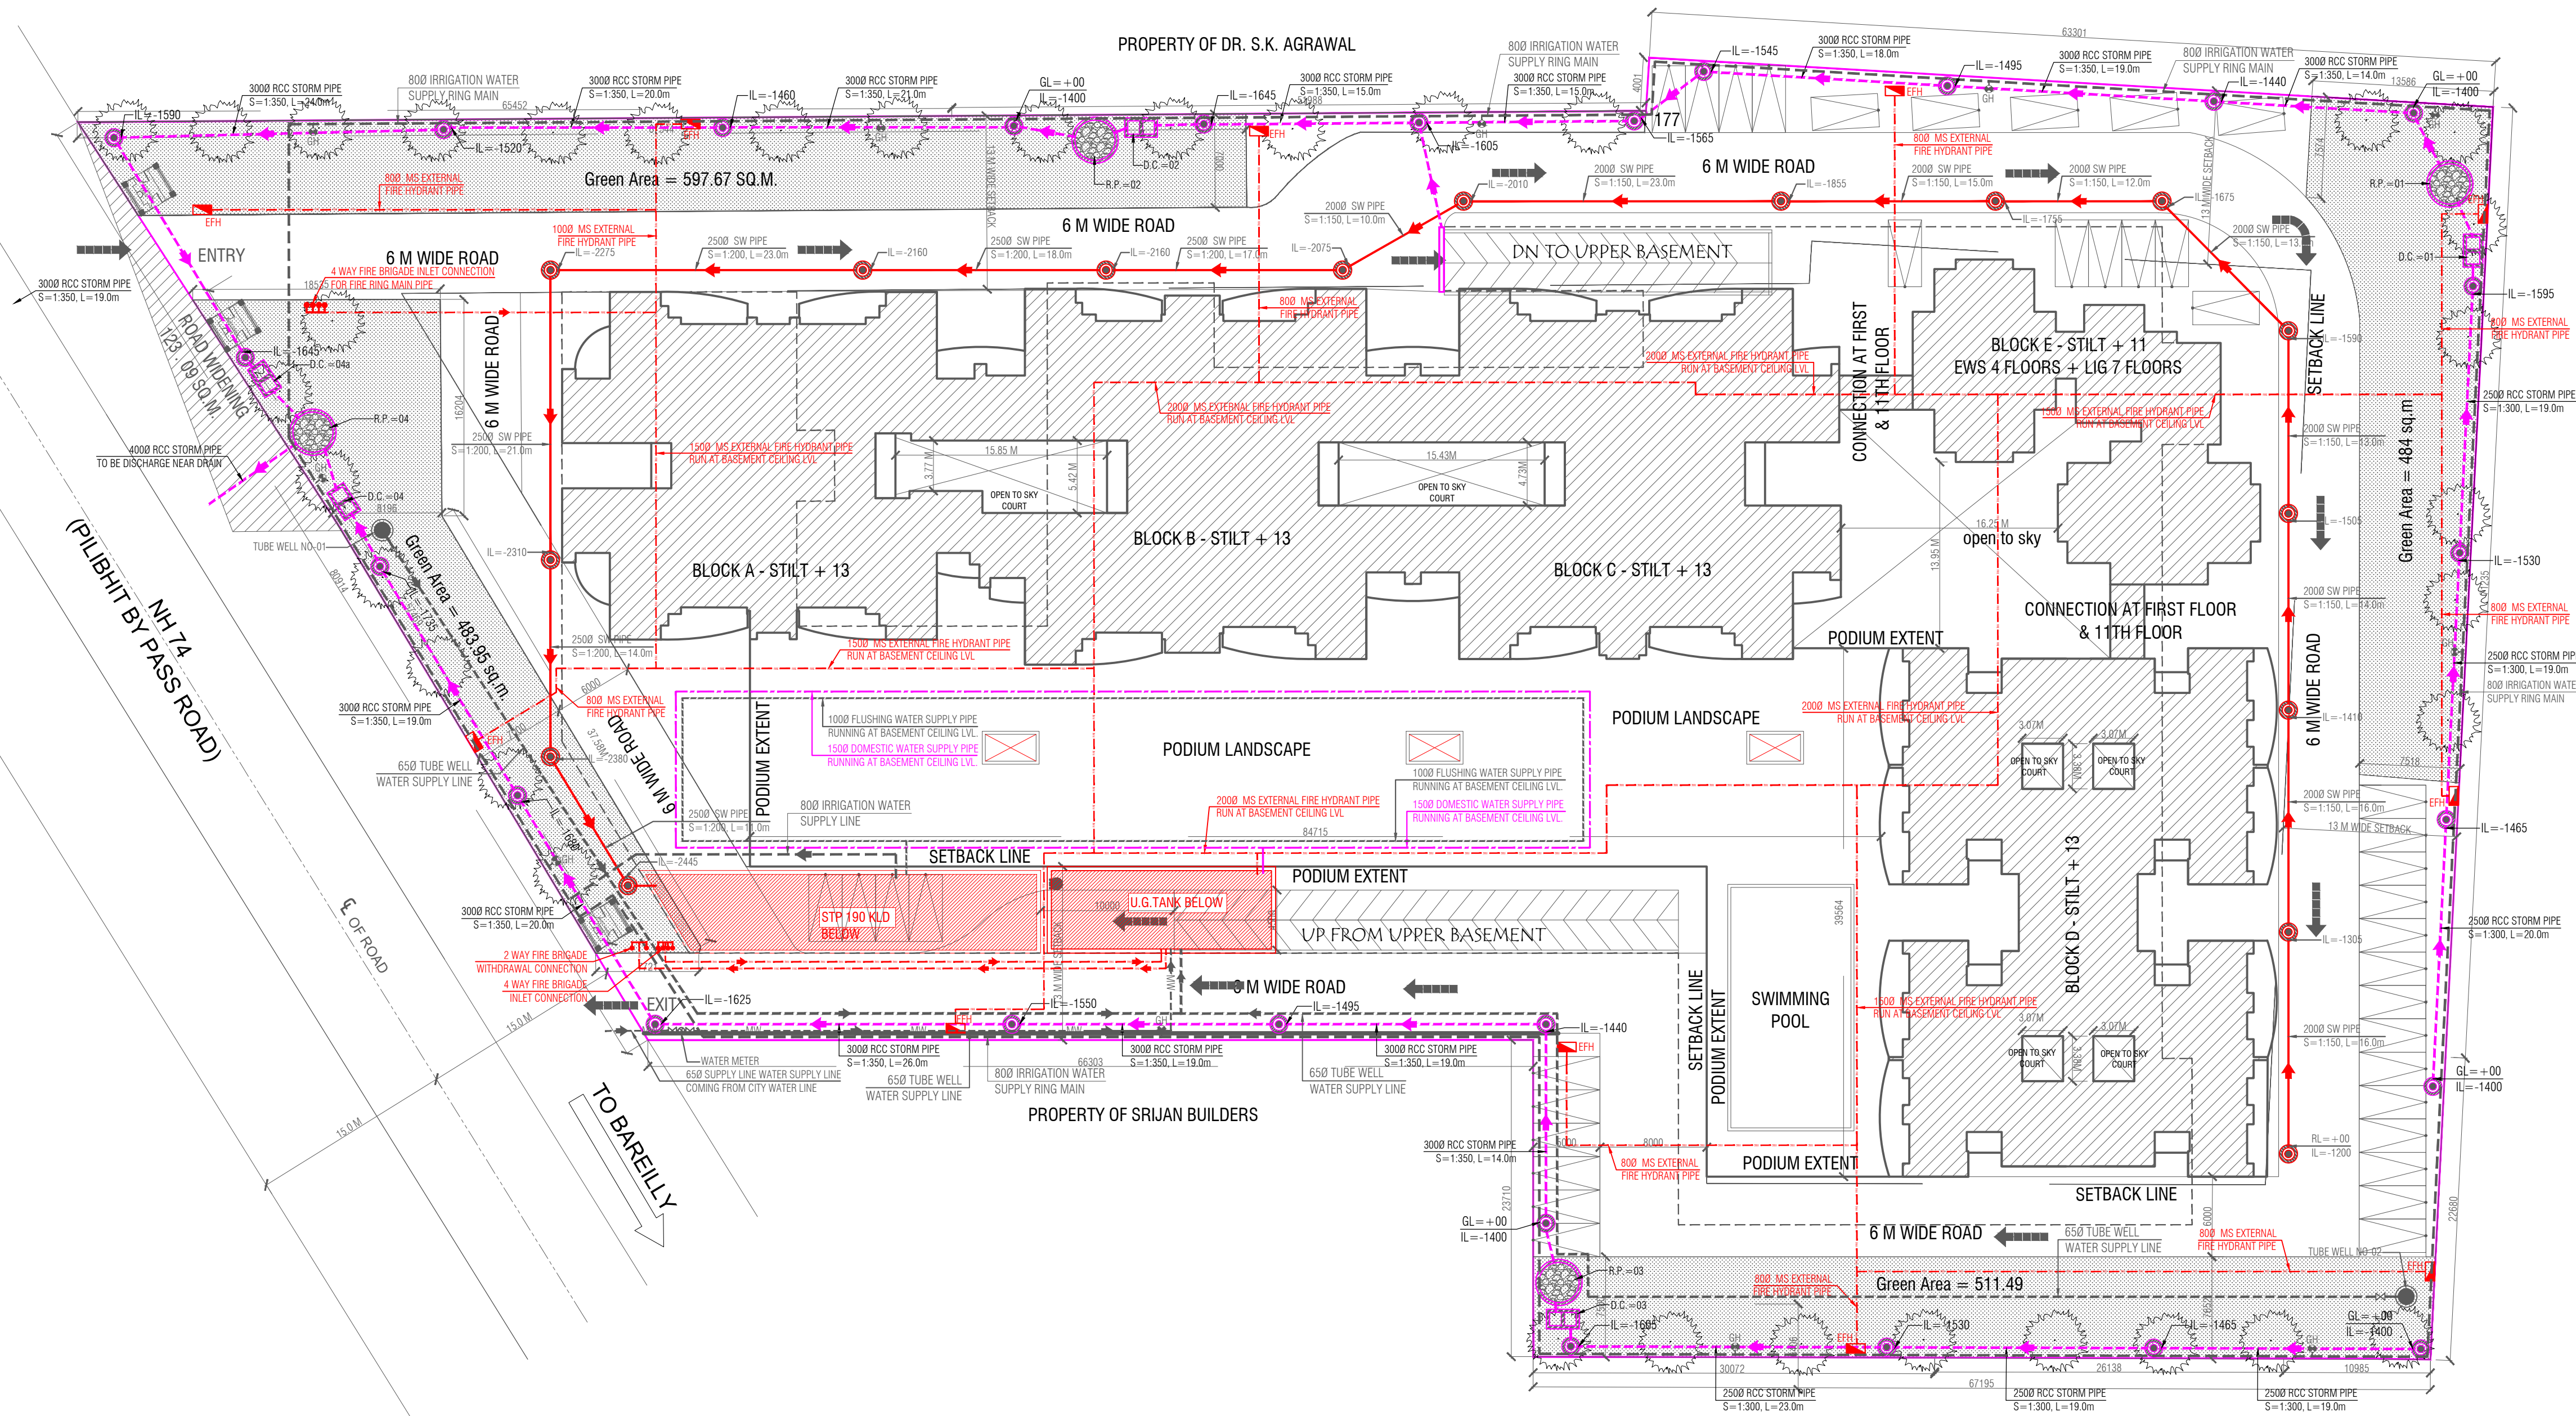

PLUMBING SERVICES LEGEND:

##	STORM WATER MANHOLE (600 x 600) MM
⊗	STORM WATER MANHOLE (900 x 800) MM
⊗	SEWER MANHOLE (800 x 900) MM
⊗	SEWER MANHOLE (900 x 800) MM
—	EXTERNAL SEWER LINE
- - -	EXTERNAL STORM WATER LINE
—	DOMESTIC WATER SUPPLY LINE
—	FLUSHING WATER SUPPLY LINE
- - -	EXTERNAL FIRE HYDRANT LINE
- - -	MUNICIPAL LINE WATER SUPPLY
- - -	MUNICIPAL LINE WATER SUPPLY
- - -	GARDEN IRRIGATION WATER SUPPLY LINE
⊗	EXTERNAL FIRE HYDRANT (750x600x250) MM
⊗	GARDEN HYDRANT
R.P.	RECHARGE PIT (3000 MM DIA)
D.C.	DESILTING CHAMBER (1000 X 2000)MM
⊗	VALVE WITH CHAMBER
⊗	NON RETURN VALVE WITH CHAMBER (N.R.V.)

OWNERS SIGN

ARCHITECTS SIGN

PROJECT
PROPOSED GROUP HOUSING,
MEGA HEIGHTS FOR M/S MEGA
QUALITY PROJECTS LLP. REGISTERED
OFFICE AT C-2, MEGA CITY 1ST FLOOR,
SANJAY NAGAR BYE PASS, BAREILLY.

FOR SITE AT KH. NOS. ,
MINJUMLA (446 TO 452),
(PART)454, (PART)455,
MINJUMLA 456, 457 & 458 IN
VILLAGE BIHARMAN NAGLA AT
NH-74 (BAREILLY PILLBHIT BY
PASS) AT BAREILLY, U.P. -
243001

ARCHITECTS :
MEHTA & ASSOCIATES
C-74, ANAND VIHAR,
DELHI -110092
PH : 22141258, 22144521

SERVICES CONSULTANTS:
PARADISE CONSULTANTS
Plot No. 96, Basement,
Near Living Style Mall, Jasola Vihar
New Delhi - 110025
Landline: -011-29943601, 26943216
E-mail: paradiseconsultants@gmail.com

DRAWING TITLE :
SITE PLAN
PLUMBING LAYOUT

scale : 1:250 (A1) drawn by : VIKRAM
date : 15/07/20 checked by : ANIL
project no : ----- approved by : NAFEEES
drawing no : 25
REVISION RO