


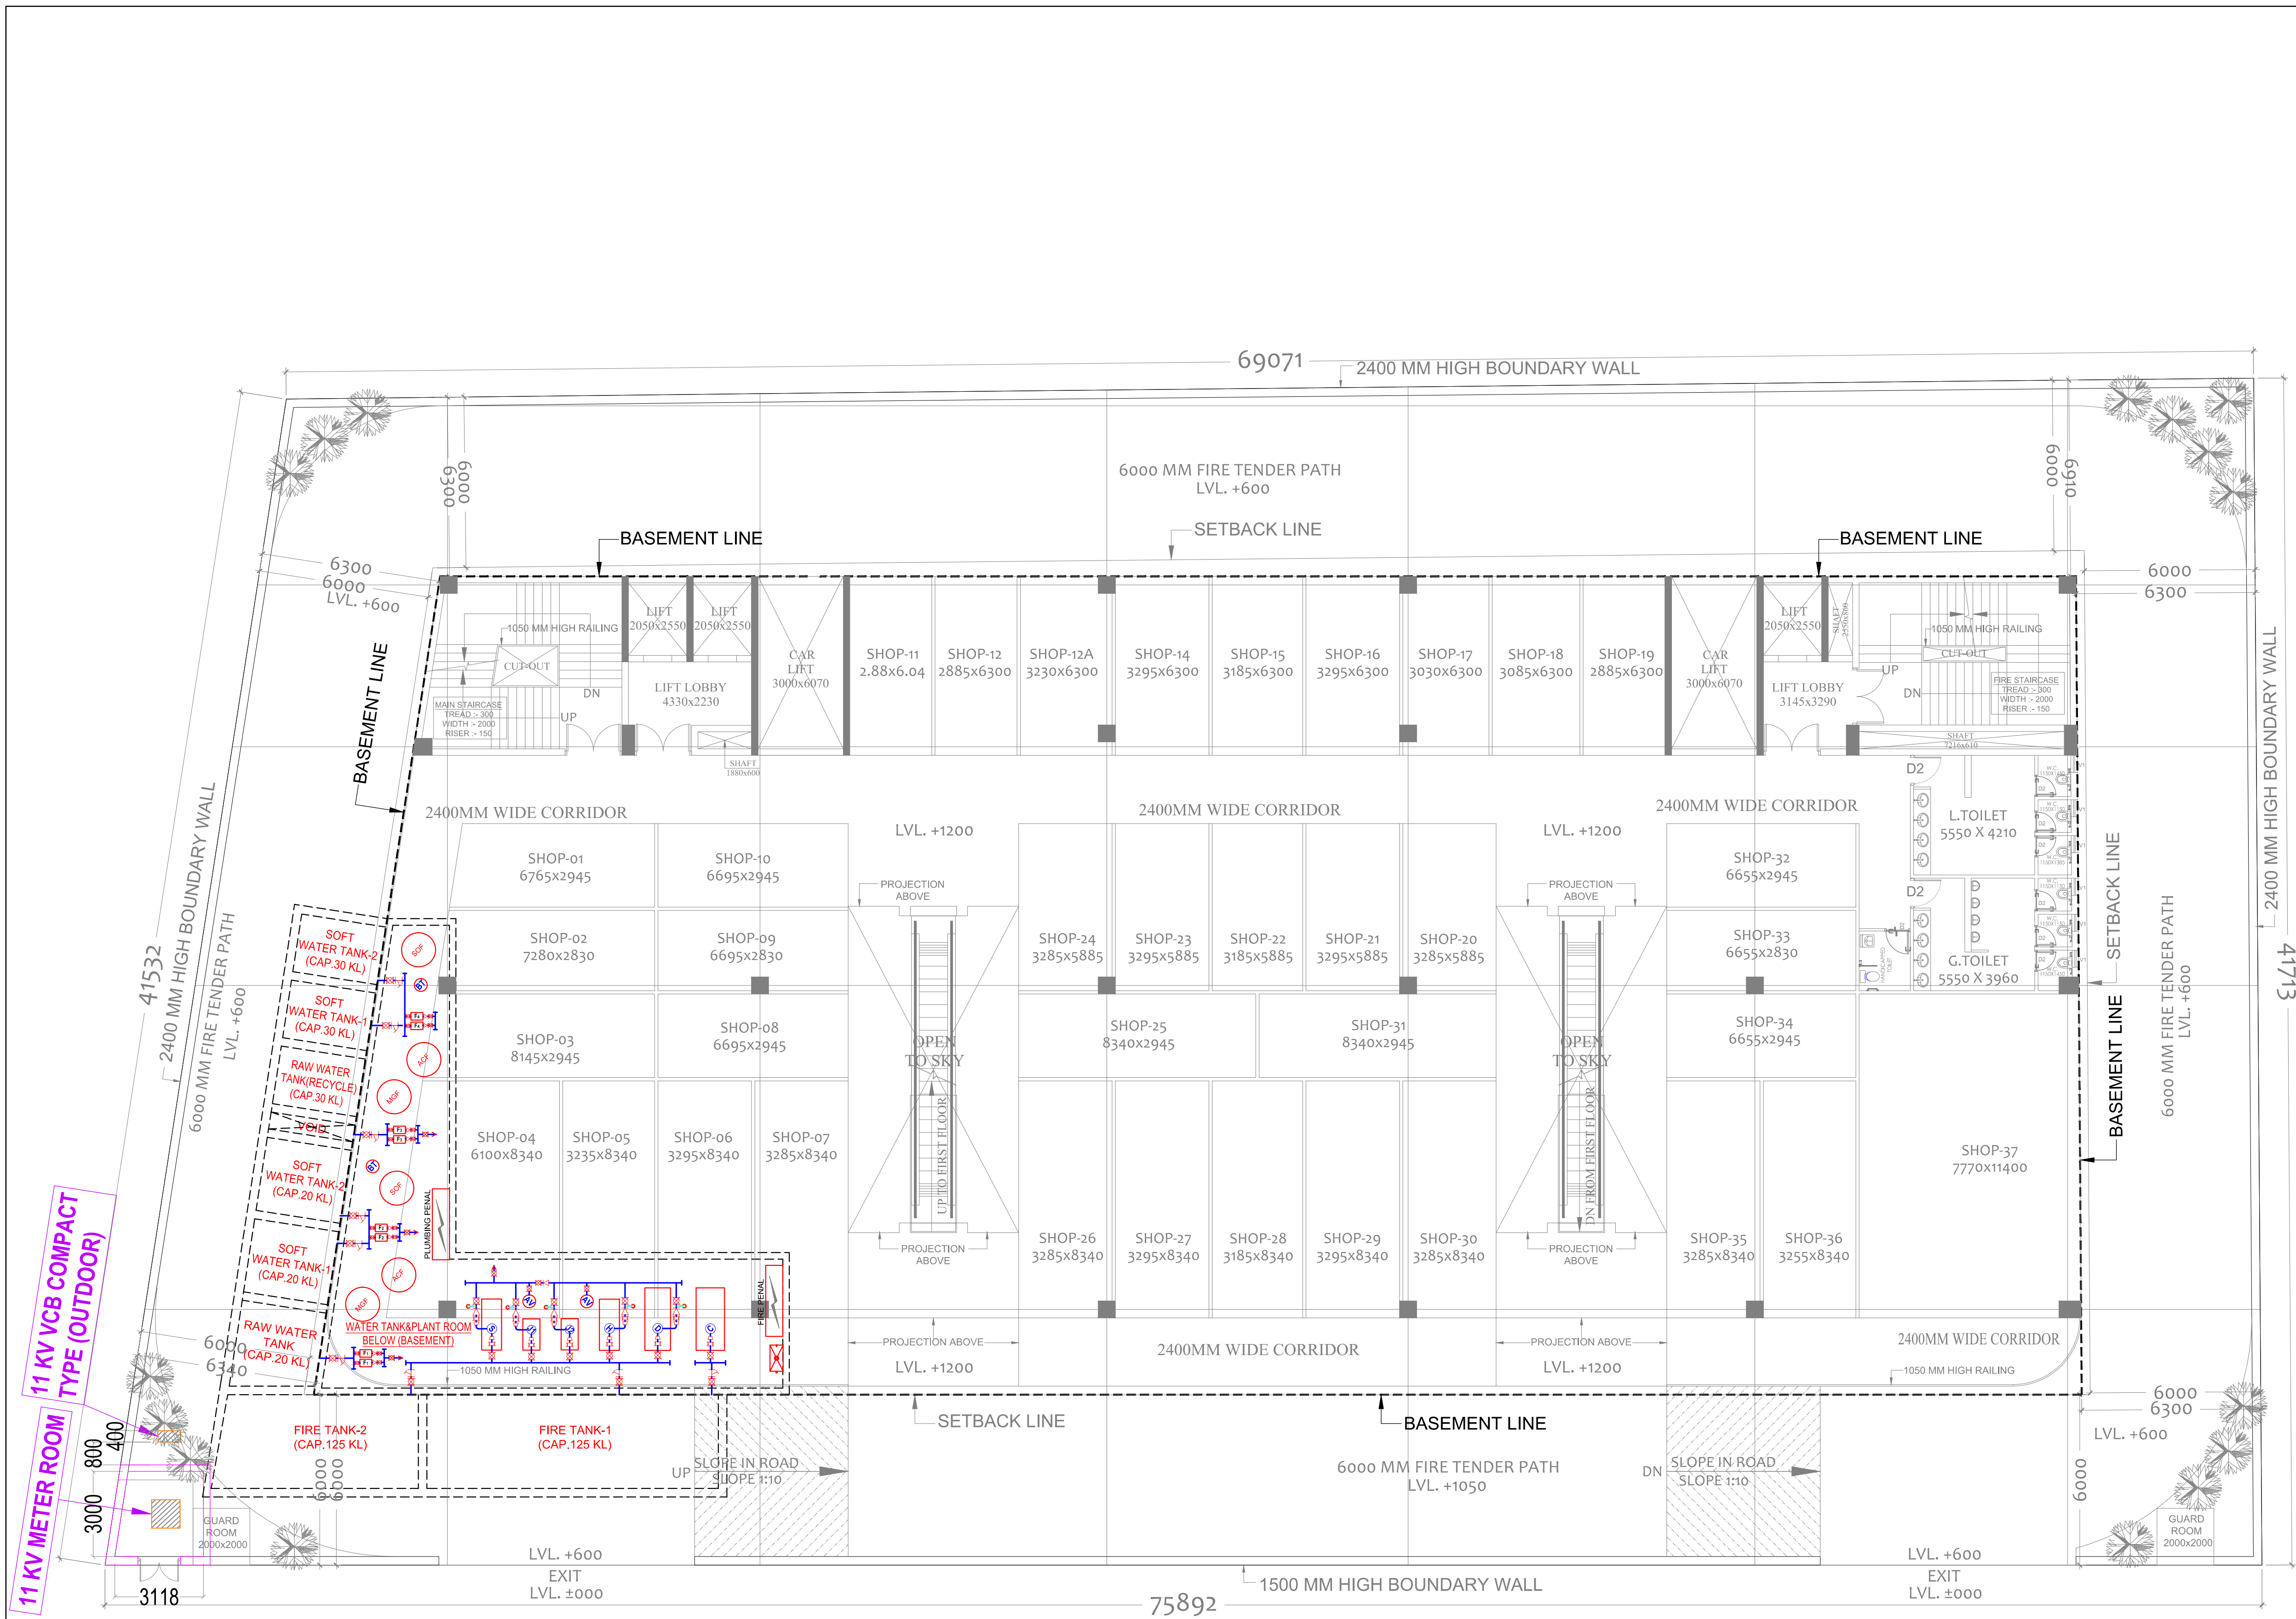

..	..	..
rev. no.	date	revision

project
**PROPOSED SUBMISSION DRAWING FOR
COMMERCIAL CENTER-05, DUDA HERA, GHAZIABAD, UP.**

Owner
GOLD COAST DEVELOPERS PVT. LTD.
A-106, POCKET-4, PANDAV NAGAR, MAYUR VIHAR, DELHI- 110091

title
SITE PLAN

subtitle
EXTERNAL ELECTRICAL LAYOUT

drawing released for
☐ APPROVAL ☒ SUBMISSION
☐ ADVANCE COPY ☐ CONSTRUCTION

drg. no. CES / G.C / SP / P-06 drawn by Surjeet

scale 1:125 @ A1 designed by Ateeq Ur Rehman

date 16.09.2021 checked by Anand Havella

architects :
modarchindia
architects interior designers & planners
studio: 1st floor, B-99, sector-63, Noida -201301, U.P.
phone: 0120-4206253, email: amitganga@hotmail.com
website: www.modarch.in

services consultant
Consummate Engineering Services (P) Ltd.
Noida Office : B - 67, Sector - 67, Noida - 201 301
Tel : (0120) 2303500 (30 Lines)
Lko. Office : R 006, Rohas Plumeria, Gomti Nagar, Lucknow
e mail : mail@cespln.in, website : www.cespln.in