


24 M. W I D E R O A D

113650

PLOT NO: GH-06B

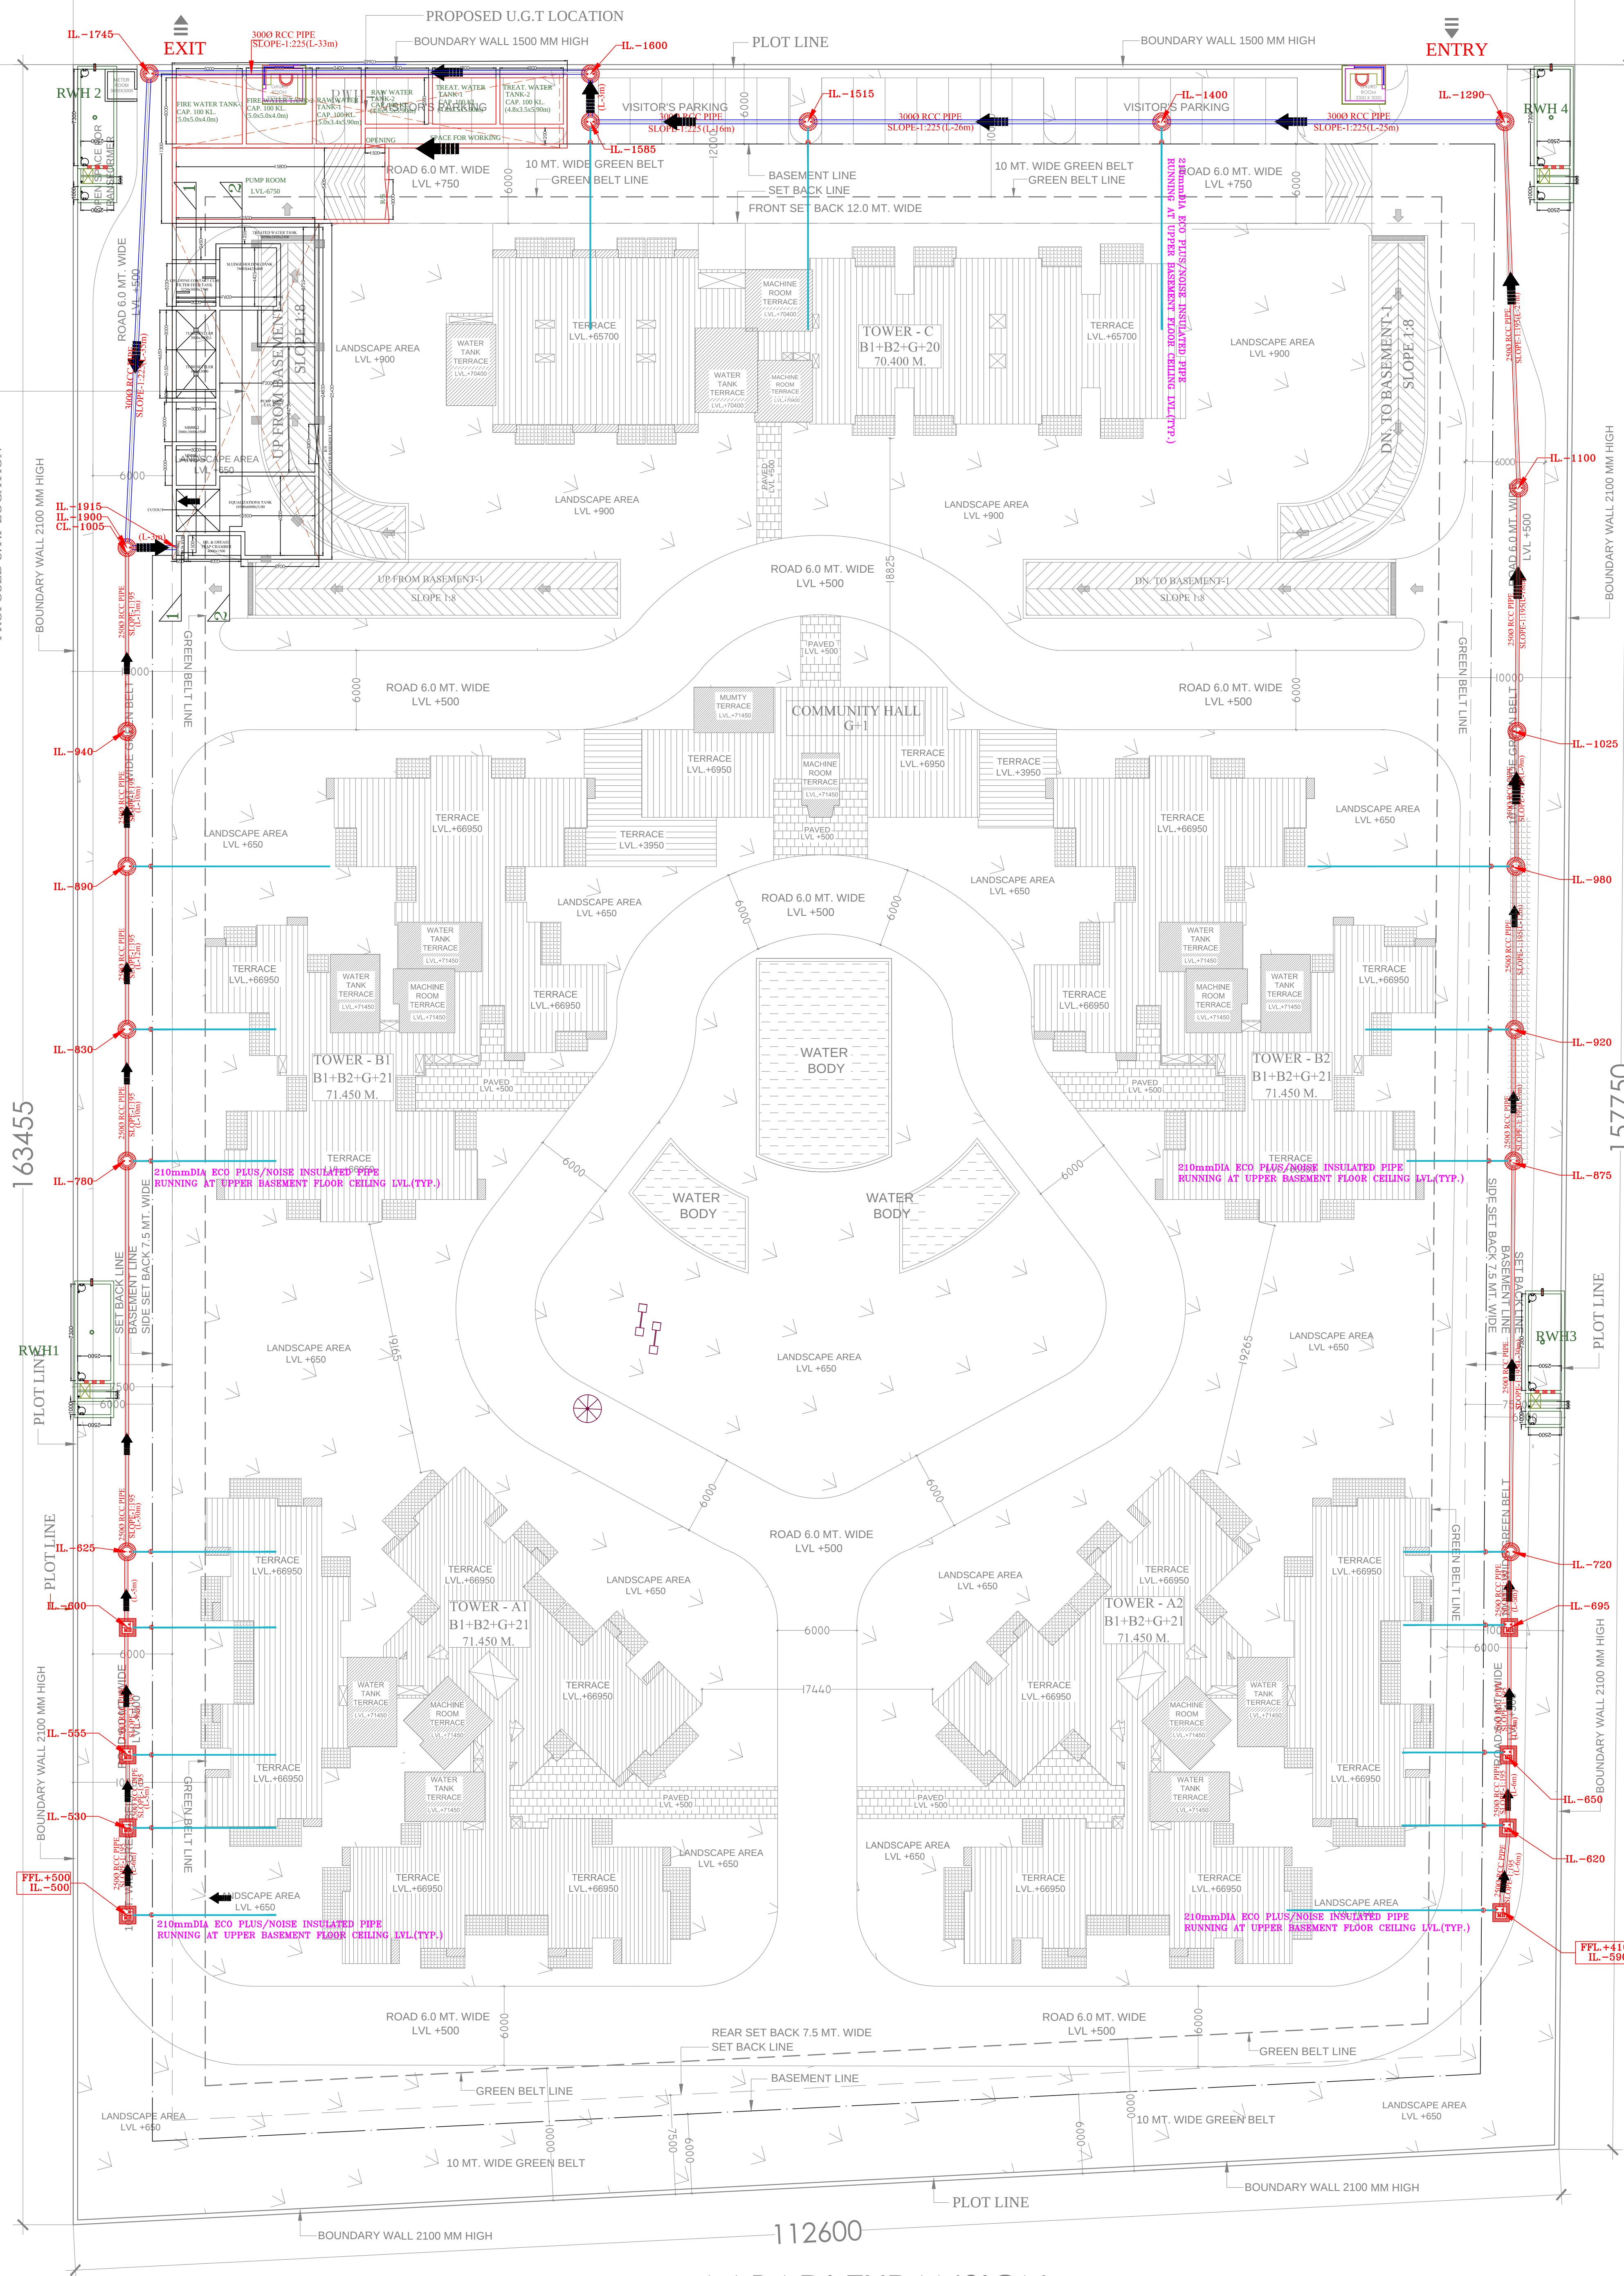

AABADI EXPANSION

SITE PLAN

LEGEND

SEWER SYSTEM		
S.NO.	DESCRIPTION	SYMBOL
1.	200mmOD uPVC PIPE CLASS-V (10kg./CM ²)	—
2.	250Ø RCC PIPE SLOPE : 1:195	—
3.	300Ø RCC PIPE SLOPE : 1:225	—
4.	GULLY TRAP (300X300mm)	GT
5.	MANHOLE (800X900mm)	MH
6.	MANHOLE (910Ø,1220Ø & 1520Ø)	MH

PLOT NO. GH-06B

SITE
CASA GRANDE-II,
PLOT NO. GH-06C
OF SECTOR CHI-V, AT
GREATER NOIDA (UP)

ABADI EXPANSION
LOCATION PLAN

INFORMAL

NOTES:-

1. ALL DIMENSIONS & LEVELS ARE IN MILLIMETERS.
2. ALL THE AREAS INDICATED ARE IN SQ.M.
3. COLUMNS ARE ONLY INDICATIVE AND WILL BE AS PER RELEVANT STRUCTURAL DRAWINGS.
4. ALL EXIT DOORS SHALL HAVE 1 HOUR FIRE RESISTANT RATING.

DRAWING TITLE :-
SITE PLAN SEWERAGE SYSTEM
PLUMBING SUBMISSION DRAWING

PROJECT :-

CASA GRANDE-II, PLOT NO. GH-06C,
OF SECTOR CHI-V, GREATER NOIDA,(UP)


OWNER :-

EARTHCON CONSTRUCTION PVT. LTD.
J-25A,SECTOR-18 NOIDA (UP)

ARCHITECT'S SEAL

OWNER'S SEAL

SERVICES CONSULTANTS:-

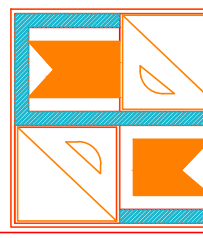 **SRIAM ENGINEERING CONSULTANTS**
(Building Engineering Services)
C2A,231C JANAKPURI, NEW DELHI - 110058
Tel: 011-40532854, 25611240
Email: srianphe@gmail.com

ARCHITECT :-

 **modarchindia**
architects interior designers & planners
studio: 1st floor, B-80, sector-63, Noida - 201301, U.P.
phone: 0120-4206253
email: amirgargal@gmail.com
website: www.modarchindia.in

SCALE:- 1:200

DATE:- 20-02-2015

DEALT BY:- DEBABRATA

CHECKED BY:- SRINIVASAN GH/CG-II/02