

THIS DRAWING IS THE PROPERTY AND COPY RIGHT OF BUILDWELL CONSULTING ENGINEERS AND THE SAME SHALL NOT BE COPIED OR USED IN ANY WAY WITHOUT THEIR WRITTEN PERMISSION.

PROJECT: SUN SHINE GROUP HOUSING

FIRE FIGHTING LEGEND		
S.NO	SYMBOL	DESCRIPTION
1.		DRAIN LINE 200Ø
2.		RECTANGULAR MANHOLE
3.		CIRCULAR MANHOLE
4.		AIR BLOWER
5.		SUBMERSIBLE PUMP
6.		CHEMICAL DOSING SYSTEM
7.		ACTIVATED CARBON FILTER
8.		MULTI GRADE FILTER
9.		FILTER PRESS
10.		SCREEN CHAMBER

DESCRIPTION

ARCHITECT:



BUILDWELL
CONSULTING ENGINEERS
Regd. Office: A-49,Abul Fazal Enclave-II,Near
Jamia, Okhla, New Delhi-110025
E-mail : civiltechno123@gmail.com
Phone. :+91-9458511015


DRAWING TITLE:
EXTERNAL DRAINAGE LAYOUT PLAN

DEALT BY FAIZAN	DATE 10-02-2024
--------------------	--------------------

SCALE
NTS

DESIGNED BY
ER.NOOR MOHD

DRAWING NO. 01	REVISION 00
-------------------	----------------

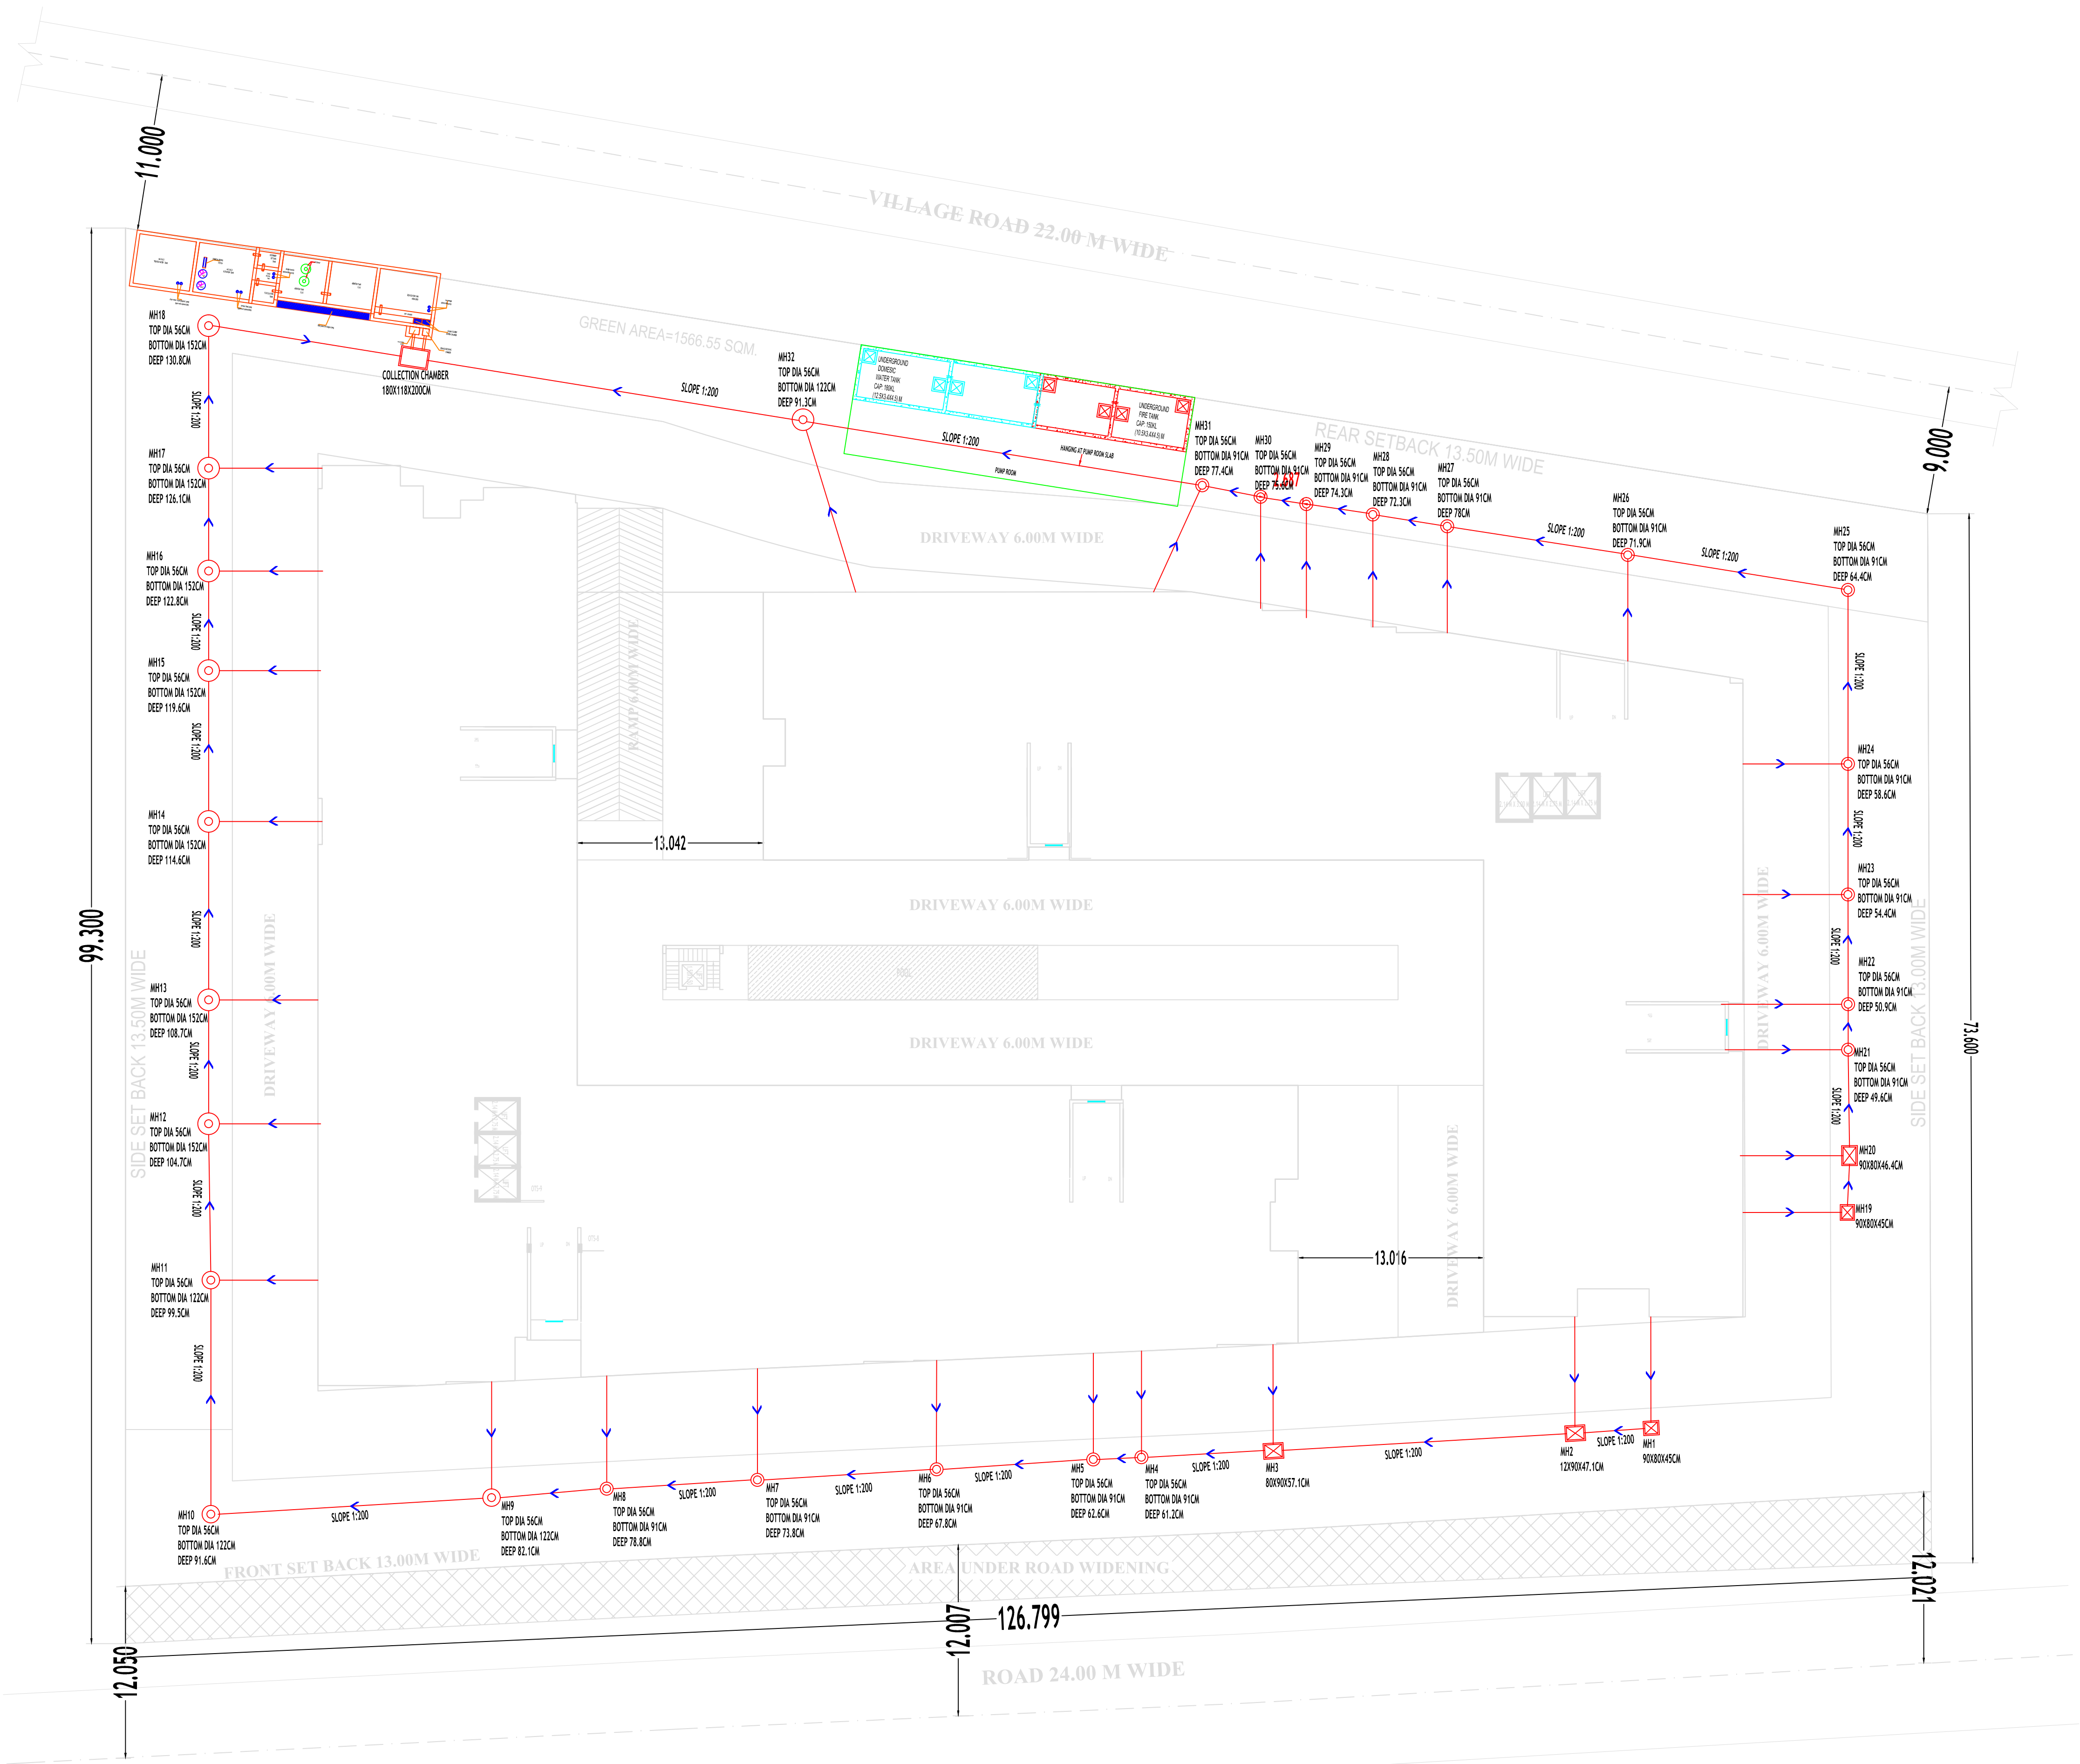

PROPOSED SITE PLAN