


45.0 M. WIDE ROAD

PHASE - 01  
TOWER - A  
TOTAL AREA = 20637.626 SQMT. LAND  
APPLIED FOR RERA REGISTRATION

20.0 M. WIDE GREEN BELT

PHASE - 02  
TOWER - B  
FUTURE DEVELOPMENT

BLOCK 2

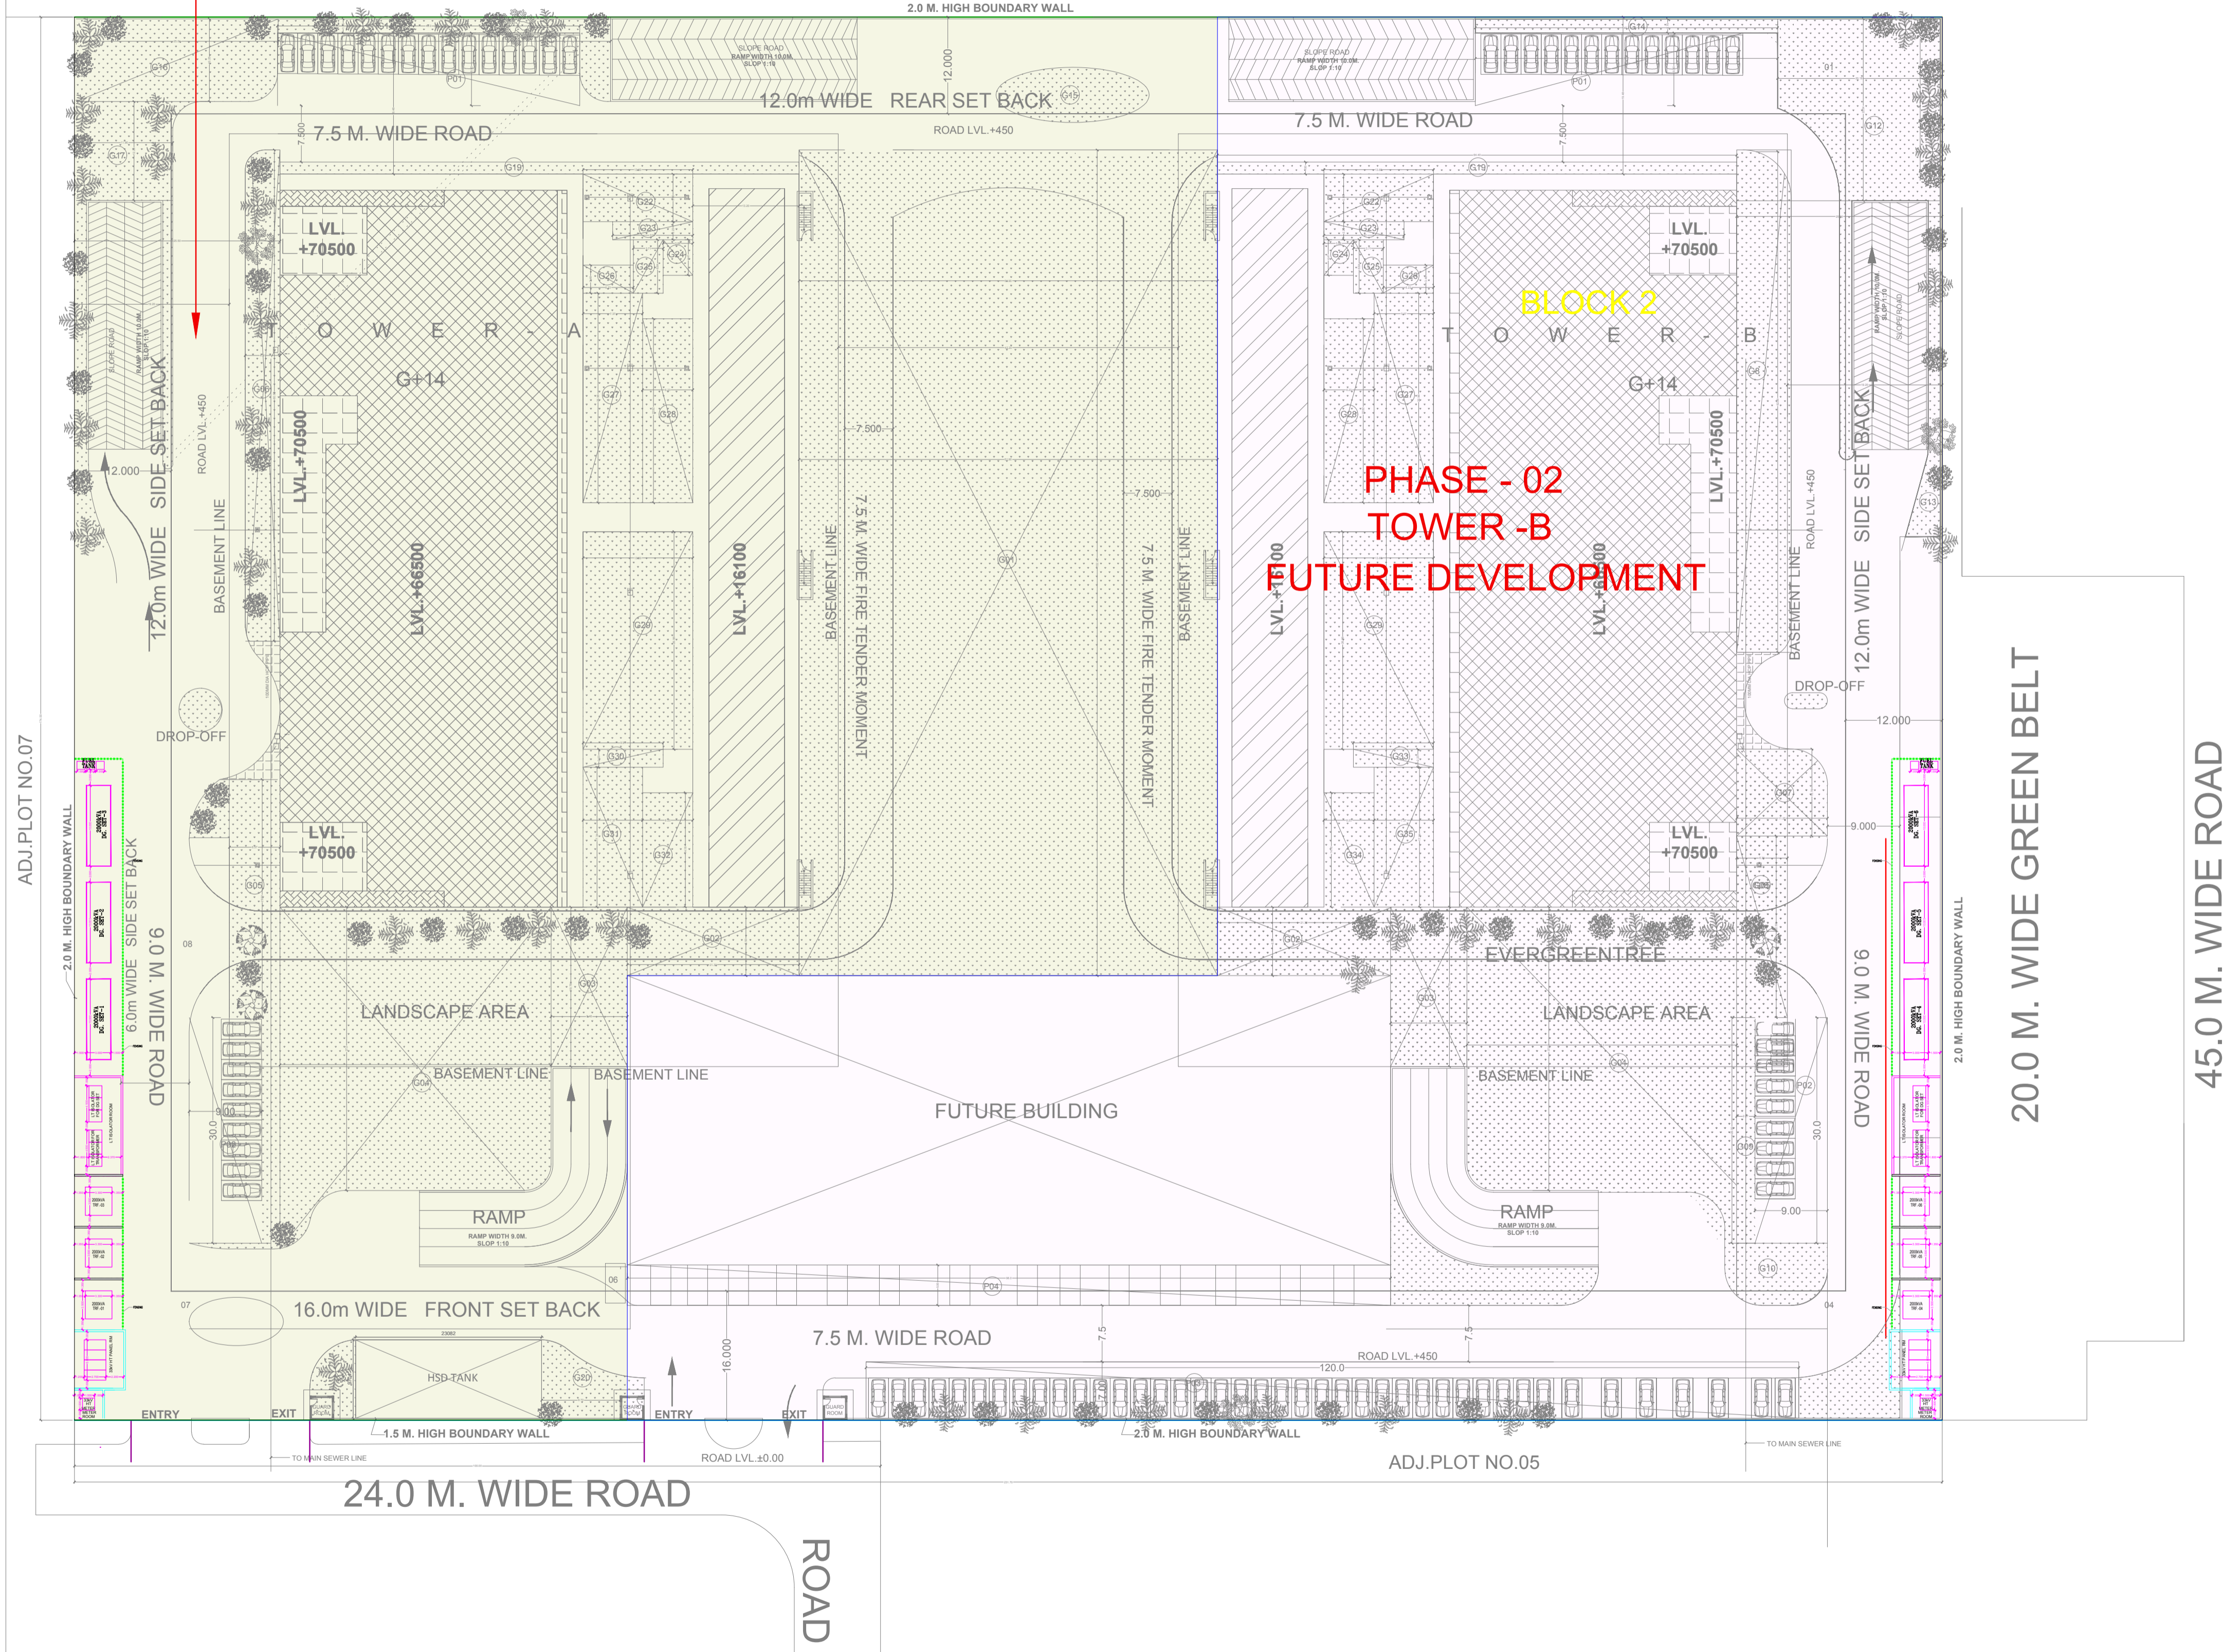

20.0 M. WIDE GREEN BELT

45.0 M. WIDE ROAD

OWNER'S SIGN.

ARCHITECTS SIGN

PROJECT  
PROPOSED PLAN FOR INSTITUTIONAL  
BUILDING ON PLOT NO.06 SECTOR - 142  
NOIDA, FOR SPLENDOR INFORMATION  
TECHNOLOGY PVT.LTD

DRAWING TITLE  
**ELECTRICAL PLAN**

Scale 1:250

Date

SHEET. NO. DRG. NO.

JOB. NO. A01-A