


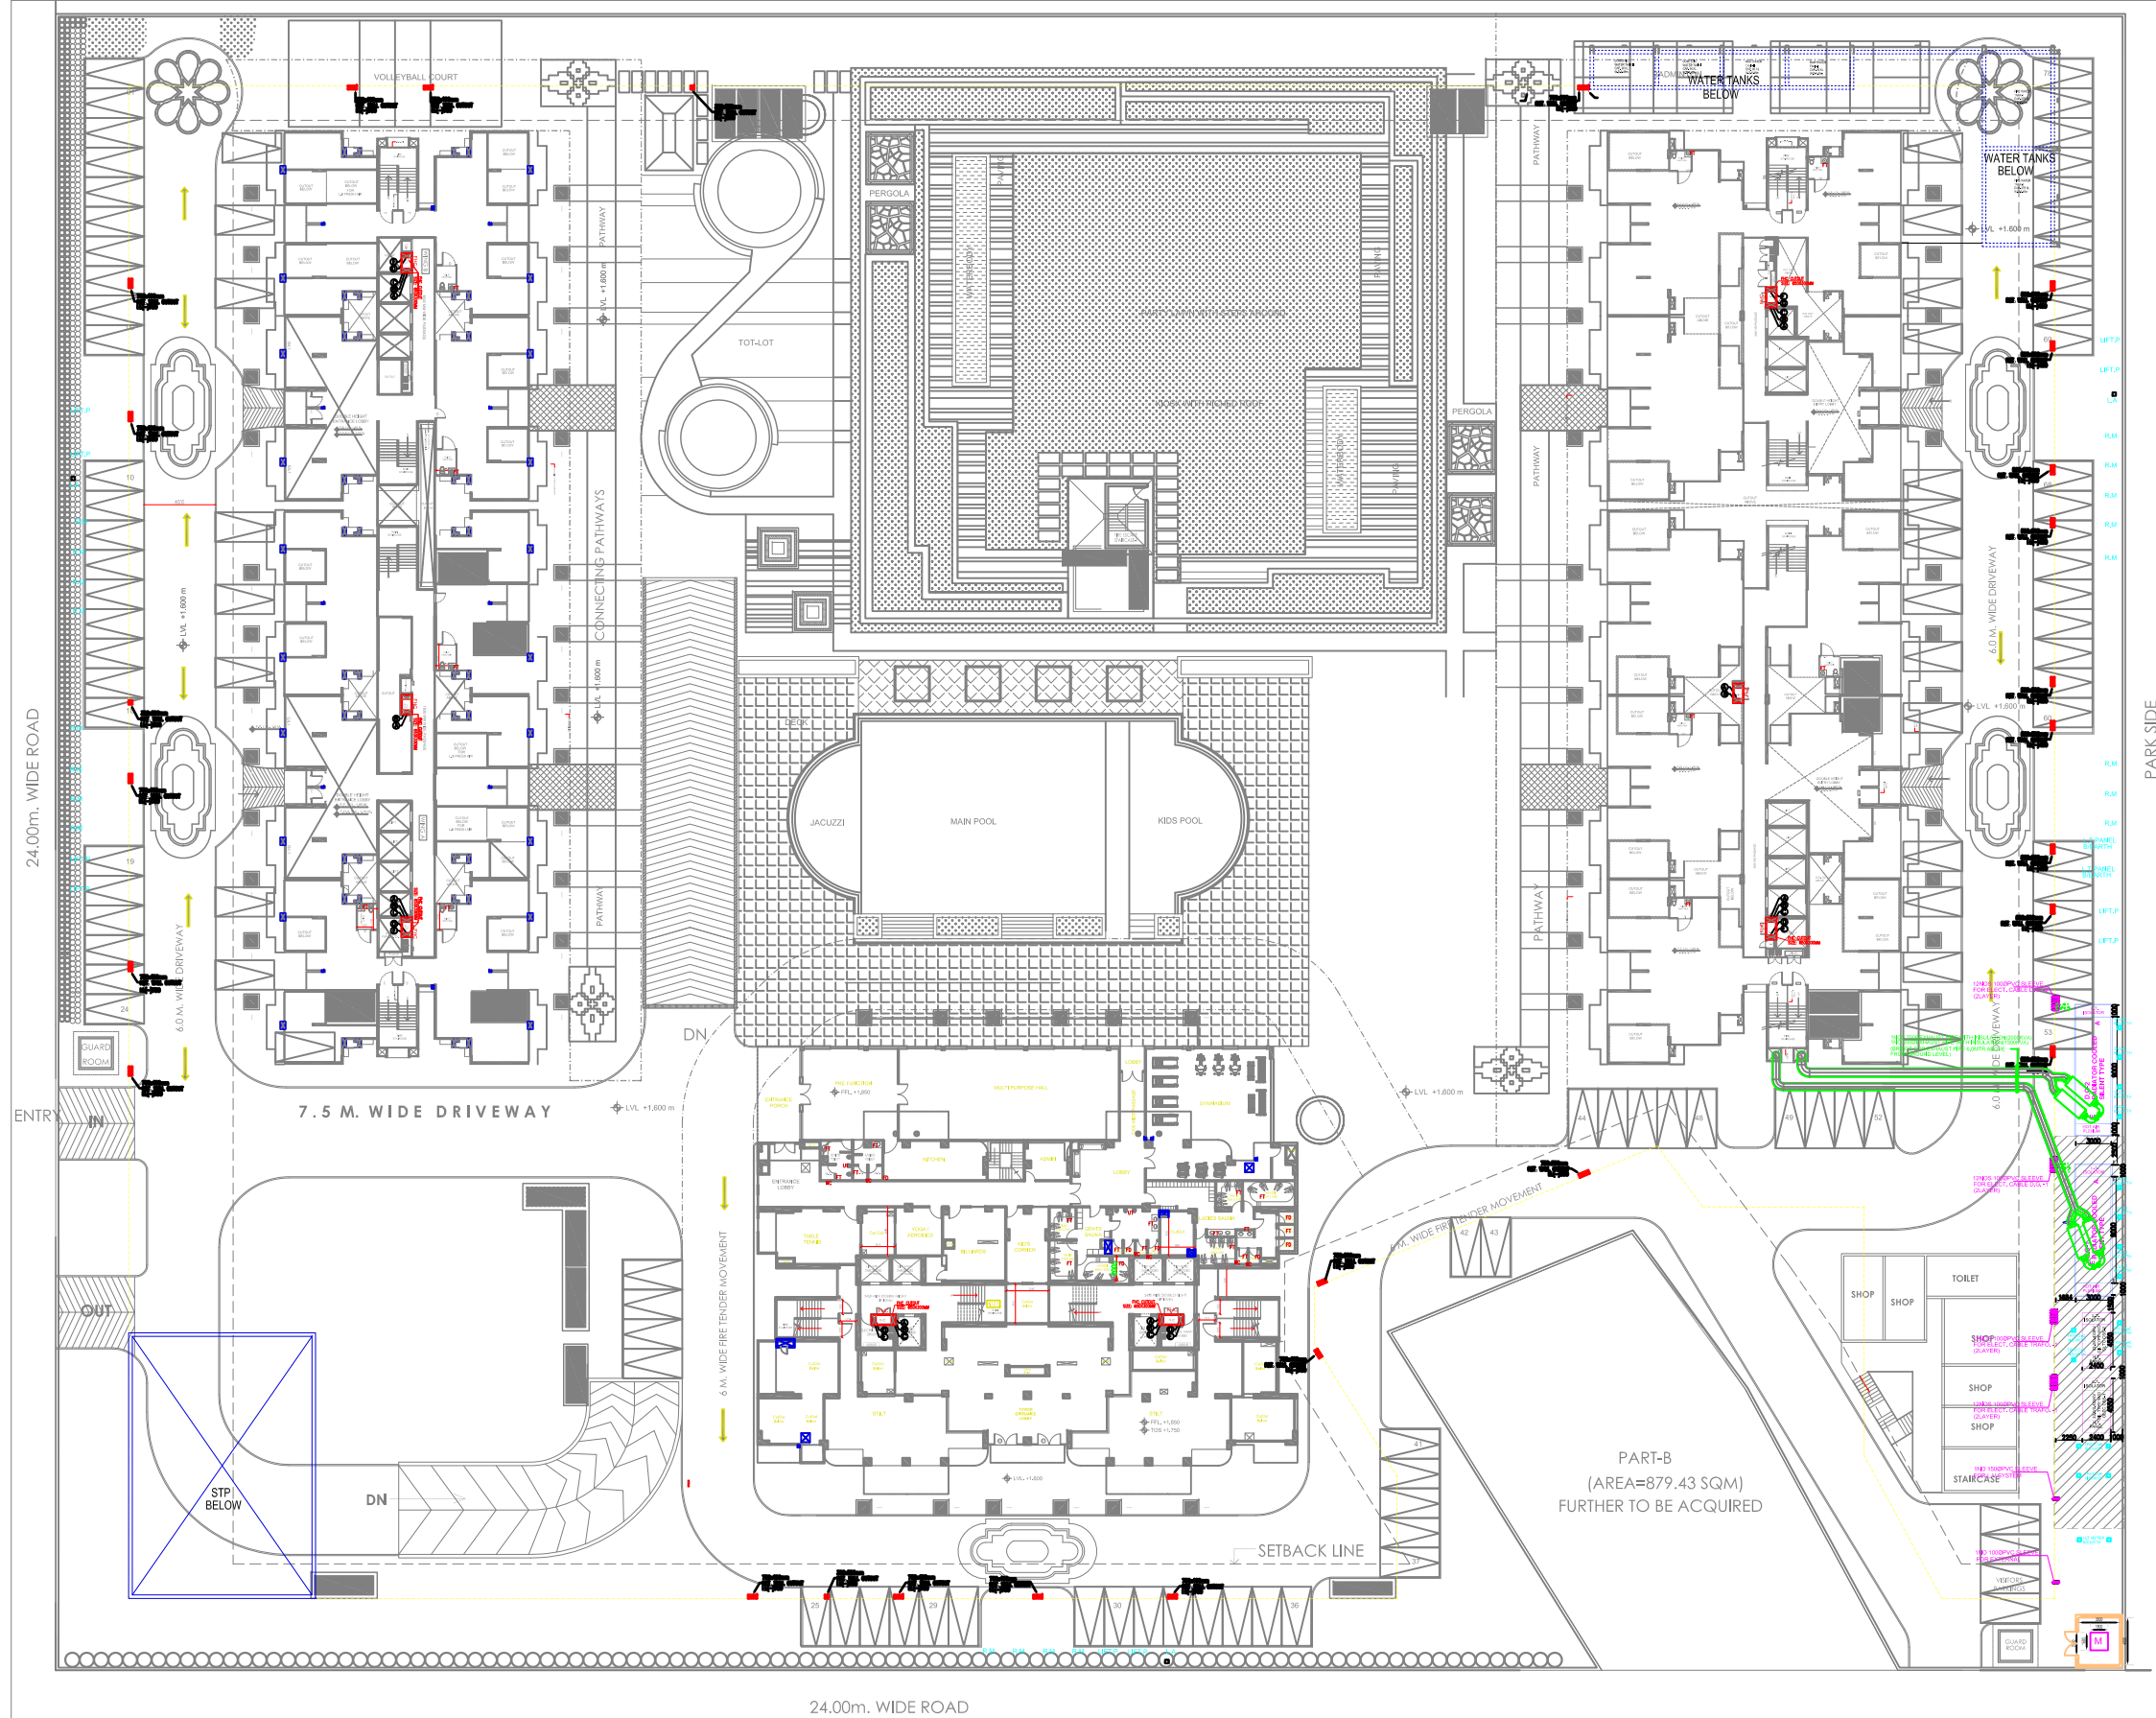

EARTHING SCHEDULE

S.NO	EARTH PIT NO.	EQUIPMENT	NO. OF EARTH PITS
1	EP1-EP2	METER-BODY	2
2	EP3-EP4	CSS-1-BODY	2
3	EP5-EP6	CSS-1-NEUTRAL	2
4	EP7-EP8	CSS-2-BODY	2
5	EP9-EP10	CSS-2-NEUTRAL	2
6	EP11-EP12	O/G SET-1-BODY	2
7	EP13-EP14	O/G SET-1-NEUTRAL	2
8	EP15-EP16	O/G SET-2-BODY	2
9	EP17-EP18	O/G SET-2-NEUTRAL	2
10	EP19-EP20	MAIN L-PHASE-BODY	2
11	EP21-EP22	EXTERNAL LIGHTING FEEDER PILLAR	2
12	EP23-EP24	LIGHTNING PROTECTION	2
13	EP25-EP26	UPS PANEL	2
14	EP27-EP28	UPS PANEL	2
15	EP29-EP30	MAIN DISTRIBUTION BOARD	2
16	EP31-EP32	MAIN L-PHASE-BODY	2
17	EP33-EP34	CLUB HOUSE	2
18	EP35-EP36	COMMERCIAL PANEL/BO	2
SUB TOTAL			44

SUBMISSION DRAWING

PROJECT:

PROPOSED SUBMISSION DRAWINGS
FOR PROPOSED GROUP HOUSING AT
PLOT No:- GH-01/B, SECTOR-10,
GREATER NOIDA WEST (U.P) FOR
M/s HEBE INFRASTRUCTURE PVT. LTD.

DRAWING TITLE :

ELECTRICAL LAYOUT
SITE PLAN

OWNER'S SIGN

ARCHITECT'S SIGN

SCALE
1:350

DEALT BY
PUSPENDAR

DATE -
MAY-2016

DESIGN BY

CHECKED BY

DRG. No.

SD-06