



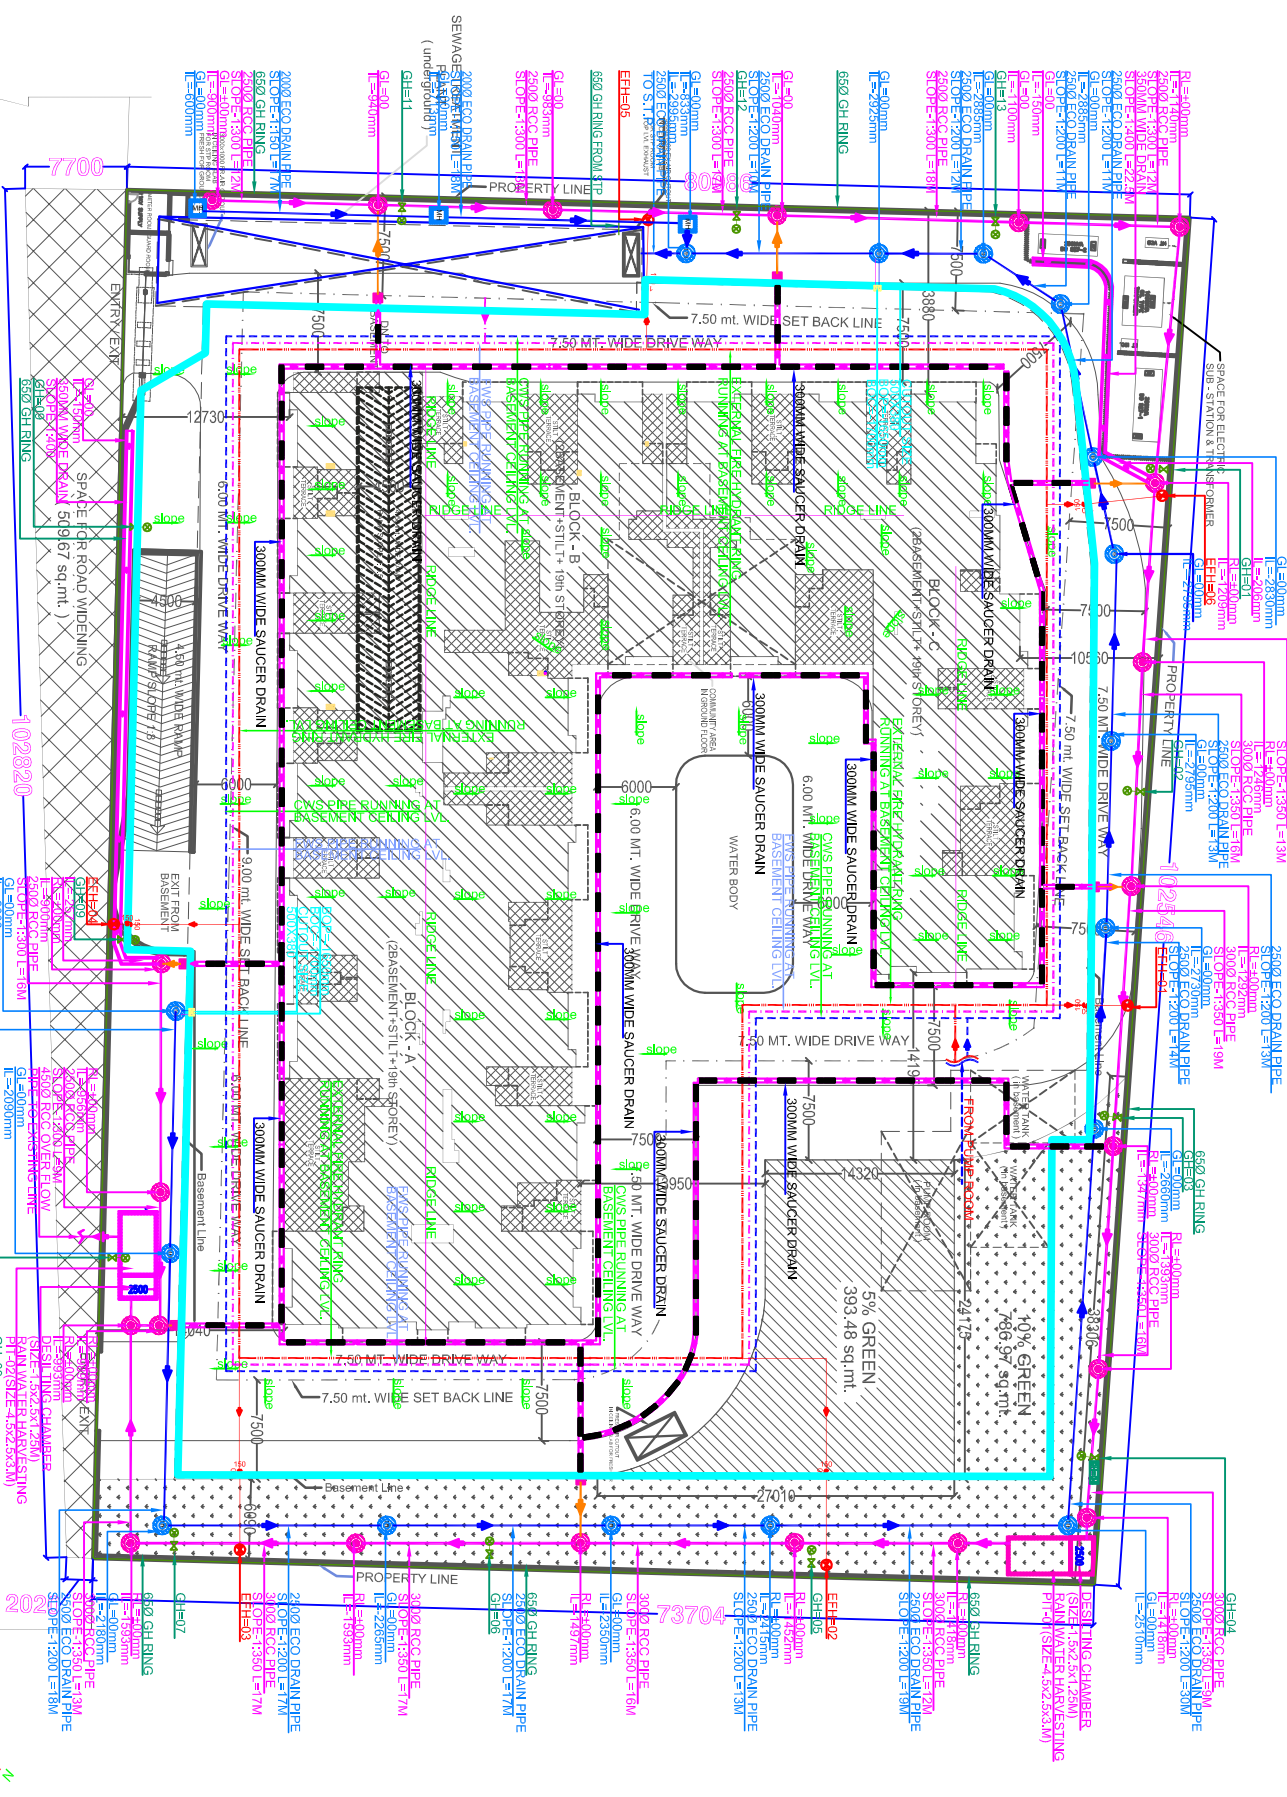


LEGEND

SYMBOL	DESCRIPTION
	EXTERNAL SEWER LINE
	COLD WATER SUPPLY LINE
	IRRIGATION WATER RING
	FLUSHING WATER SUPPLY LINE
	EXTERNAL FIRE HYDRANT RING
	EXTERNAL SEWER LINE MANHOLE
	EXTERNAL STORM LINE MANHOLE
	EFH EXTERNAL FIRE HYDRANT
	GH GARDEN HYDRANT

PLUMBING LEGEND:

	RAIN WATER HARVESTING
--	-----------------------

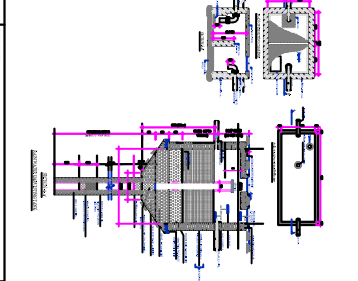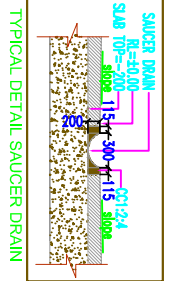

DATE: 10/10/2024
DRAWING FOR THE GROUP HOUSING PROJECT
VILLAGE MOOR HAKAR GHANZABAD (U.P.)
M/s. BANKEY BHAI INFRAHOMES (P.) LTD.
DRAWN BY: M. RAJEEV AGARWAL
CHECKED BY: ANU AGARWAL
SCALE: 1:100
SHEET NO: 02/02

ANU AGARWAL ARCHITECTS
OFFICE: 10/10/2024
PHONE: 98765 43210
EMAIL: anu@anuarchitects.com

DATE: 10/10/2024
DRAWN BY: ANU AGARWAL
CHECKED BY: ANU AGARWAL
SCALE: 1:100
SHEET NO: 02/02