


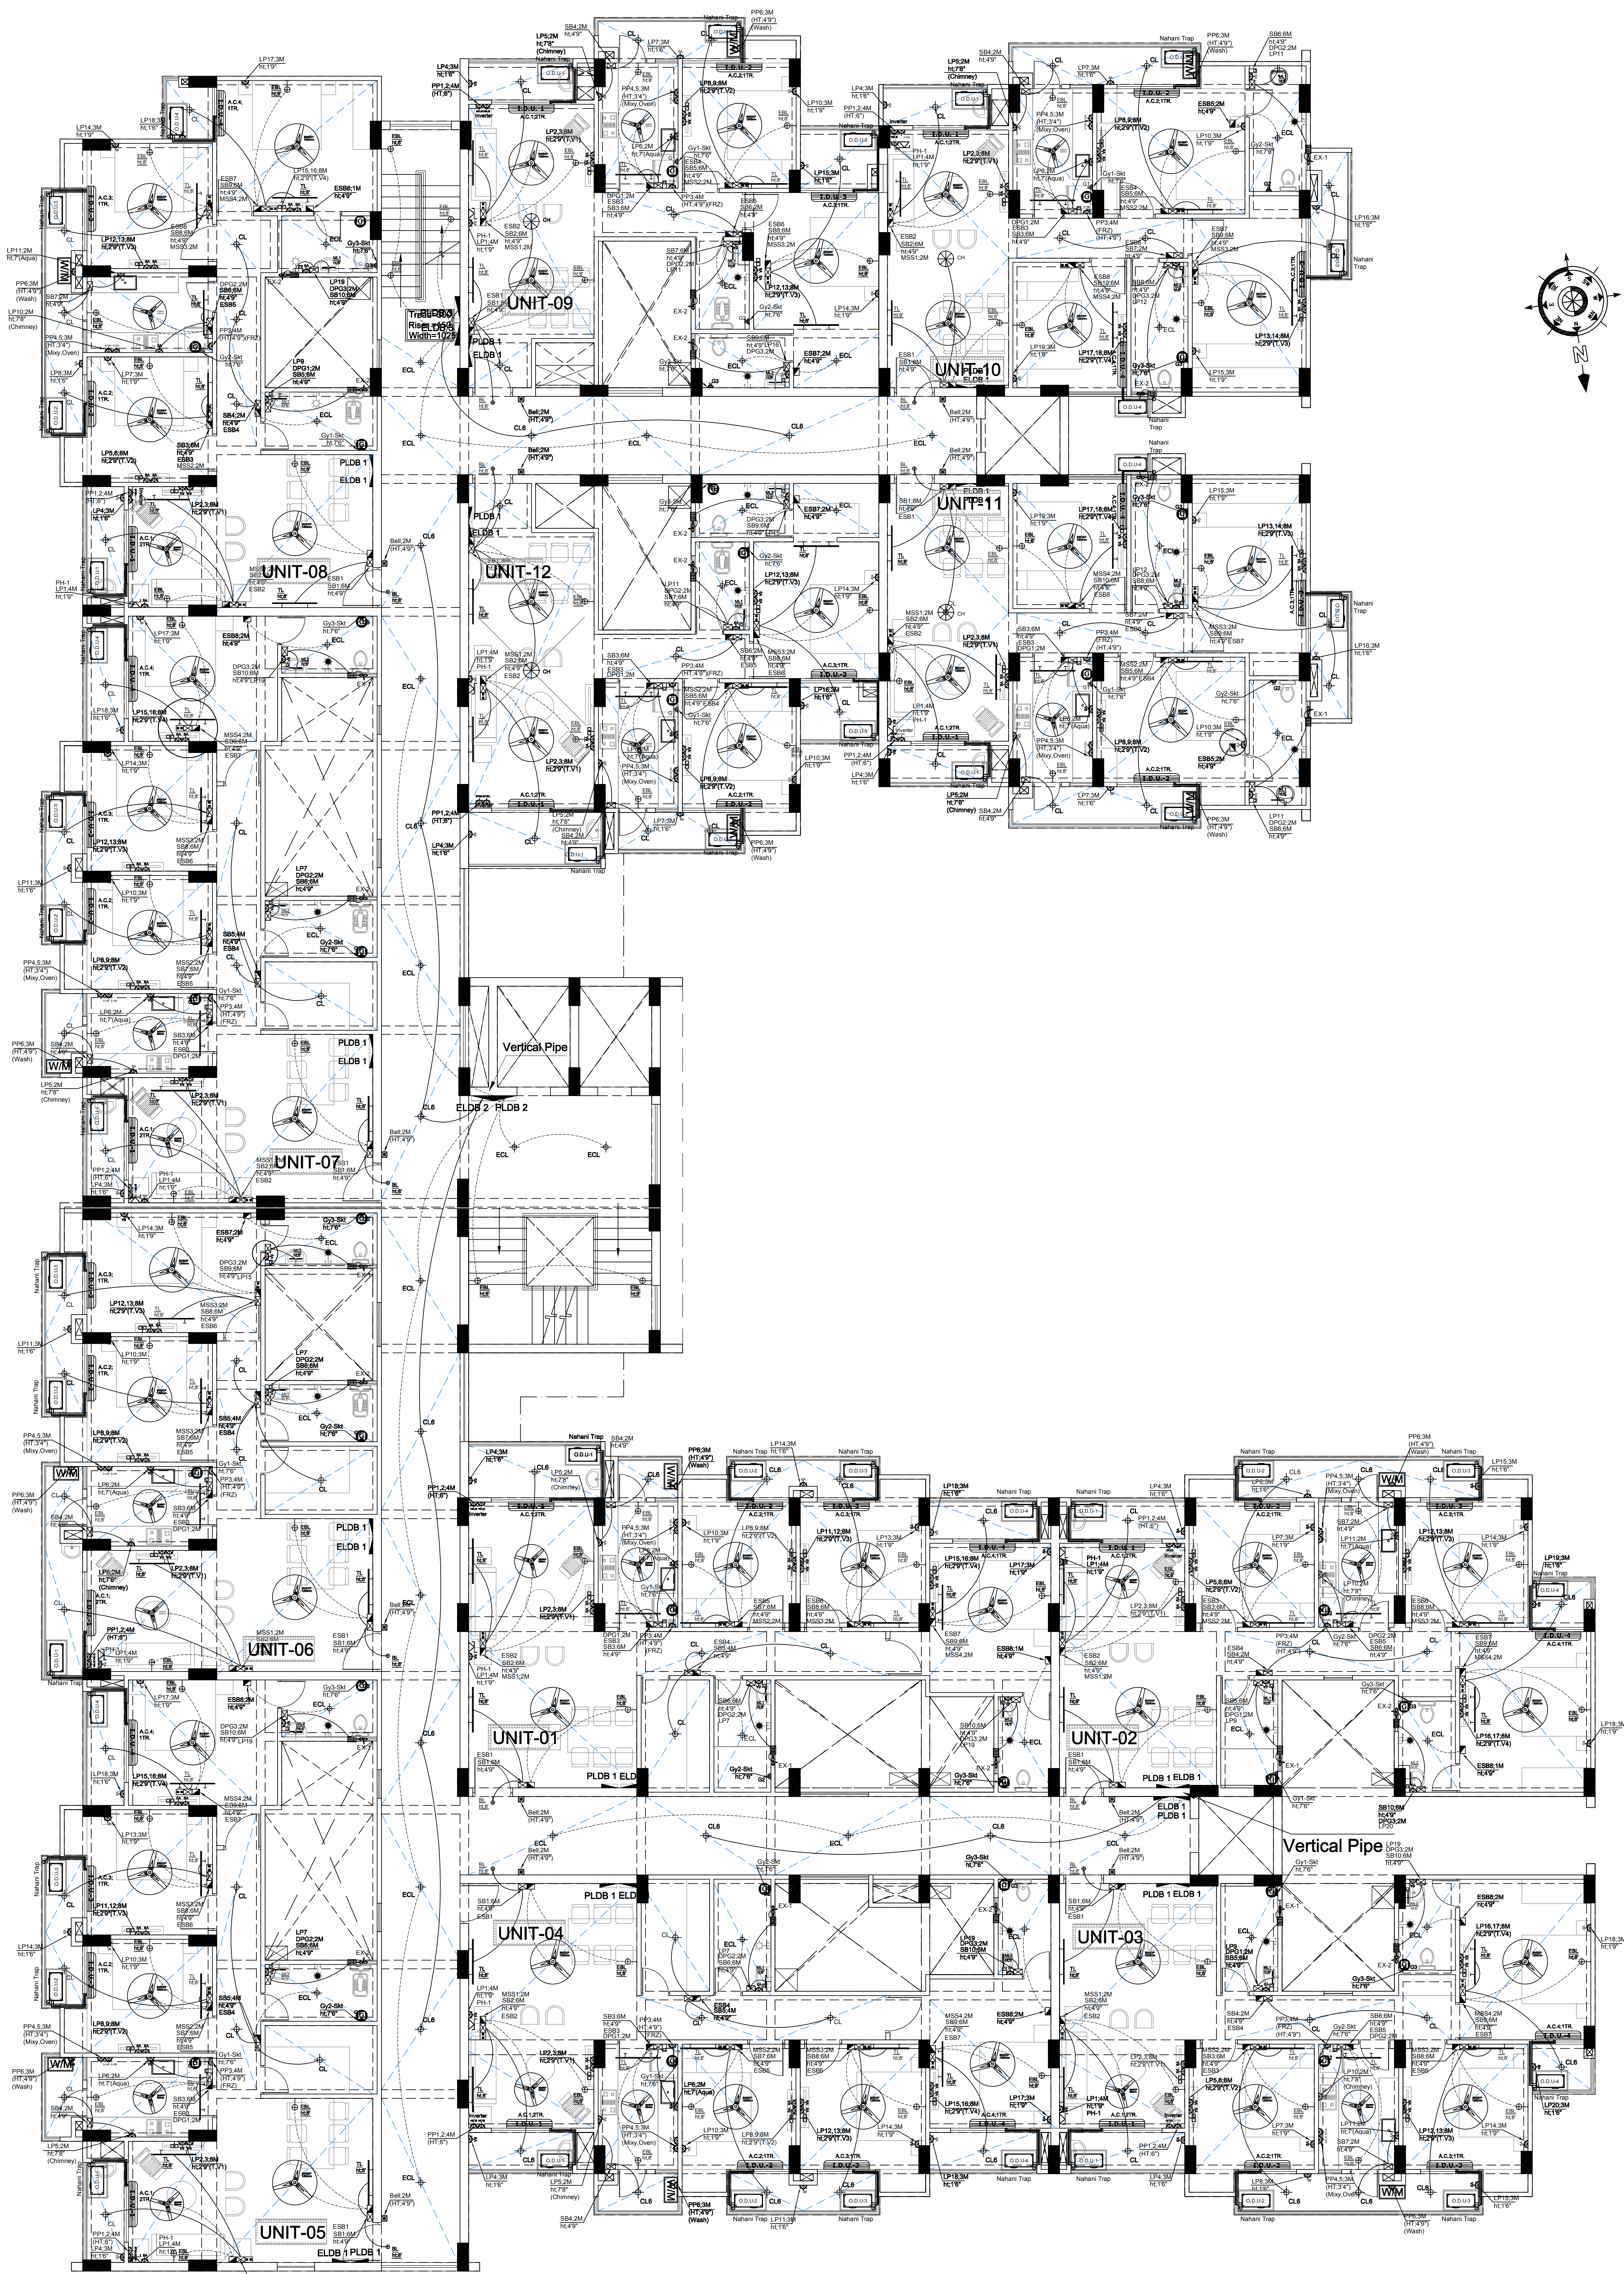

ELECTRICAL PLAN (RESIDENTIAL BLOCK-C)

Note- For ceiling & wall electrical(except Kitchen)

Existing Cum Proposed Group Housing Project for
MS Jeet Home Solution Pvt Ltd for
shri jitender kumar & shri Lalan prasad sinha.
Anjee no- 45/1,47/1,47/2, 47/3 at mauza-samara & pangana Raihupur
Anjee no.- 17,17/1,17/2,16,11/1, 11/2,11/3 at mauza-katesar & pangana Raihupur
dist:- chandaul

Client:
Mr. Lalal Prasad Sinha
Mr. Jitender Kumar

PROJECT :-

GROUP HOUSING AT PARAO
VARANASI

TITLE :-

BLOCK-C

DRAWN BY :-

CHECKED BY :- PRADEEP

DRG. NO. :-

DATE :- 29-09-17

ELECTRICAL CONSULTANT

SONI CONSULTENCY SERVICES
Electrical Design,Planning,Estim&Costing
ADDRESS - VAISHALI NAGAR BHILAI DIST DURG (CG) 490023
E-mail- sanjaysoni_elec@rediffmail.com. sanjaysoni.elec@gmail.com

SCALE	DRN.BY	SANJAY SONI	DRG.NO.
SCALE TO FIT	DATE	SANJAY SONI	

ARCHITECT:

GEOMETRIC DESIGN STUDIO PVT LTD
architecture|engineering|interiors

b-3 prashantpuri d.i.g colony m.a.road varanasi 02

geometricdesigns@gmail.com,
mail@geometricdesignstudio.com

0542-2511515

91- 9453018242