


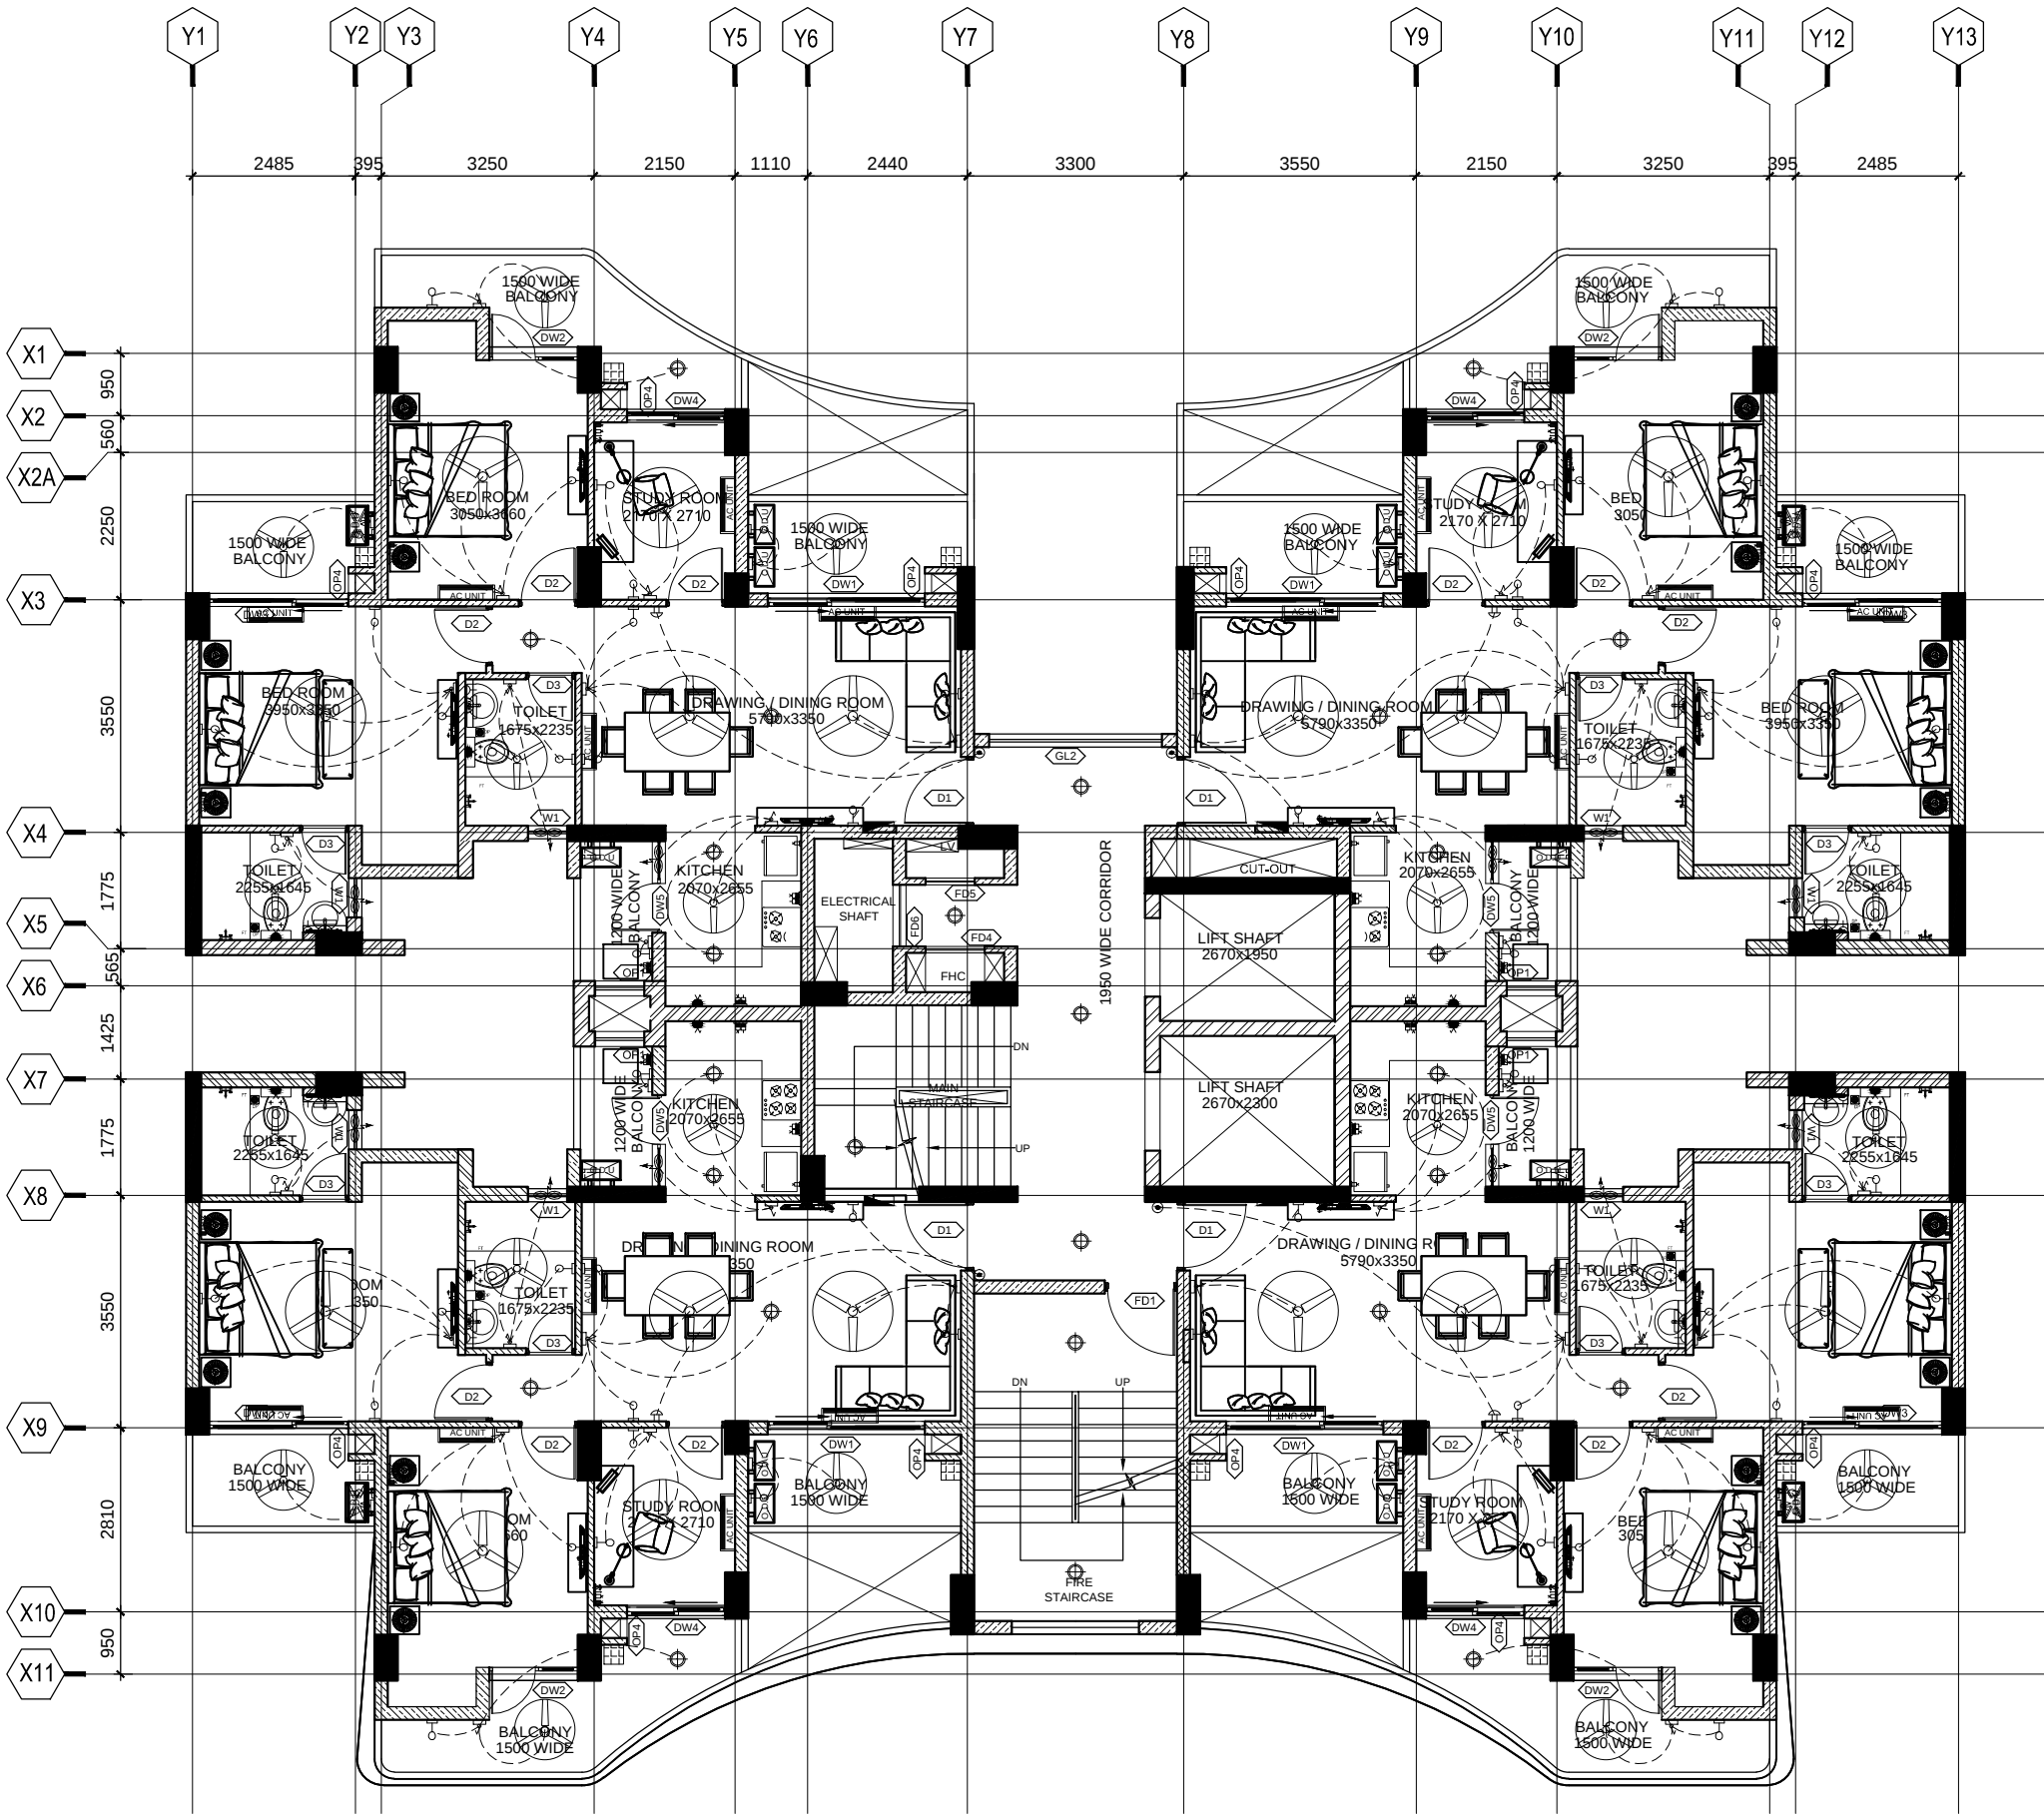

9TH TO 19TH FLOOR
PLAN

LEGEND			
S.NO	SYMBOL	DESCRIPTION	HEIGHT
1		SWITCH BOARD AT 42" HT.	1050 MM
2		6 AMP POWER POINT FOR A.C WITH SWITCH	450 mm
3		16 amp. 5 PIN POWER SOCKET WITH SWITCH	450 mm
4		6 amp. 5 PIN SOCKET WITH SWITCH (ROOMS)	450 mm
5		16 amp. 5 PIN POWER SOCKET WITH SWITCH (KITCHEN)	1050 mm
6		6 amp. 5 PIN POWER SOCKET WITH SWITCH (KITCHEN)	1050 mm
7		BELL	
8		BELL PUSH BUTTON	
9		6 AMP PIN SOCKET FOR EXHAUST FAN (SWITCH ON SWITCH BOARD)	1800 mm
10		point for telephone and intercom	450 mm
11		16 amp. 5 PIN POWER SOCKET FOR T.V.	1050 mm
12		split a.c. position	AS / AC DWG
13		FAN POINT	IN CEILING
14		6 amp. 5 PIN SOCKET WITH SWITCH (KITCHEN, UTILITY & TOILET)	1000 mm UNLESS SPECIFIED
15		LIGHT POINT	IN CEILING
16		LIGHT POINT in wall	2100 mm
17		MIRROR LIGHT POINT	As/detail
18		16A SWITCH FOR GYSER	As/detail
		WASHING MACHINE	

CLIENT:

URBTECH INDIA DEVLOPERS PVT. LTD.

PROJECT:

PROPOSED PLAN FOR
HILSTON URBTECH, SECTOR-79,
NOIDA (U.P)

ARCHITECTURE, STRUCTURAL ENGINEERING AND SERVICES/MEP:

OPTIMIZATION CONSULTANTS
ARCHITECTURE • STRUCTURAL ENGINEERING
SERVICES/MEP • PROJECT COST OPTIMIZATION
202&203, HIMLAND HOUSE COMMERCIAL COMPLEX KARAMPURA
NEW DELHI-110015
Email: optpro34@yahoo.com

S.NO.	NOTES
1.	ALL DIMENSIONS ARE IN mm UNLESS NOTED OTHERWISE.
2.	DO NOT SCALE THE DRAWING REFER TO DIMENSIONS AS INDICATED.
3.	IF ANY DISCREPANCY FOUND CONTRACTOR TO BRING TO THE NOTICE OF THE CONSULTANTS BEFORE EXECUTION.
4.	THIS DRAWING TO BE READ IN CONJUNCTION WITH RELEVANT ARCHITECTURAL, STRUCTURAL AND OTHER SERVICES GPC DRAWINGS.

NO. OF COPIES	ISSUED TO	DATE
	GOOD FOR CONSTRUCTION 08 JAN. 2018 Optimization Consultants New Delhi	
REV.	DESCRIPTION	DATE

BUILDING TITLE
TOWER- A TO E

DRAWING TITLE
9TH TO 19TH FLOOR PLAN

CHECKED SUSHMA	APPROVED M	SCALE NTS	DRG. NO. M-TAE-207
DRAWN RENU		DATE 08.01.2018	REV. NO. R0