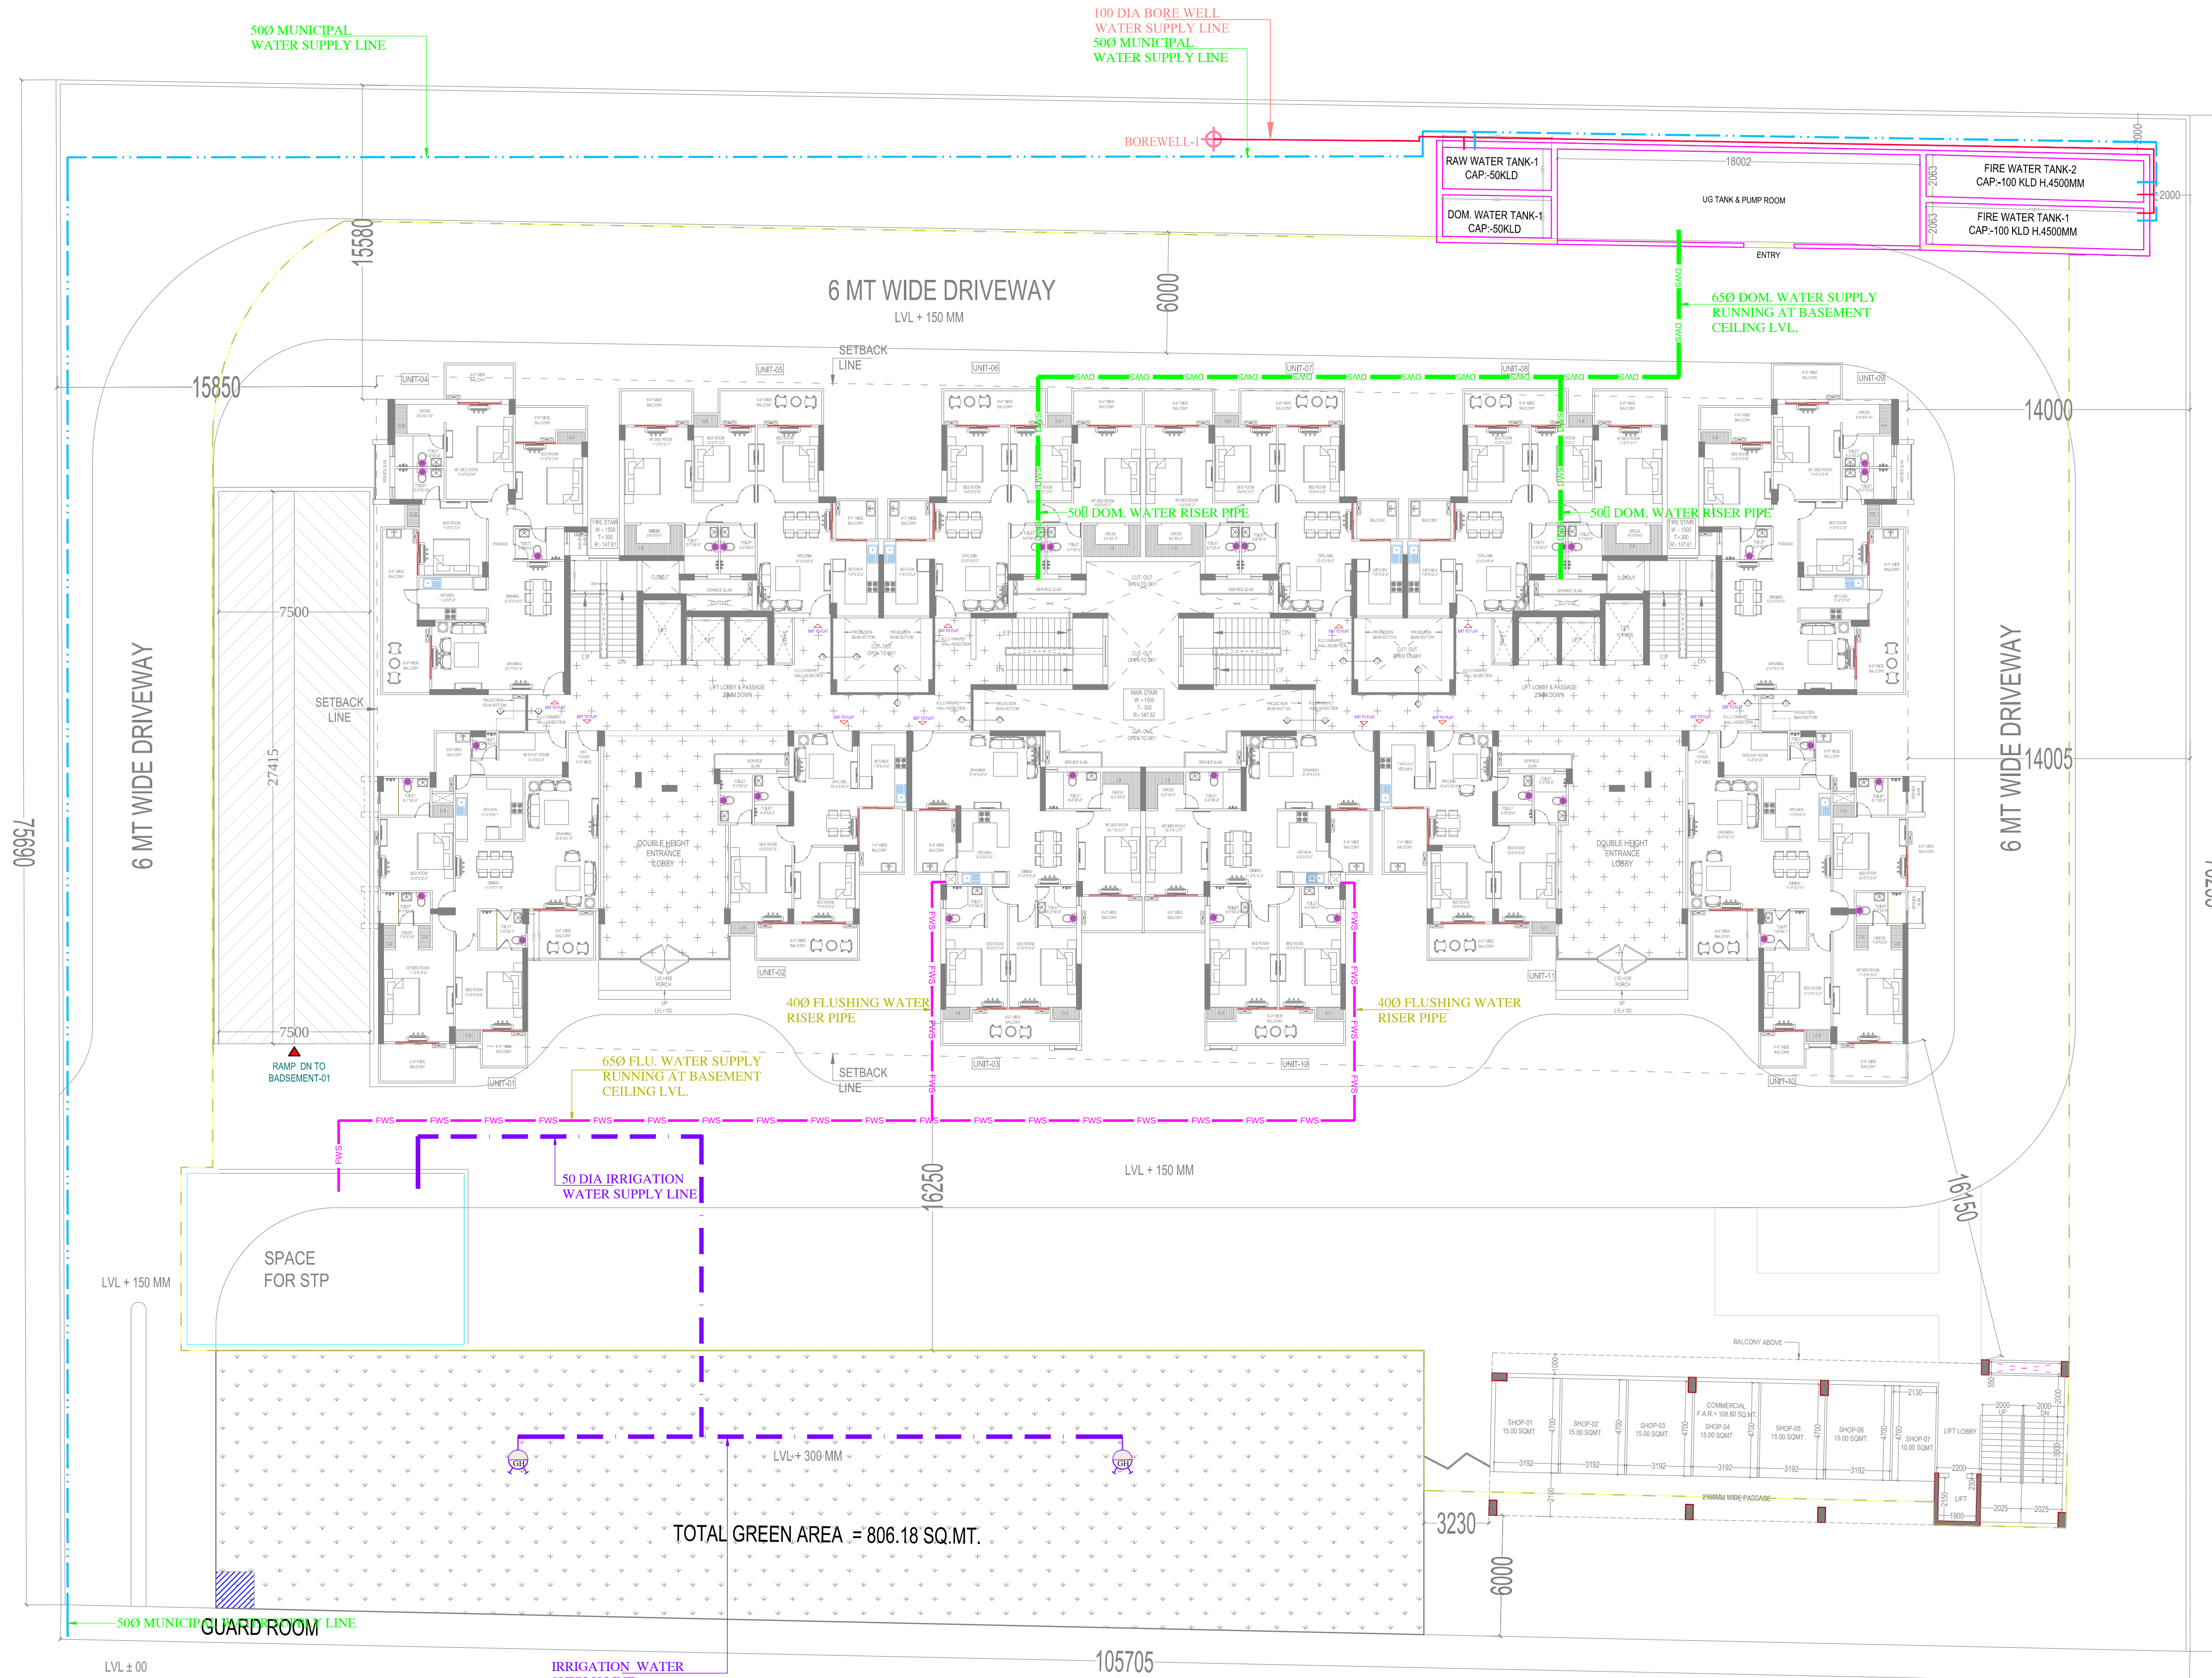


COPY	REV.	DATE	REVISION/ISSUED TO

PROJECT :-
PROPOSED A R DOMAIN GROUP HOUSING
AT KHASRA NO. 1093, VILLAGE-MORTA,
GHAZIABAD

BUILDERS & PROMOTER :-
M/S A R BUILDTECH PVT. LTD.

DRAWING TITLE
EXTERNAL DUAL WATER SUPPLY
LAYOUT
BUILDING HEIGHT=2B+G+14TH FLOOR

DRAWN BY :-	CHECKED BY :-	DATED :-
NASEEB	KAMAL	20.02-25

SCALE :-	DRG. NO. :-	JOB. NO. :-
N.T.S.	PKV/PL/05	R0

• THIS DRAWING IS THE PROPERTY OF SPACE DESIGNERS AND IS NOT TO BE USED FOR ANY PURPOSE OTHER THAN FOR WHICH IT IS ISSUED WITH OUT PERMISSION OF ITS PRINCIPALS.
• THIS DRAWING IS TO BE READ IN CONJUNCTION WITH OTHER RELEVANT ARCHITECTURAL, STRUCTURAL AND OTHER SERVICES CONSULTANTS DRAWING. IT SHALL BE THE DEEMED RESPONSIBILITY OF THE CONTRACTOR/CLIENT TO BRING IN TO NOTICE OF ARCHITECTS IF ANY DISCREPANCY WITHIN OR BETWEEN THE DRAWINGS PRIOR TO CONSTRUCTION.
• ALL WRITTEN DIMENSIONS ARE TO BE FOLLOWED AND THE DRAWING IS NOT TO BE SCALED.

ARCHITECTS :-
Space Designers International
B - 34, SECTOR-67, NOIDA
PH : +91 9711633717, 18
Mob: 9811070399, 9811336231
e-mail : spacesdi@gmail.com, www.spacedi.com

MEP CONSULTANT:
PKV Consulting Engineers (P) Ltd.
C-815, DDA Flats, Loni Road, Delhi - 110093
TELEFAX - 011-22816297
E-mail - pramod@pkv.co.in
info@pkv.co.in

NOTE:-ACCORDING TO THE HEIGHT NOC THE MAXIMUM HEIGHT OF THE BUILDING WILL BE 49050 MM

SITE PLAN
BUILDING HEIGHT=2B+G+14TH FLOOR

LEGEND:-		
S.NO	DESCRIPTION	SYMBOL
1.	DOMESTIC WATER SUPPLY RISER LINE	
2.	FLUSHING WATER SUPPLY RISER LINE	
3.	MUNICIPAL WATER SUPPLY LINE	
4.	BORE WELL WATER SUPPLY LINE	
5.	IRRIGATION WATER SUPPLY LINE	